


- NOTES:
 1) EXACT MOUNTING DETAILS TO BE DETERMINED AT JOBSITE BY OTHERS.
 2) CALCULATIONS MAY SHOW THE EFFECT OF SHADOWING CAUSED BY BUILDINGS AND OBJECTS WITHIN THE CALCULATED SPACE OR IN THE SITE AREA.
 3) READINGS SHOWN ARE INITIAL HORIZONTAL FOOTCANDLES ON A FLAT SITE UNLESS OTHERWISE INDICATED.
 4) THIS CALCULATION IS BASED ON LIMITED INFORMATION SUPPLIED BY OTHERS TO SWANEY LIGHTING ASSOCIATES AND STANDARD ASSUMPTIONS OF THE SPACE AND/OR SITE.
 5) CONFORMANCE TO CODES AND OTHER LOCAL REQUIREMENTS AS DETERMINED BY THE AHJ ARE THE RESPONSIBILITY OF THE OWNER AND/OR THE OWNER'S REPRESENTATIVE.
 6) THIS LAYOUT DRAWING MUST BE COORDINATED WITH THE SITE LOCATION FOR CORRECT FIXTURE ORIENTATION.
 7) CHECK GRAPHIC SCALE. DOCUMENTS PRINTED OR PLOTTED FROM ELECTRONIC FILES MAY OCCUR AT OTHER THAN THE DESIRED OR ASSUMED GRAPHIC SCALES. IT IS THE RESPONSIBILITY OF THE RECIPIENT TO VERIFY THAT THE PRINTED OR PLOTTED-TO-SCALE DRAWING IS PRINTED TO SCALE.

Calculation Summary					
Label	Avg	Max	Min	Avg/Min	Max/Min
full site	0.82	3.8	0.0	N.A.	N.A.
Off Property	0.00	0.1	0.0	N.A.	N.A.
property line	0.01	0.1	0.0	N.A.	N.A.

Luminaire Schedule (note fixture catalogue numbers are not complete)					
Type	Qty	Lumens	LLF	Lum. Watts	Description
G1	1	4460	0.900	55.8	ARS-18L4K-083-5M-U-XX
S3B	1	1890	0.900	112.9	CL1S-16LU-4K-3-BC
ST	1	64	0.900	5.32	EL807_3L3K_UNV
W1	2	462	0.900	6.8	EC-LED-e66-WFL-12

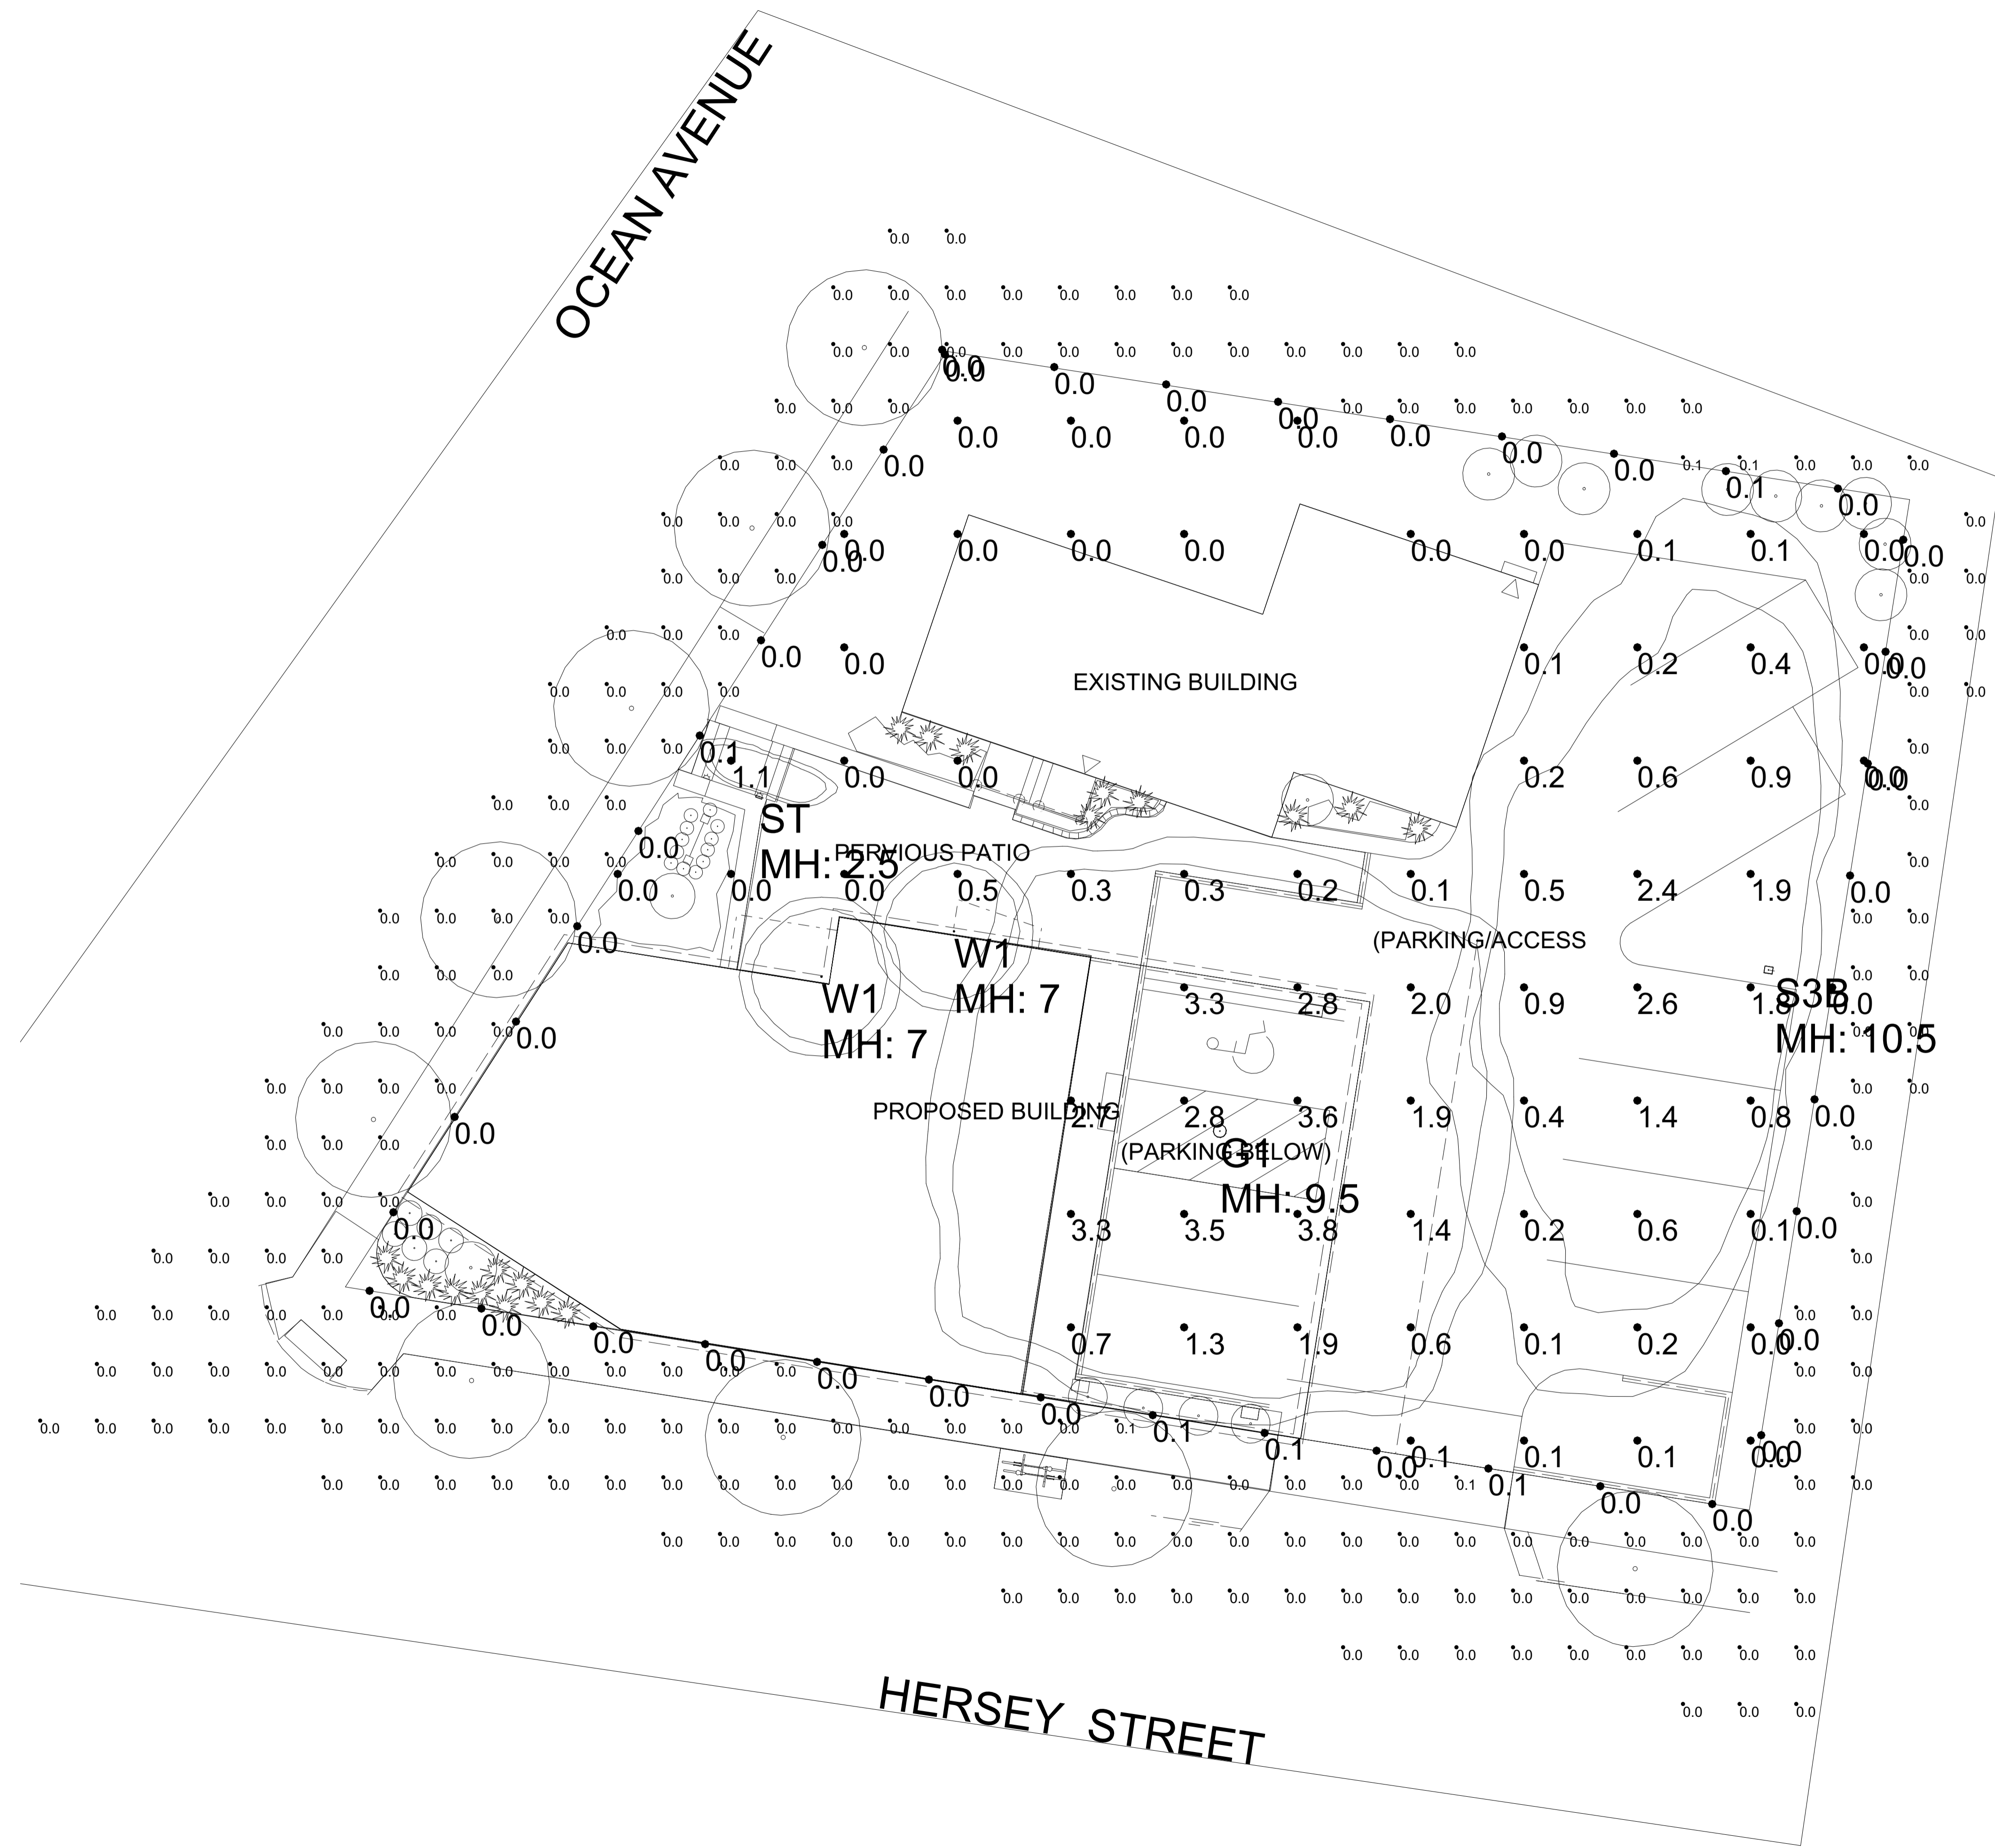

23 OCEAN AVE
 PORTLAND, ME
 PRELIMINARY SITE LIGHTING

DATE: 6/17/2016
 GENERATED BY SWANEY LIGHTING, SCARBOROUGH ME - 207-883-7100 - swaneylighting.com

WESCO
 BH MILLIKEN
 SCALE NOT TO SCALE
 Prelim site AGI

Page 1 of 1

SWANEY LIGHTING ASSOCIATES, INC.

CITY OF PORTLAND
 APPROVED FOR
 Subject to City of Portland Approval and Seal
 DATE OF APPROVAL 10/20/16
 PLANNER Neil Donohue
 PROJECT NO. 2016-150

THIS DRAWING IS THE PROPERTY OF SWANEY LIGHTING ASSOCIATES, INC. AND IS NOT TO BE REPRODUCED OR TRANSMITTED IN ANY FORM OR BY ANY MEANS, ELECTRONIC OR MECHANICAL, INCLUDING PHOTOCOPYING, RECORDING, OR BY ANY INFORMATION STORAGE AND RETRIEVAL SYSTEM, WITHOUT THE WRITTEN PERMISSION OF SWANEY LIGHTING ASSOCIATES, INC. THIS DRAWING IS TO BE USED FOR THE PROJECT AND SITE SPECIFICALLY IDENTIFIED HEREIN AND IS NOT TO BE USED FOR ANY OTHER PROJECT OR SITE. SWANEY LIGHTING ASSOCIATES, INC. MAKES NO WARRANTY, REPRESENTATION, OR GUARANTEE OF ANY KIND, EXPRESS OR IMPLIED, AS TO THE ACCURACY, COMPLETENESS, OR SUITABILITY OF THE INFORMATION PROVIDED IN THIS DRAWING. SWANEY LIGHTING ASSOCIATES, INC. SHALL NOT BE LIABLE FOR ANY DAMAGES, INCLUDING CONSEQUENTIAL DAMAGES, ARISING FROM THE USE OF THIS DRAWING. THE USER OF THIS DRAWING SHALL BE RESPONSIBLE FOR OBTAINING ALL NECESSARY PERMITS AND APPROVALS FROM THE APPLICABLE AGENCIES. SWANEY LIGHTING ASSOCIATES, INC. IS NOT RESPONSIBLE FOR THE PERFORMANCE OF THE MANUFACTURER OF ANY PRODUCTS SHOWN IN THIS DRAWING. ANY VARIATION IN FIXTURE PERFORMANCE FROM THAT SHOWN IN THIS DRAWING IS NOT THE RESPONSIBILITY OF SWANEY LIGHTING ASSOCIATES, INC.