


A REMODEL OF EXISTING: CODMAN STREET APARTMENTS FOR BAO BAO INVESTMENTS, INC.



VICINITY MAP:

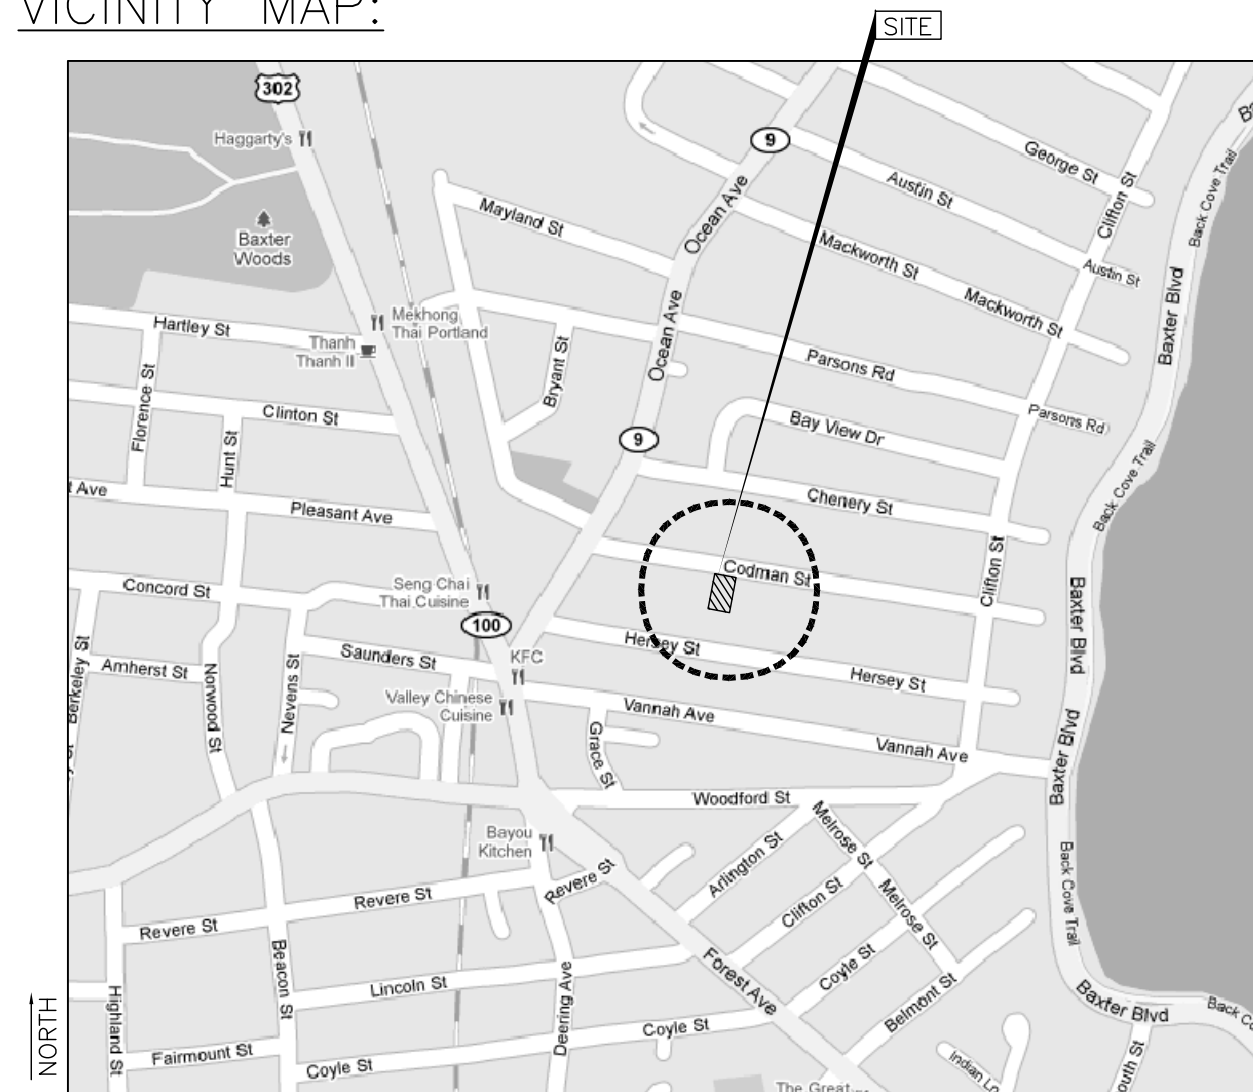

GENERAL NOTES:

- SCOPE: THIS IS A REMODEL OF AN EXISTING HOUSE, MOSTLY NEW FIXTURES, FURNISHINGS, CASEWORK, HARD FLOOR FINISHES, CASEWORK AND REPLACEMENT WINDOWS, SOME MINOR WALL REMOVAL AND MINOR WALL INSTALLATION, AND INTERIOR PAINTING. CHANGE OF OCCUPANCY USE, QUANTITY OF THREE (3) LIVING UNITS.
- REMOVE ALL EXISTING AND REPLACE AS REQUIRED (UNLESS OTHERWISE NOTED):
 - WINDOWS
 - DOORS
 - KITCHEN CABINETS
 - COUNTER TOPS
 - PLUMBING FIXTURES
 - APPLIANCES
 - KITCHEN AND BATHROOM FLOOR FINISHES
- PATCH AND PAINT ALL WALLS AND CEILINGS
- REMOVE ALL NON-FUNCTIONAL, BROKEN, NON-CODE COMPLIANT OR UNSAFE ELECTRICAL ITEMS AND REPLACE AS NEEDED (INCLUDING BUT NOT EXCLUSIVELY):
 - LIGHT FIXTURES
 - ELECTRICAL PANELS
 - WALL OUTLETS
 - WALL SWITCHES
- REMOVE ANY EXISTING SMOKE DETECTORS AND CARBON MONOXIDE DETECTORS.
- INSTALL NFPA COMPLIANT, U.L. LISTED PHOTO-EYE SMOKE DETECTORS AND CARBON MONOXIDE DETECTORS, AND EMERGENCY EXIT LIGHTING WITH DUAL POWERED HARDWIRED AC / BATTERY BACKUP UNITS, ALL WIRED WITH INTERCONNECTING ALARMS TO EACH LEVEL AS INDICATED ON DRAWINGS.
- REMOVE ALL INTERIOR WALL BOARD WITH MOLD, MILDEW, OR MOISTURE DAMAGE. REPLACE WITH BLUEBOARD IN TILED AREAS, CEMENTITIOUS BOARD IN WET AREAS, AND MOISTURE RESISTANT GYPSUM WALL BOARD IN ALL REMAINING AREAS.

LEGEND:

- CARBON MONOXIDE DETECTOR CEILING / WALL LOCATION (SEE FLOOR PLANS)
- SMOKE DETECTOR CEILING LOCATION CEILING / WALL LOCATION (SEE FLOOR PLANS)
- EXHAUST FAN VENTED TO OUTSIDE
- ILLUMINATED EMERGENCY EXIT SIGN WITH WAYFINDING LIGHTS
- INTERIOR WALL CONSTRUCTION 2X4 WOOD STUD @ 16" O.C. WITH 1/2" INT GWB EA SIDE. PATCH AND PAINT TO MATCH ADJACENT EXISTING CONDITION TO REMAIN
- EXTERIOR WALL CONSTRUCTION 2X6 WOOD STUD FRAMING @ 16" O.C. WITH 1/2" INT GWB & 3/8" EXT WOOD SHEATHING, MOISTURE BARRIER & SIDING TO MATCH EXISTING
- EXISTING WALL TO REMAIN
- EXISTING WALL TO BE DEMOLISHED
- MEANS OF EGRESS #1
- MEANS OF EGRESS #2

ALL CONDITIONS ARE DOCUMENTED AS EXISTING ON MAY 20, 2011

APPLICABLE BUILDING CODES:

- M.U.B.E.C. (MAINE UNIFORM BUILDING (AND) ENERGY CODE.
- MAINE PLUMBING CODE
- N.E.C. NATIONAL ELECTRICAL CODE
- N.F.P.A. 101 LIFE SAFETY CODE

ALL CURRENT VERSIONS UNO

OCCUPANCY CLASSIFICATION: RESIDENTIAL GROUP R-2 APARTMENT HOUSE

CONSTRUCTION: TYPE V B, NON-SPRINKLED
ALLOWABLE HEIGHT: 40 FEET, 2 STORIES (GRAND FATHERED)
ALLOWABLE AREA: 7,000 SQUARE FEET

ABBREVIATIONS:

- AFF ABOVE FINISHED FLOOR
- CLG CEILING
- C CENTERLINE
- CONC CONCRETE
- DN DOWN
- EXT EXTERIOR
- GWB GYPSUM WALLBOARD
- HTR HEATER
- INT INTERIOR
- MHT (APPARENT) MEAN HIGH TIDE
- OD OUT DIAMETER
- POOD POST CURRENT OWNER DEVELOPMENT
- P PROPERTY LINE
- REF REFRIGERATOR
- ROW RIGHT OF WAY
- UNO UNLESS NOTED OTHERWISE
- WTR WATER

SHEET INDEX:

- G-0.0 COVER SHEET
- C-0.1 SITE PLAN
- D-1.0 BASEMENT AND FIRST FLOOR DEMO PLANS
- D-1.1 SECOND FLOOR DEMO PLAN
- A-1.0 BASEMENT AND FIRST FLOOR PLANS
- A-1.1 SECOND AND THIRD FLOOR PLANS
- A-5.0 FRAMING DETAILS
- A-6.0 DOOR AND WINDOW TYPES AND SCHEDULES

Sheet Notes

- SEE GENERAL NOTES ON COVER SHEET.
- ALL POOD WAS DONE WITHOUT A BLDG. PERMIT AND IS DOCUMENTED IN THIS SET RETROACTIVELY FOR CITY CEO.
- ALL WORK PREVIOUSLY DONE (WITHOUT BUILDING PERMIT) AFTER CURRENT OWNER IS SHOWN AS NEW WORK EVEN IF IT CURRENTLY EXISTS, PER PORTLAND CODE ENFORCEMENT OFFICE.

No. Revision / Issue Date

ALBADO ENTERPRISES
92 BROADWAY
ROCKLAND, ME 04841
Tel: (310) 963-7670
Fax: (866) 283-1199
E- MARIO@ALBADOENTERPRISES.COM

STEVE RUSZKAL, ARCHITECT
17 POND SHORE DRIVE
CUMBERLAND, ME 04021
Tel: (207) 408-9913
Fax: (207) 809-5990
E- SRUSZKA@MAINE.RR.COM

DEVELOPER:
BAO BAO INVESTMENT, INC.
PORTLAND, ME 04101
TEL (207) 879-7600

AN APARTMENT RENOVATION FOR:
CODMAN ST. APARTMENTS
17 CODMAN STREET
PORTLAND, ME 04103

Issued: 15 JULY 2011

Scale: AS NOTED

Drawn By: MA & SPR

Reviewed By:

GENERAL COVER

G-0.0