

REVISION	0	ISSUED FOR REVIEW & APPROVAL	5/3/2016
DESCRIPTION			
DATE			


RESERVED FOR CITY STAMP

**CUNNINGHAM**  
**Security Systems**  
 10 Princes Point Road, Yarmouth, Maine 04096  
 Office: 207.846.3350 • Fax: 207.846.6080

**PLEASANT AVENUE**  
**PORTLAND, MAINE**  
**FIRST FLOOR FIRE ALARM PLAN**

DRAWN	JPB	UNICAD JOB #16232
CHECKED	WAYNE B. HAWES	PROJECT # 90496
DATE	5/3/2016	
REVISION	0	
SCALE	1/8"=1'-0"	

**FA-3**

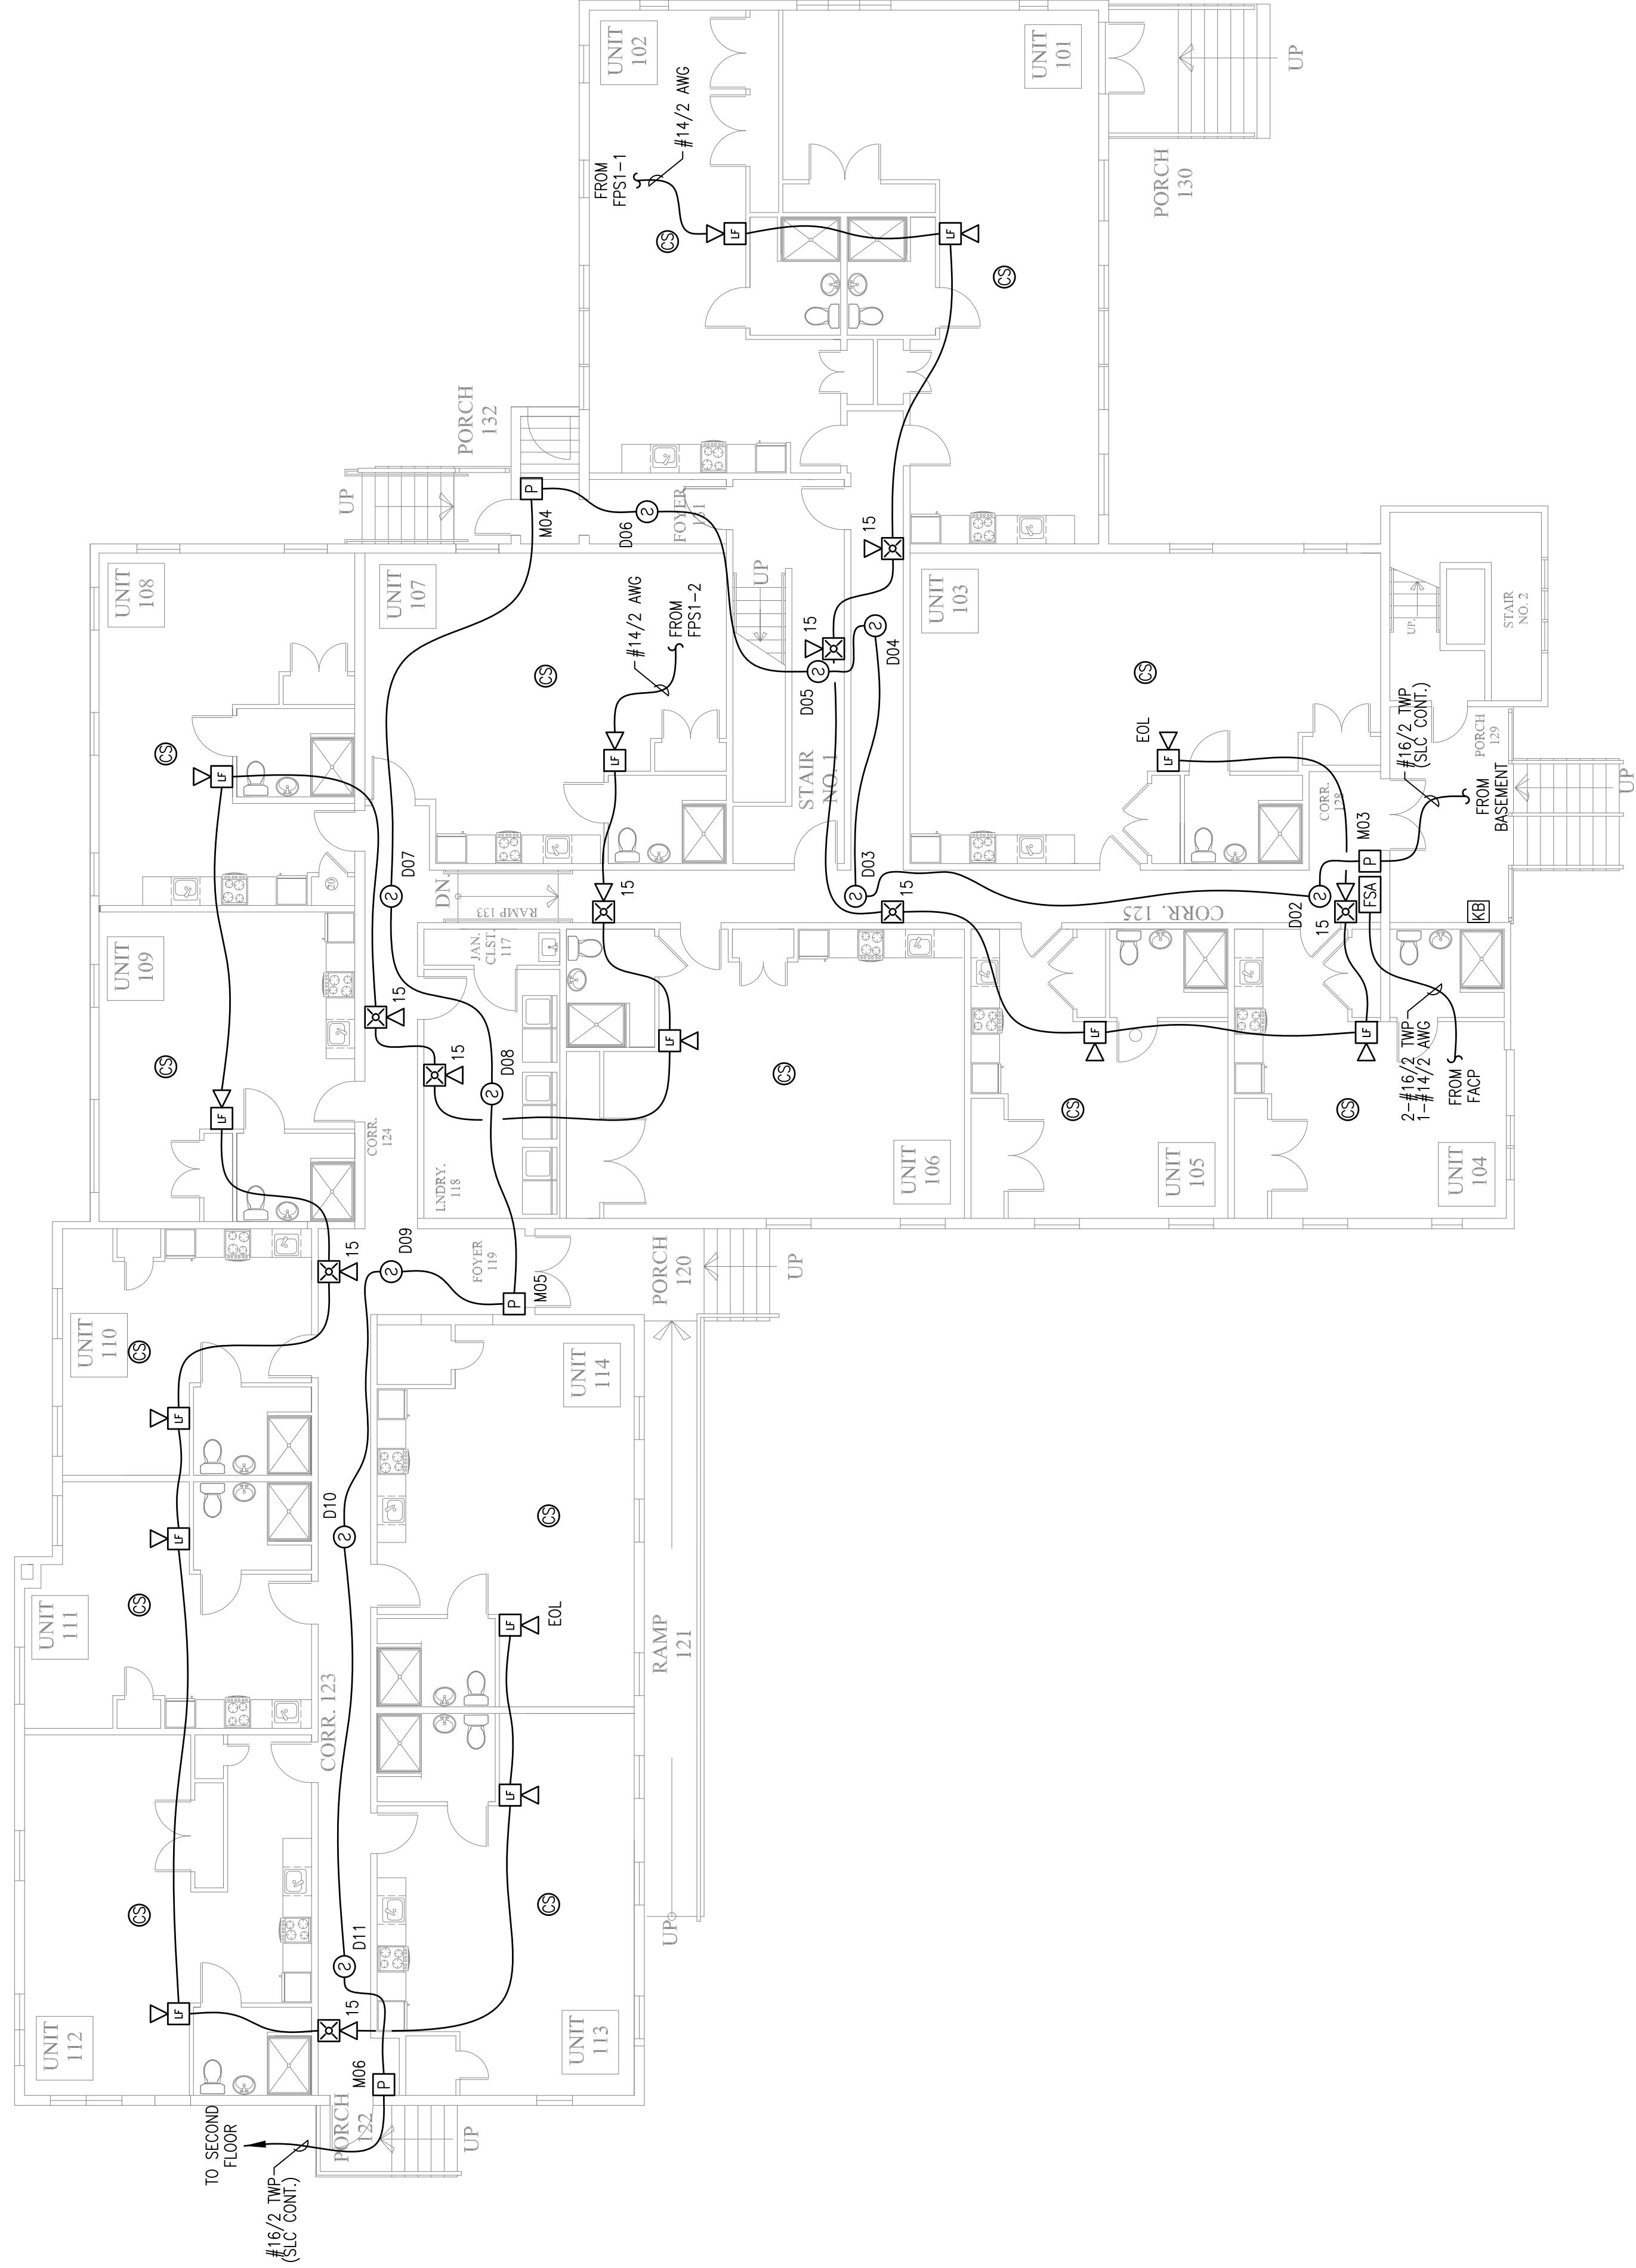

**FIRST FLOOR FIRE ALARM PLAN**  
 SCALE: 1/8"=1'-0"

