

REVISION	0	ISSUED FOR REVIEW & APPROVAL	5/3/2016
DESCRIPTION			
DATE			

RESERVED FOR CITY STAMP


CUNNINGHAM
Security Systems

10 Princes Point Road, Yarmouth, Maine 04096
Office: 207.846.3350 • Fax: 207.846.6080

**PLEASANT AVENUE
PORTLAND, MAINE
SECOND FLOOR FIRE ALARM PLAN**

DRAWN	JPB	UNICAD JOB #16232
CHECKED	WAYNE B. HAWES	PROJECT # 90496
DATE	5/3/2016	
REVISION	0	
SCALE	1/8"=1'-0"	

FA-4

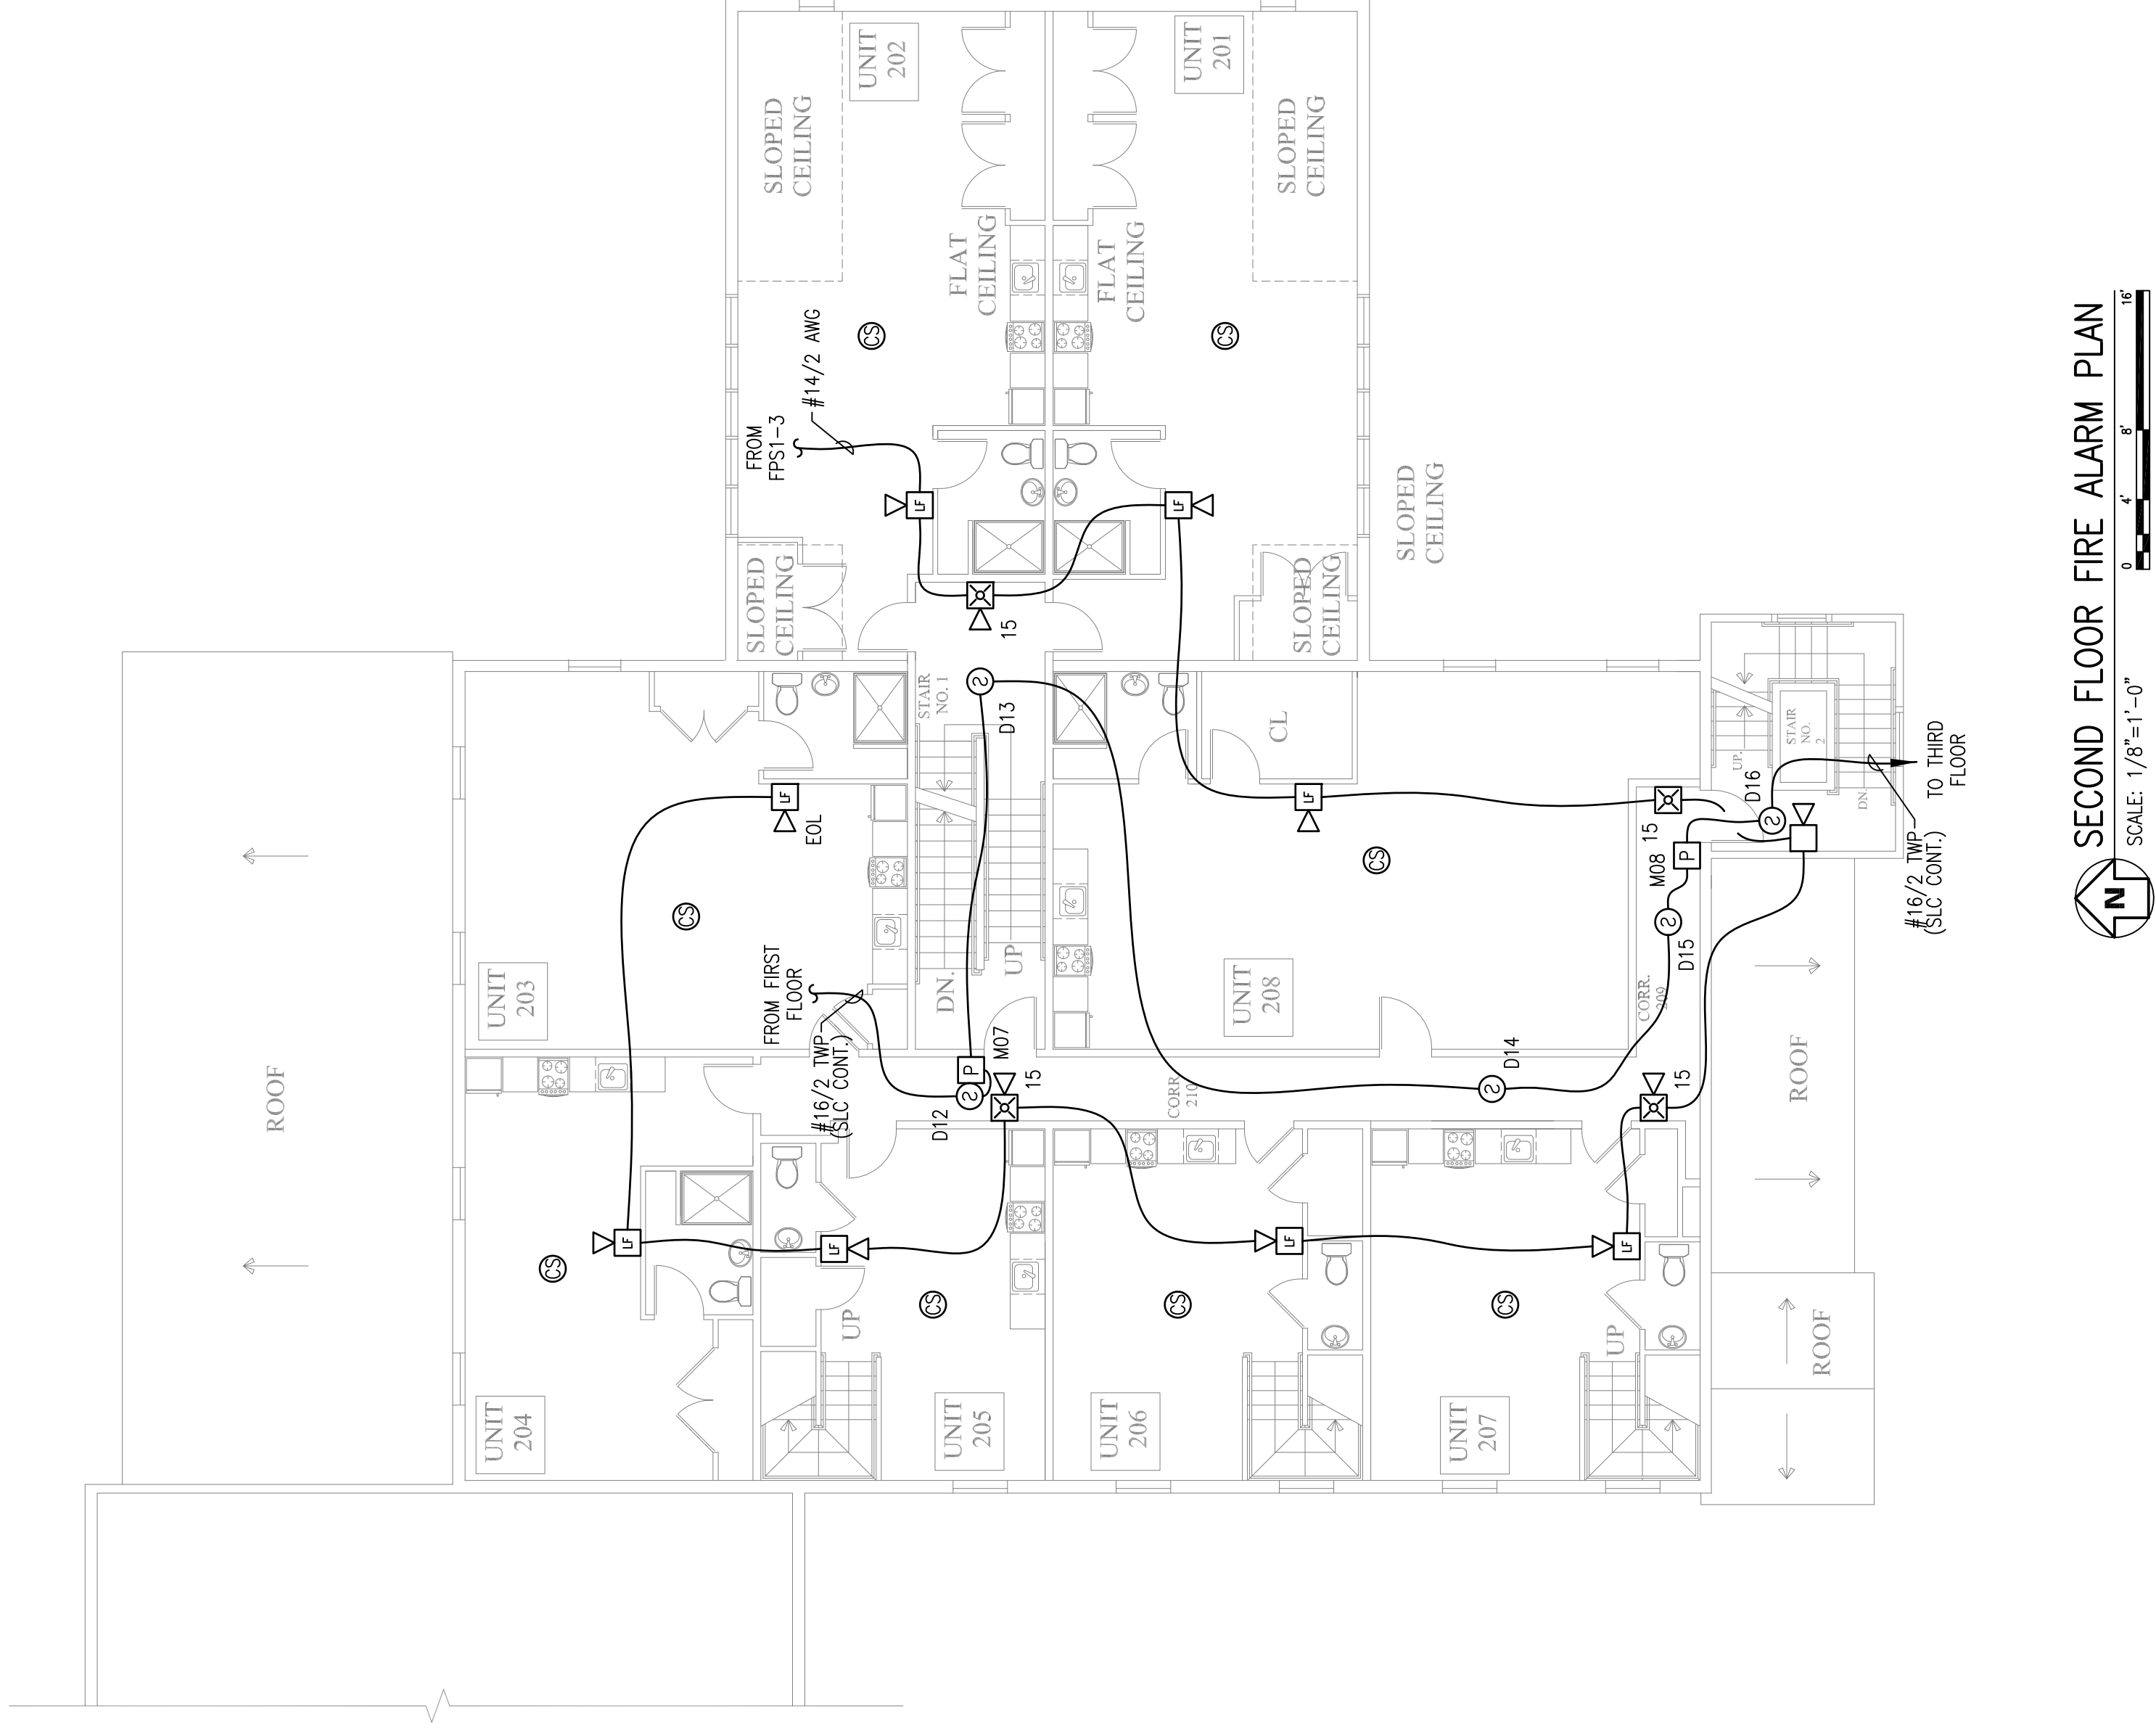

UNICAD Inc.
Fire Alarm Design & Drafting Services

www.unicad.net
579A W. 40th St.
Portland, ME 04106
Office: 603.865.6410