


Returns
 8" 200 CFM 2nd fl 1200
 12" 200 CFM 3rd fl 200
 1900 quiet

Variable Speed w/ 2 stage Cooling

⊕ SURFACE MOUNTED FIXTURE
 ⊖ PENDANT

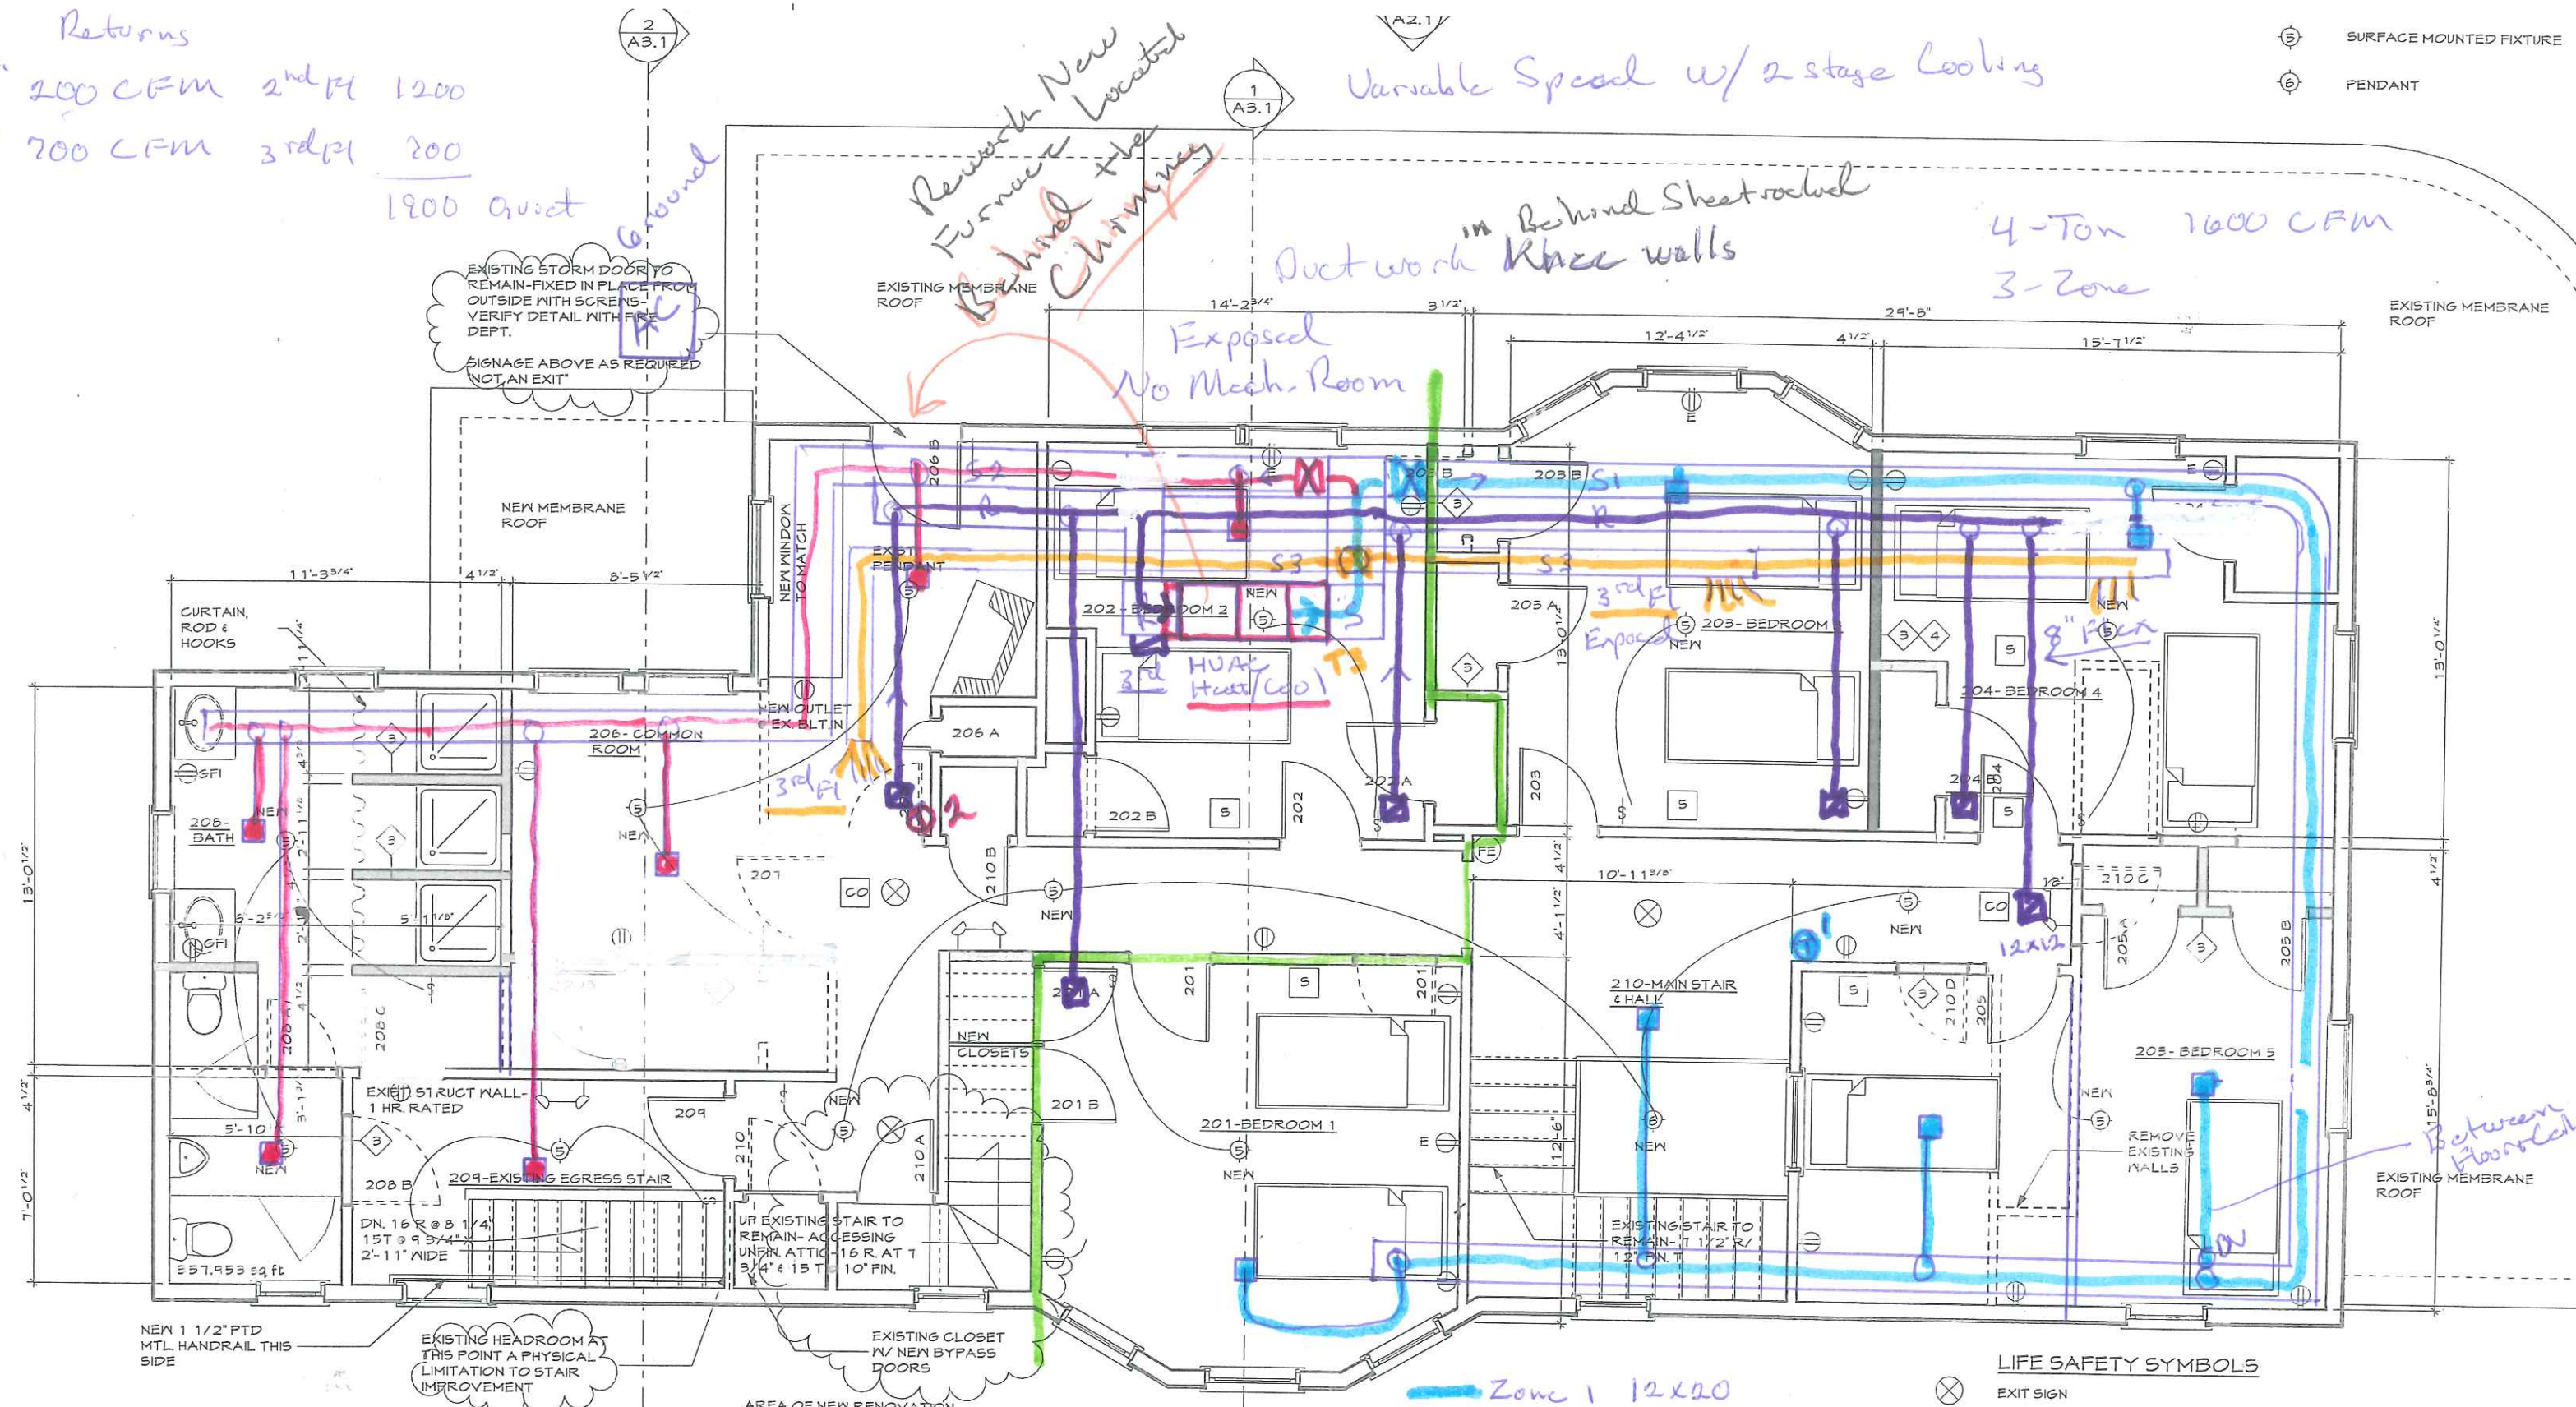

Zone 1 12x20
 Zone 2 12x20
 3rd fl 14" Spiral exposed
 Return

LIFE SAFETY SYMBOLS
 ⊗ EXIT SIGN
 ⊕ EMERGENCY LIGHTING
 S SMOKE DETECTOR
 FE FIRE EXT. WALL MTD.
 CO CARBON MONOXIDE DETECTOR

1 Second Floor Pl
 A1.3 SCALE: 1/4" = 1'-0"
 Heating Plan

This will heat the 2nd + 3rd Floor for Sprinkler System