


1 First Floor Reflected Ceiling Plan  
SCALE: 1/8" = 1'-0"

2 Second Floor Reflected Ceiling Plan  
SCALE: 1/8" = 1'-0"

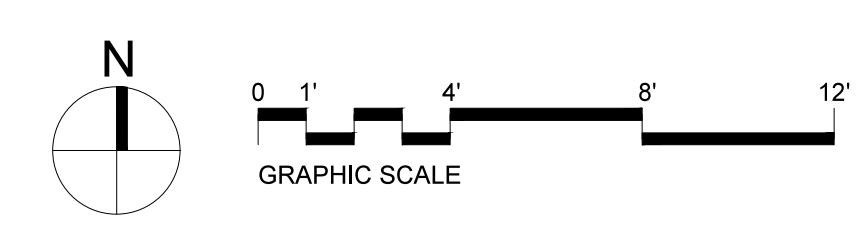

LDD PROJECT NAME: N/A  
DRAWING NAME: N/A  
FIELD BOOK USED: N/A

Scott Simons Architects  
75 York Street, Portland, Maine 04101  
www.simonsarchitects.com  
207.772.4656

DESIGNED BY: AKS  
DRAWN BY: KC  
CHECKED BY: AKS  
SCALE: AS SHOWN  
DATE: 02/06/15

REFERENCES:

PORTLAND PUBLIC LIBRARY  
BURBANK BRANCH  
377 Stevens Avenue  
Deering Center  
Portland, Maine 04103

CITY OF PORTLAND, MAINE  
Addition + Renovation for  
The Burbank Branch Library  
ISSUED FOR PERMITTING

REFLECTED CEILING PLANS

SHEET # **A131**  
PLAN NUMBER

