



1 ELECTRICAL POWER & SYSTEMS PLAN - SECOND FLOOR  
SCALE: 1/4"=1'

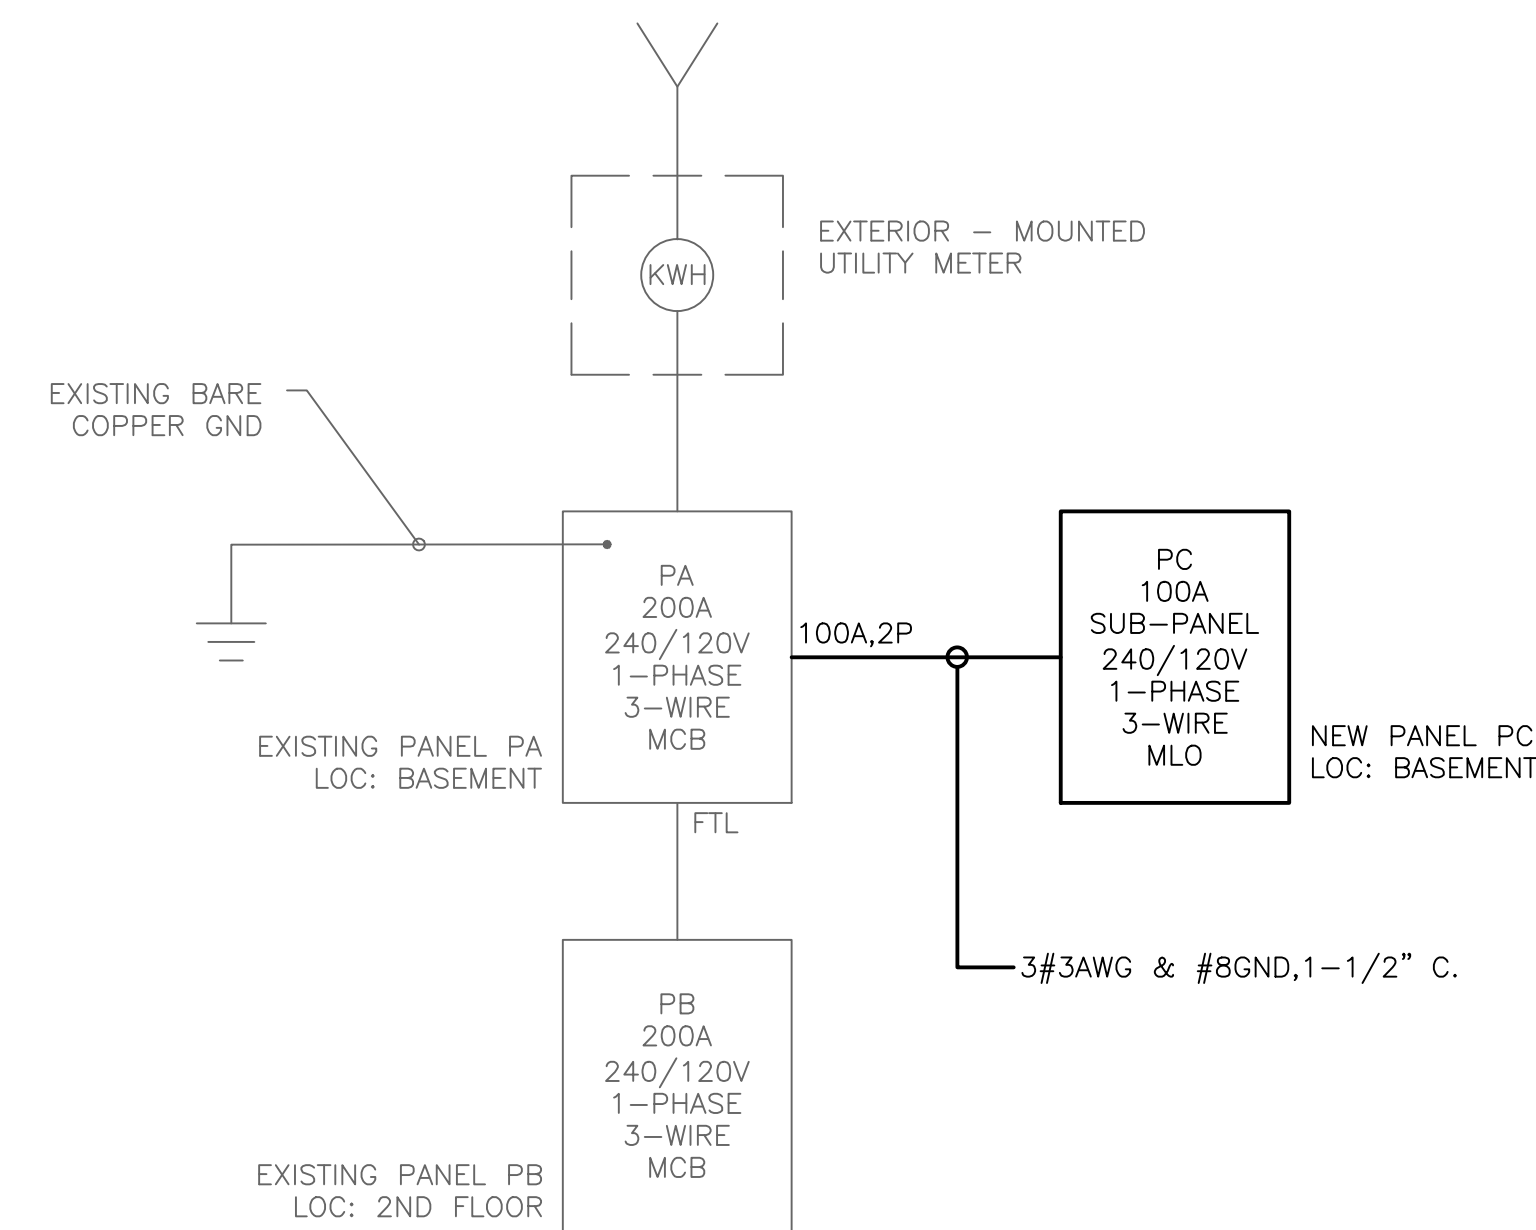

3 ONE LINE DIAGRAM (BASE BID)  
SCALE: NOT TO SCALE

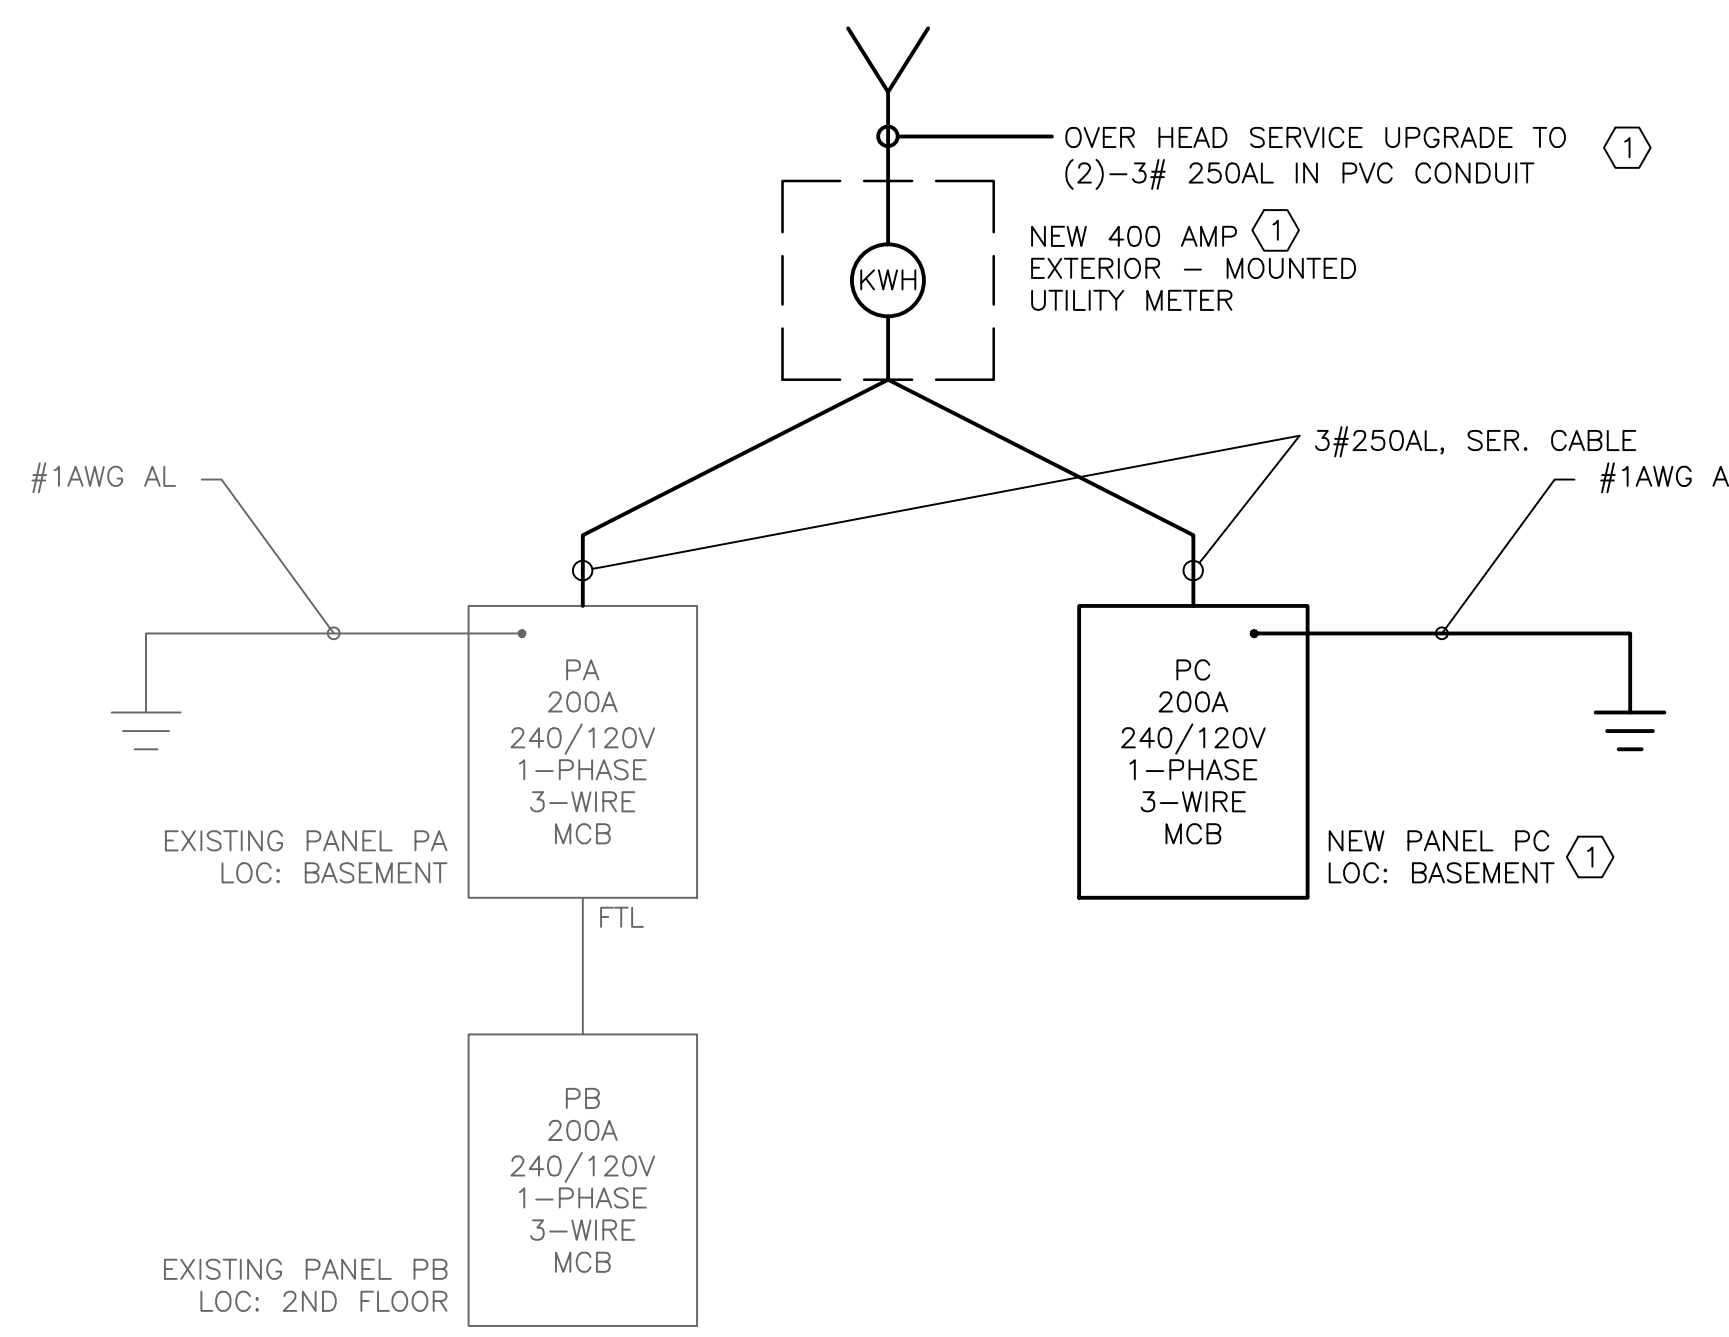

2 ONE LINE DIAGRAM (ADD ALTERNATE)  
SCALE: NOT TO SCALE

**NOTES:**  
1. SEE E0.0 FOR LEGEND, ABBREVIATIONS AND GENERAL NOTES.

**KEYED NOTES:**  
① AIR CONDITIONING ADD ALTERNATE.  
② PANEL PB IS LOCATED IN WALL BEING REMOVED AND REPLACED. REMOVE AND REINSTALL EXISTING PANEL IN NEW WALL. SPIN PANEL 180 DEGREES SO FACING CORRIDOR (NOT SINK).  
③ RELOCATE EXISTING AREA OF REFUGE CALL BOX TO THIS LOCATION.


LDD PROJECT NAME:  
N/A  
DRAWING NAME:  
FIELD BOOK USED:  
N/A

Scott Simons Architects  
75 York Street, Portland, Maine 04101  
www.simonsarchitects.com  
207.772.4656



REFERENCES:

|              |           |             |        |        |
|--------------|-----------|-------------|--------|--------|
| DESIGNED BY: | DRAWN BY: | CHECKED BY: | SCALE: | DATE:  |
|              |           |             |        | 2-6-15 |

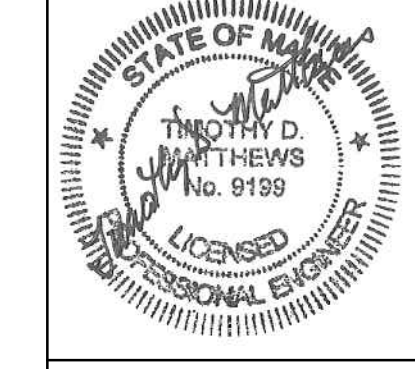

PORTLAND PUBLIC LIBRARY  
BURBANK BRANCH  
377 Stevens Avenue  
Deering Center  
Portland, Maine 04103

CITY OF PORTLAND, MAINE  
Addition + Renovation for  
The Burbank Branch Library  
ISSUED FOR PERMITTING

ELECTRICAL POWER & SYSTEMS FLOOR  
PLAN - SECOND FLOOR

SHEET #  
**E1.2**  
PLAN NUMBER

