


**1** ELECTRICAL LIGHTING & FIRE ALARM PLAN – SECOND FLOOR  
SCALE: 1/4"=1'

LIGHTING CONTROL SCHEDULE		
ROOM	FIXTURE "ON" BY	FIXTURE "OFF" BY
101 VESTIBULE	CORNER SENSOR	CORNER SENSOR
102 HOLD/PUBLIC COMPUTING	SWITCH	SWITCH/CEILING SENSOR
102B RAMP	SWITCH	SWITCH/CEILING SENSOR
103 TOILET	EXISTING SWITCH	EXISTING SWITCH
104 STAIR	EXISTING SWITCH	EXISTING SWITCH
106A PROCESSING	SWITCH	SWITCH/CEILING SENSOR
106B OFFICE	WALL SENSOR	WALL SENSOR
108 CIRCULATION	SWITCH	SWITCH/CEILING SENSOR
109A,B NEW ADULT FICTION	SWITCH	SWITCH/CEILING SENSOR
110 CHILDRENS	SWITCH	SWITCH/CEILING SENSOR
111 YOUTH SERVICES	WALL SENSOR	SWITCH/CEILING SENSOR
112 HALL	SWITCH	SWITCH/CEILING SENSOR
13 MECHANICAL ROOM	SWITCH	SWITCH/CEILING SENSOR

LIGHTING CONTROL SCHEDULE		
ROOM	FIXTURE "ON" BY	FIXTURE "OFF" BY
201 UPPER STAIR HALL	CORNER SENSOR	CORNER SENSOR
202 ADULT NON FICTION	SWITCH	SWITCH/CEILING SENSOR
203 UPPER HALL	EXISTING SWITCH	EXISTING SWITCH
204 CORRIDOR	EXISTING SWITCH	EXISTING SWITCH
205 STAFF TOILET	EXISTING SWITCH	EXISTING SWITCH
206 STAFF ROOM	SWITCH	SWITCH/CEILING SENSOR
207 COLLECTION	SWITCH	SWITCH/CEILING SENSOR

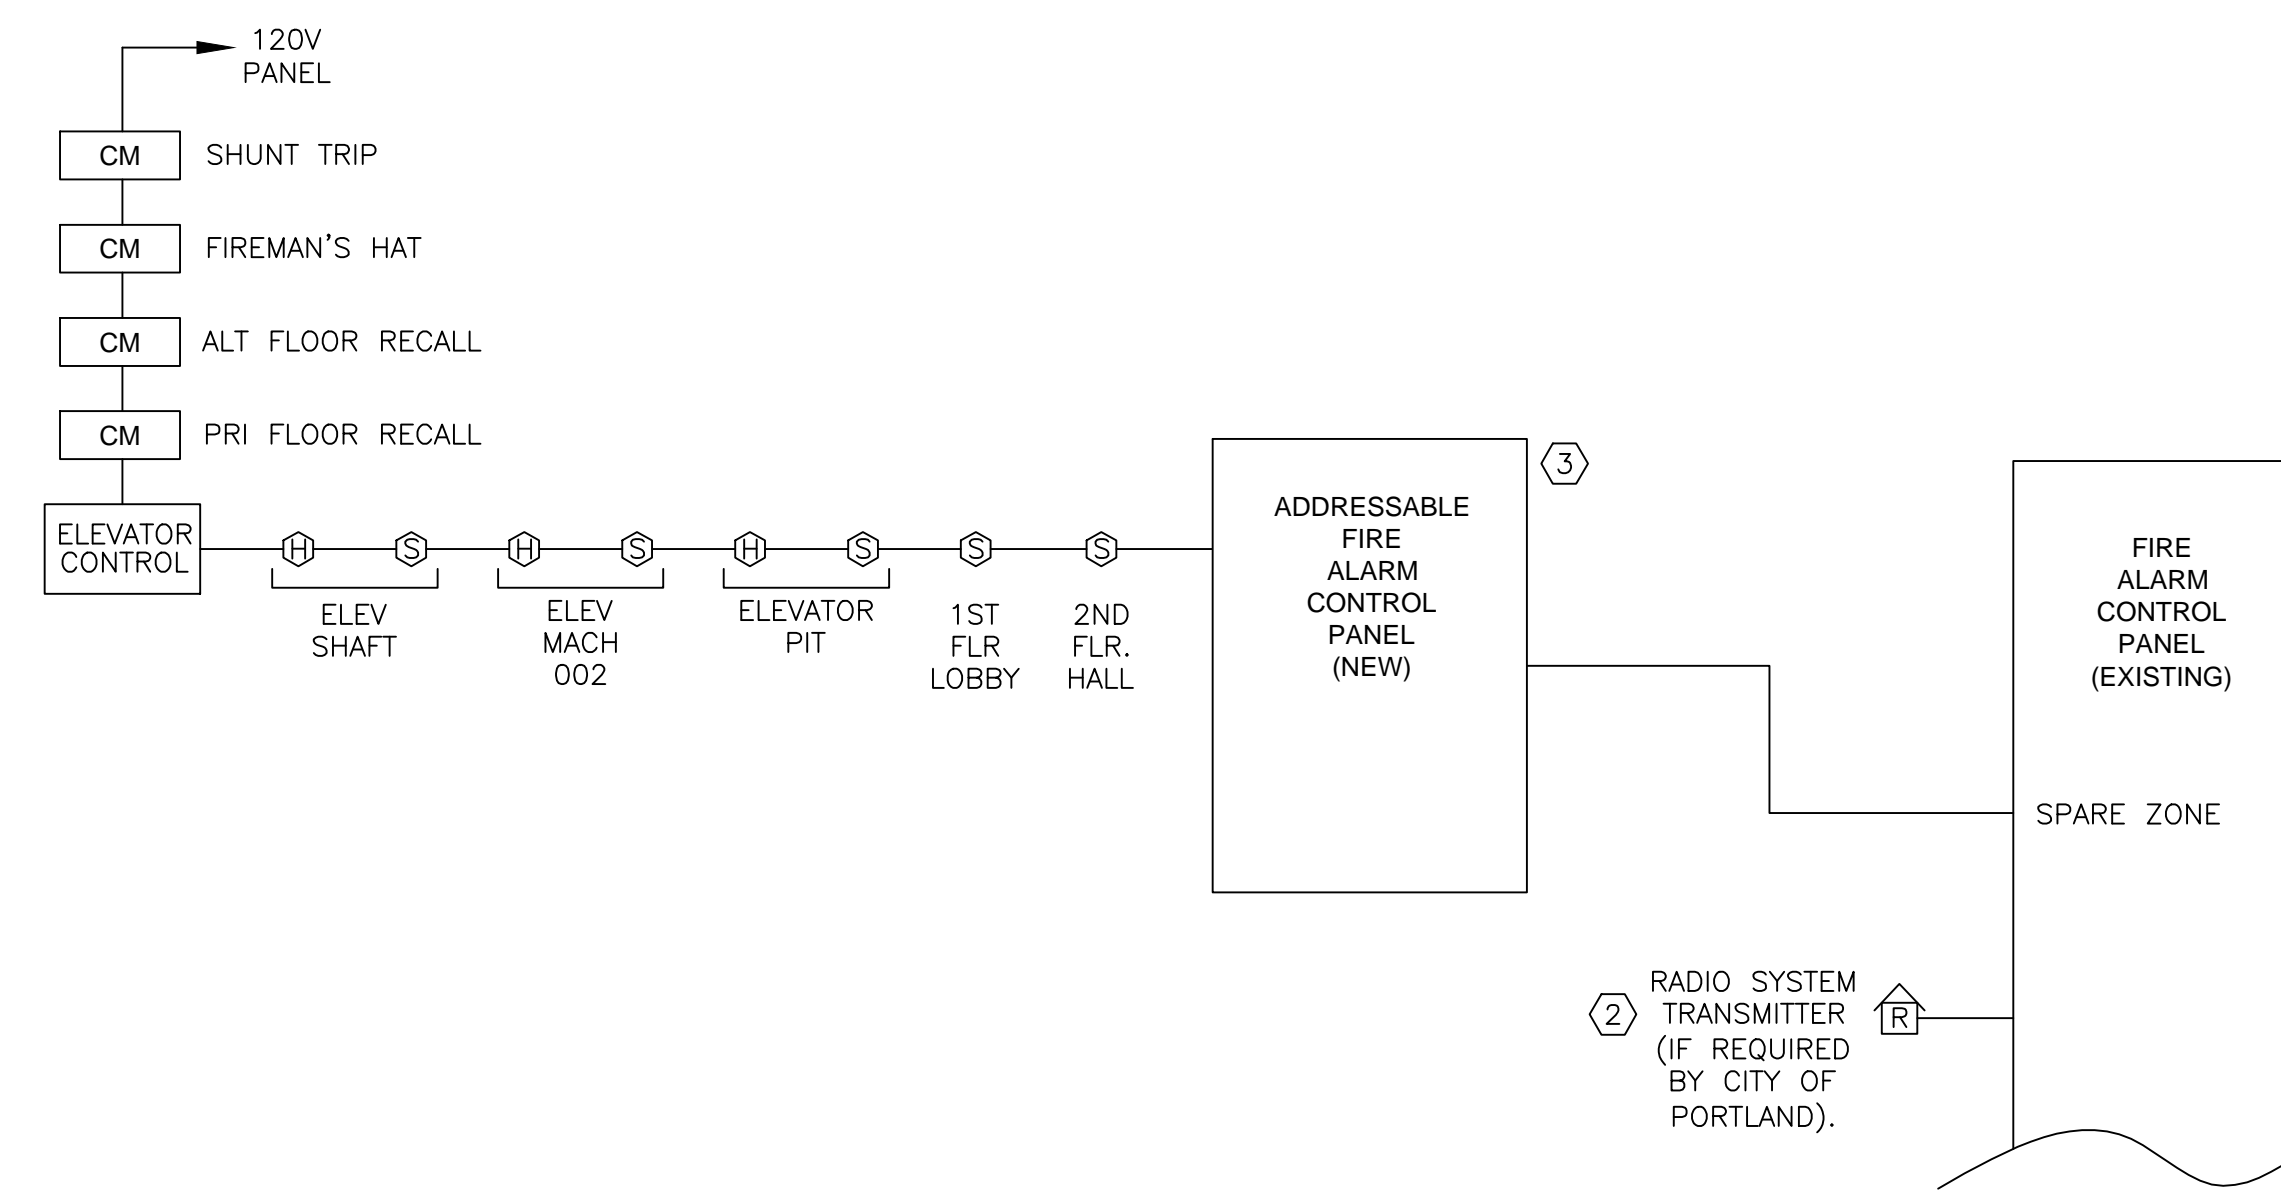


**2** FIRE ALARM RISER DIAGRAM – NEW AND EXISTING(PARTIAL)  
SCALE: NOT TO SCALE

**NOTES:**  
1. SEE E0.0 FOR LEGEND, ABBREVIATIONS AND GENERAL NOTES.  
**KEYED NOTES:**  
① EXISTING LIGHTING TO REMAIN IN 203 UPPER HALL, 204 CORRIDOR, 205 STAFF TOILET  
② CITY OF PORTLAND IS REQUIRING INSTALLATION OF NEW RADIO BASED TELEMTRY EQUIPMENT WHEN ALTERATIONS/UPGRADES ARE MADE TO FIRE ALARM PANELS.  
③ FURNISH NEW ADDRESSABLE FIRE ALARM PANEL TO SUPPORT THE ELEVATOR RECALL AND MONITORING FUNCTIONS SHOWN. CONNECT ALARM OUTPUT OF THIS PANEL TO THE SPARE ZONE OF THE EXISTING FIRE ALARM CONTROL PANEL.

LDD PROJECT NAME: N/A  
DRAWING NAME: N/A  
FIELD BOOK USED: N/A  
Scott Spone Architects  
75 York Street, Portland, Maine 04101  
www.scottsponearchitects.com  
207.772.4656

**REFERENCES:**  
DESIGNED BY:  
DRAWN BY:  
CHECKED BY:  
SCALE:  
DATE: 2-6-15

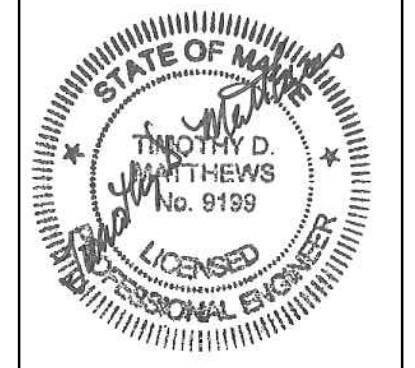

PORTLAND PUBLIC LIBRARY  
BURBANK BRANCH  
377 Stevens Avenue  
Deering Center  
Portland, Maine 04103

CITY OF PORTLAND, MAINE  
Addition + Renovation for  
The Burbank Branch Library  
ISSUED FOR PERMITTING

**ELECTRICAL LIGHTING & FIRE ALARM PLAN - SECOND FLOOR**  
SHEET # **E2.2**  
PLAN NUMBER

