

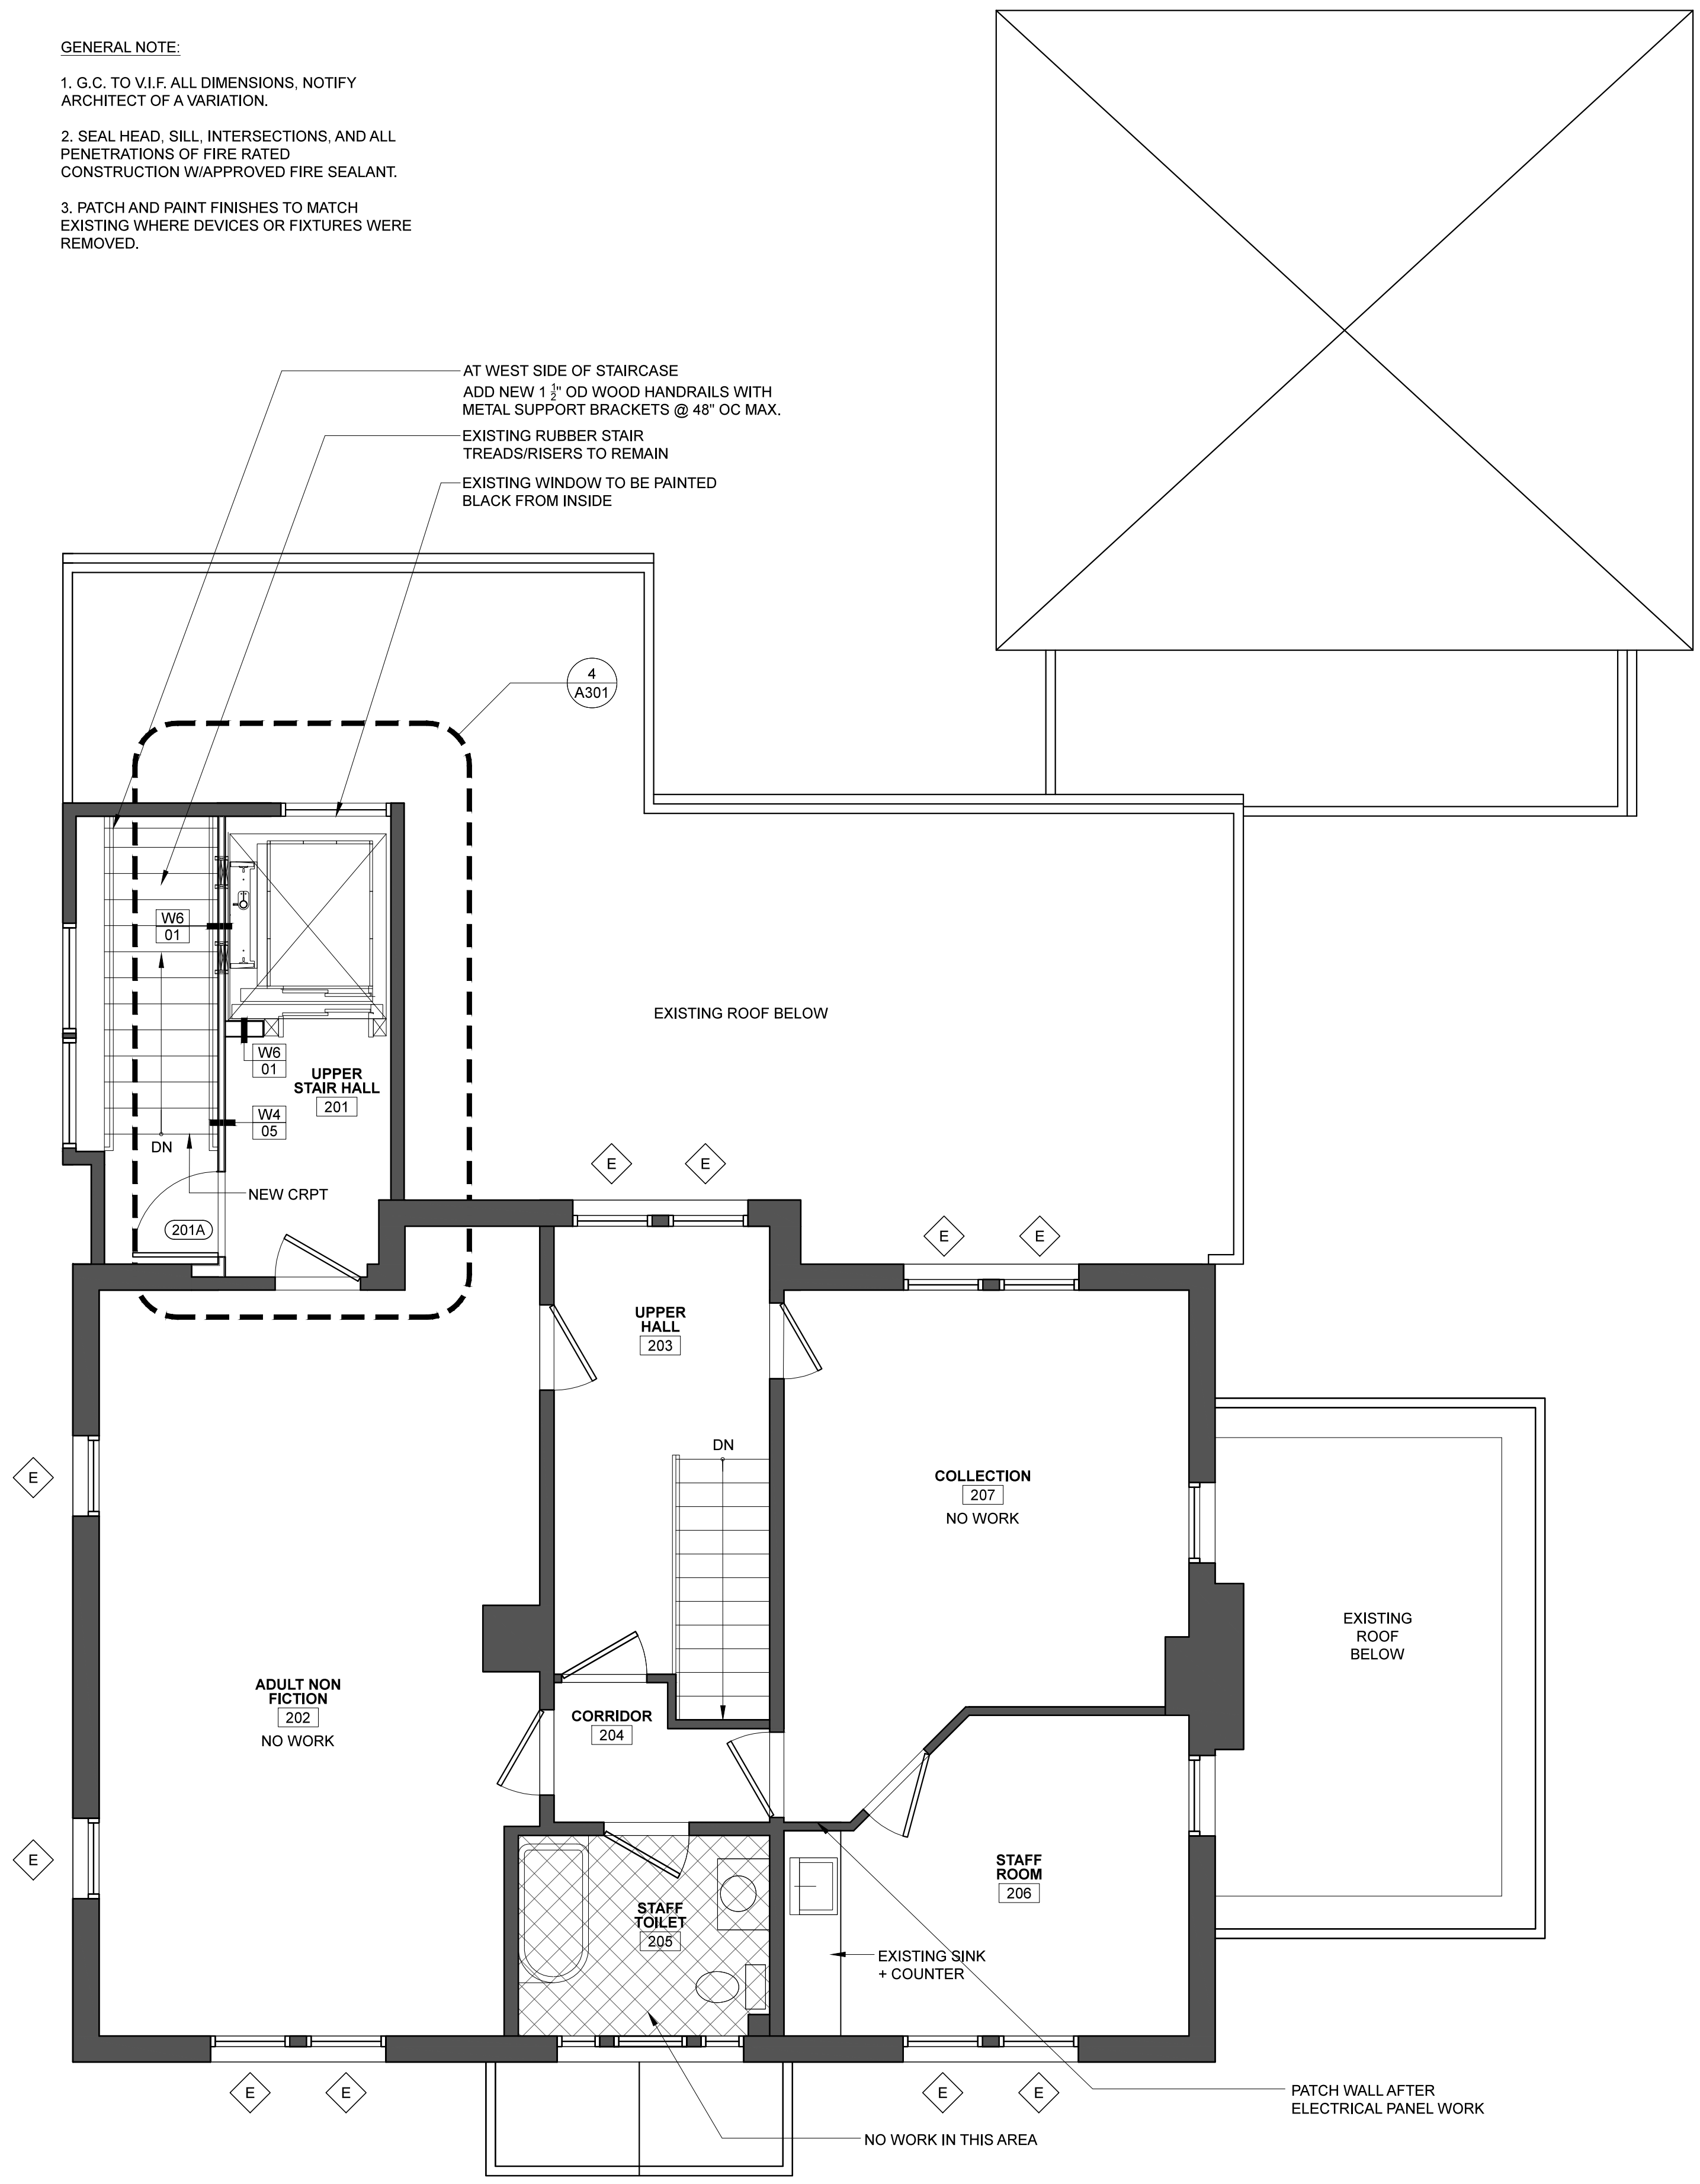


GENERAL NOTE:


1. G.C. TO V.I.F. ALL DIMENSIONS, NOTIFY ARCHITECT OF A VARIATION.
2. SEAL HEAD, SILL, INTERSECTIONS, AND ALL PENETRATIONS OF FIRE RATED CONSTRUCTION W/APPROVED FIRE SEALANT.
3. PATCH AND PAINT FINISHES TO MATCH EXISTING WHERE DEVICES OR FIXTURES WERE REMOVED.

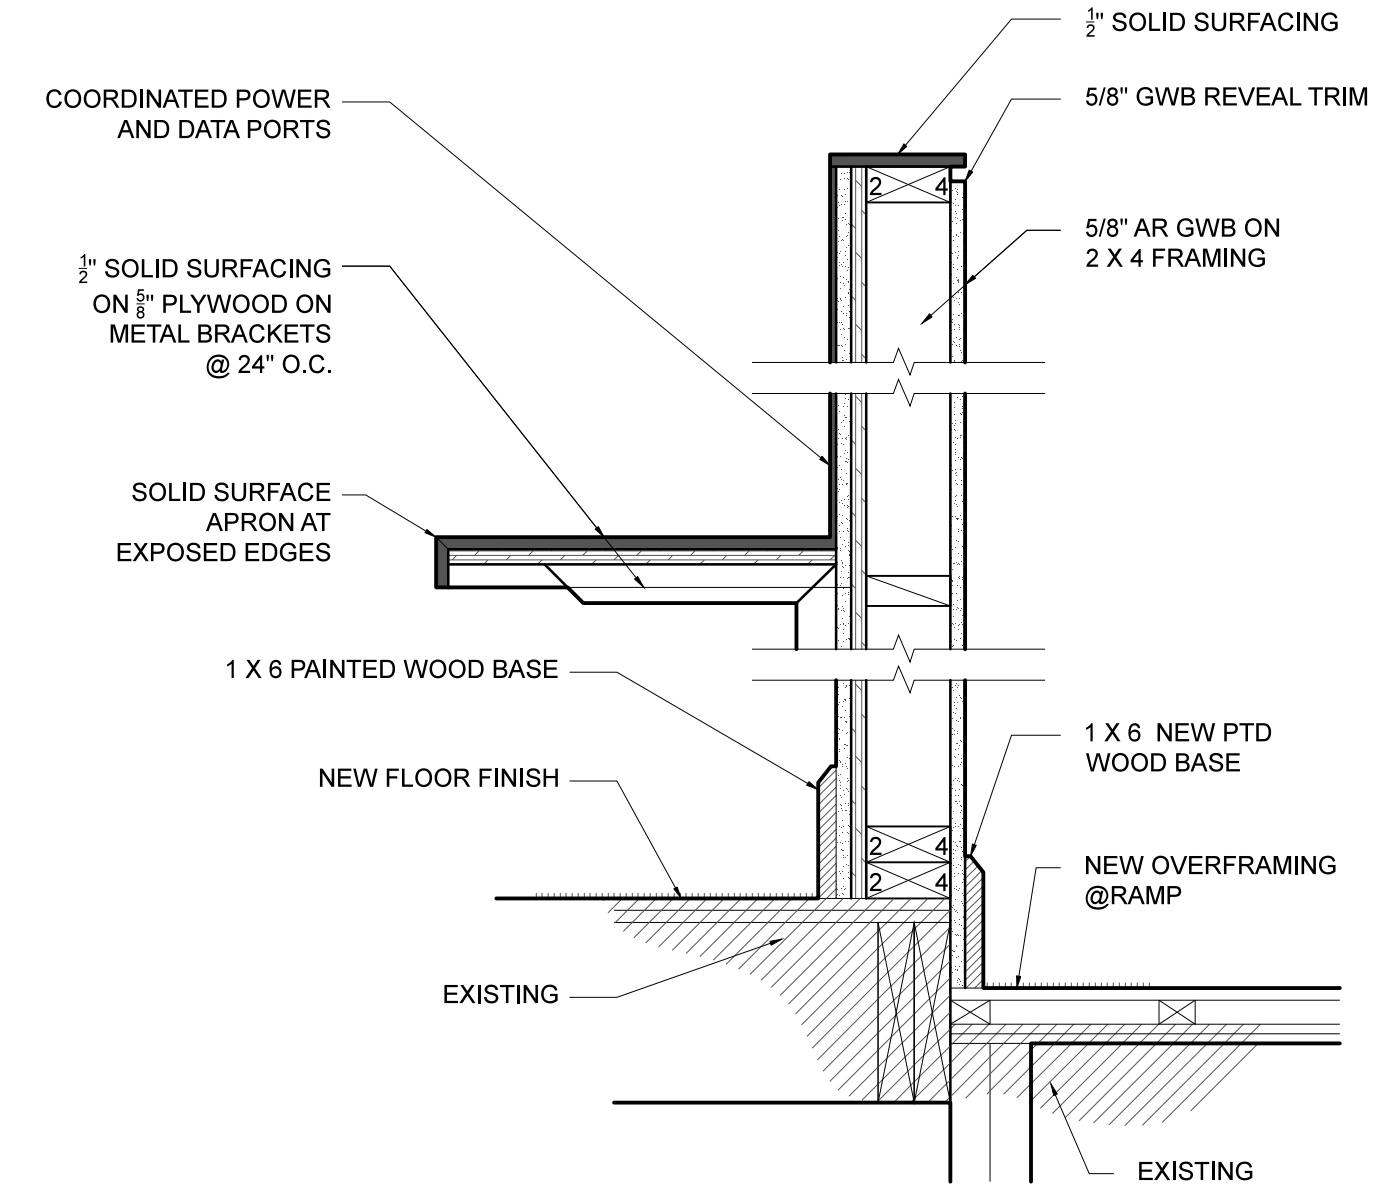

1 Second Floor Plan
SCALE: 1/4" = 1'-0"

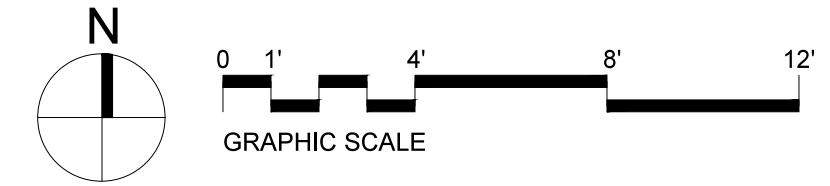

4 Counter Section
SCALE: 1 1/2" = 1'-0"

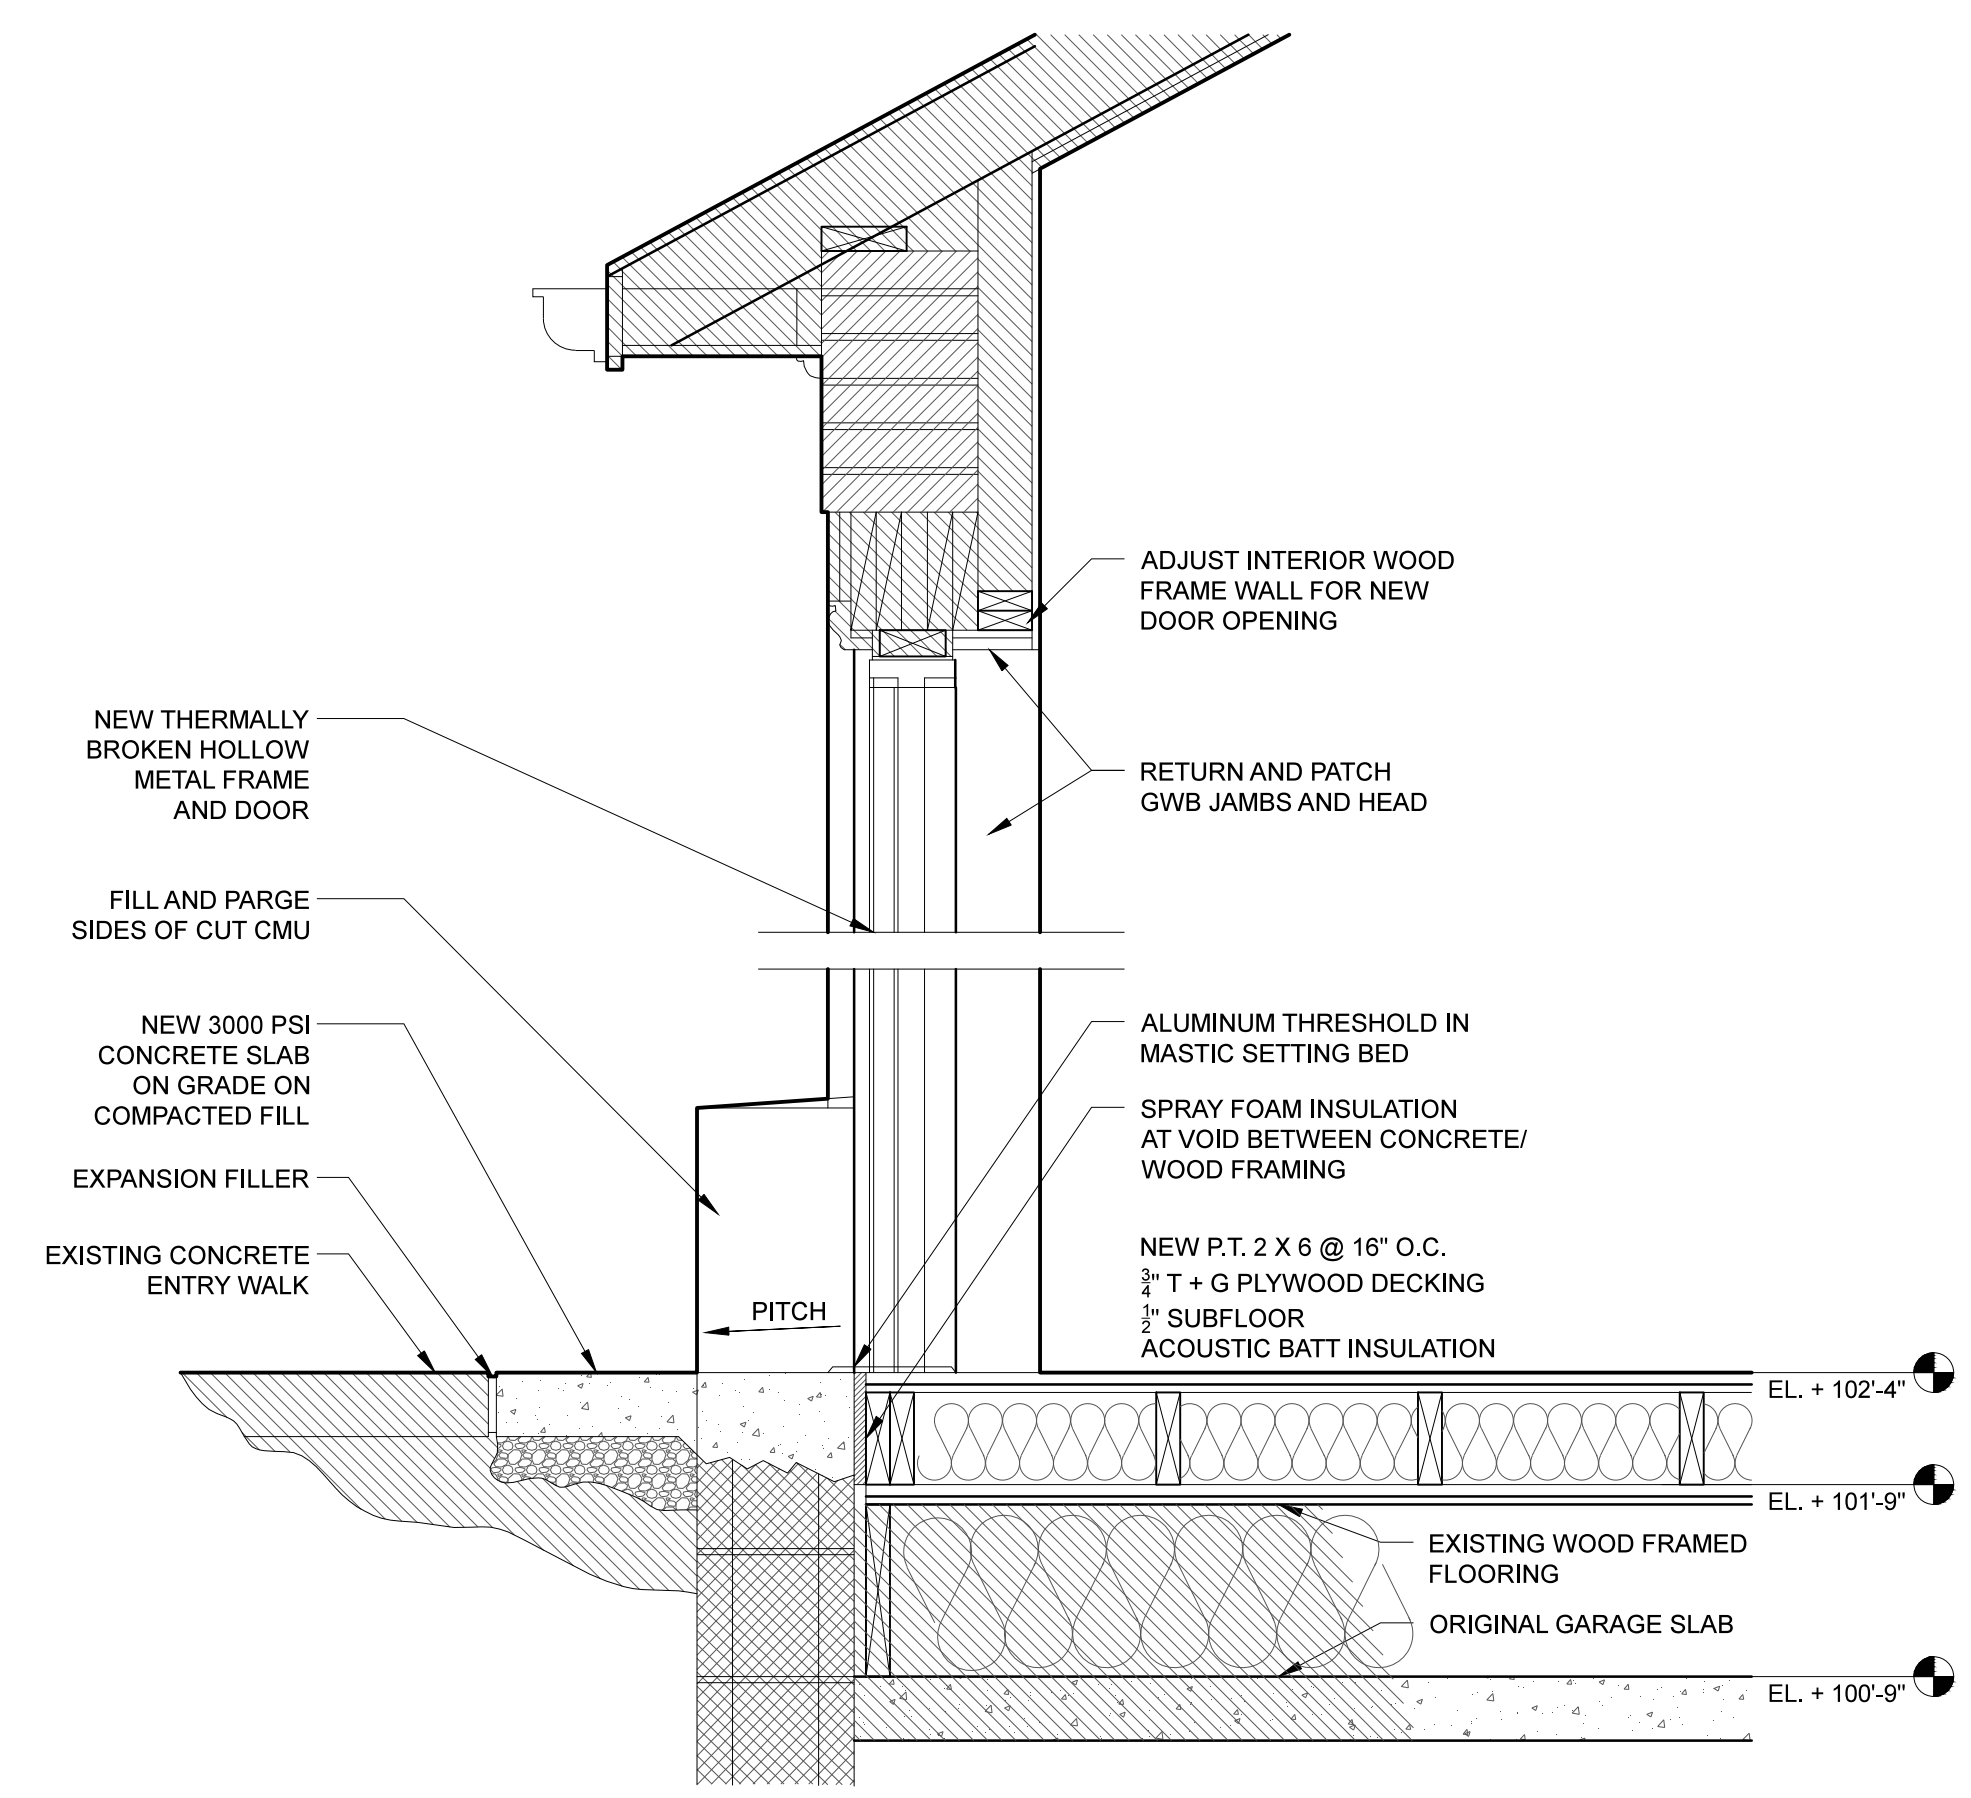

3 Wall Section
SCALE: 1" = 1'-0"


LDD PROJECT NAME:
N/A
DRAWING NAME:
FIELD BOOK USED:
N/A

Scott Simons Architects
75 York Street, Portland, Maine 04101
www.scottsimonsarchitects.com
207.777.4656

424 Fore Street
Portland, Maine 04101
Phone: 207.842.2860
Fax: 207.842.2828
www.cascobayengineering.com

REFERENCES:

DESIGNED BY:	AKS
DRAWN BY:	KC
CHECKED BY:	AKS
SCALE:	AS SHOWN
DATE:	10/16/15

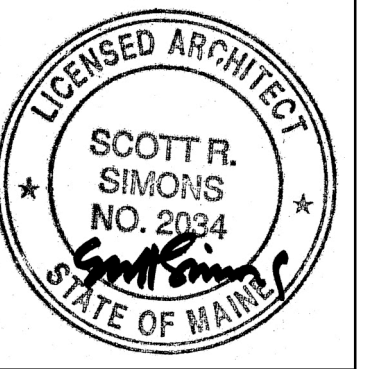

PORTLAND PUBLIC LIBRARY
BURBANK BRANCH
377 Stevens Avenue
Deering Center
Portland, Maine 04103

CITY OF PORTLAND, MAINE
Addition + Renovation for
The Burbank Branch Library
ISSUED FOR BIDDING

SECOND FLOOR PLAN

SHEET # **A102**
PLAN NUMBER