
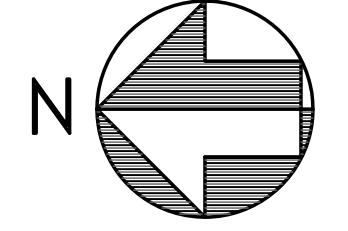


SYMBOLS AND ABBREVIATIONS


ABV	AUTOMATIC BALANCING VALVE	HVAC	HEATING, VENTILATING AND AIR CONDITIONING		WATER SUPPLY PIPING
AC	AIR CONDITIONING	LAT	LEAVING AIR TEMPERATURE		WATER RETURN PIPING
AD	ACCESS DOOR	LDB	LEAVING DRY BULB		COLD WATER PIPING
AFF	ABOVE FINISH FLOOR	LWB	LEAVING WET BULB		REFRIGERANT LIQUID PIPING
AH	AIR HANDLER	MBH	THOUSAND BTU PER HOUR		REFRIGERANT SUCTION PIPING
AP	ACCESS PANEL	MV	MANUAL VENT		EXISTING PIPING
APD	AIR PRESSURE DROP	NG	NATURAL GAS		PIPING TO BE REMOVED
ATC	AUTOMATIC TEMP. CONTROL	NTS	NOT TO SCALE		UNION
AV	AUTOMATIC VENT	OA	OUTDOOR AIR		HOSE CONNECTION
B	BOILER	OD	OUTSIDE DIMENSION		FLANGE
BD	BACKDRAFT DAMPER	OU	OUTDOOR UNIT		GLOBE VALVE
CD	CONDENSATE DRAIN	P	PUMP		CHECK VALVE
CFH	CUBIC FEET PER HOUR	PC	PLUMBING CONTRACTOR		BALANCING VALVE
CFM	CUBIC FEET PER MINUTE	PD	PUMP DISCHARGE		CONTROL VALVE
CP	CONDENSATE PUMP	PF	PADDLE FAN		PRESSURE REDUCING VALVE
CTE	CONNECT TO EXISTING	PRV	PRESSURE REDUCING VALVE		BALL VALVE
CUH	CABINET UNIT HEATER	R	RETURN		INVERTED ECCENTRIC REDUCER
CV	CONTROL VALVE	RIC	RETURN IN COVER		THERMOSTAT
D	DRAIN	RL	REFRIGERANT LIQUID		THERMOSTAT WITH GUARD
EAT	ENTERING AIR TEMPERATURE	RS	REFRIGERANT SUCTION		CONNECT TO EXISTING
EC	ELECTRICAL CONTRACTOR	RR	RETURN REGISTER		MANUAL DAMPER
EDB	ENTERING DRY BULB	RV	RELIEF VALVE		SUPPLY AIR DUCT
EF	EXHAUST FAN	S	SUPPLY		RETURN / RELIEF AIR DUCT
ESP	EXTERNAL STATIC PRESSURE	SA	SUPPLY AIR		
EWB	ENTERING WET BULB	SP	STATIC PRESSURE		
EWT	ENTERING WATER TEMPERATURE	SV	SAFETY VALVE		
FCV	FLOW CONTROL VALVE	T	THERMOMETER		
FP	FINNED PIPE	TC	TEMPERATURE CONTROL		
FS	FLOW SENSOR	TSP	TOTAL STATIC PRESSURE		
FV	FACE VELOCITY	T'STAT	THERMOSTAT		
GC	GENERAL CONTRACTOR	UC	UNDERCUT		
GPH	GALLONS PER HOUR	WPD	WATER PRESSURE DROP		
GPM	GALLONS PER MINUTE	WTD	WATER TEMPERATURE DROP		
HC	HEATING CONTRACTOR	WTR	WATER TEMPERATURE RISE		
HWR	HOT WATER RETURN				
HWS	HOT WATER SUPPLY				
H&V	HEATING & VENTILATING				

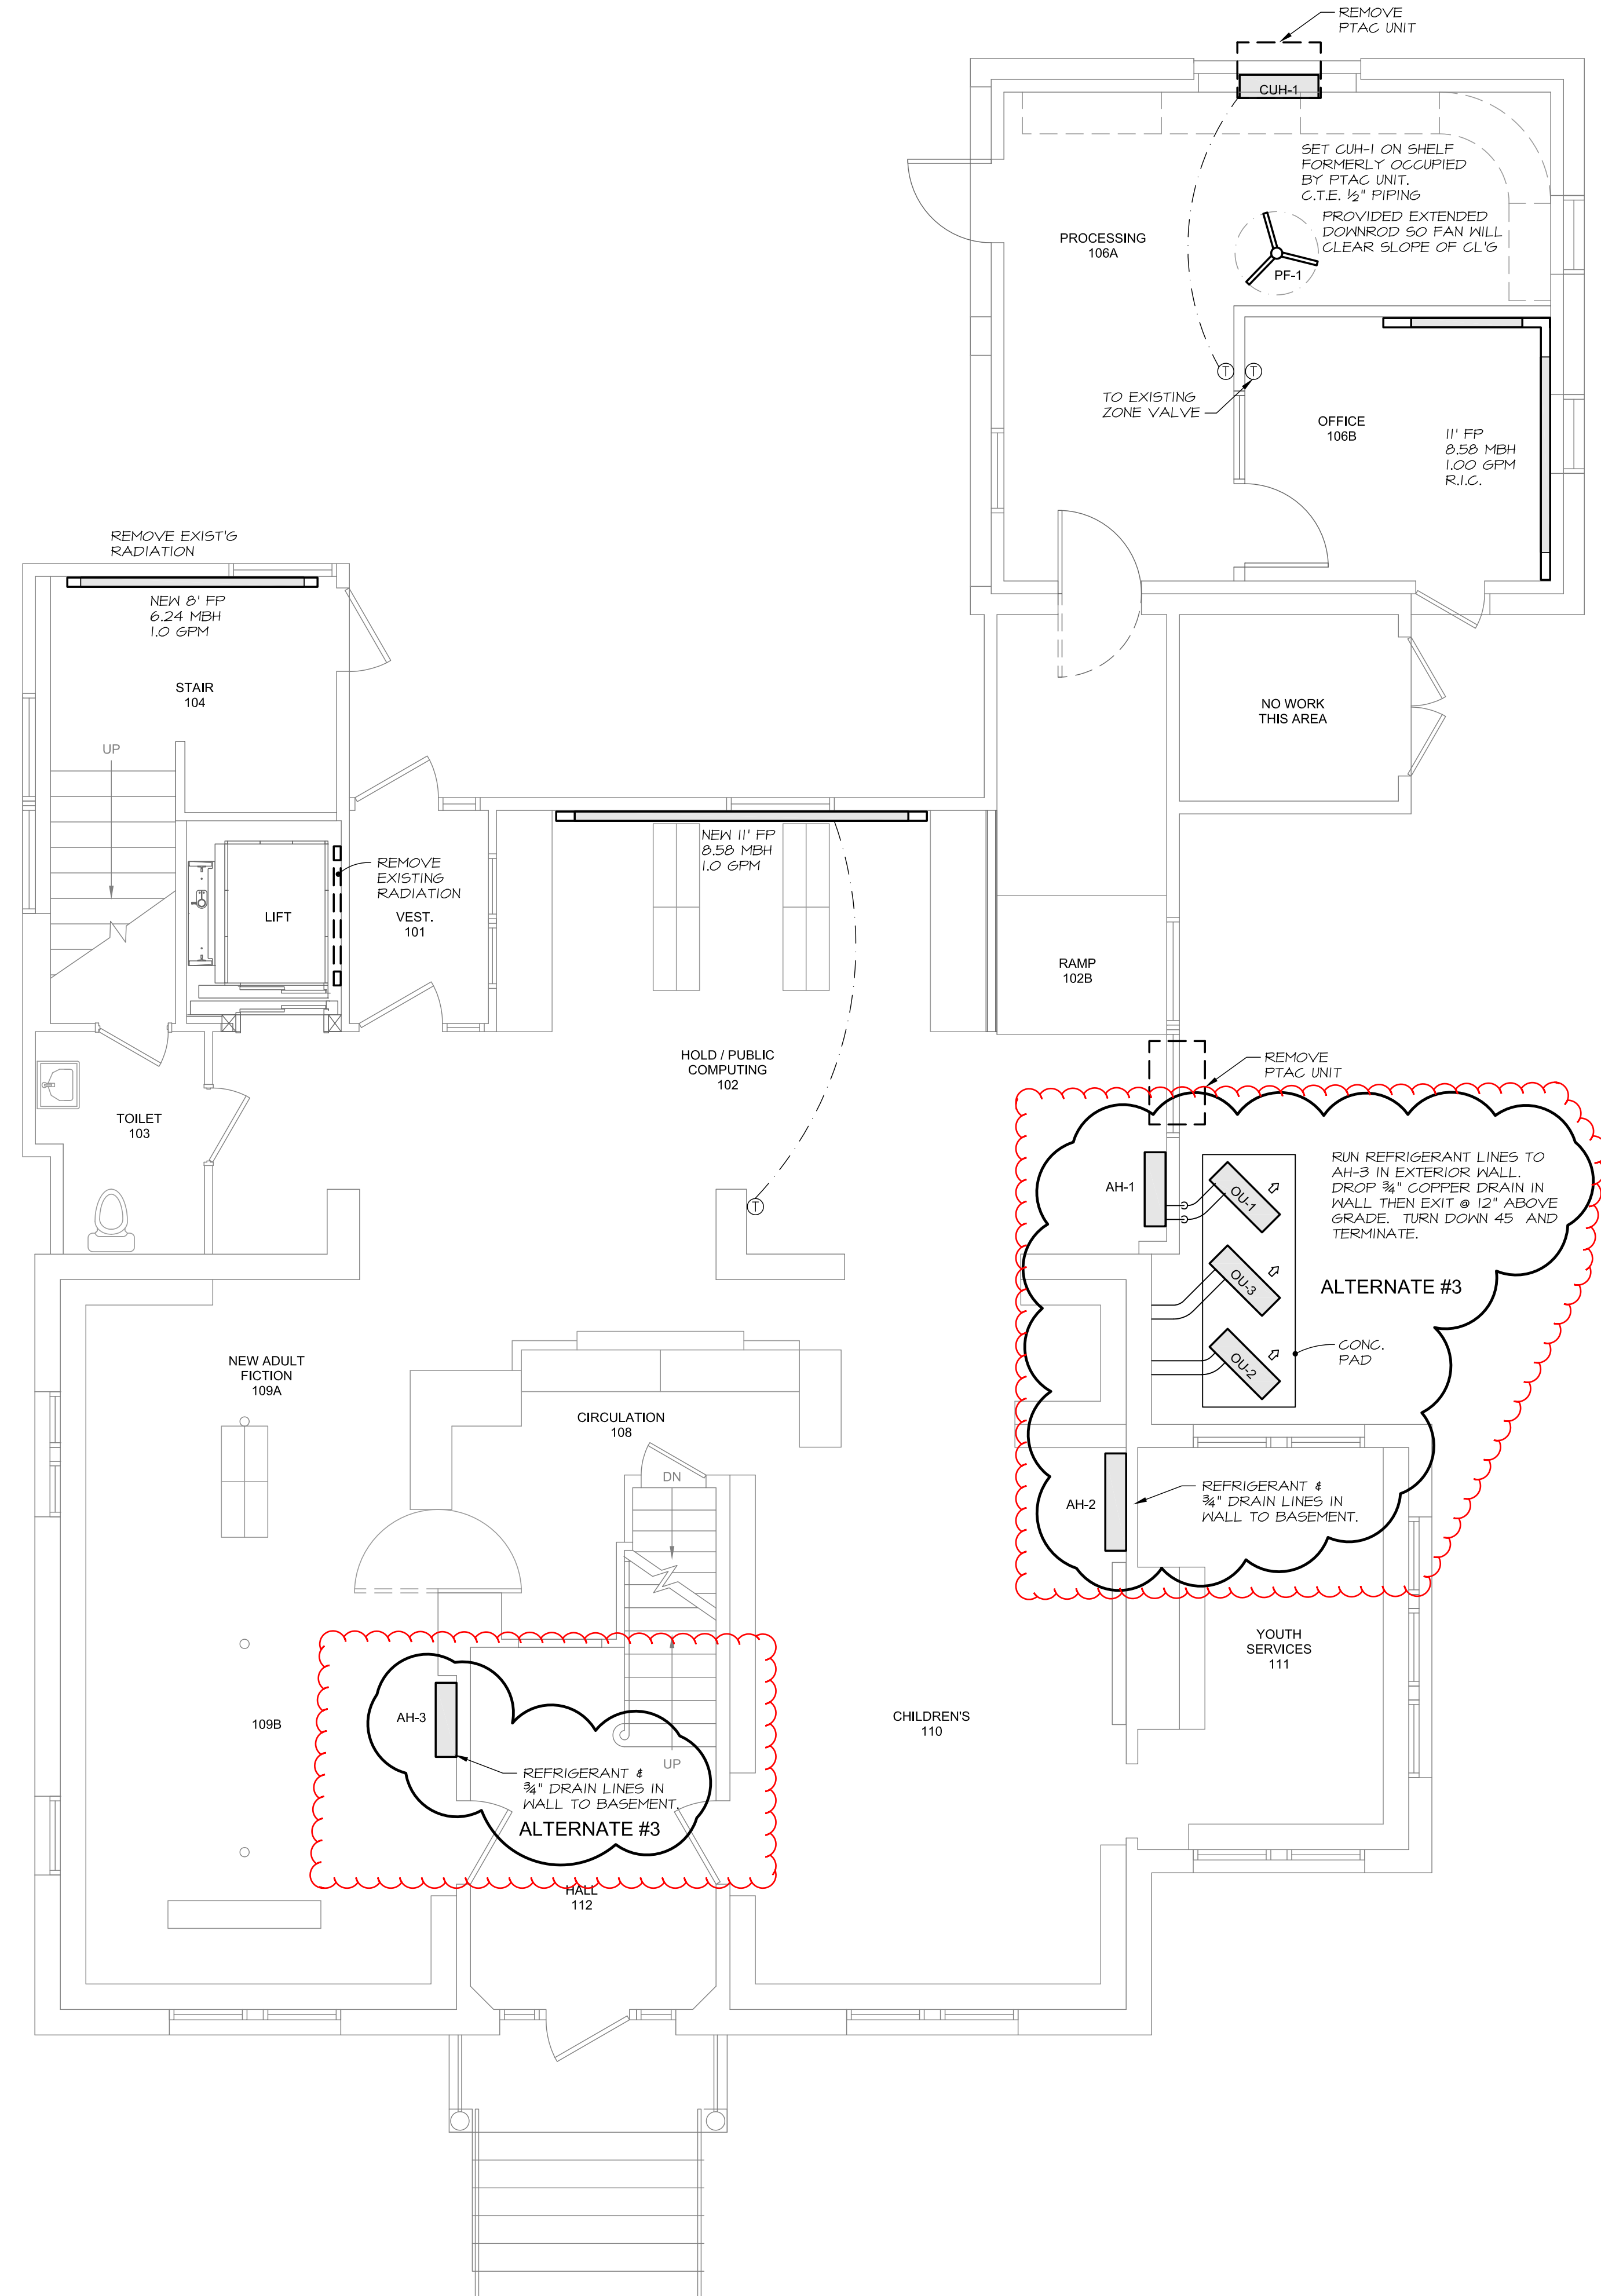

LDD PROJECT NAME: N/A
 DRAWING NAME: N/A
 FIELD BOOK USED: N/A

Soori Simons Architects
 75 York Street
 Portland, Maine 04101
 207.772.4656
 soorissimonsarchitect.com

RESIGNED BY: [Signature]
 DRAWN BY: [Signature]
 CHECKED BY: [Signature]
 SCALE: 1/4" = 1'-0"
 DATE: OCT. 16, 2015

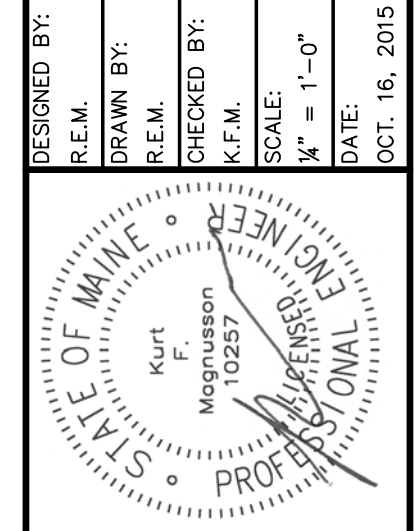

PORTLAND PUBLIC LIBRARY
 BURBANK BRANCH
 377 Stevens Avenue
 Deering Center
 Portland, Maine 04103

CITY OF PORTLAND, MAINE
 Addition + Renovation for
 The Burbank Branch Library
 Issued for bidding

BASEMENT MECHANICAL PLAN
 SHEET # M2
 PLAN NUMBER



MECHANICAL SYSTEMS ENGINEERS
 ROYAL RIVER CENTER, UNIT 108
 10 FOREST FALLS DRIVE, YARMOUTH, MAINE 04096
 (207) 846-1441
 FACEBOOK: MECHANICAL SYSTEMS ENGINEERS
 © COPYRIGHT 2015



October 26, 2015 - 9:08 am
 \\MEPFS1\Projects\1428 Portland Library Burbank\Drawings\1428_M1-M2 (10-23-2015).dwg