



DOMESTIC WATER PIPING SHALL BE TYPE L COPPER OR CPVC.
 SANITARY AND VENT PIPING SHALL BE SERVICE WEIGHT CAST
 IRON OR SCHEDULE 40 PVC (VTR SHALL BE CAST IRON (ONLY))


NOTE - HORIZONTAL VENT PIPING SHALL BE LIMITED TO ABOVE
 THE THIRD FLOOR

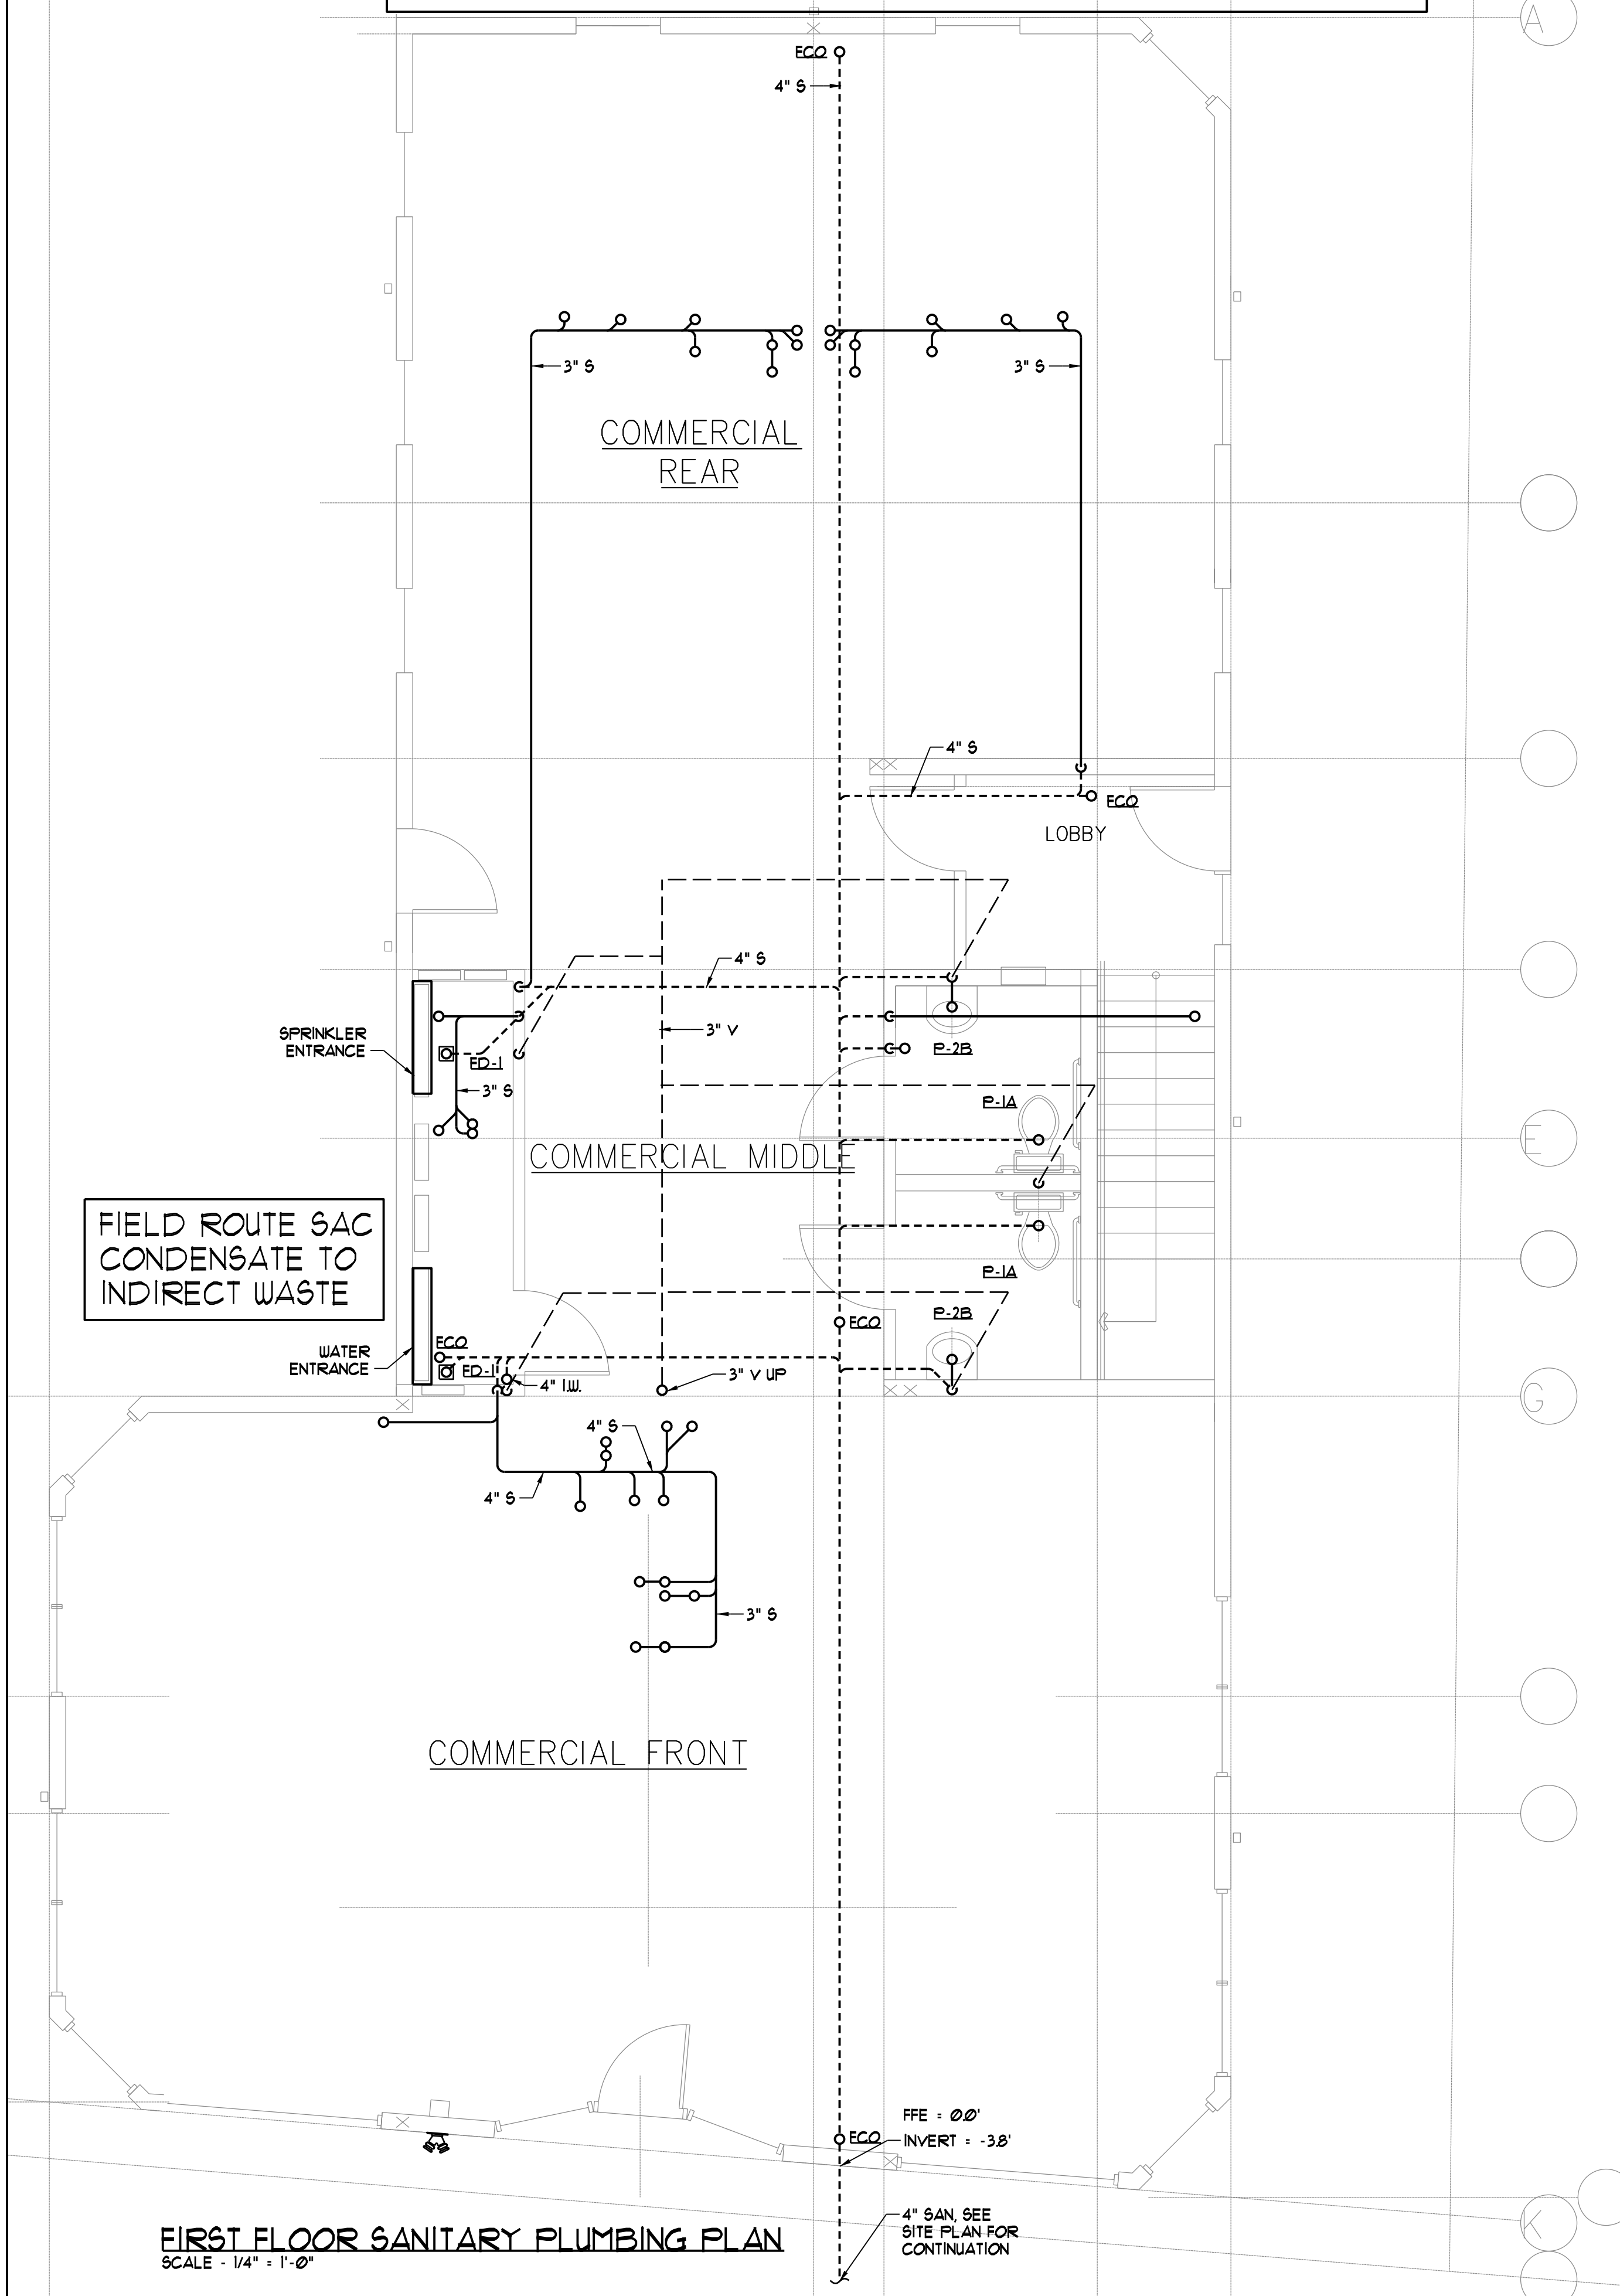

FIRST FLOOR SANITARY PLUMBING PLAN
 SCALE - 1/4" = 1'-0"

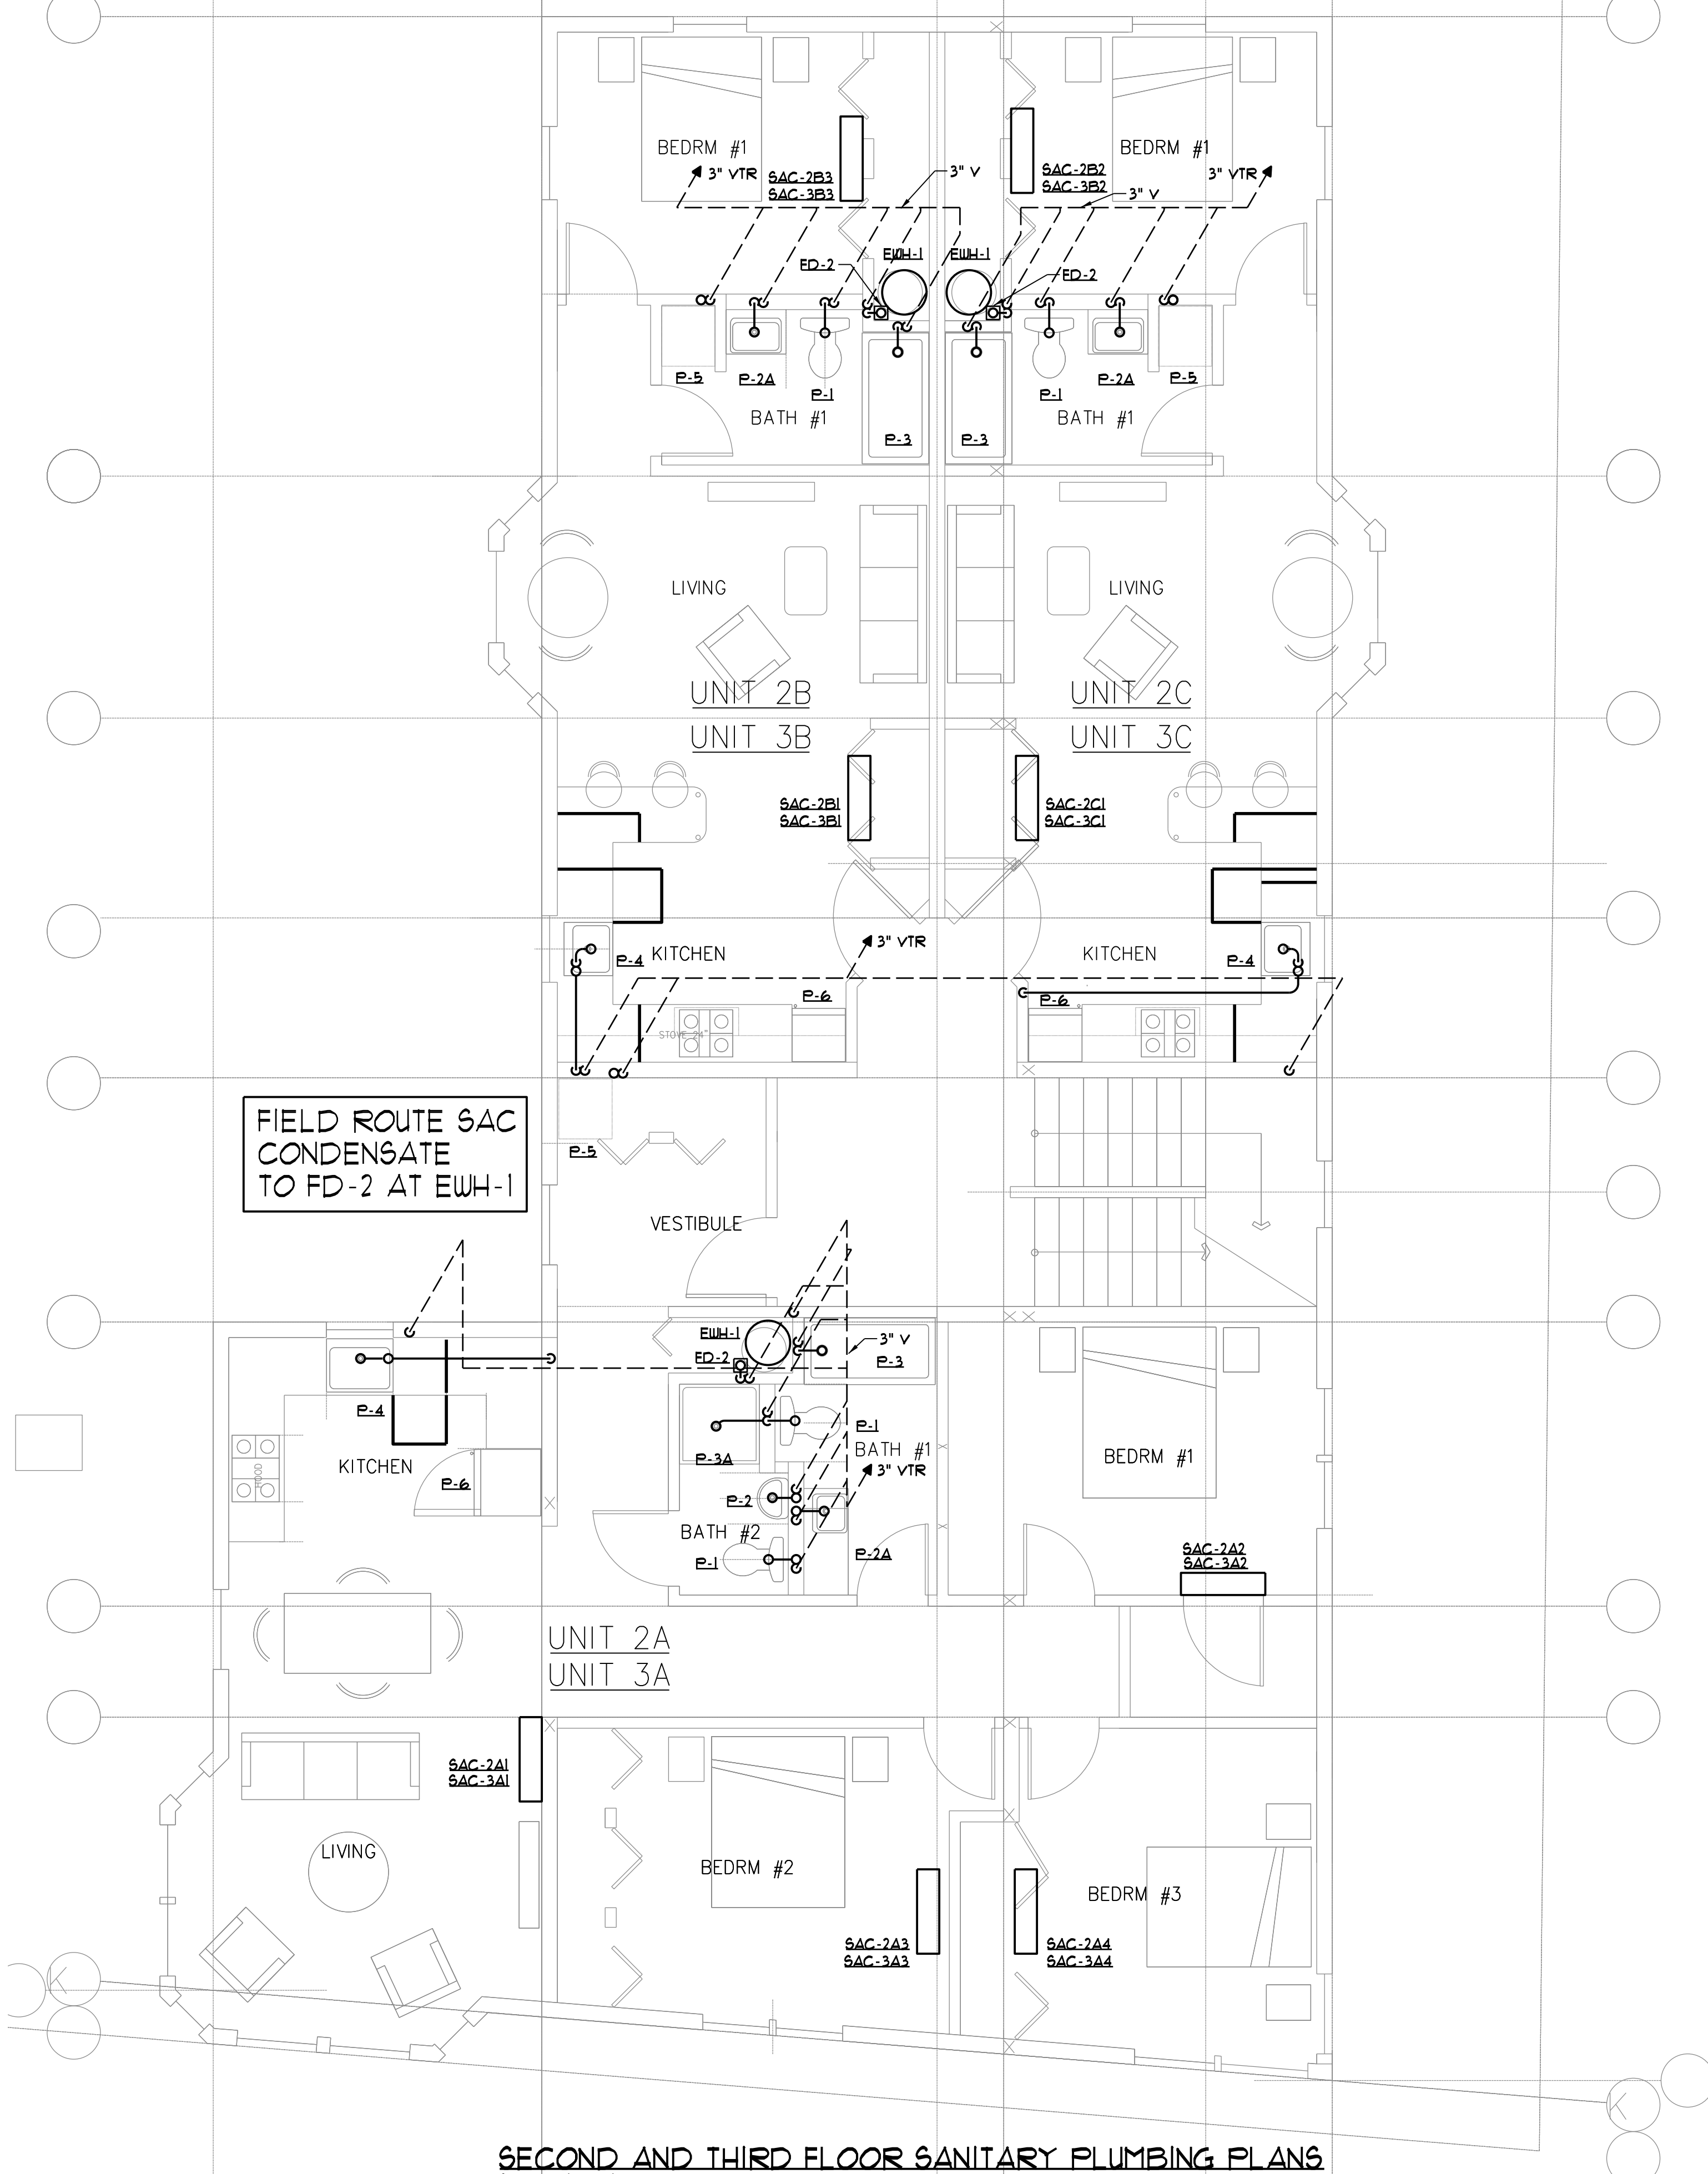

SECOND AND THIRD FLOOR SANITARY PLUMBING PLANS
 SCALE - 1/4" = 1'-0"

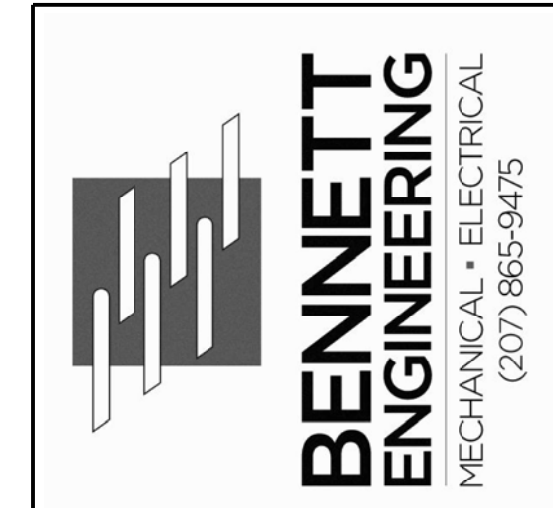

PROGRESS PRINT
 NOT FOR CONSTRUCTION

502 DEERING CENTER

SANITARY PLUMBING PLAN

Date Drawn -	4-19-17
Drawn By -	JMY
Revised -	
Project #	-
Scale -	1/4" = 1'-0"
Sheet Number -	M2.1