



FIRST FLOOR DOMESTIC PLUMBING PLAN
SCALE - 1/4" = 1'-0"

NOTE - PIPING THIS PLAN SHOWN FOR SECOND FLOOR PIPING ARRANGEMENT (OVERHEAD). THIRD FLOOR PIPING SHALL BE RUN BELOW THE THIRD FLOOR. NO PIPING SHALL BE RUN IN THE ROOF STRUCTURE

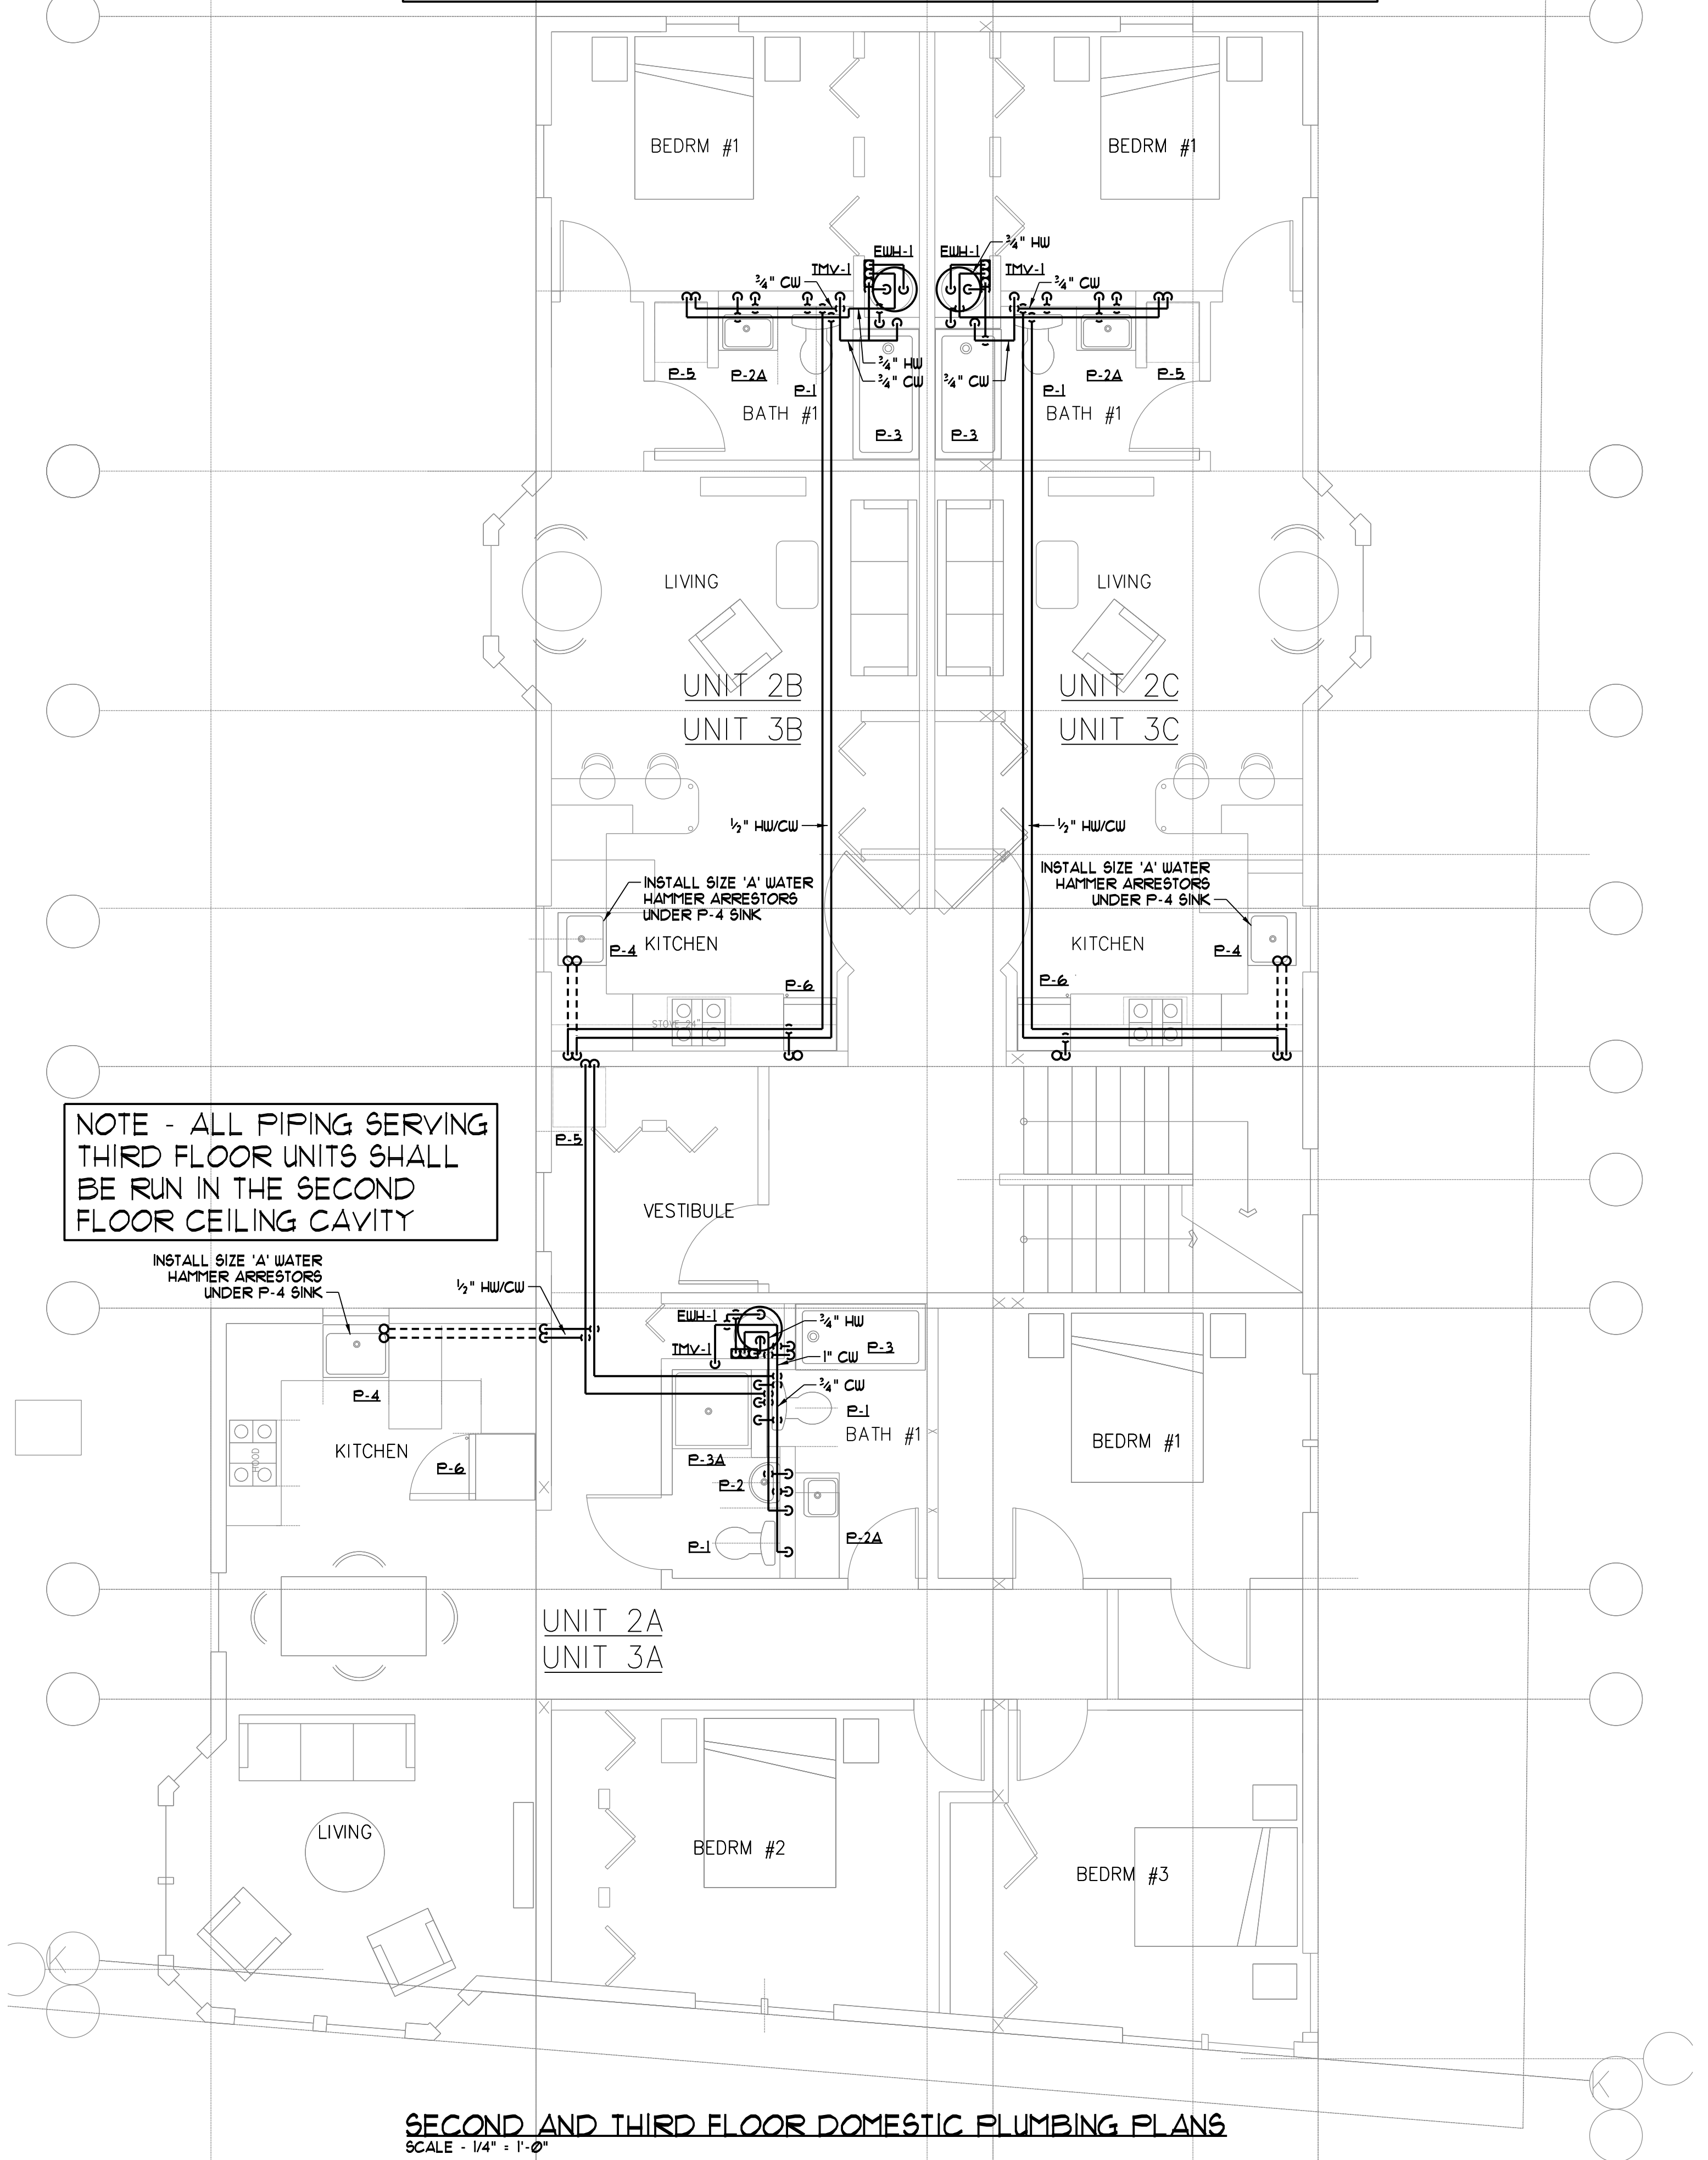

NOTE - ALL PIPING SERVING THIRD FLOOR UNITS SHALL BE RUN IN THE SECOND FLOOR CEILING CAVITY

SECOND AND THIRD FLOOR DOMESTIC PLUMBING PLANS
SCALE - 1/4" = 1'-0"

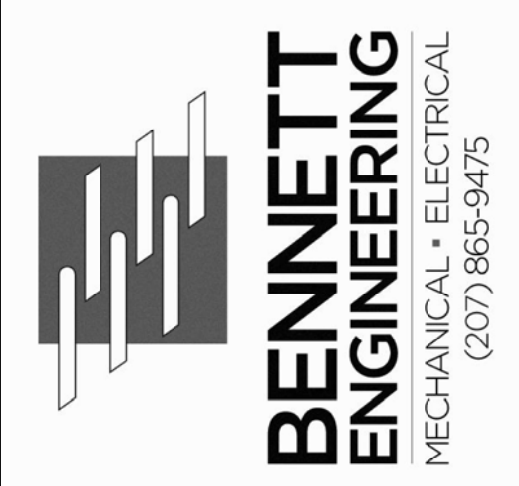

PROGRESS PRINT
NOT FOR CONSTRUCTION

502 DEERING CENTER
DOMESTIC PLUMBING PLAN

Date Drawn -	4-19-17
Drawn By -	JMV
Revised -	
Project #	-
Scale -	1/4" = 1'-0"
Sheet Number -	M2.2