



DOMESTIC WATER PIPING SHALL BE TYPE L COPPER OR CPVC.  
 SANITARY AND VENT PIPING SHALL BE SERVICE WEIGHT CAST  
 IRON OR SCHEDULE 40 PVC (VTR SHALL BE CAST IRON (ONLY))

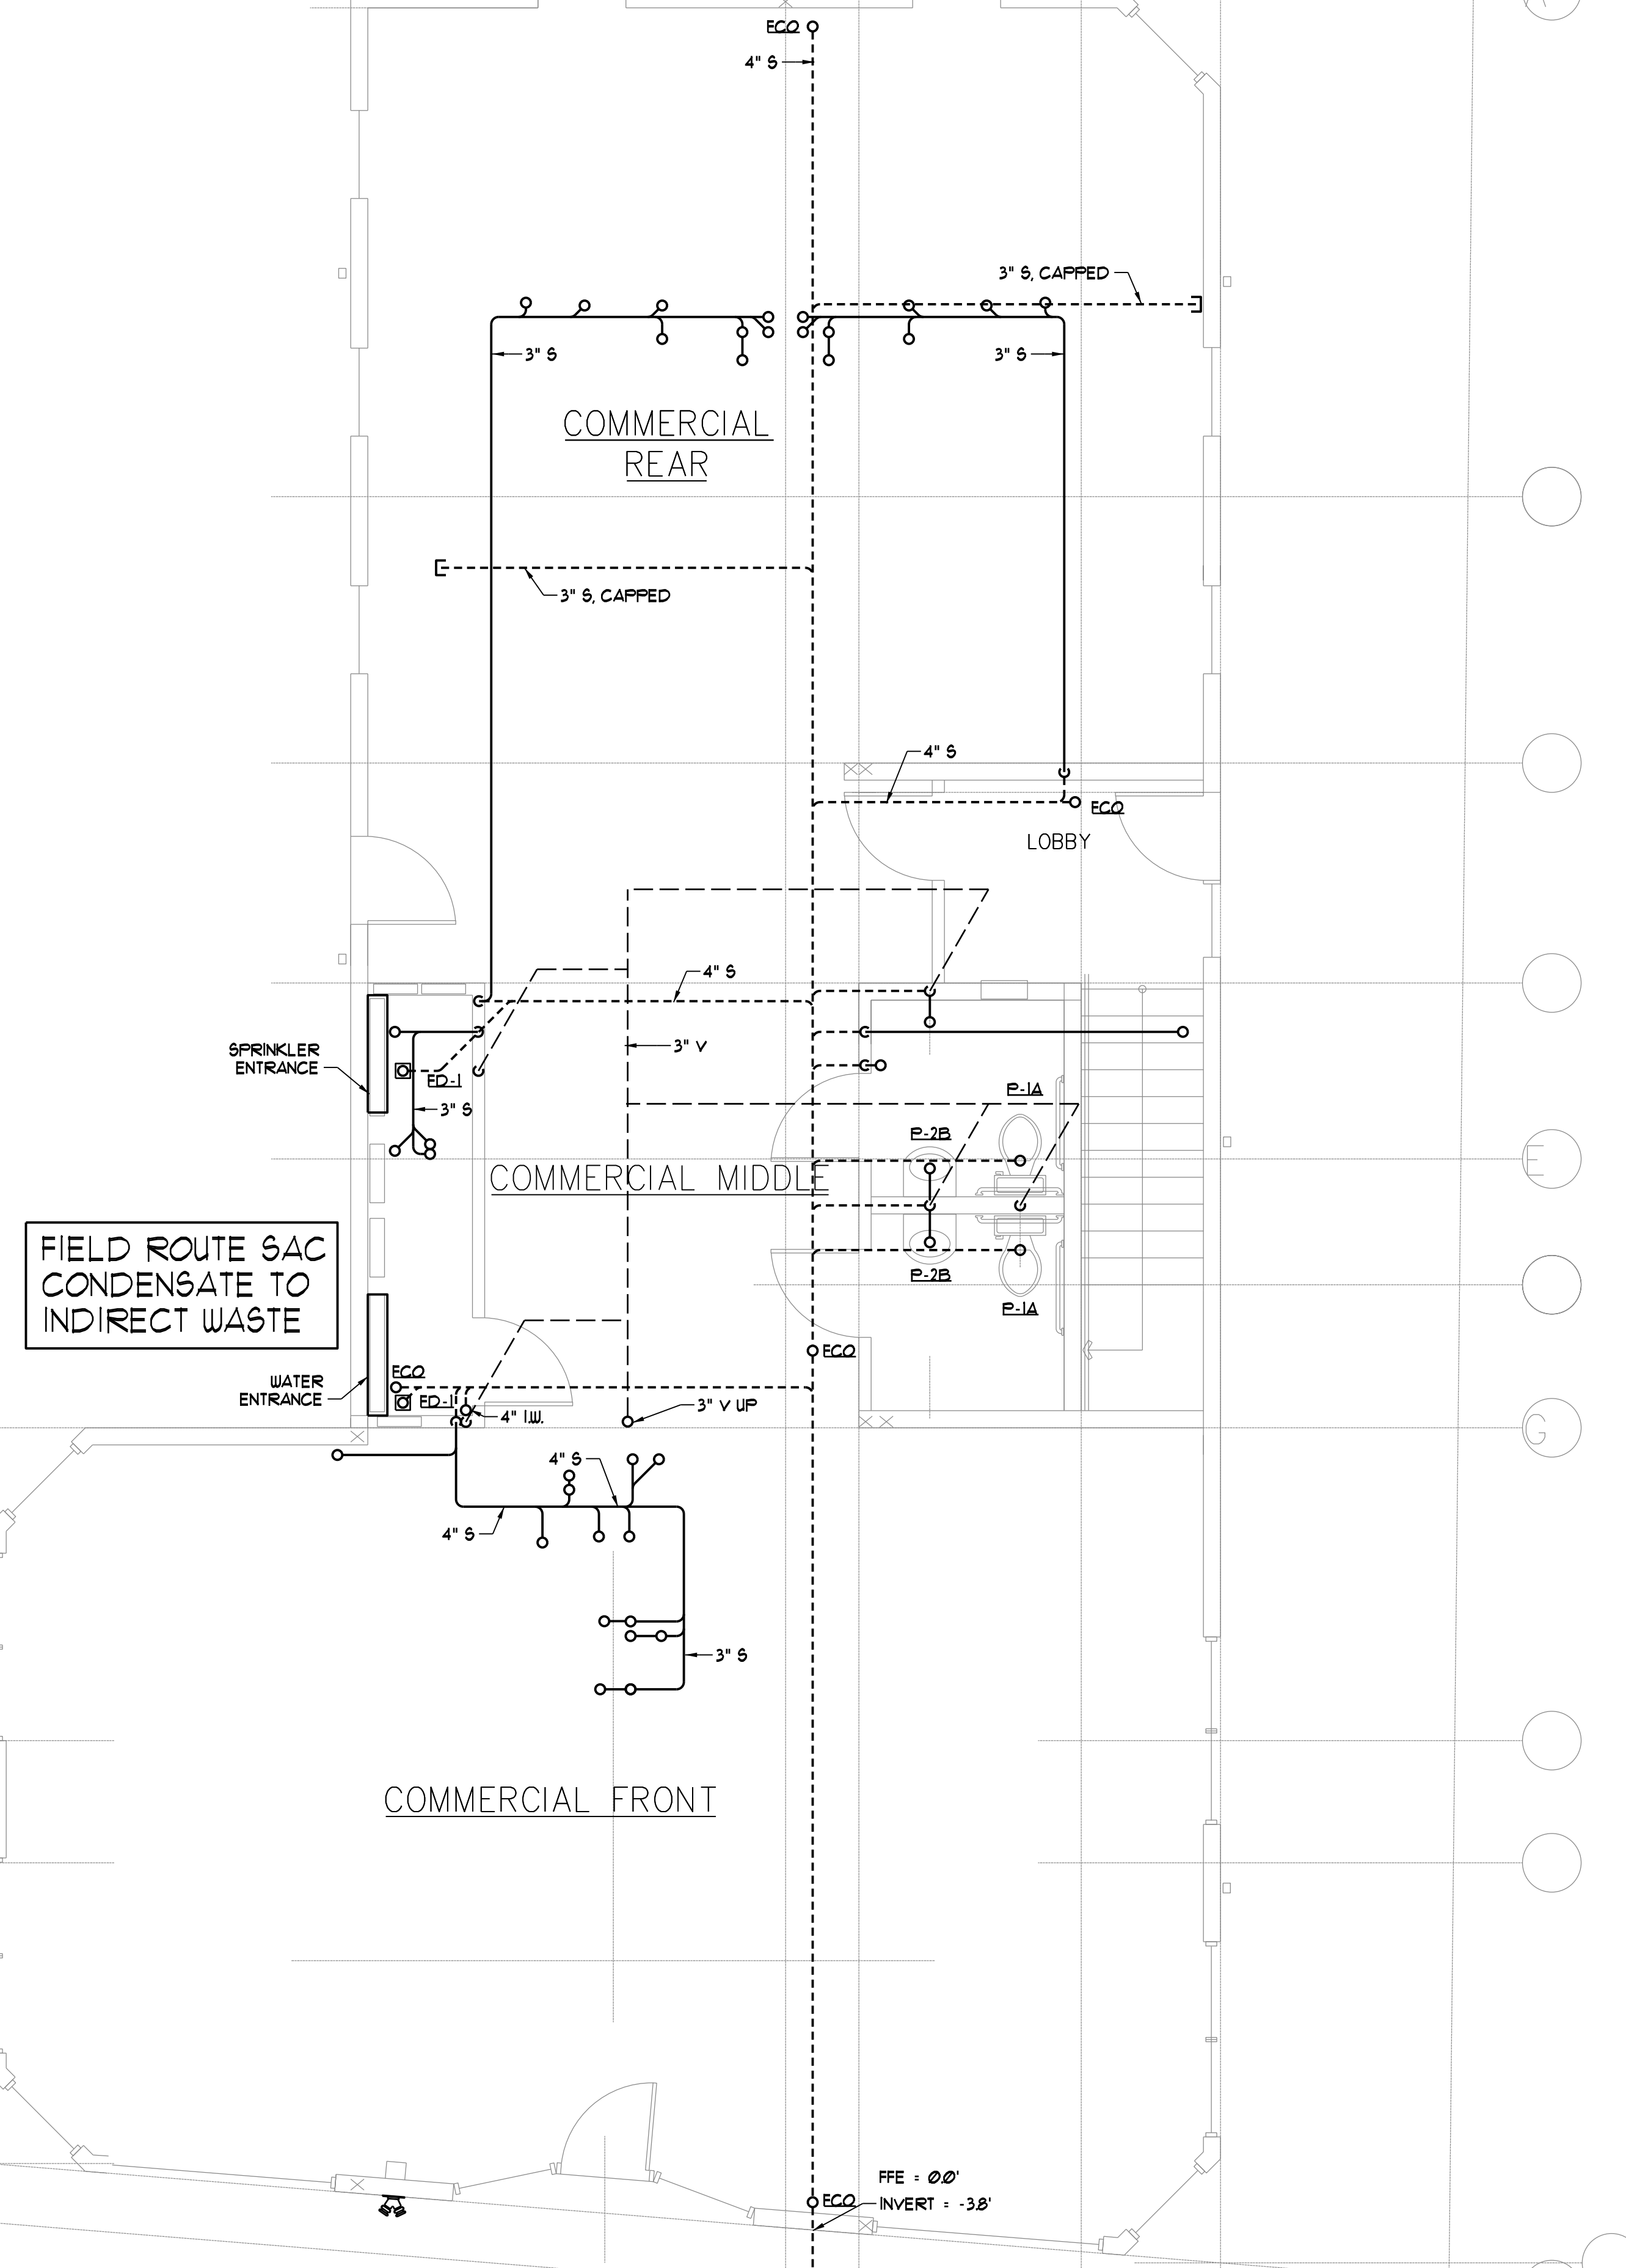



FIRST FLOOR SANITARY PLUMBING PLAN  
 SCALE - 1/4" = 1'-0"

4" SAN SEE  
 SITE PLAN FOR  
 CONTINUATION

NOTE - HORIZONTAL VENT PIPING SHALL BE LIMITED TO ABOVE  
 THE THIRD FLOOR

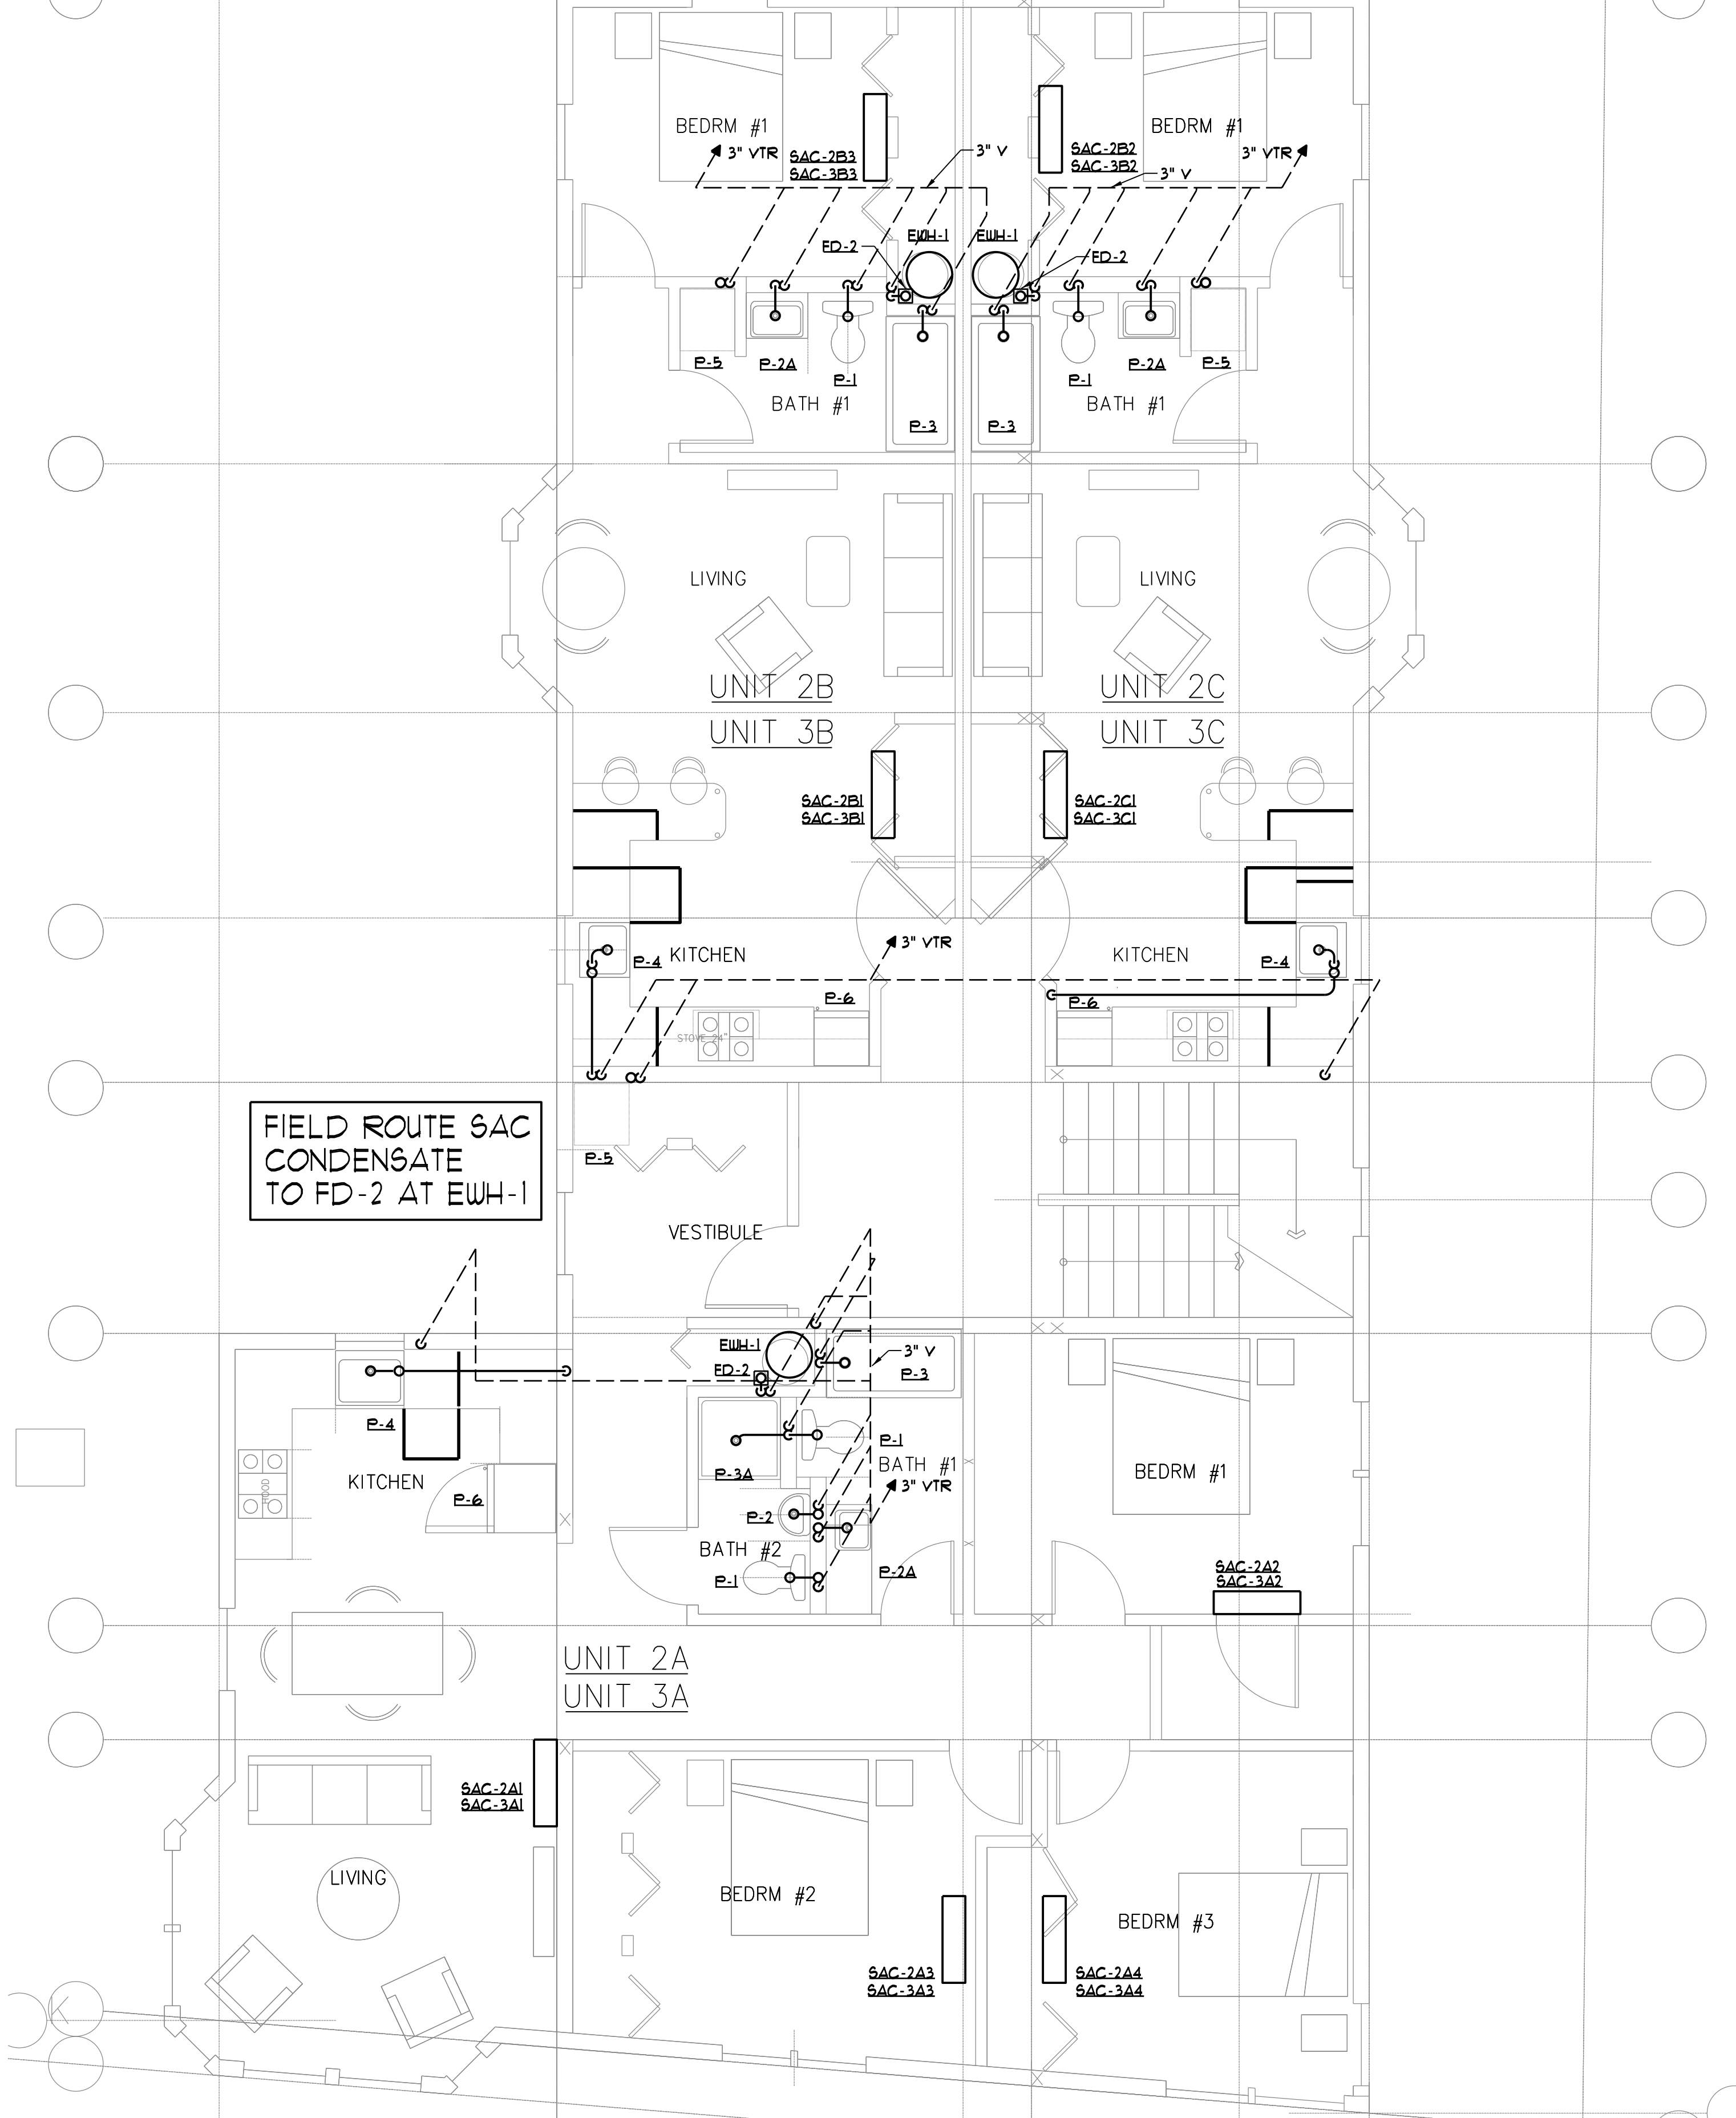

SECOND AND THIRD FLOOR SANITARY PLUMBING PLANS  
 SCALE - 1/4" = 1'-0"

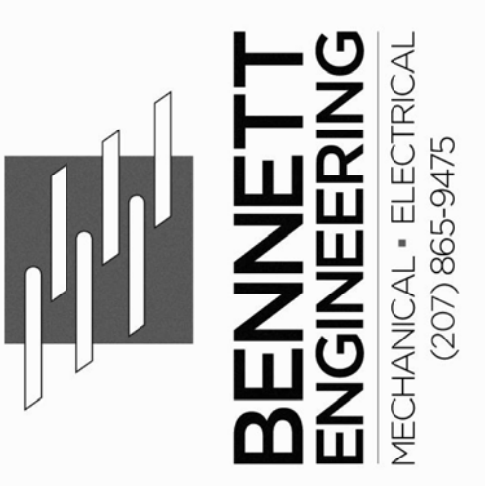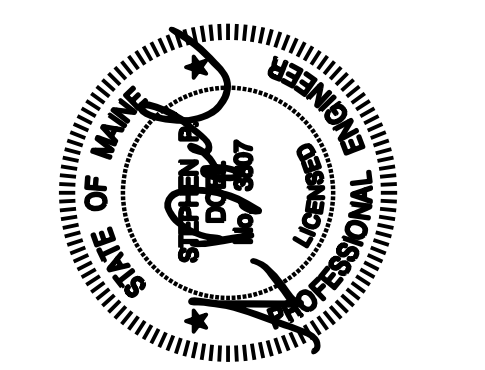

502 DEERING CENTER

SANITARY PLUMBING PLAN

Date Drawn -	5-12-17
Drawn By -	JMY
Revised -	
Project #	-
Scale -	1/4" = 1'-0"
Sheet Number -	M2.1