

LEGEND

EGRESS PATH - - - - -

1 HOUR FIRE RESISTANCE RATED WALL - - - - -

1 HOUR FIRE RESISTANCE RATED STAIR ENCLOSURE [Hatched Box]


1ST FLOOR OCCUPANCY BUSINESS (GROUP B)

OCCUPANT LOAD = 21

ILLUMINATION, EXIT SIGNS & FIRE ALARMS SEE E1.1 ELECT LIGHTING PLAN

INTERIOR WALL AND CLNG FINISHES SHALL BE CLASS A OR B. INTERIOR FLOOR FINISHES FOR BUSINESS OCCUPANCY SHALL BE CLASS I OR CLASS II.

SEE ALSO ACCOMPANYING COMPLETE CODE REVIEW

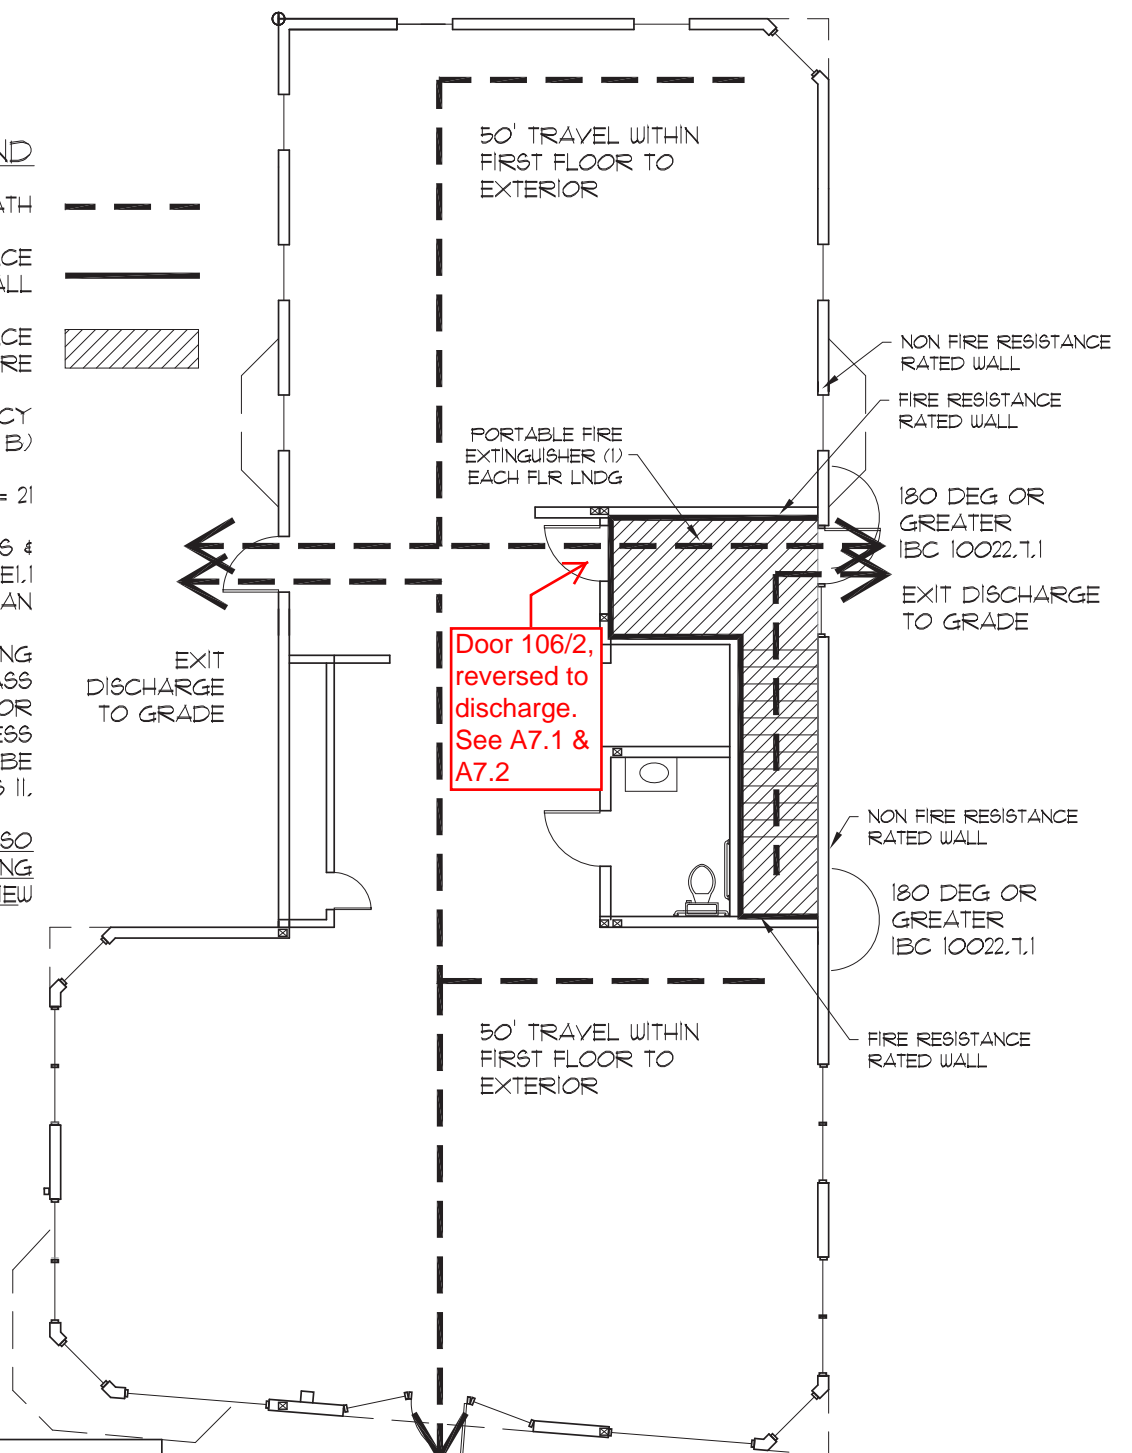

502 DEE NEW

502 STEVENS

FOR PERMIT
NOT FOR
CONSTRUCTION

TITLE: LIFE SAFETY PLANS

REV	DATE	ISSUE
D		
C		
B		
A	05/15/2017	PERMIT

DRAWING NO:
AO

2	1ST FLR LIFE SAFETY PLAN
SCALE = NONE	