


- △
- △
- △
- △
- △

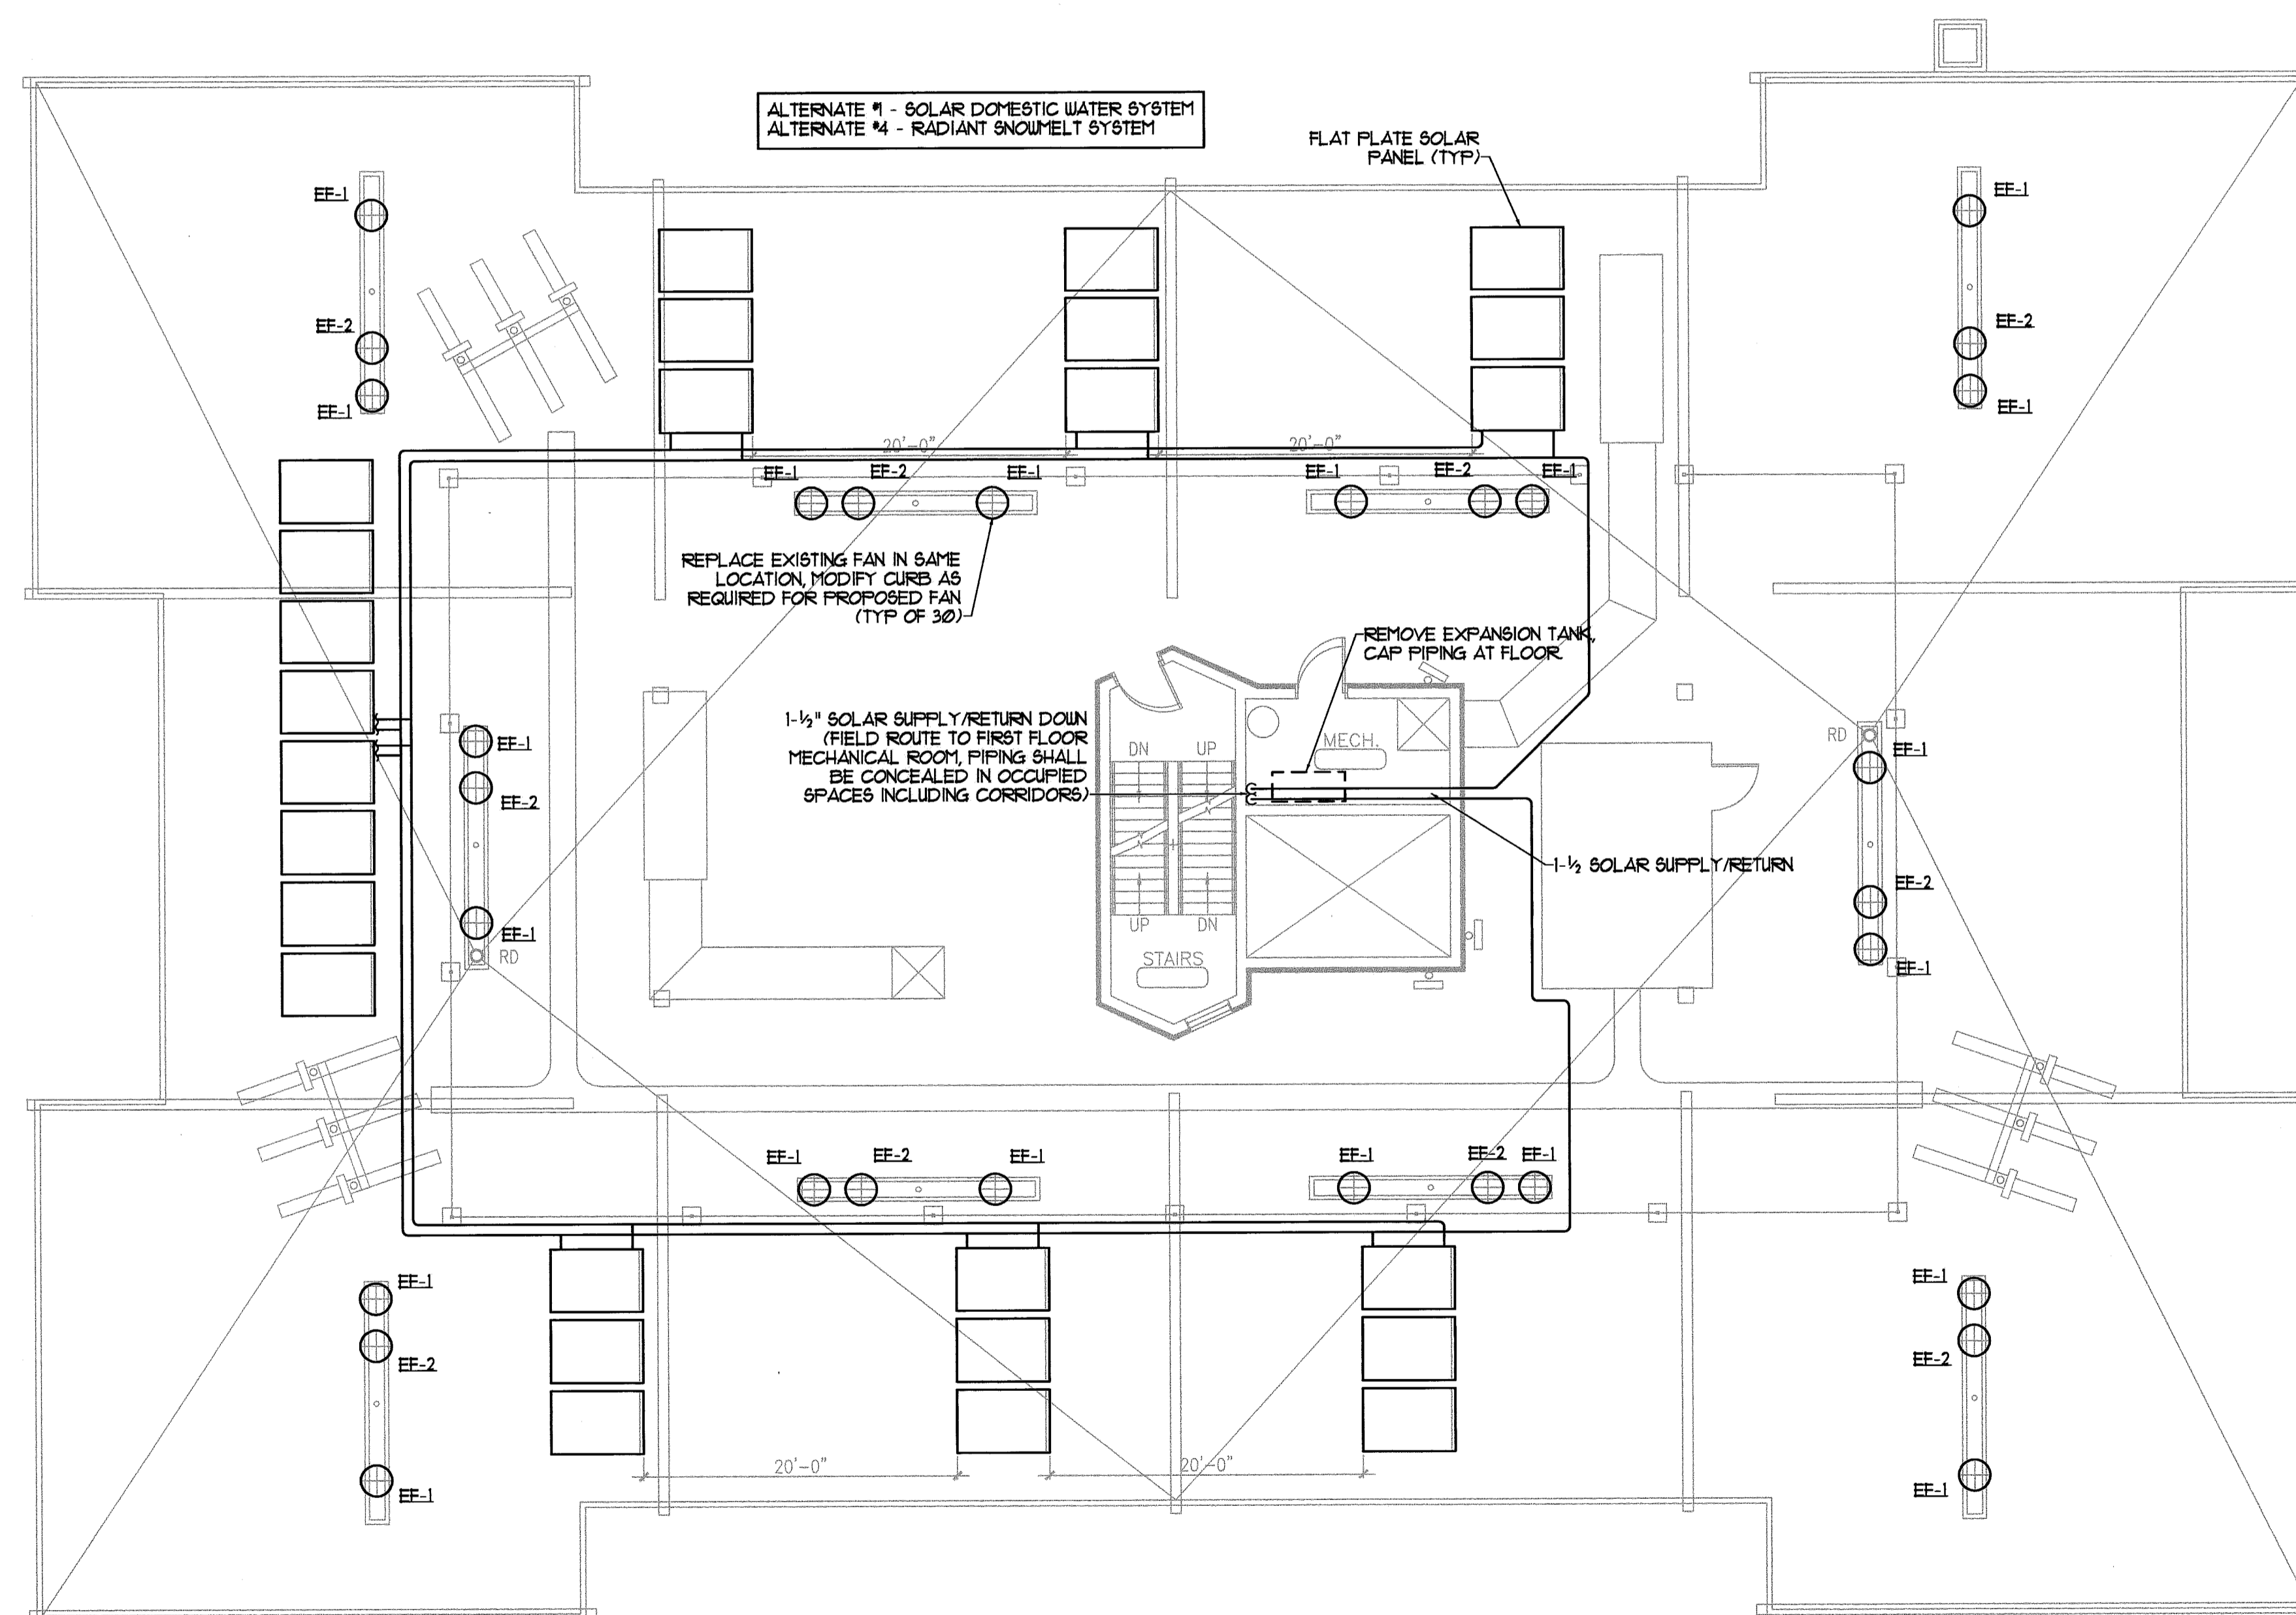

**ROOF MECHANICAL PLAN**  
SCALE - 1/8" = 1'-0"