

Owner:
Diocesan Bureau of Housing
PO BOX 11559
Portland, Maine 04104-7559
TEL. 207-773-6471

Client:

Deering Pavilion

Portland, Maine

Project No: 08441

Drawing Title:

ROOF ELECTRICAL PLAN


Scale: As Noted
Date: May 20, 2010

Revisions:

- ▲
- ▲
- ▲
- ▲
- ▲

Drawing Number:

E1.02

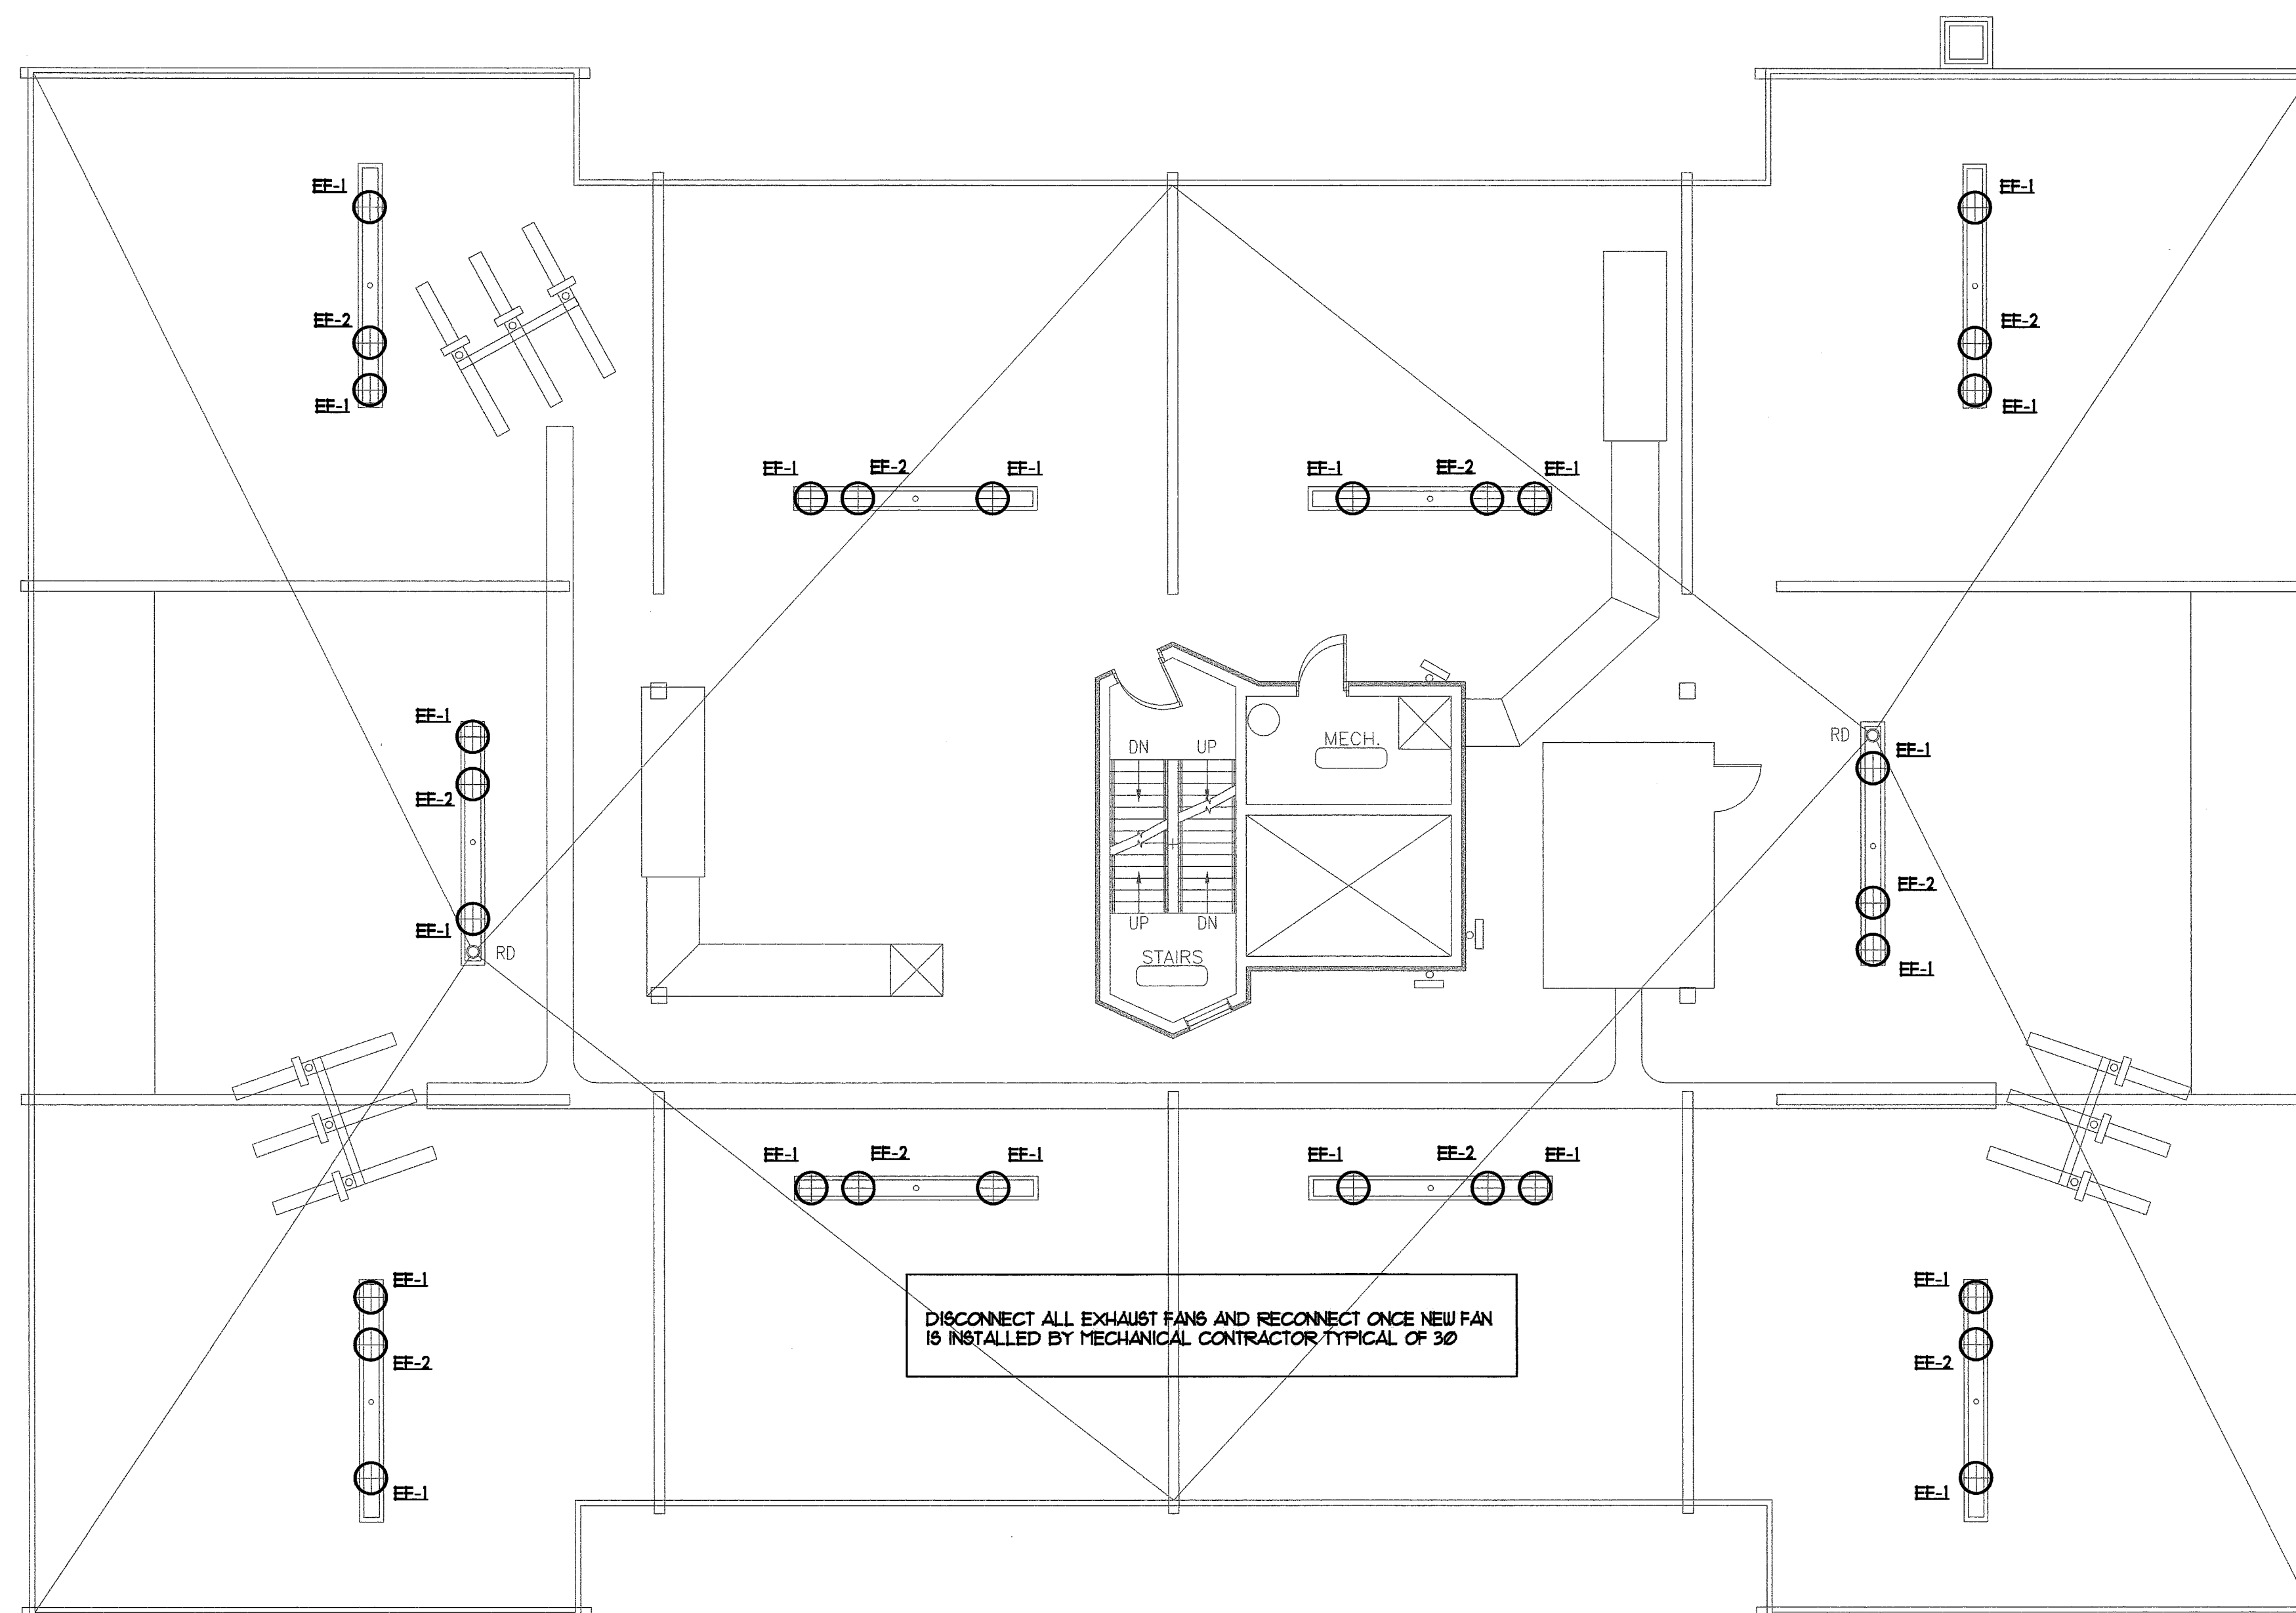

ROOF ELECTRICAL PLAN
SCALE - 1/8" = 1'-0"