


GENERAL NOTES:
 1. PLASTER CEILING (ABOVE DROP CEILING) AT ALL ROOMS AND CORRIDORS UNO.
 2. REMOVE ALL EXISTING LIGHT FIXTURES AND INTERCOM DEVICES IN NUNCCELLS, TYP.
 3. REMOVE ALL EXISTING RADATORS, UNO.

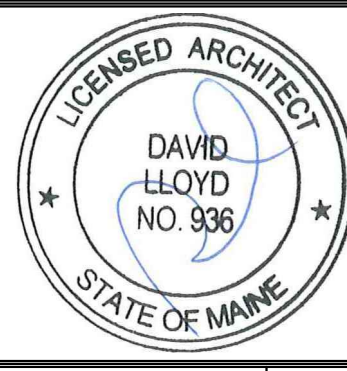

Prepared For:
MOTHERHOUSE LLC


Consultant:
ARCHETYPE architects
 48 Union Wharf Portland, Maine 04101
 (207) 772-0022 ARCHETYPE@ARCHETYPE.COM

Project:
MOTHERHOUSE SENIOR HOUSING
 605 STEVENS AVENUE
 PORTLAND, MAINE 04103

Revisions:

Date: 15 FEB 2016
 Scale: 3/32" = 1'-0"
EXISTING THIRD FLOOR PLAN & DEMO

A0.03

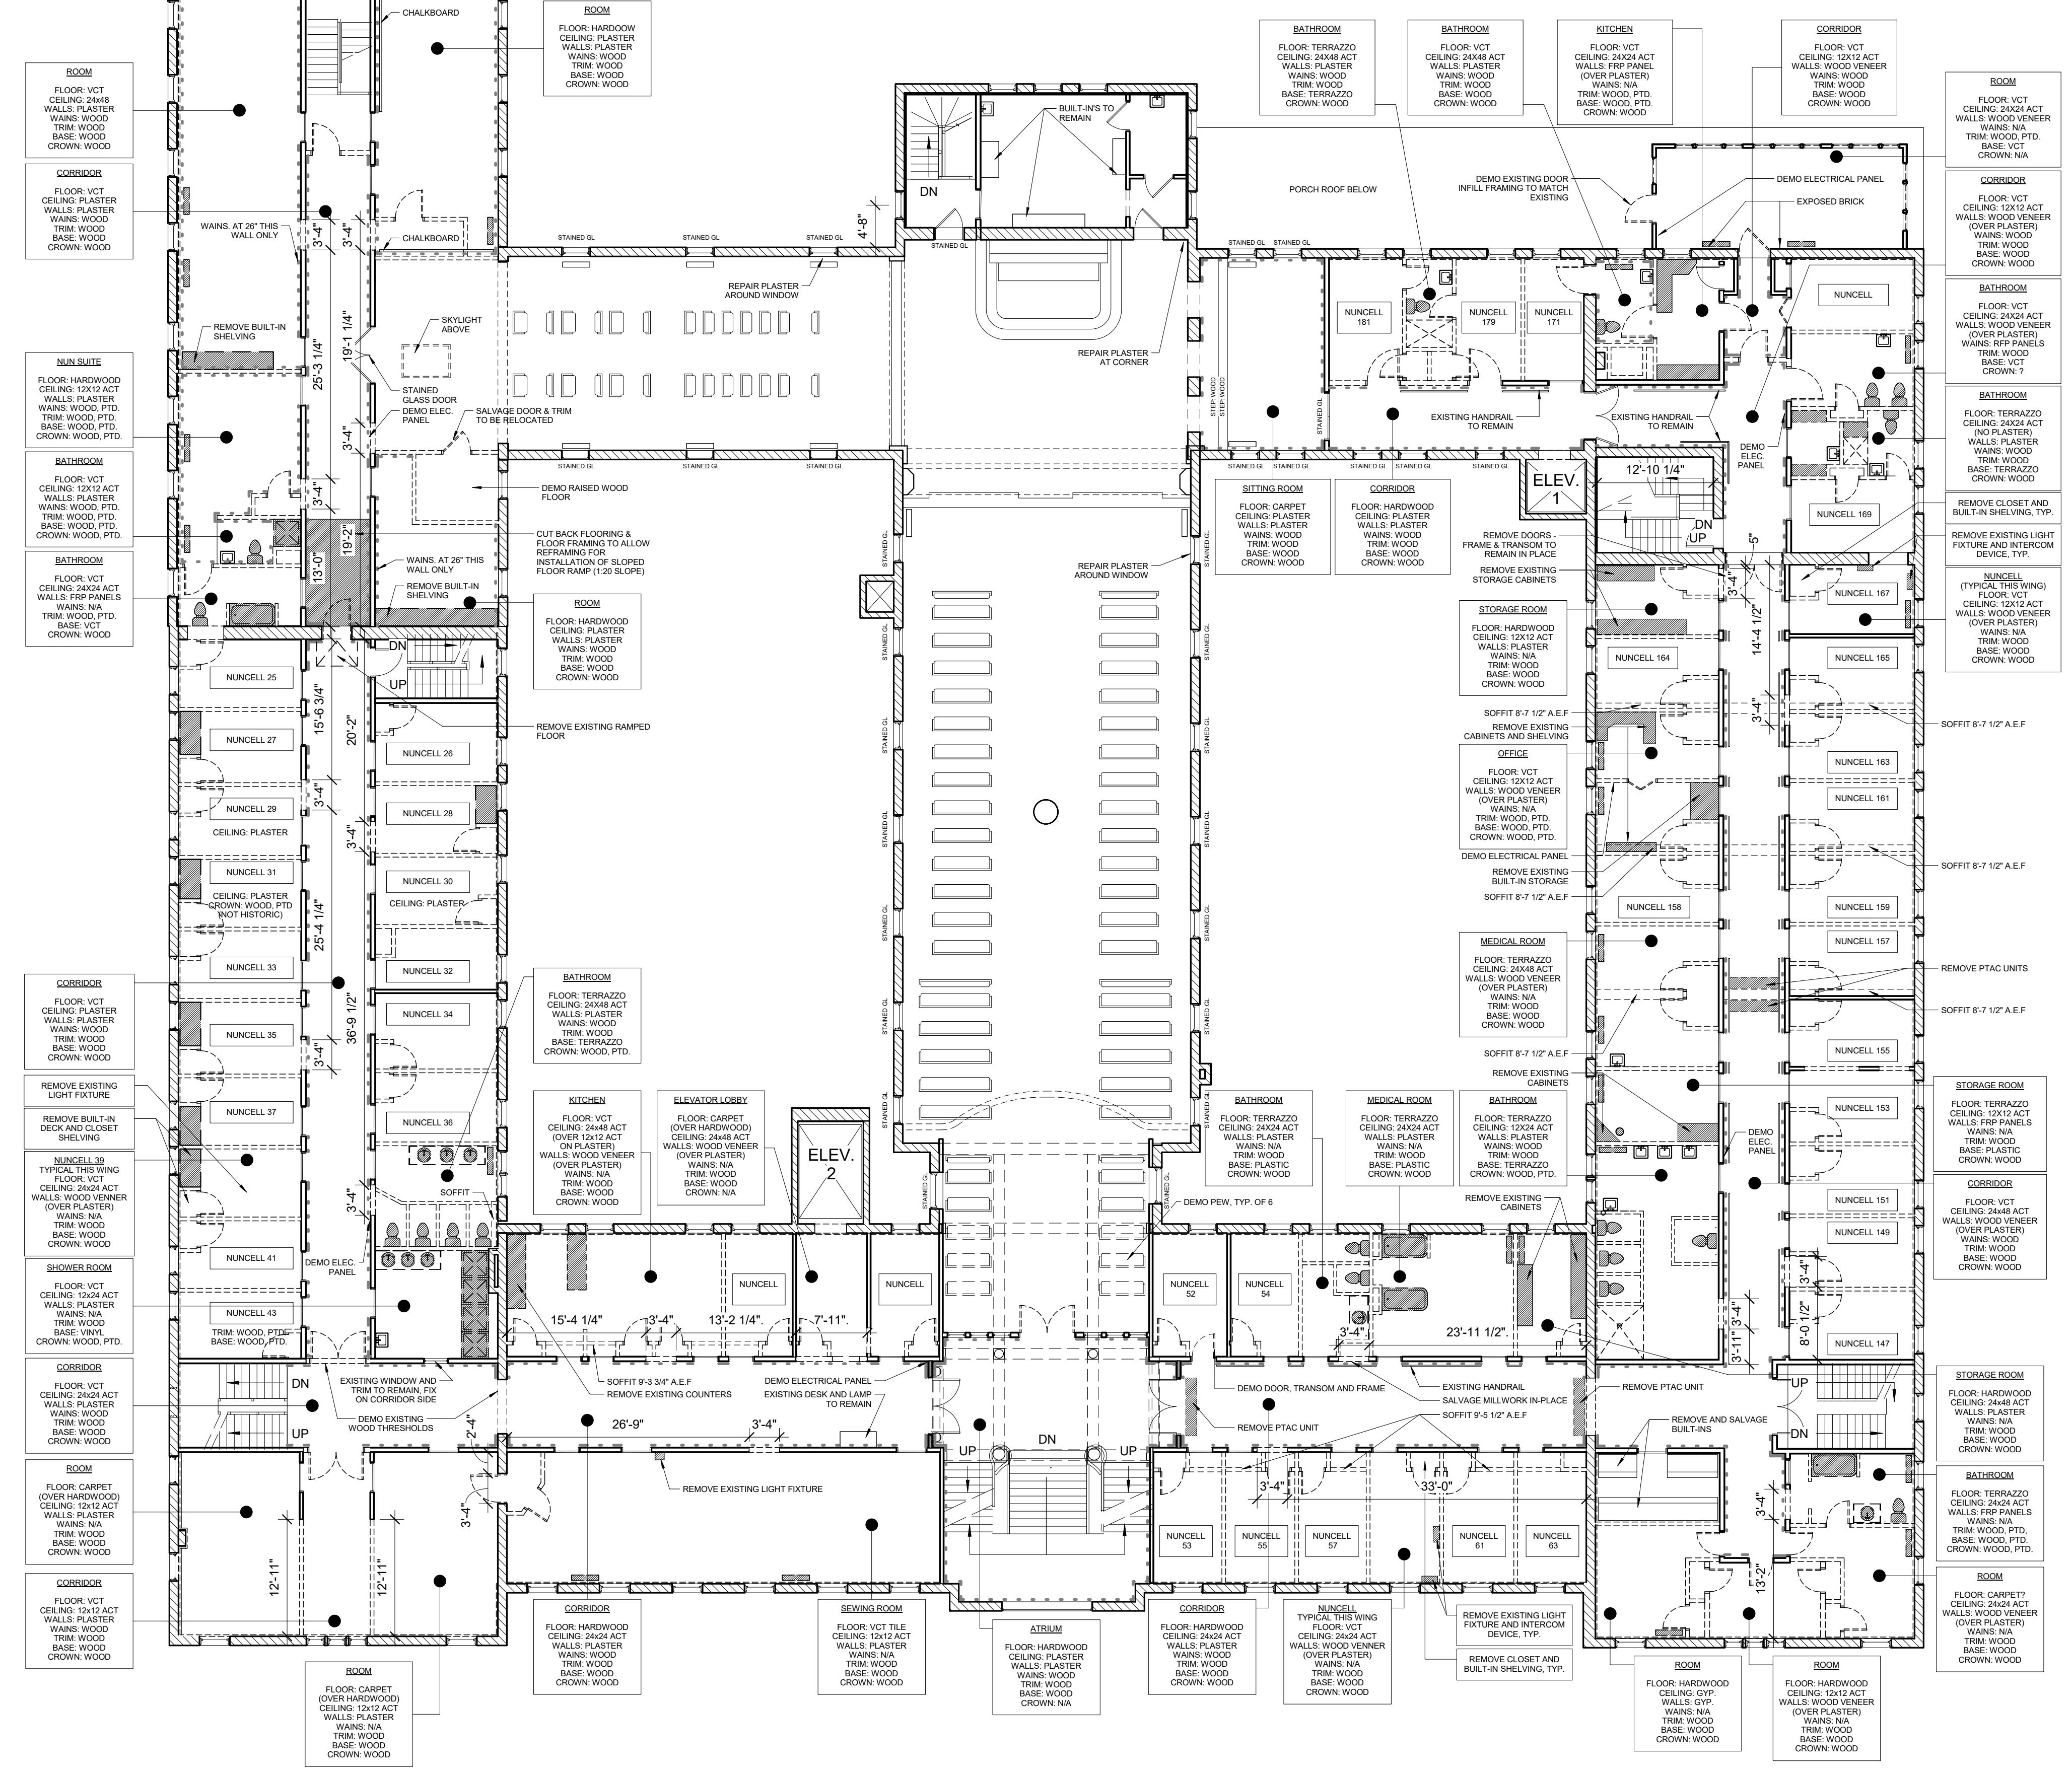

1 | EXISTING THIRD FLOOR PLAN & DEMO
 3/32" = 1'-0"