



NOTE:  
SEE LANDSCAPE PLANS FOR NEW LIGHT  
POLE LOCATIONS

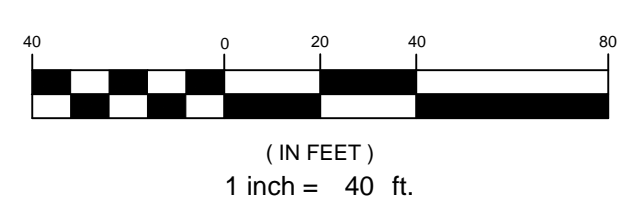

REV	DATE	DESCRIPTION
5	03.01.16	ISSUED FOR BID SET
4	02.15.16	ISSUED FOR 90% MSHA SUBMISSION
3	11.20.15	ISSUED FOR 50% MSHA SUBMISSION
2	07.28.15	REISSUED FOR SITE PLAN REVIEW
1	06.24.15	ISSUED FOR SITE PLAN REVIEW

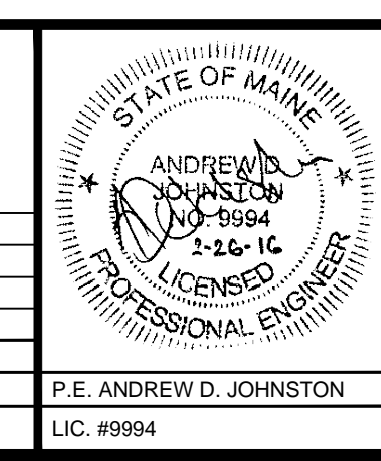

PROJECT  
**MOTHERHOUSE SENIOR HOUSING**

SHEET TITLE  
**UTILITY PLAN**

CLIENT  
**MOTHERHOUSE ASSOCIATES LP**

**FST** FAY, SPOFFORD & THORNDIKE  
ENGINEERS • PLANNERS • SCIENTISTS  
778 MAIN ST., SUITE 8, SOUTH PORTLAND, ME 04106

DRAWN: DED DATE: JANUARY 2016  
DESIGNED: ADJ SCALE: 1" = 40'  
CHECKED: ADJ JOB NO. SP-M162  
FILE NAME: SP-M162 UTILITY  
SHEET C5.0