
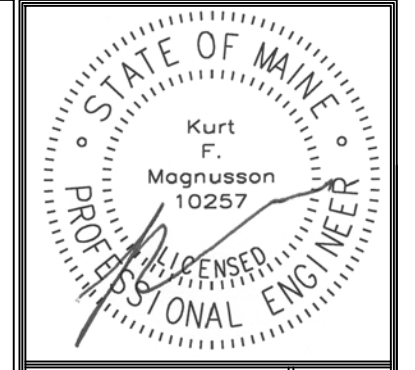
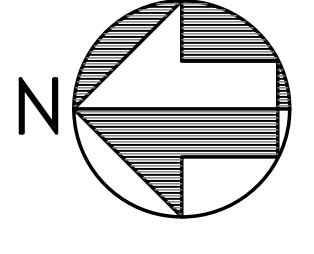


February 26, 2016 - 10:15 am
\\MSEFFS1\Projects\1530 Motherhouse Sr Drawings\1530 P1-P11.dwg

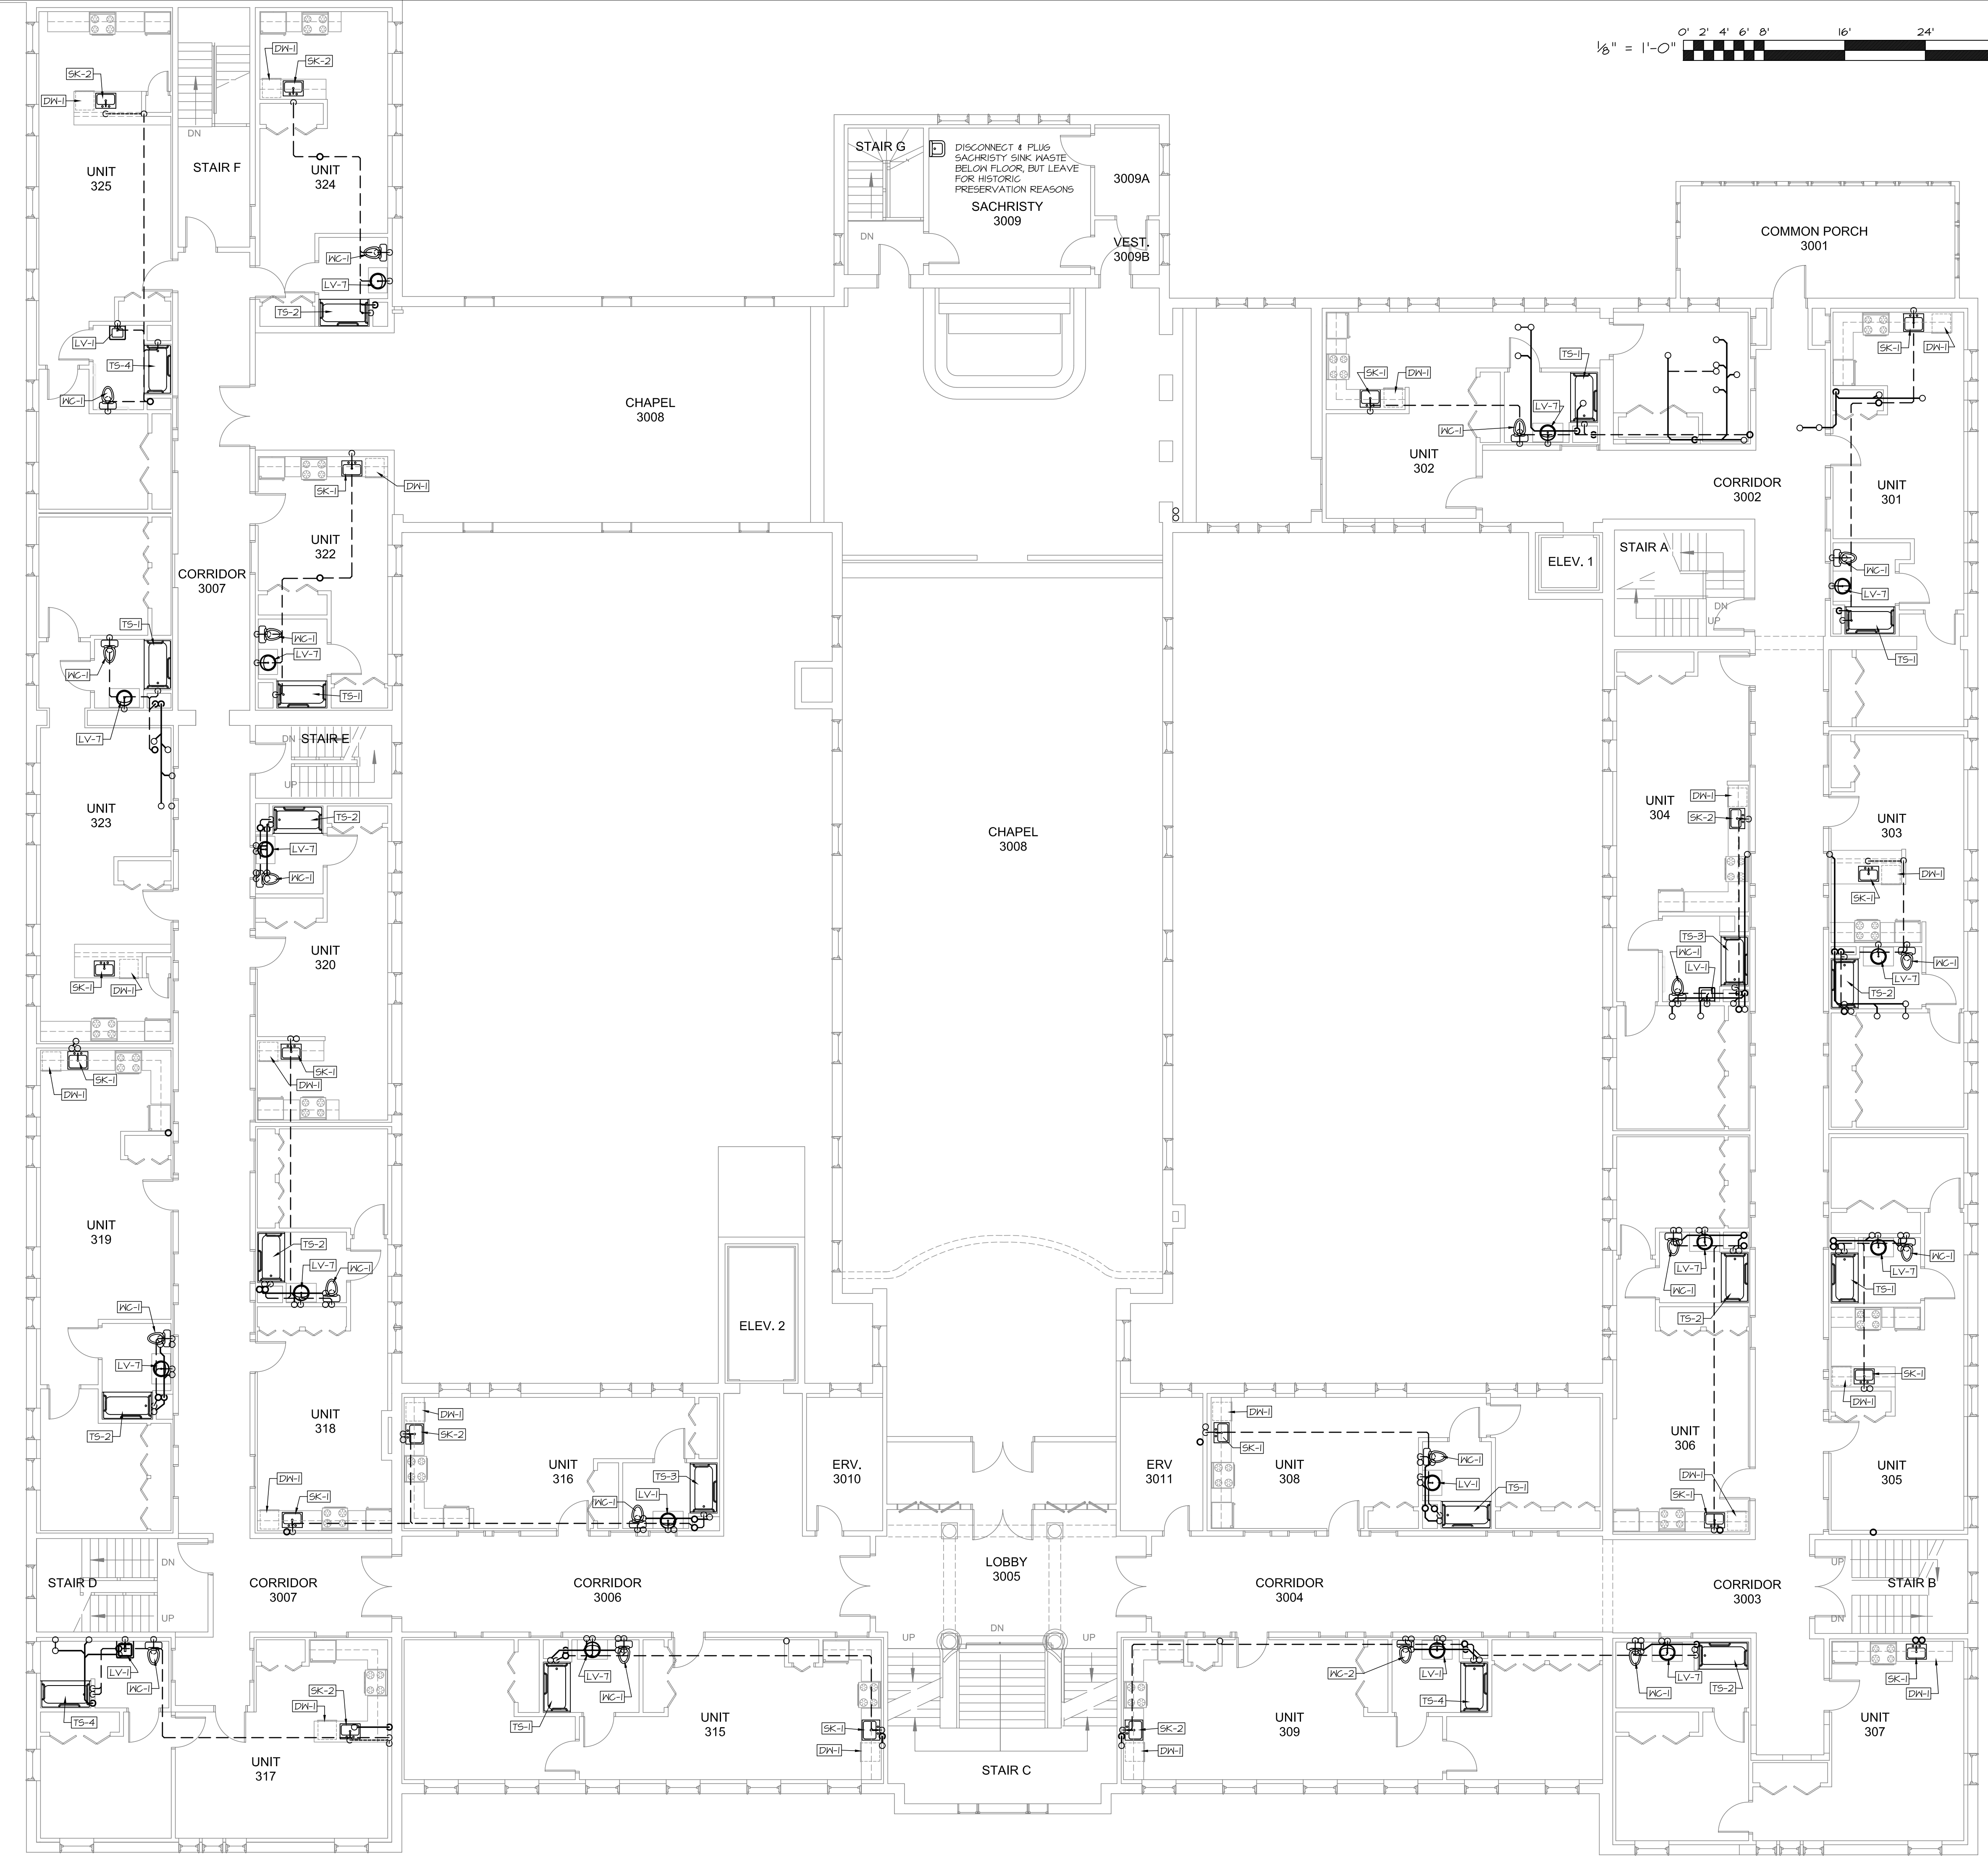

Prepared For:
MOTHERHOUSE LLC
Portland, ME 04103

Consulting Engineer:
MECHANICAL SYSTEMS ENGINEERS
10 FOREST FALLS DRIVE, WARRENTH, MAINE 04098
(207) 846-1441
FACEBOOK: MSES/MSSE ENGINEERS
© COPYRIGHT 2015

Architect:
ARCHETYPE Architects
48 Union Wharf Portland, Maine 04101
(207) 772-6022 ARCHETYPE@ARCHETYPEPA.COM

Project:
MOTHERHOUSE SENIOR HOUSING
PORTLAND, MAINE

Revisions:
Permit Set: 15 February 2016

Date: 15 FEB. 2016
Scale: 1/8" = 1'-0"
THIRD FLOOR DRAIN AND VENT PLUMBING PLAN

P4
MSE PROJECT 1530

