
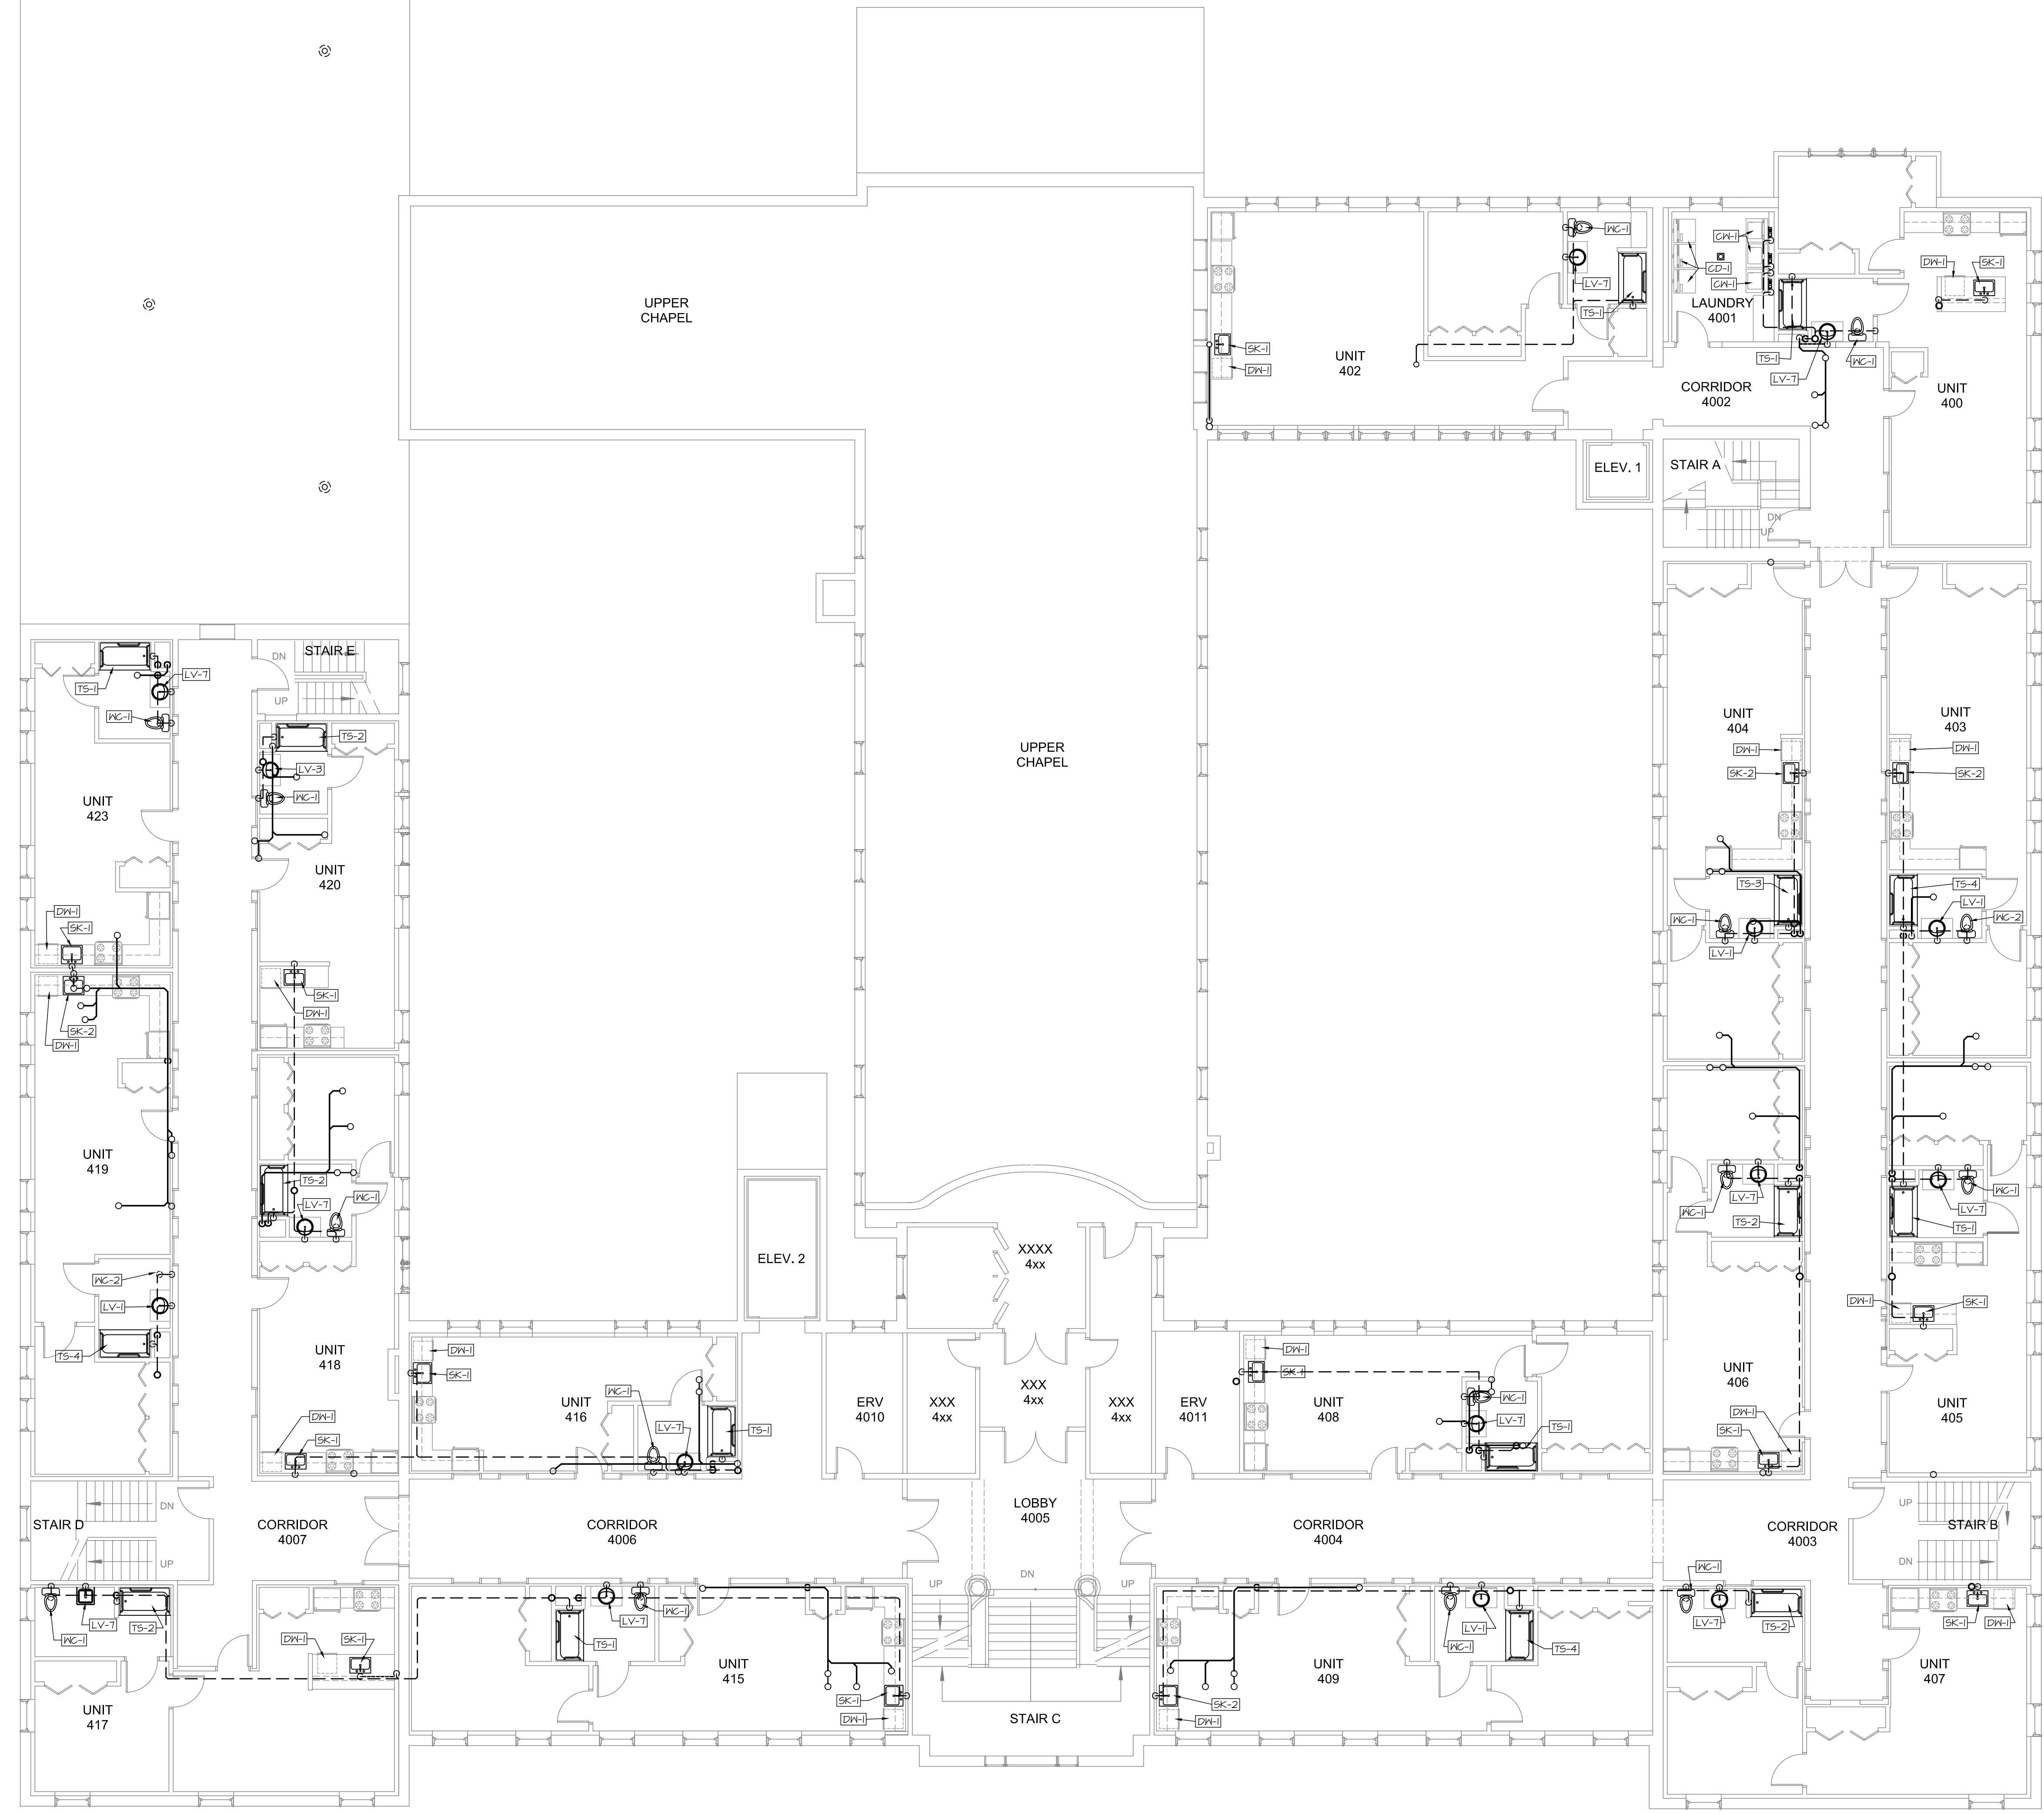
 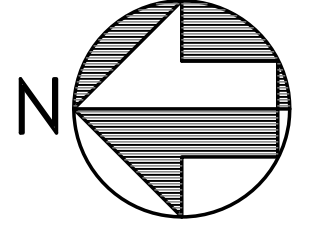


February 26, 2016 - 10:16 am  
 \\MSEFFS1\Projects\1530 Motherhouse Sr Drawings\1530 P1-P11.dwg

1/8" = 1'-0"



Prepared For:	MOTHERHOUSE LLC Portland, ME 04103
Consulting Engineer:	 MECHANICAL SYSTEMS ENGINEERS 10 FOREST FALLS DRIVE, WARRENTHURST, MAINE 04098 (207) 846-1441 FACEBOOK: MSES/MESE © COPYRIGHT 2015
Architect:	 ARCHETYPE architects 48 Union Wharf Portland, Maine 04101 (207) 772-6022 ARCHETYPE@ARCHETYPEPA.COM
Project:	MOTHERHOUSE SENIOR HOUSING PORTLAND, MAINE
Revisions:	Permit Set: 15 February 2016
Date:	15 FEB. 2016
Scale:	1/8" = 1'-0"
<b>FOURTH FLOOR        DRAIN AND VENT        PLUMBING PLAN</b>	
<b>P5</b> <small>MSE PROJECT 1530</small>	