
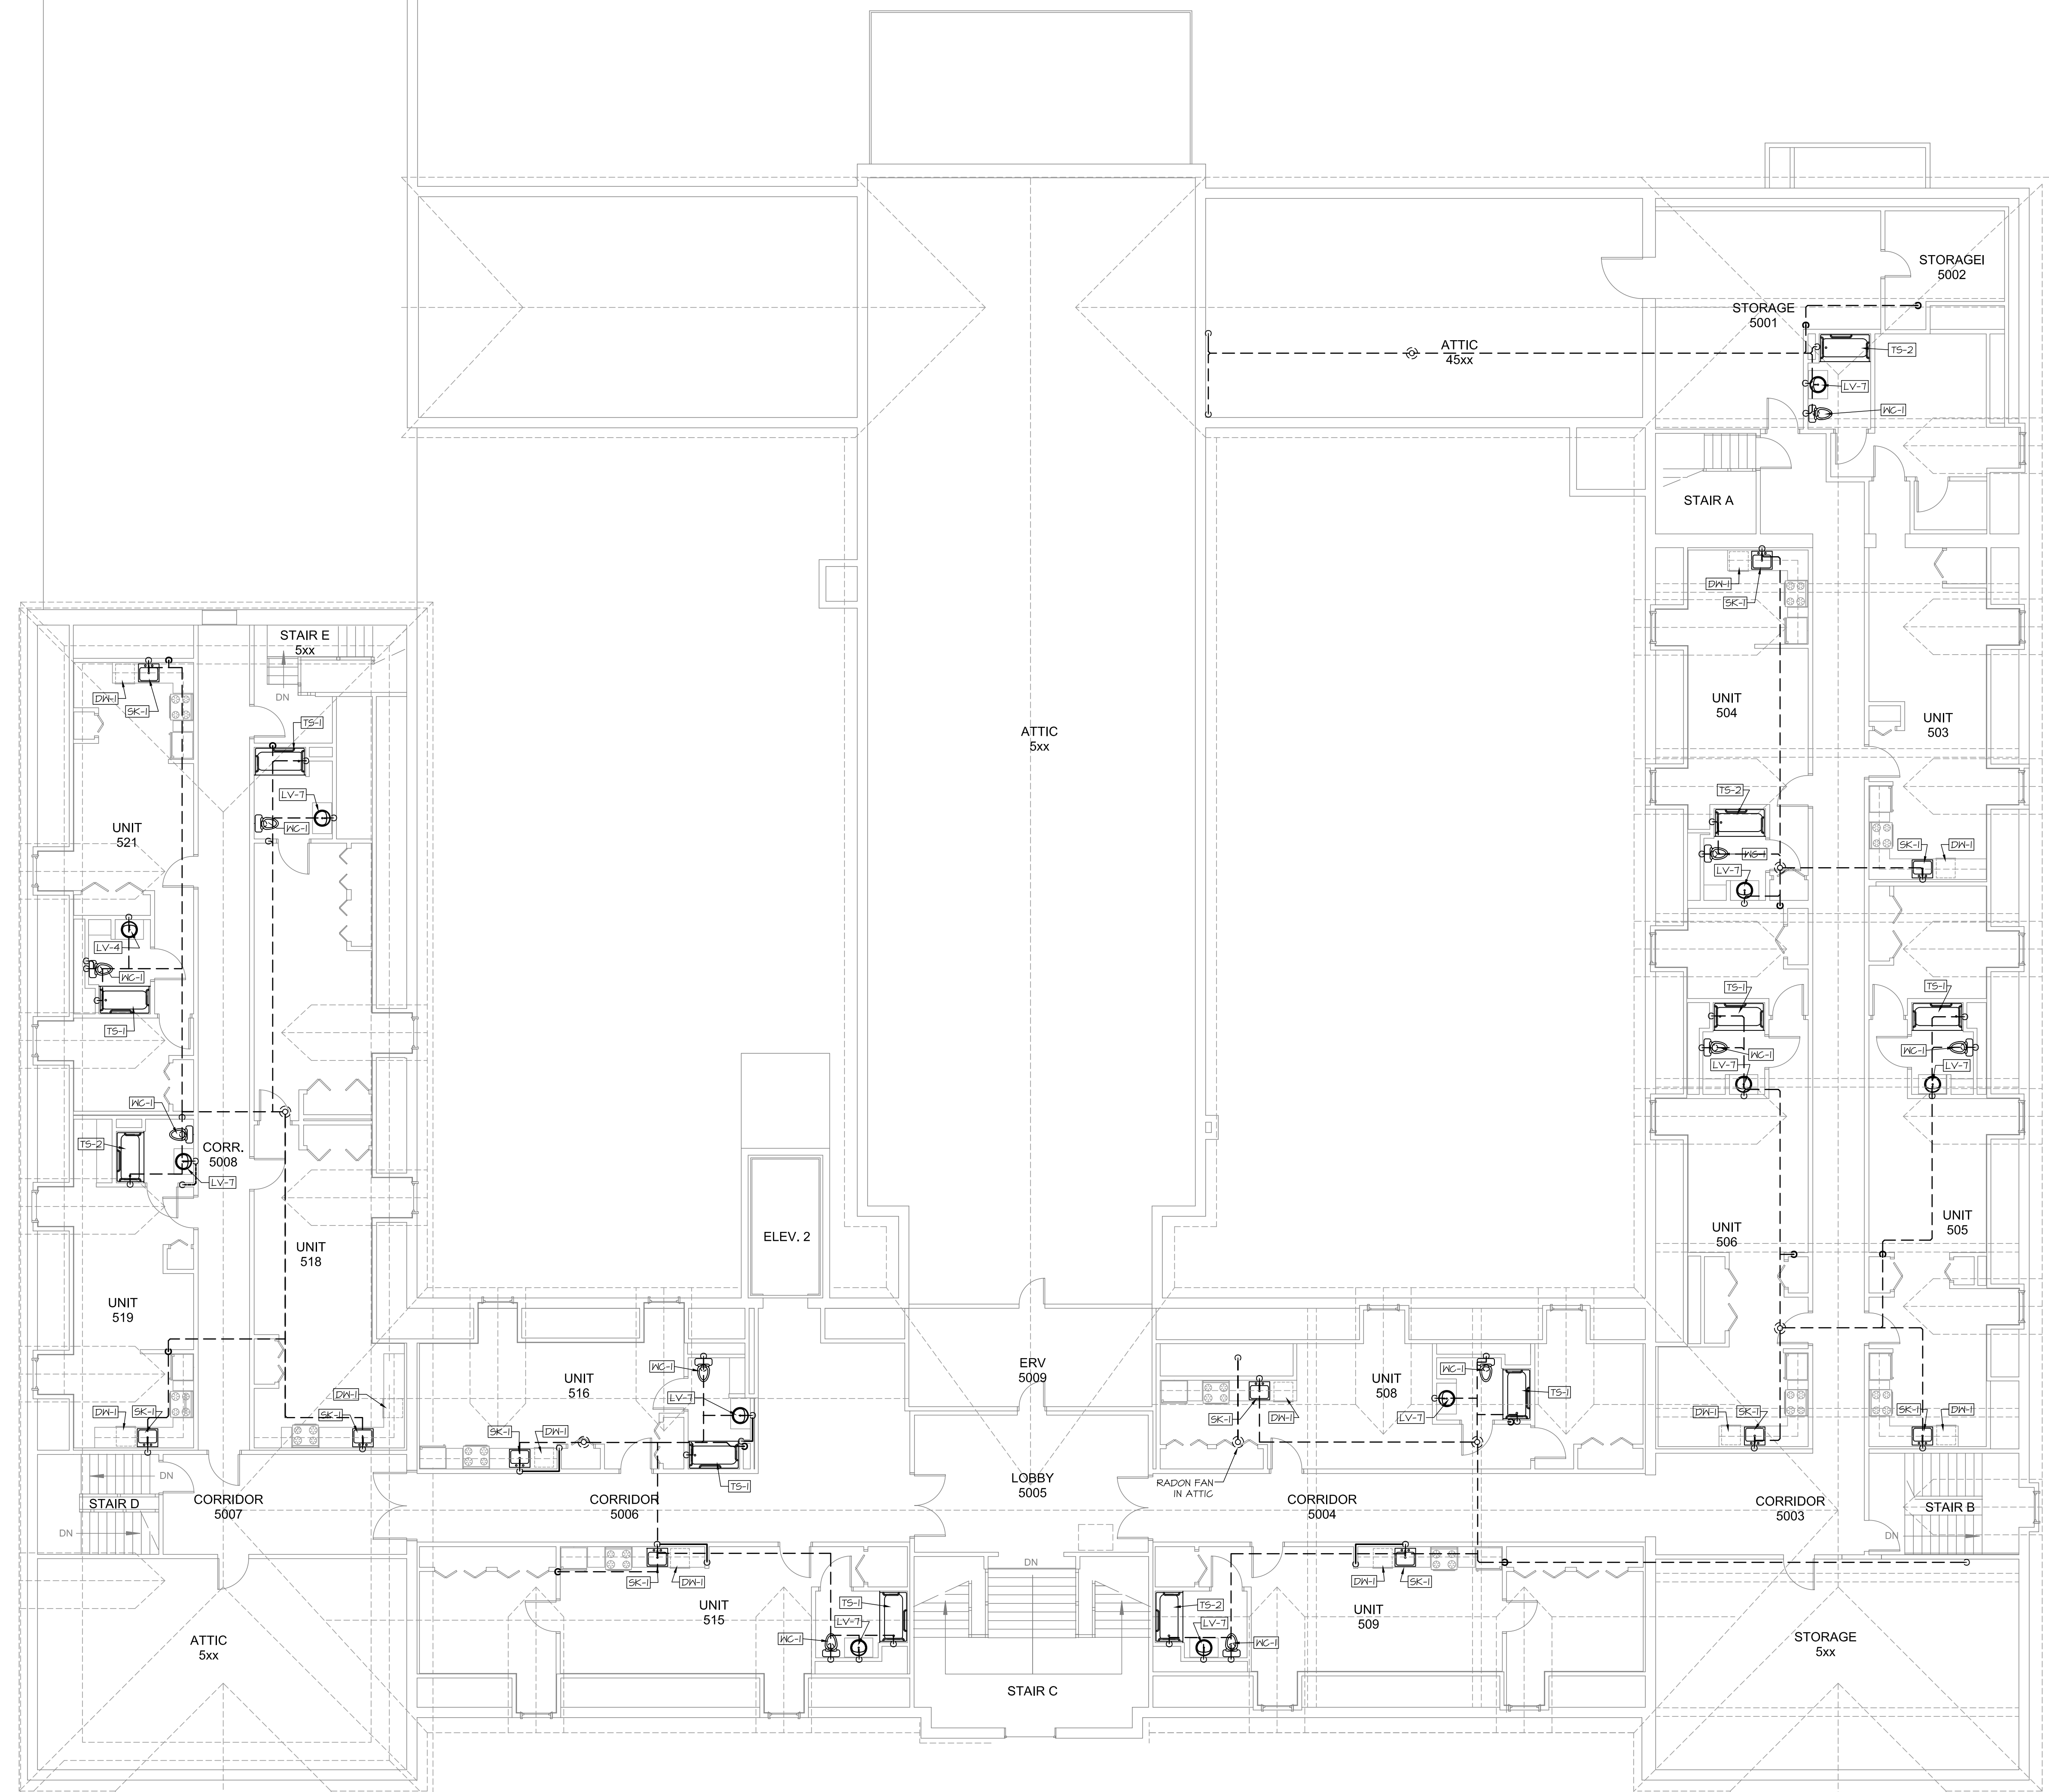
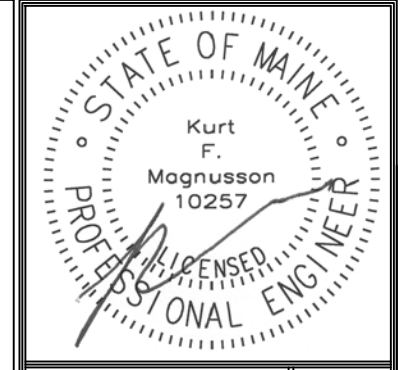


February 26, 2016 - 10:17 am  
\\MSEFFPS1\Projects\1530 Motherhouse Sr Drawings\1530 P1-P11.dwg

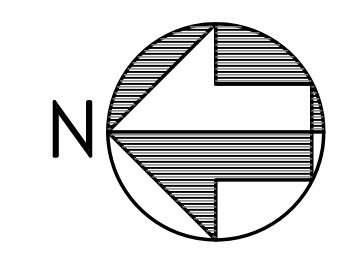

Prepared For:  
**MOTHERHOUSE LLC**  
Portland, ME 04103

Consulting Engineer:  
**MECHANICAL SYSTEMS ENGINEERS**  
10 FOREST FALLS DRIVE, WARRENTH, MAINE 04098  
© COPYRIGHT 2015

Architect:  
**ARCHETYPE Architects**  
48 Union Wharf Portland, Maine 04101  
(207) 772-6022 ARCHETYPE@ARCHETYPEPA.COM

Project:  
**MOTHERHOUSE SENIOR HOUSING**  
PORTLAND, MAINE

Revisions:  
Permit Set: 15 February 2016

Date: 15 FEB. 2016  
Scale: 1/8" = 1'-0"  
**FIFTH FLOOR DRAIN AND VENT PLUMBING PLAN**



**P6**  
MSE PROJECT 1530