

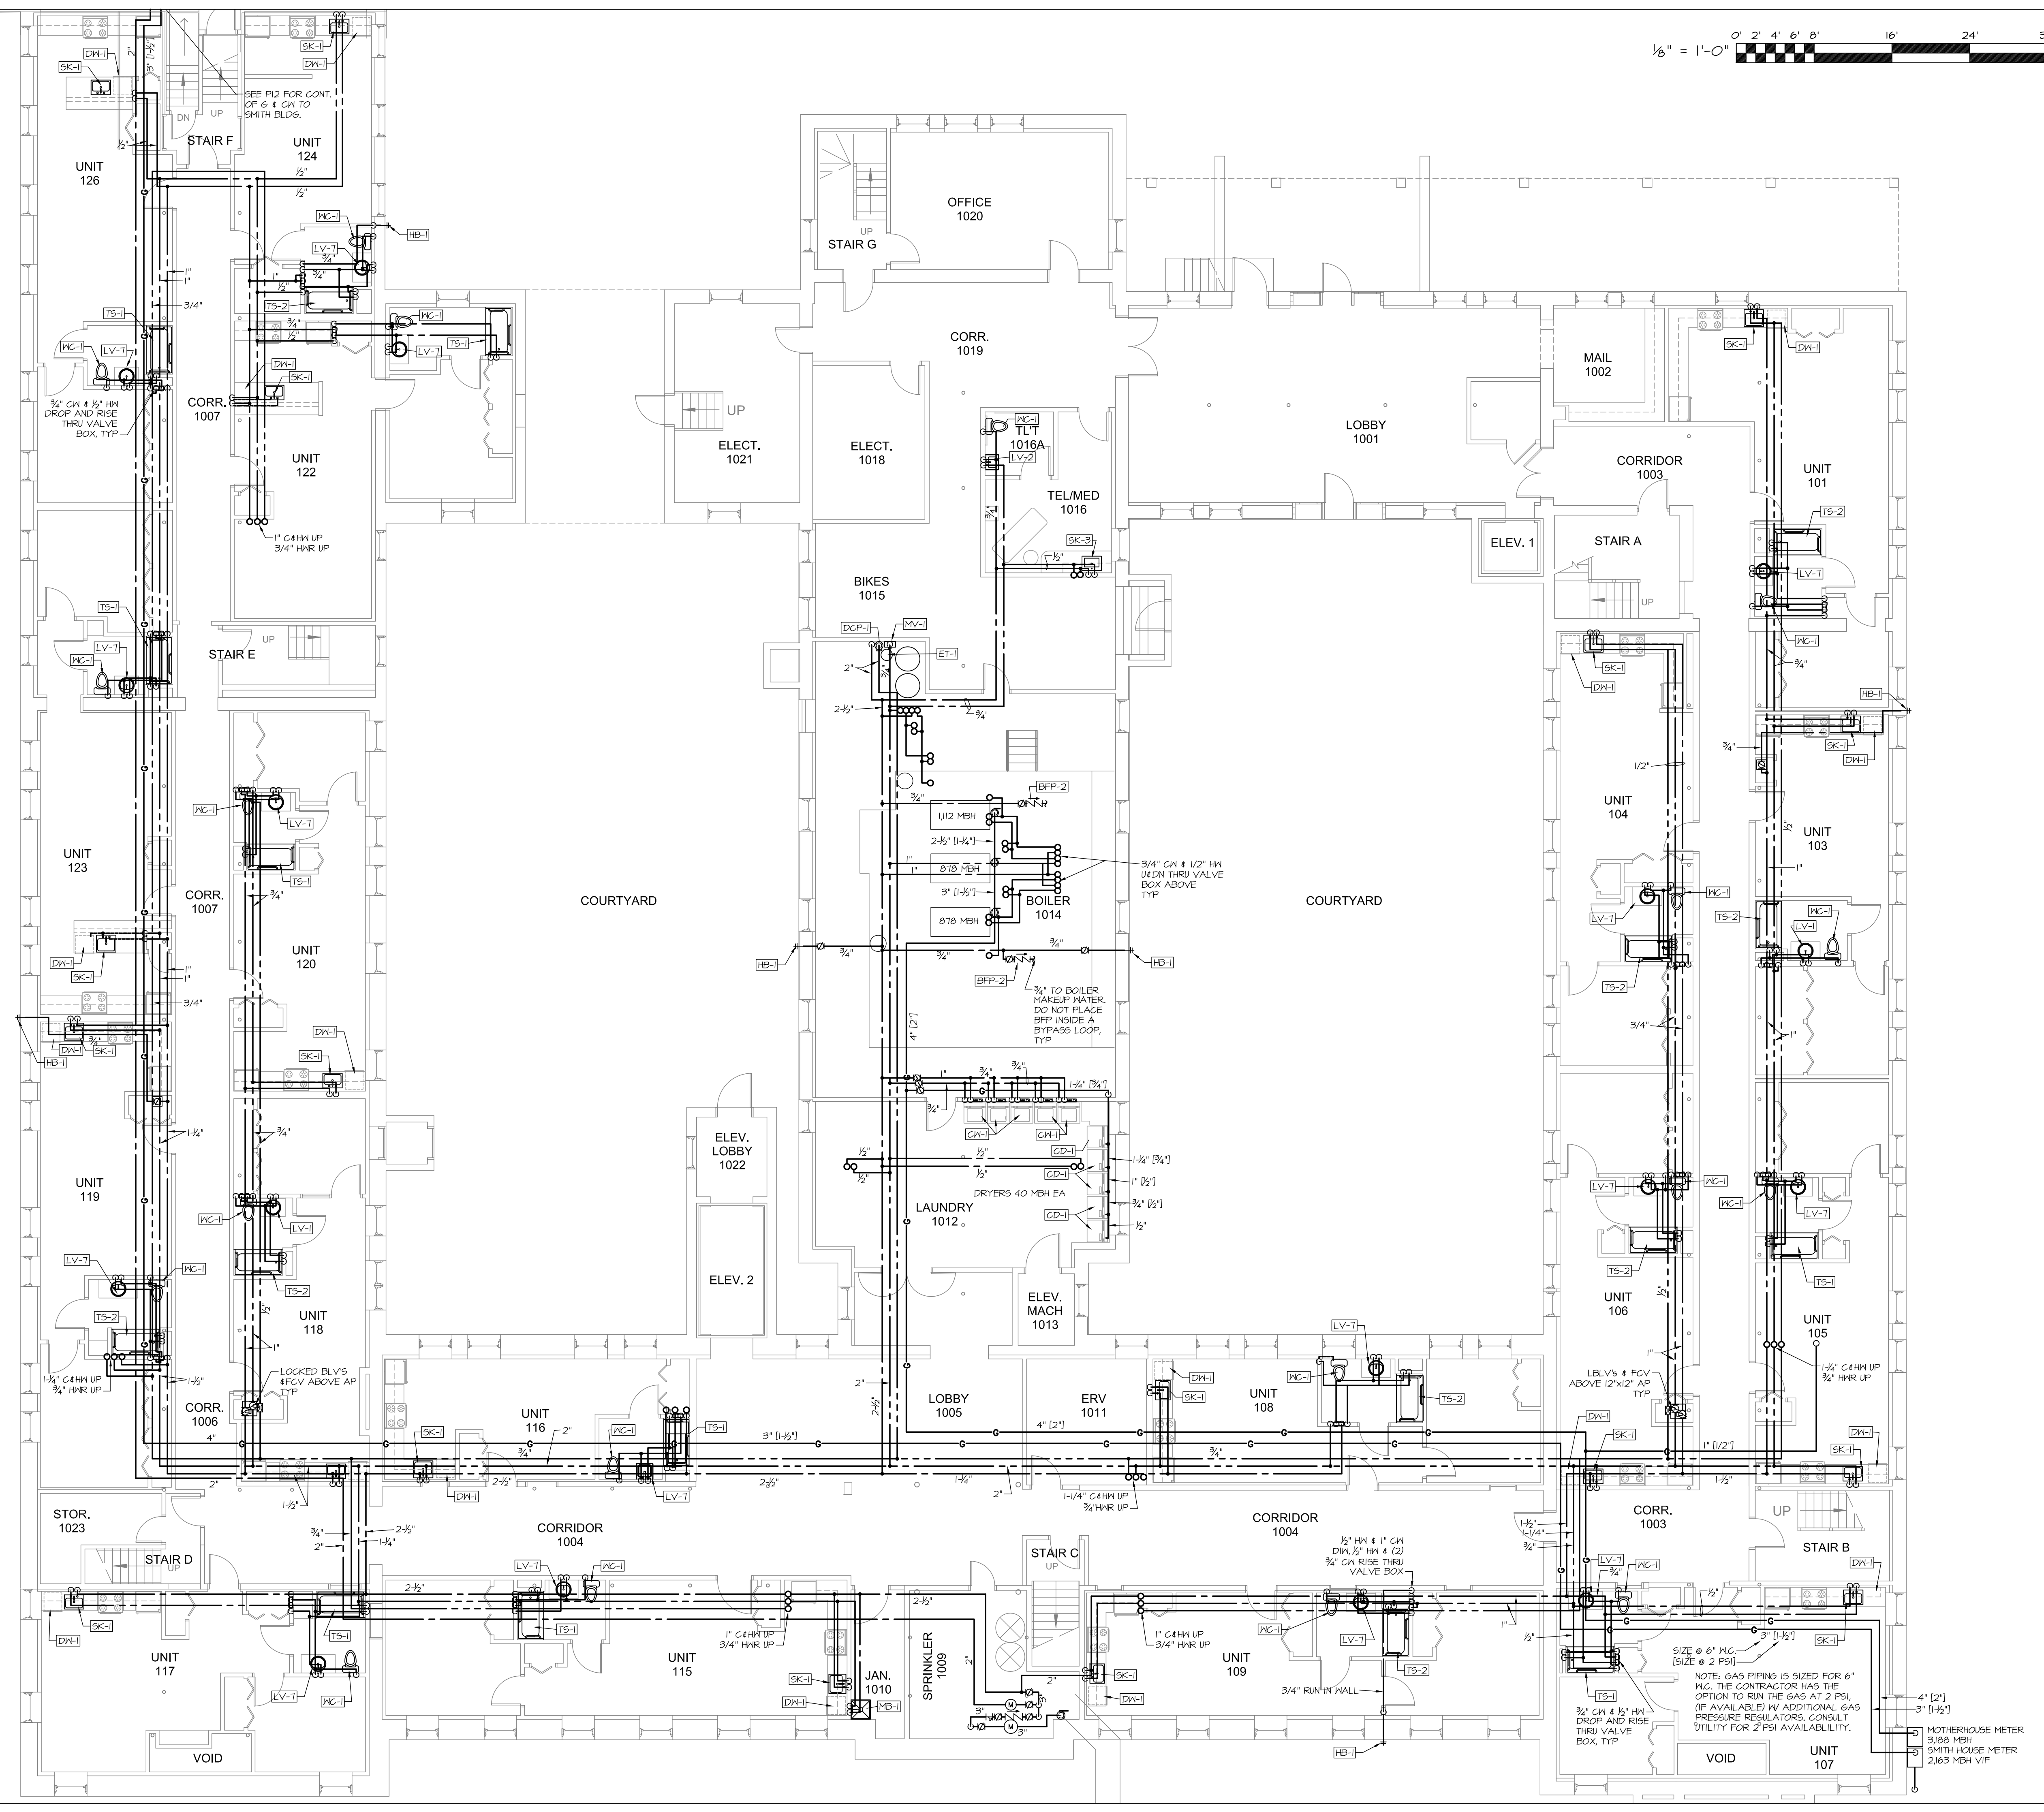


February 26, 2016 - 10:18 am
 \\MSEFFS1\Projects\1530 Motherhouse Sr Drawings\1530 P1-P11.dwg

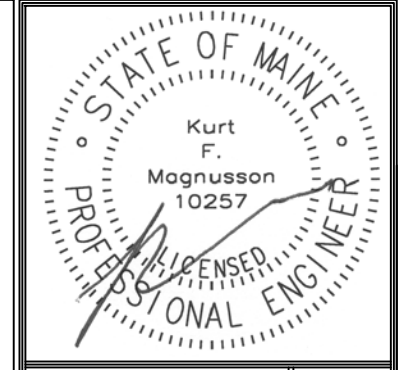

1/8" = 1'-0"
 0' 2' 4' 6' 8' 16' 24' 32'

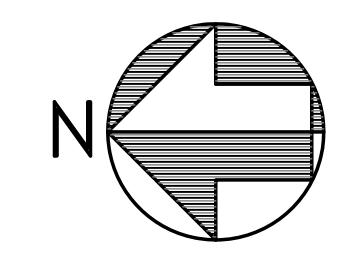

Prepared For:
MOTHERHOUSE LLC
 Portland, ME 04103

Consulting Engineer:
MECHANICAL SYSTEMS ENGINEERS
 MECHANICAL SYSTEMS ENGINEERS, LLC
 10 FOREST FALLS DRIVE, WARRENTHURST, MAINE 04098
 (207) 846-1441
 FACEBOOK: MSES-MAINE MECHANICAL ENGINEERS
 © COPYRIGHT 2015

Architect:
ARCHETYPE architects
 48 Union Wharf Portland, Maine 04101
 (207) 775-6022 ARCHETYPE@ARCHETYPEPA.COM

Project:
MOTHERHOUSE SENIOR HOUSING
 PORTLAND, MAINE

Revisions:
 Permit Set: 15 February 2016

Date: 15 FEB. 2016
 Scale: 1/8" = 1'-0"
FIRST FLOOR DOMESTIC WATER PLUMBING PLAN

P7
 MSE PROJECT 1530

