
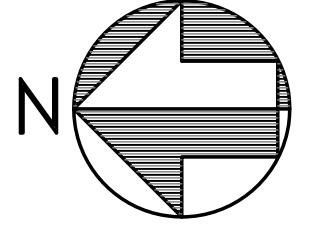


February 26, 2016 - 10:20 am
 \\MSEFFS1\Projects\1530 Motherhouse Sr Drawings\1530 P1-P11.dwg

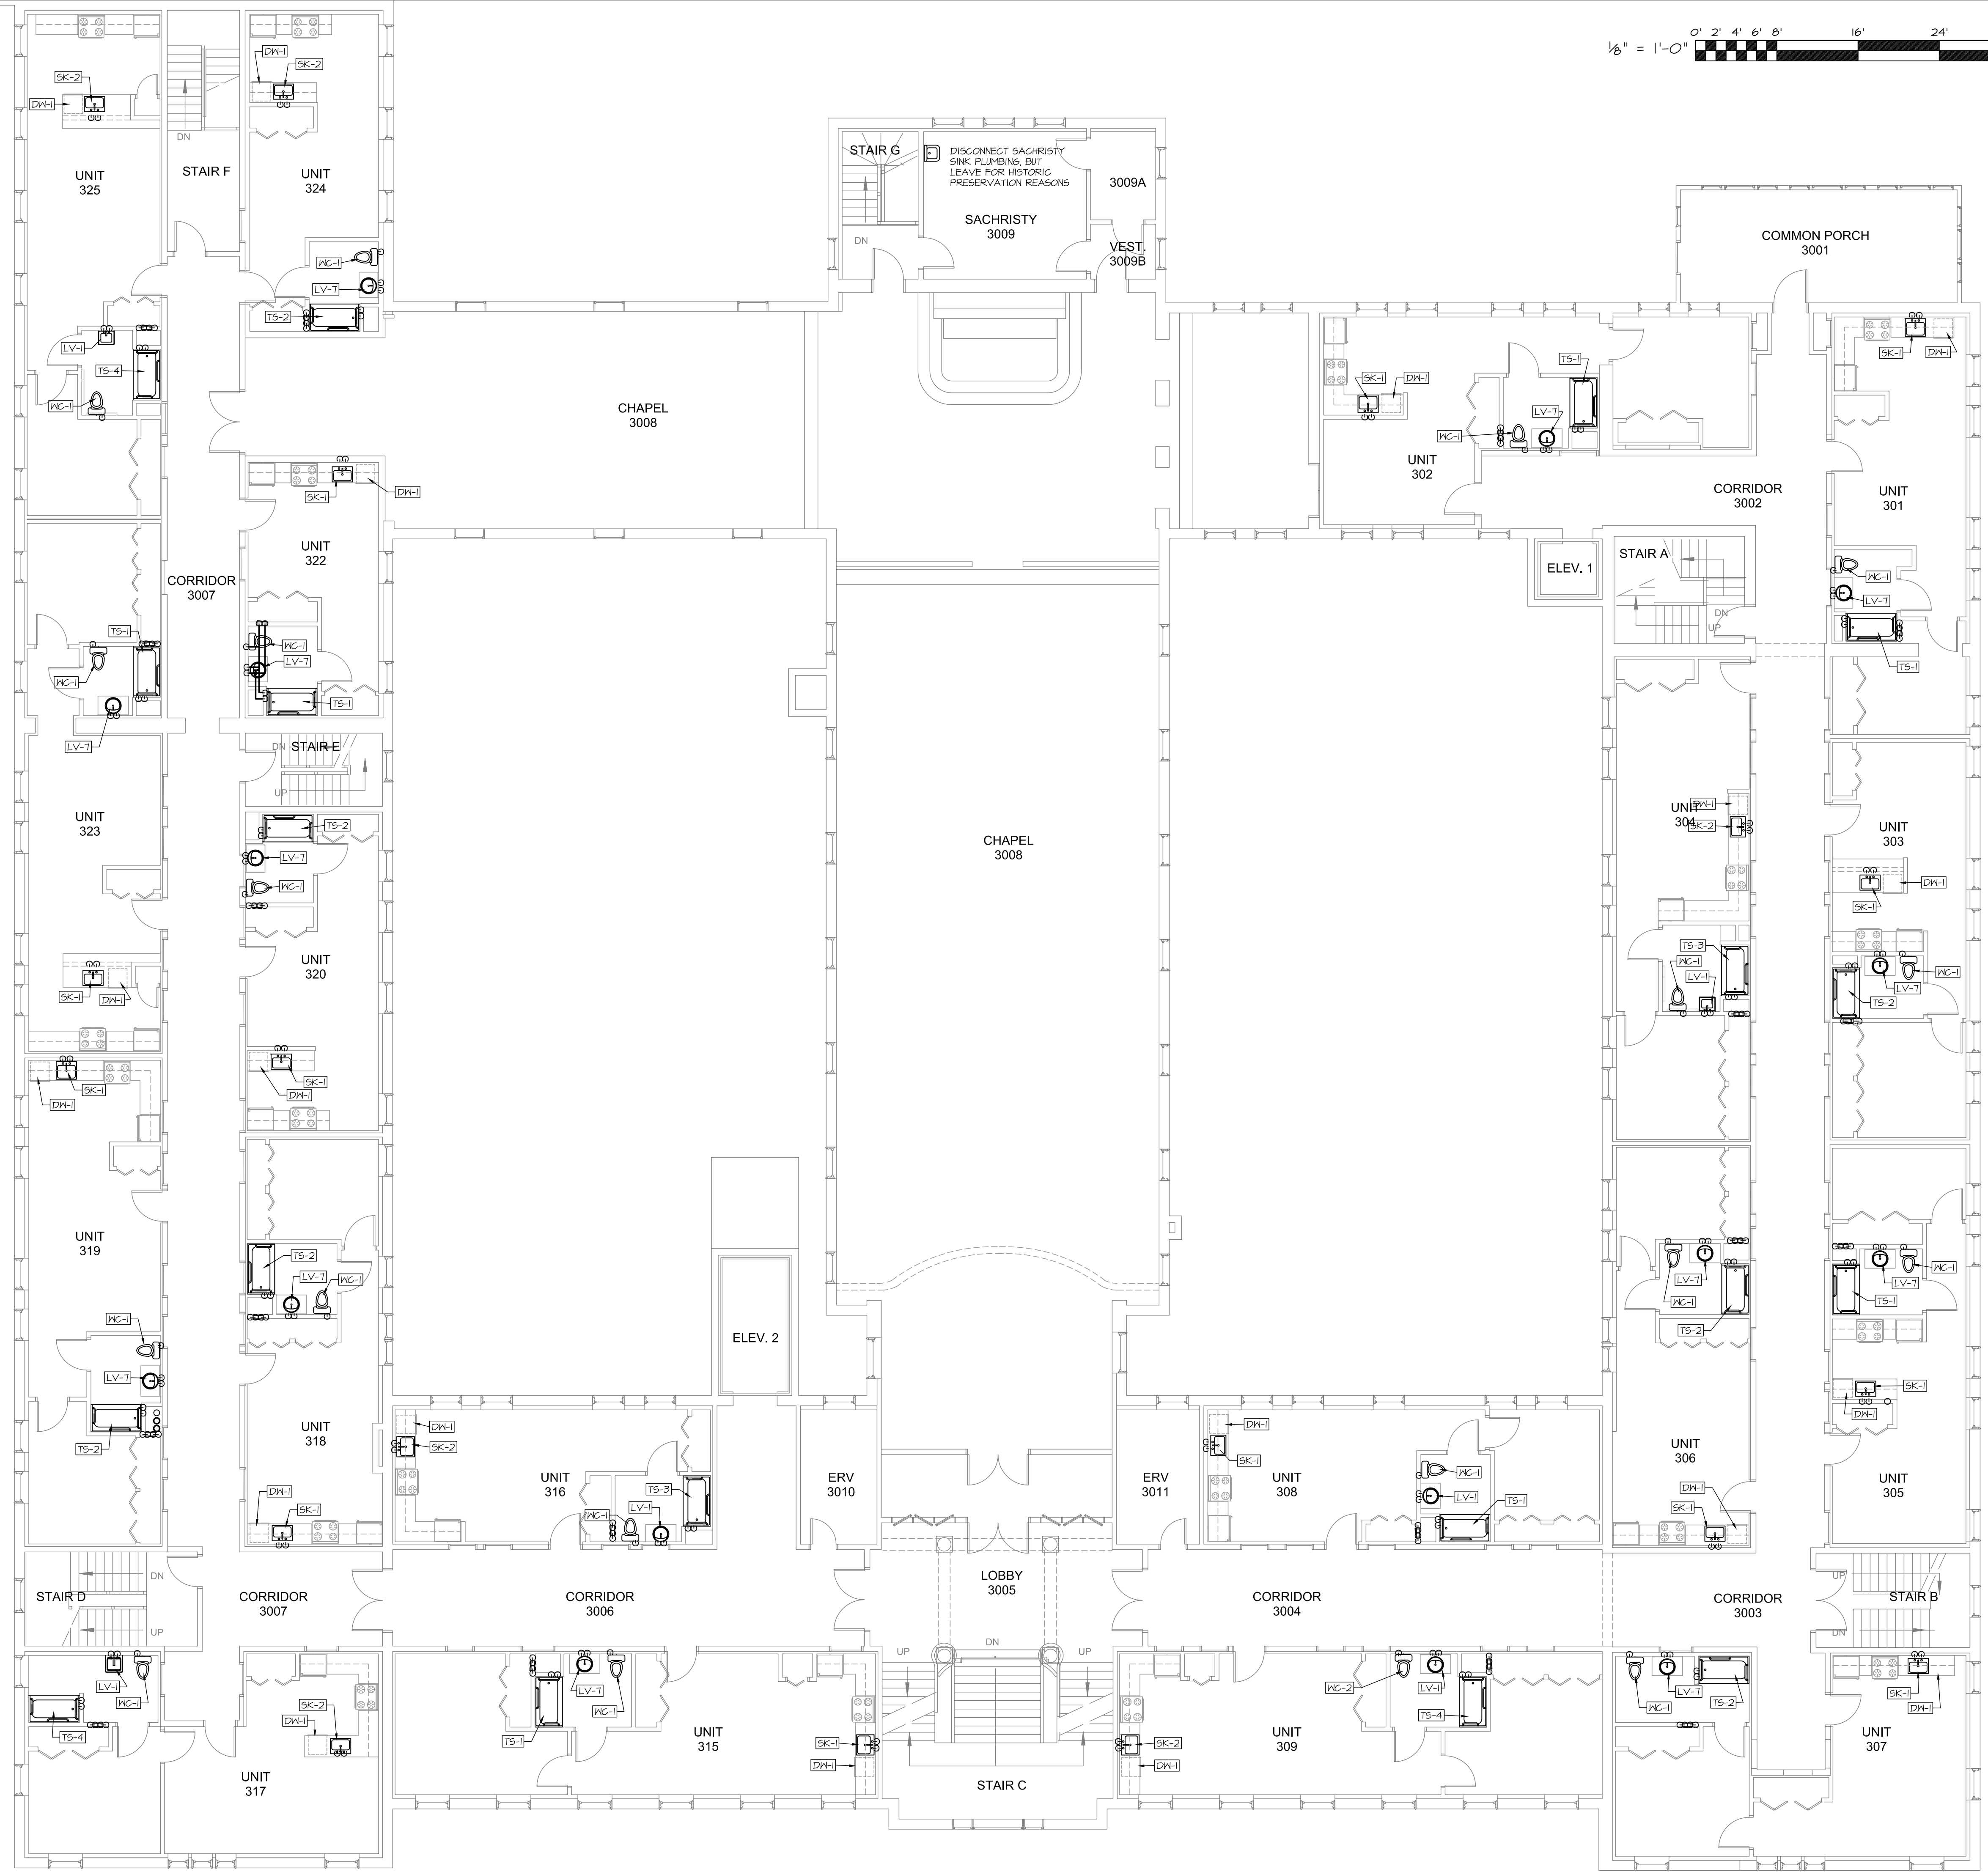

Prepared For:	MOTHERHOUSE LLC Portland, ME 04103
Consulting Engineer:	 MECHANICAL SYSTEMS ENGINEERS <small>10 FOREST FALLS DRIVE, WARRENTHURST, MAINE 04098 (207) 846-1441 FACEBOOK: MSES-MAINE © COPYRIGHT 2015</small>
Architect:	 ARCHETYPE Architects <small>48 Union Wharf, Portland, Maine 04101 (207) 772-6022 ARCHETYPE@ARCHETYPEDA.COM</small>
Project:	MOTHERHOUSE SENIOR HOUSING PORTLAND, MAINE
Revisions:	Permit Set: 15 February 2016
Date:	15 FEB. 2016
Scale:	1/8" = 1'-0"
THIRD FLOOR DOMESTIC WATER PLUMBING PLAN	
P9 <small>MSE PROJECT 1530</small>	