


- GENERAL CEILING PLAN NOTES**
1. REFER TO SHEET G1002 FOR ALL ABBREVIATIONS.
 2. CONTRACTOR TO VERIFY LOCATION OF MAIN CEILING TEES BEFORE PROCEEDING WITH FIXTURE INSTALLATION. NOTIFY ARCHITECT OF INTERFERENCES.
 3. NOTIFY ARCHITECT OF ANY DISCREPANCIES BETWEEN ARCHITECTURAL REFLECTED CEILING AND MECHANICAL LIGHTING PLANS PRIOR TO CONSTRUCTION.
 4. REFER TO ELECTRICAL PLANS FOR LOCATIONS OF STROBES AND EXIT SIGNS.
 5. ALL CEILING GRILLES, TRIM EDGES, AND SLOT DIFFUSERS TO MATCH ADJACENT CEILING COLOR.
 6. ALL SPRINKLER HEADS TO OCCUR AT CENTER OF TILES.
 7. LAYOUT TILES AS SHOWN IN REFLECTED CEILING PLANS.
 8. REFER TO SPECIFICATION SECTION 09611 FOR ALL ACOUSTICAL PANEL CEILING TYPES.
 9. ALL CEILINGS TO BE 9'6" A.F.F. U.N.O.
 10. WHERE NO CEILING MATERIAL IS SHOWN THE STRUCTURE ABOVE IS TO BE EXPOSED. U.N.O.
 11. SEE EL SHEETS FOR CONTINUED LIGHTING INFORMATION.
 12. SEE MH SHEETS FOR CONTINUED MECHANICAL INFORMATION.
 13. ALL APC'S APC-1 U.N.O.

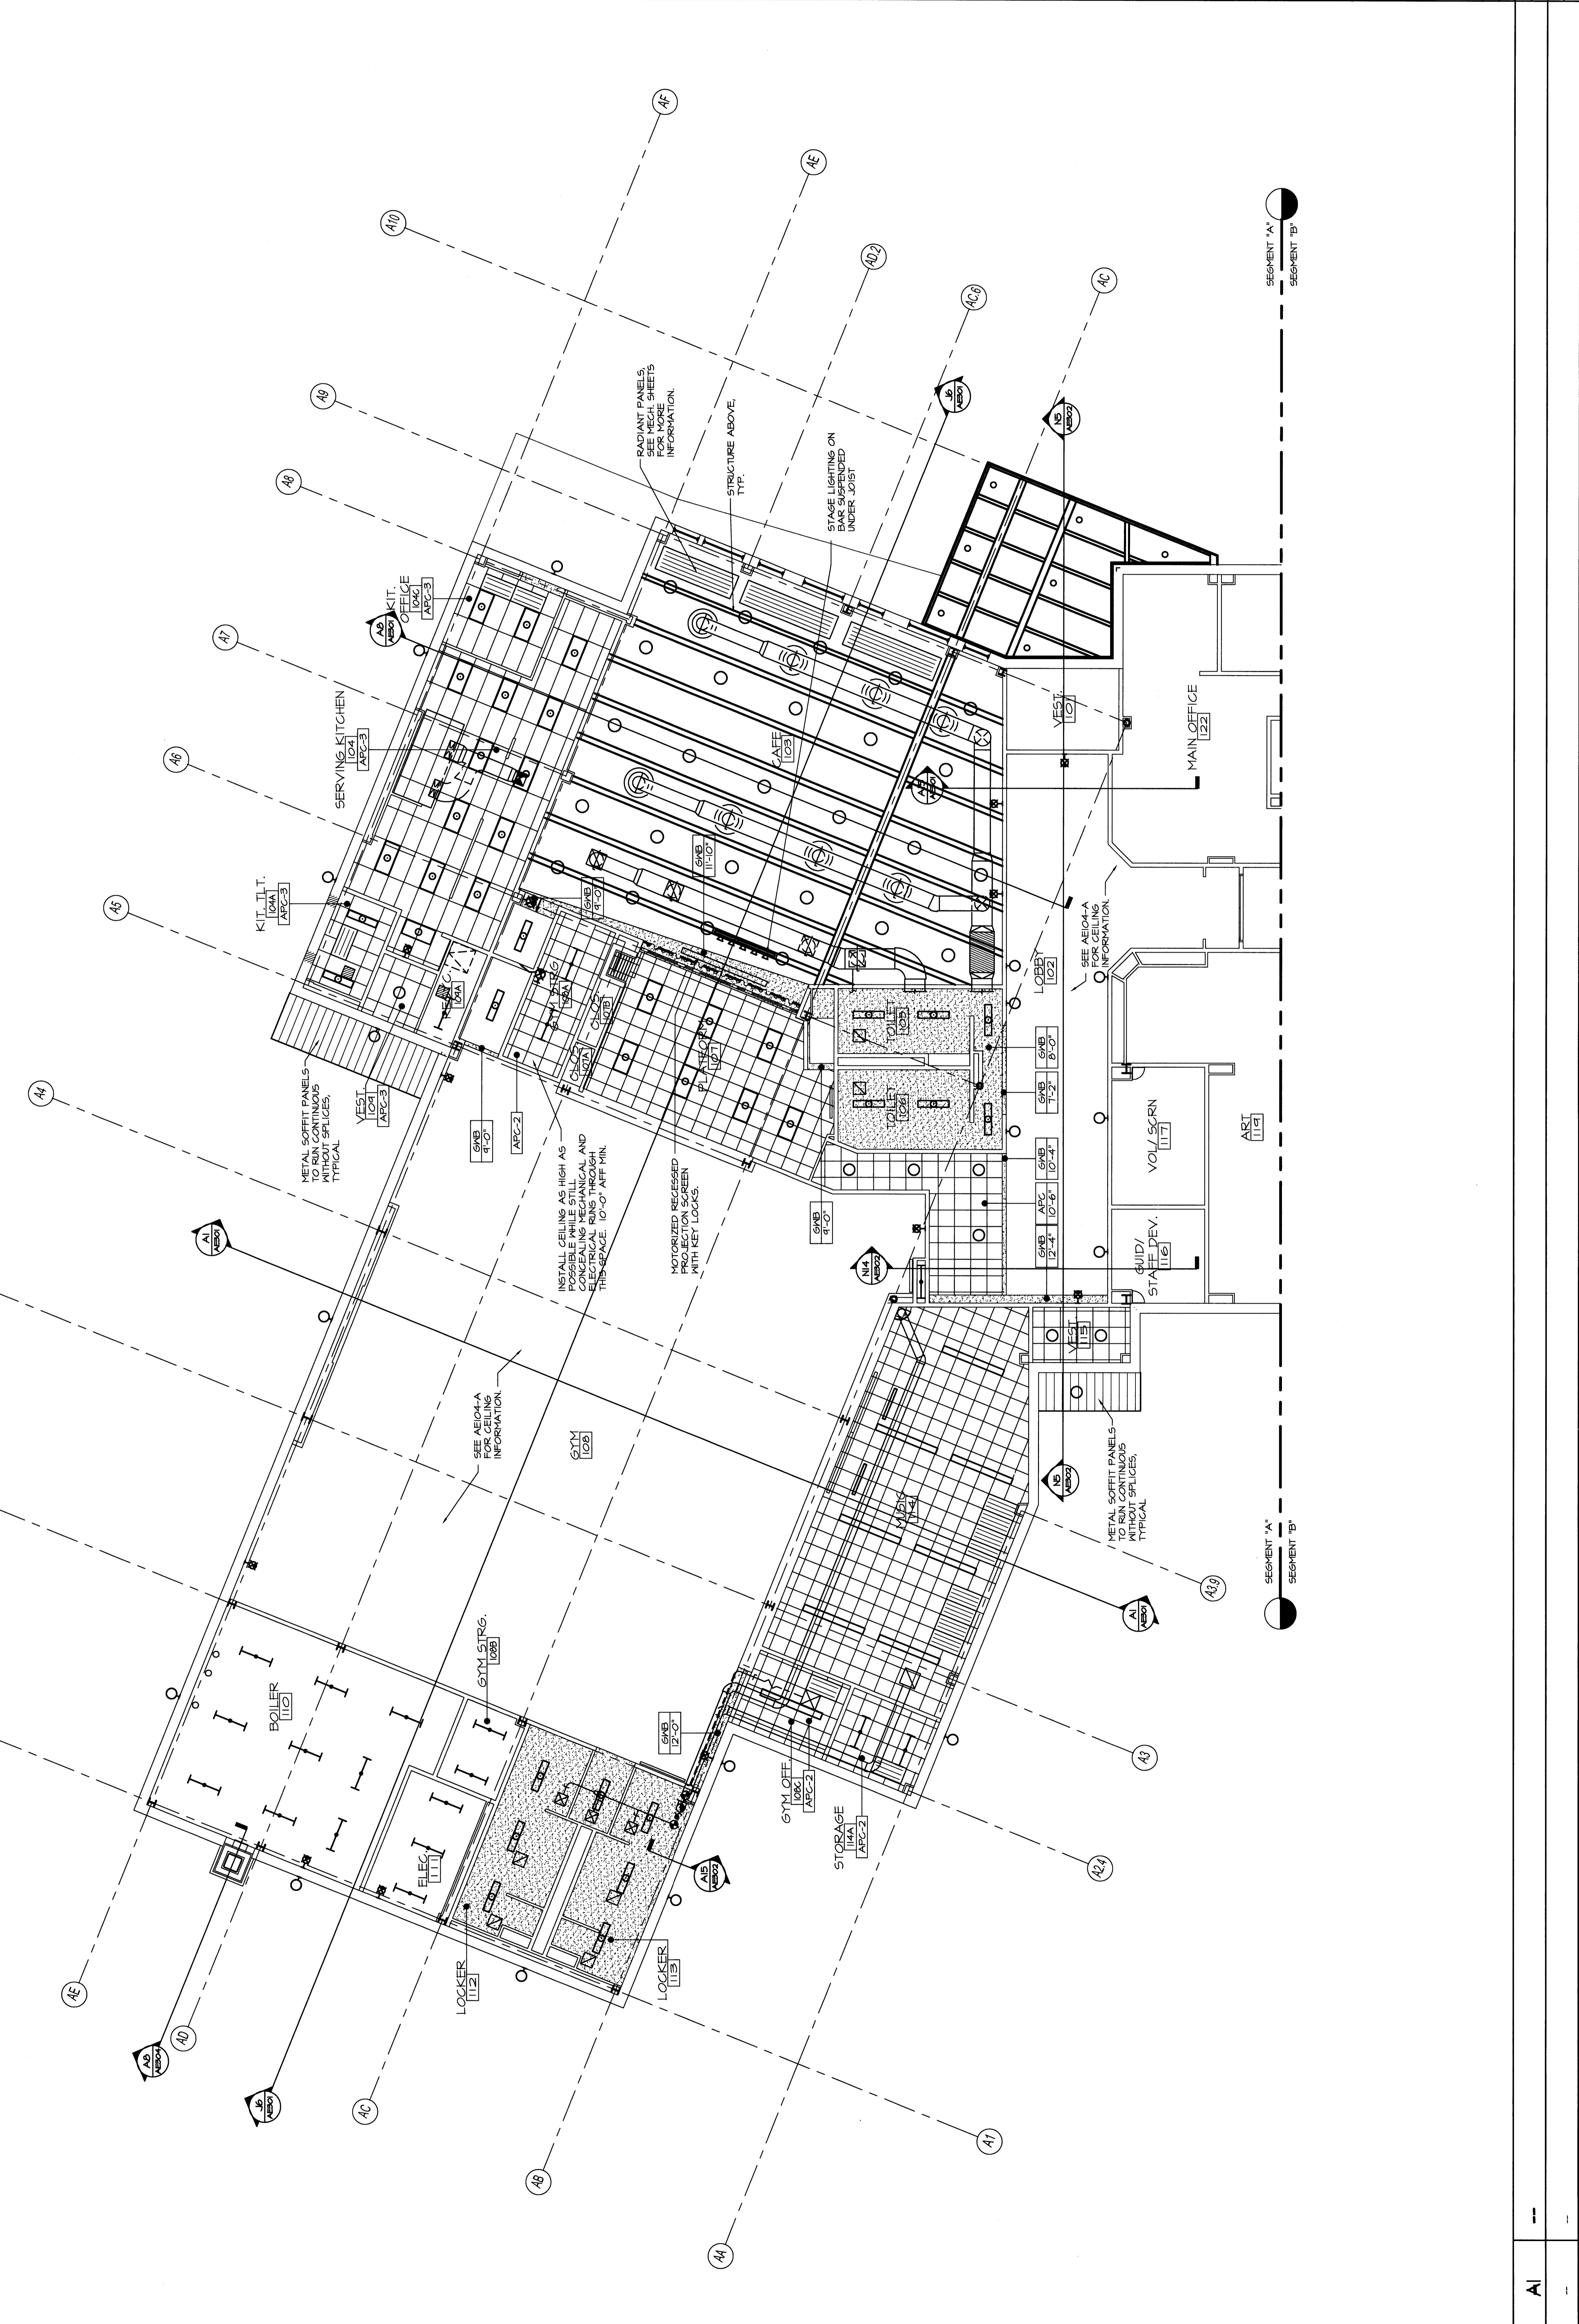


- CEILING LEGEND**
- ELECTRICAL SYMBOLS INDICATING LIGHTING LOCATIONS. REFER TO ELECTRICAL SHEETS FOR TYPE OF LIGHTING FIXTURES.
 - MECHANICAL SYMBOLS INDICATING SUPPLY DIFFUSER OR EXHAUST RETURN GRILLE. SEE SHEETS FOR SIZE / TYPE OF DIFFUSER / GRILLE.
 - MECHANICAL SYMBOL INDICATING RADIANT PANEL LOCATION. REFER TO SHEETS FOR SIZE / TYPE OF PANEL.
 - ACOUSTICAL PANEL CEILING 2'-0"x2'-0" & METAL SUSPENSION GRID.
 - ACOUSTICAL PANEL CEILING 2'-0"x4'-0" & METAL SUSPENSION GRID.
 - NEW 7% GYPSUM WALL BOARD CEILING OR SOFFIT.
 - PROJECTOR BRACKET (QSC). CONTRACTOR TO PROVIDE ABOVE. PROVIDE ESCUTCHEON RING WHERE BRACKET EXTENSION POLE PASSES THROUGH APC.

REV.	DESCRIPTION	DATE
0		00.00.00

PERMIT APPLICATION
SUBMISSION 3-18-09

CURRENT ISSUE STATUS:

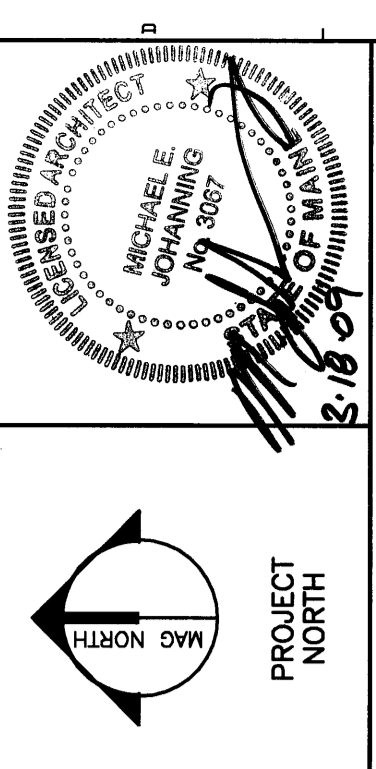

WBRC
ARCHITECTS - ENGINEERS
 100 WASHINGTON ST., SUITE 200
 PORTLAND, MAINE 04101-2000
 TEL: 603.761.1111 FAX: 603.761.1112

OCEAN AVENUE ELEMENTARY SCHOOL
 PORTLAND, ME

FIRST FLOOR REFLECTED CEILING PLAN SEG. A

SHEET TITLE	331610-AE103-A
WBRC JOB FILE	331610
SCALE	AS NOTED
PROJECT NUMBER	MEJ
DRAWN BY	MEJ
CHECKED BY	MEJ
SHEET NO.	1
PROJECT NAME	AE103-A