


- GENERAL CEILING PLAN NOTES:**
- REFER TO SHEET G1002 FOR ALL ABBREVIATIONS.
 - CONTRACTOR TO VERIFY LOCATION OF MAIN CEILING TEES BEFORE PROCEEDING WITH FIXTURE INSTALLATION. NOTIFY ARCHITECT OF INTERFERENCES.
 - NOTIFY ARCHITECT OF ANY DISCREPANCIES BETWEEN MECHANICAL/ELECTRICAL PLANS AND ELECTRICAL LIGHTING PLANS PRIOR TO CONSTRUCTION.
 - REFER TO ELECTRICAL PLANS FOR LOCATIONS OF STROBES AND EXIT SIGNS.
 - ALL CEILING GRILLES, TRIM EDGES AND SLOT DIFFUSERS TO MATCH ADJACENT CEILING COLOR.
 - ALL SPRINKLER HEADS TO OCCUR AT CENTER OF TILES.
 - LAYOUT TILES AS SHOWN IN REFLECTED CEILING PLANS.
 - REFER TO SPECIFICATION SECTION 09511 FOR ALL ACoustICAL PANEL CEILING TYPES.
 - ALL CEILINGS TO BE 9'-6" AFF. U.N.O.
 - WHERE NO CEILING MATERIAL IS SHOWN THE STRUCTURE ABOVE IS TO BE EXPOSED. U.N.O.
 - SEE EL SHEETS FOR CONTINUED LIGHTING INFORMATION.
 - SEE MH SHEETS FOR CONTINUED MECHANICAL INFORMATION.
 - ALL APC IS APC-1 U.N.O.

- CEILING LEGEND:**
- ELECTRICAL SYMBOLS INDICATING LIGHTING LOCATIONS. REFER TO EL SHEETS FOR TYPE OF LIGHTING FIXTURES.
 - MECHANICAL SYMBOLS INDICATING SUPPLY DIFFUSER OR EXHAUST FAN. REFER TO MH SHEETS FOR SIZE / TYPE OF DIFFUSER / GRILLE.
 - MECHANICAL SYMBOL INDICATING RADIANT PANEL LOCATION. REFER TO MH SHEETS FOR SIZE / TYPE OF PANEL.
 - ACOUSTICAL PANEL CEILING 2'-0"X2'-0" & METAL SUSPENSION GRID.
 - ACOUSTICAL PANEL CEILING 2'-0"X4'-0" & METAL SUSPENSION GRID.
 - NEW 3/8" GYPSUM WALL BOARD CEILING ON SOFFIT.
 - PROJECTOR BRACKET (OSCI).
 - PROJECTOR BRACKET (OSCI) MOUNTED TO STRUCTURE ABOVE. BRACKET EXTENSION POLE PASSES THROUGH APC, TYP. CENTER LOCATION. CONFIRM LOCATIONS WITH INTERIOR ELEVATIONS AND ELECTRICAL DRAWINGS.

REV.	DESCRIPTION	DATE
0		00.00.00

**PERMIT APPLICATION
SUBMISSION 3-18-09**

CURRENT ISSUE STATUS:

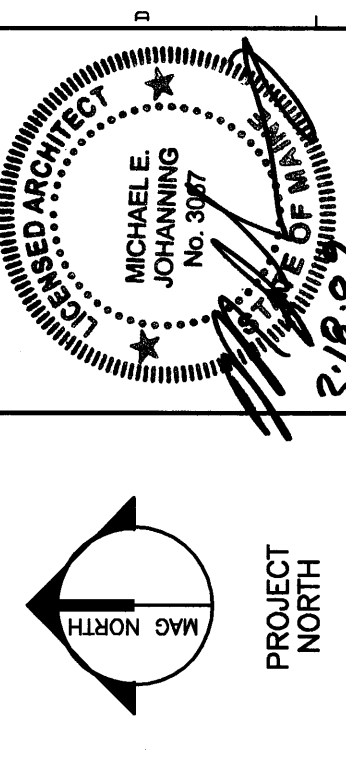

WBRC ARCHITECTS - ENGINEERS
 WALTER B. ROBERTSON & COMPANY ARCHITECTS, INC. 300-300
 PORTLAND, OREGON 97208

OCEAN AVENUE ELEMENTARY SCHOOL
 PORTLAND, ME

FIRST FLOOR REFLECTED CEILING PLAN SEG. C

SHEET TITLE: 331610-AE103-C

WBRC CAD FILE: 331610

PROJECT NO.: 331610

SCALE: AS NOTED

PROJECT MANAGER: MEJ

DRAWN BY: RAD

CHECKED BY: MEJ

SHEET NO.: AE103-C

