


- GENERAL CEILING PLAN NOTES:**
1. REFER TO SHEET G1002 FOR ALL ABBREVIATIONS
  2. CONTRACTOR TO VERIFY LOCATION OF MAIN ELECTRICAL PANELS AND COORDINATE WITH FIXTURE INSTALLATION. NOTIFY ARCHITECT OF INTERFERENCES.
  3. NOTIFY ARCHITECT OF ANY DISCREPANCIES BETWEEN ARCHITECTURAL REFLECTED CEILING PLANS AND ELECTRICAL LIGHTING PLANS PRIOR TO CONSTRUCTION.
  4. REFER TO ELECTRICAL PLANS FOR LOCATIONS OF STROBES AND EXIT SIGNS.
  5. ALL CEILING GRILLES, TRIM EDGES, AND SLOT DIFFUSERS TO MATCH ADJACENT CEILING COLOR.
  6. ALL SPRINKLER HEADS TO OCCUR AT CENTER OF TILES.
  7. LAYOUT TILES AS SHOWN IN REFLECTED CEILING PLANS.
  8. REFER TO SPECIFICATION SECTION 09511 FOR ALL ACOUSTICAL PANEL CEILING TYPES.
  9. ALL CEILINGS TO BE 9'-6" A.F.F. U.N.O.
  10. WHERE NO CEILING MATERIAL IS SHOWN, THE STRUCTURE ABOVE IS TO BE EXPOSED U.N.O.
  11. SEE EL SHEETS FOR CONTINUED LIGHTING INFORMATION.
  12. SEE MH SHEETS FOR CONTINUED MECHANICAL INFORMATION.
  13. ALL APC IS APC-1 U.N.O.

- CEILING LEGEND:**
- ELECTRICAL SYMBOLS INDICATING LIGHTING LOCATIONS. REFER TO EL SHEETS FOR SIZE / TYPE OF LIGHTING FIXTURES.
  - MECHANICAL SYMBOLS INDICATING EXHAUST/RETURN GRILLE LOCATIONS. REFER TO MH SHEETS FOR SIZE / TYPE OF DIFFUSER / GRILLE.
  - MECHANICAL SYMBOLS INDICATING RADIANT PANEL LOCATION. REFER TO MP SHEETS FOR SIZE / TYPE OF PANEL.
  - ACOUSTICAL PANEL CEILING 2'-0"X2'-0" & METAL SUSPENSION GRID.
  - ACOUSTICAL PANEL CEILING 2'-0"X2'-0" & METAL SUSPENSION GRID.
  - NEW 5/8" GYPSUM WALL BOARD CEILING OR SOFFIT.
  - PROJECTOR BRACKET (OS/CI) MOUNTED TO STRUCTURE ABOVE CEILING OR TO PROBE SCROUCHER TO LONG WHERE BRACKET EXTENSION POLE PASSES THROUGH APC.

REV.	DESCRIPTION	DATE
0		09/03/09

**PERMIT APPLICATION**  
**SUBMISSION 3-18-09**  
CURRENT ISSUE STATUS:

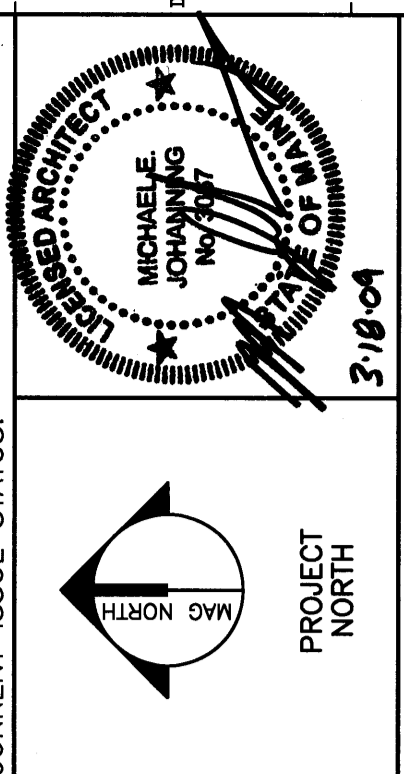


**WBRC**  
ARCHITECTS • ENGINEERS  
WWW.WBRCORC.COM  
100 WASHINGTON STREET, SUITE 200  
PORTLAND, ME 04101-2000  
TEL: 603.733.1100  
FAX: 603.733.1101

OCEAN AVENUE ELEMENTARY SCHOOL  
PORTLAND, ME

SECOND FLOOR REFLECTED CEILING PLAN SEG. A

SHEET TITLE:	331610-AE104-A
WBRC JOB FILE:	331610
SCALE:	AS NOTED
PROJECT NUMBER:	MEJ
DRAWN BY:	RAJ
CHECKED BY:	MEJ
SHEET NO.:	AE104-A

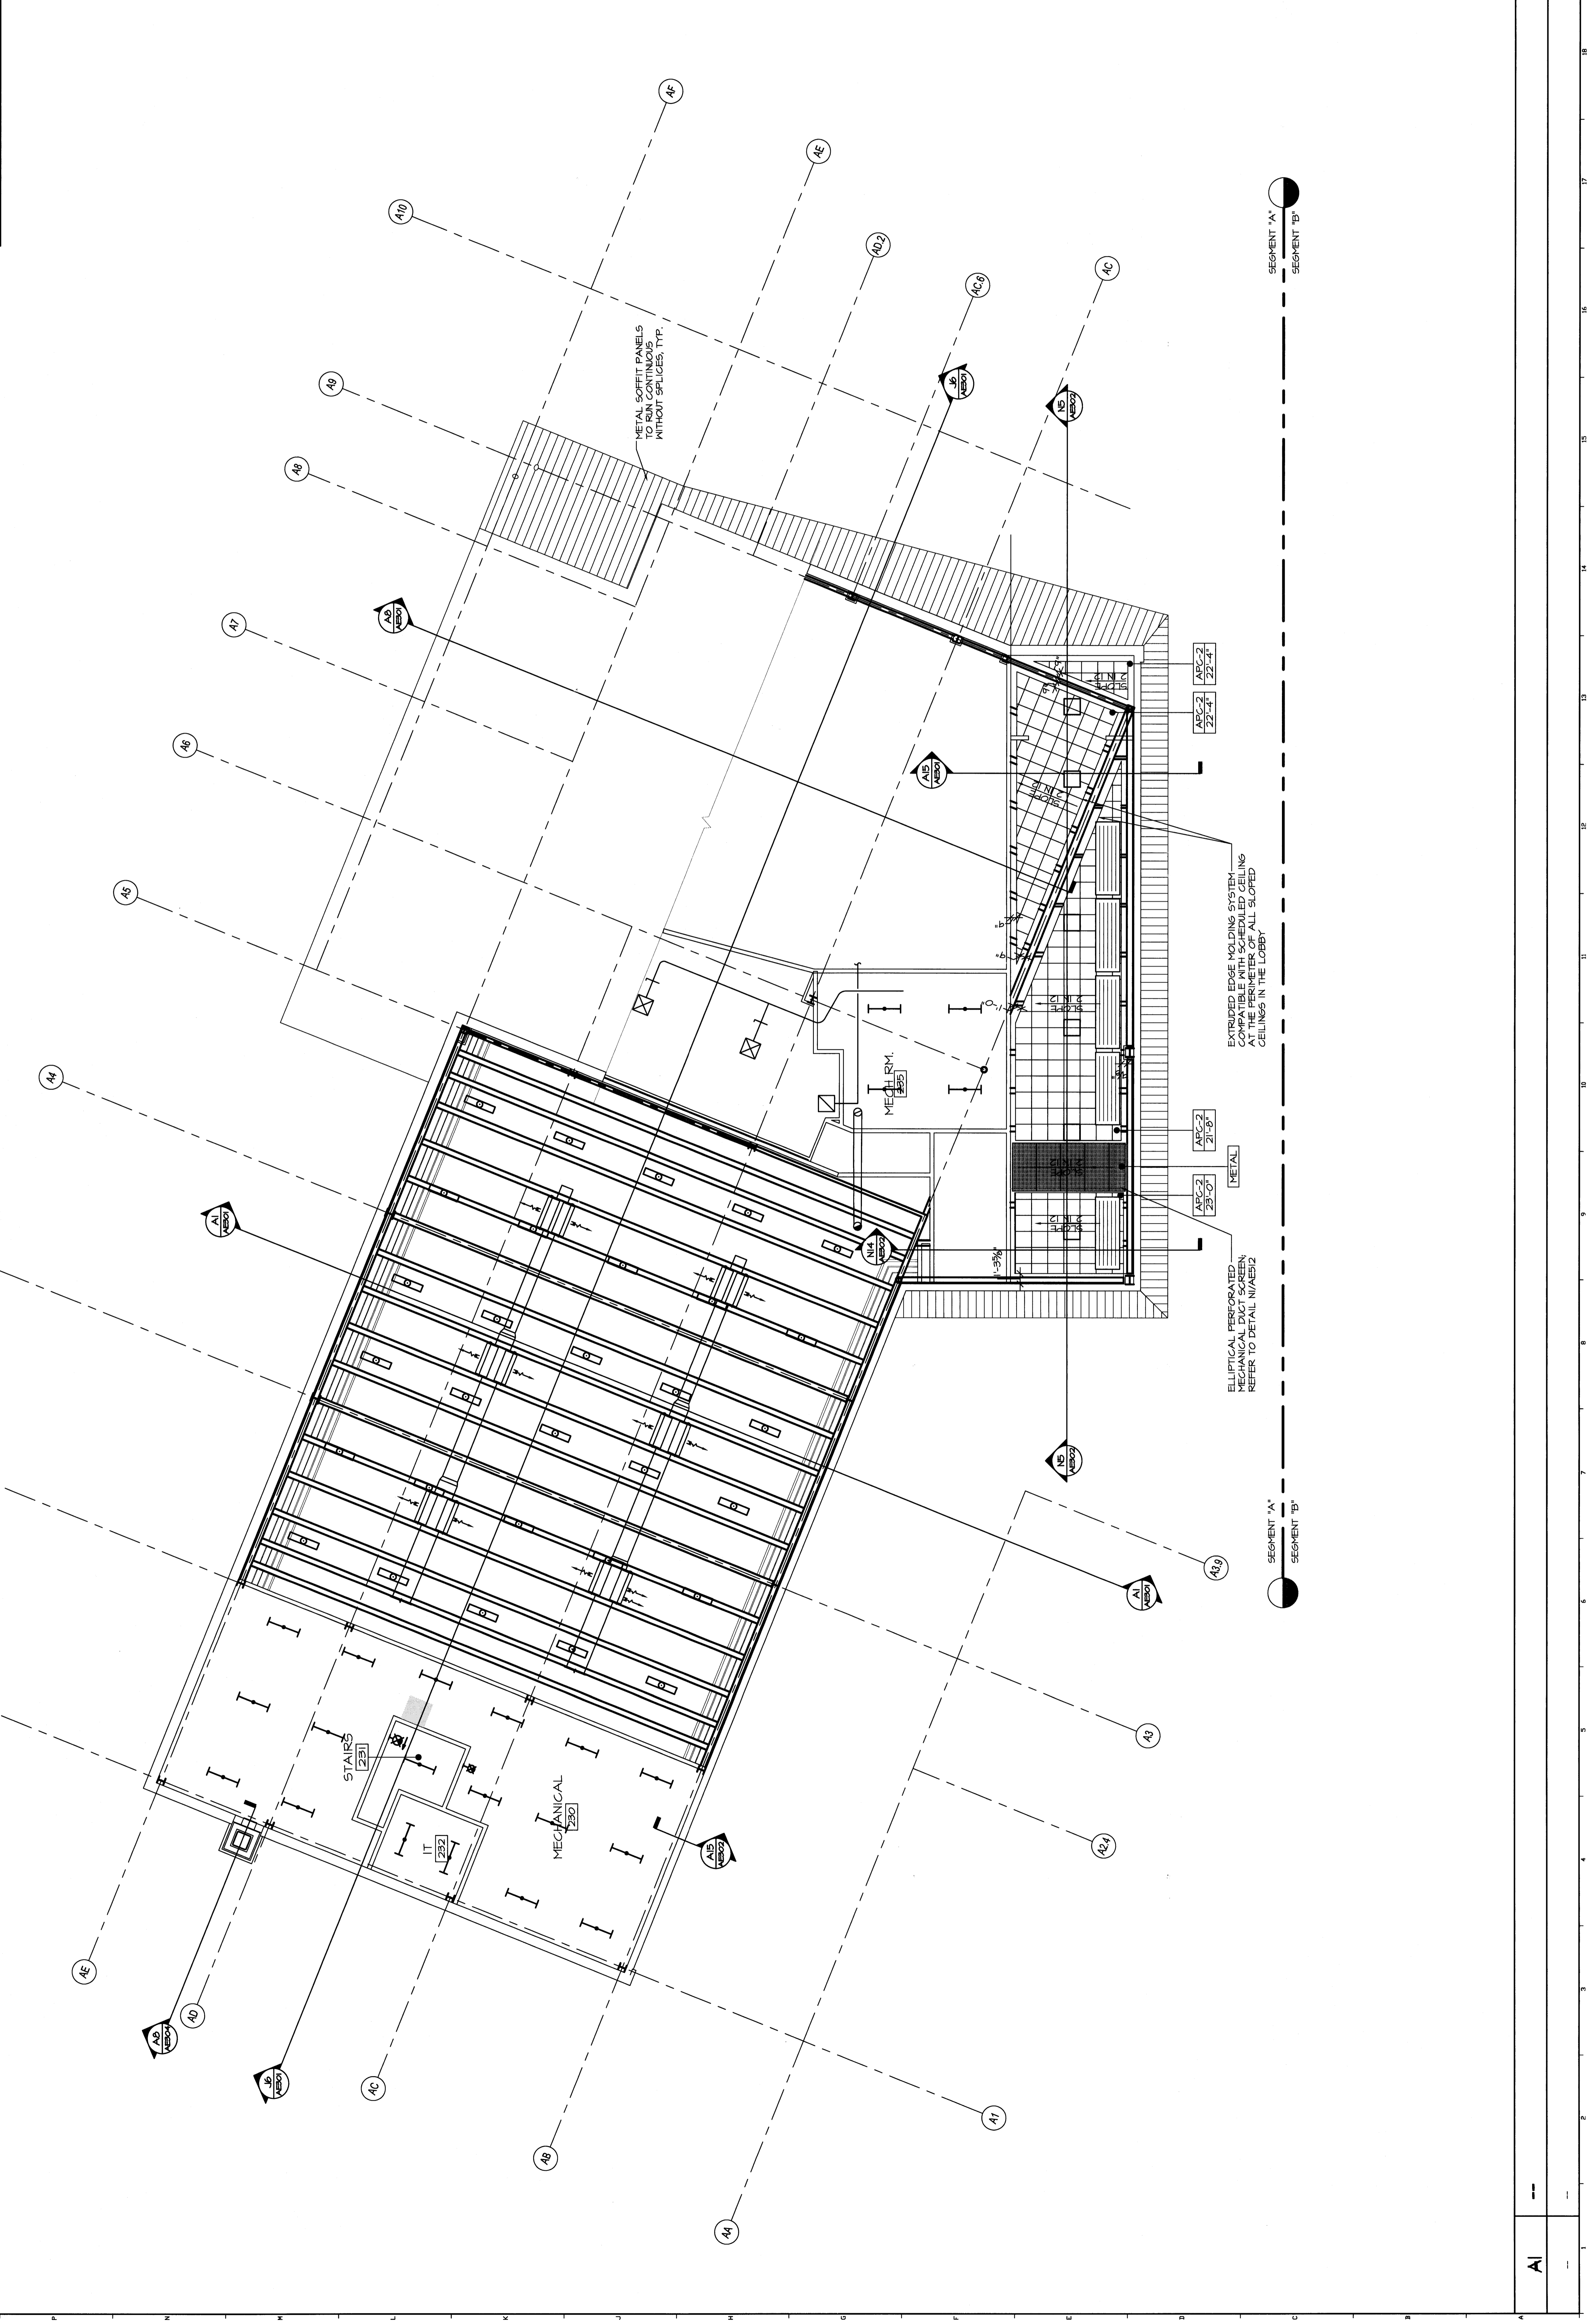

AI