

GENERAL CEILING PLAN NOTES
1. REFER TO SHEET G1002 FOR ALL ABBREVIATIONS.
2. CONTRACTOR TO VERIFY LOCATION OF MAIN CEILING TEES BEFORE PROCEEDING WITH FIXTURE INSTALLATION. NOTIFY ARCHITECT OF ANY INTERFERENCES.
3. NOTIFY ARCHITECT OF ANY DISCREPANCIES BETWEEN ARCHITECTURAL REFLECTED CEILING PLAN AND ELECTRICAL SYMBOLS PRIOR TO CONSTRUCTION.
4. REFER TO ELECTRICAL PLANS FOR LOCATIONS OF STROBES AND EXIT SIGNS.
5. ALL CEILING GRILLES, TRIM EDGES, AND SLOT DIFFUSERS TO MATCH ADJACENT CEILING COLOR.
6. ALL SPRINKLER HEADS TO OCCUR AT CENTER OF TILES.
7. LAYOUT TILES AS SHOWN IN REFLECTED CEILING PLANS.
8. REFER TO SPECIFICATION SECTION 09511 FOR ALL ACOUSTICAL PANEL CEILING TYPES.
9. ALL CEILINGS TO BE 9'6" A.F.F. U.N.O.
10. WHERE NO CEILING MATERIAL IS SHOWN THE STRUCTURE ABOVE IS TO BE EXPOSED. U.N.O.
11. SEE EL SHEETS FOR CONTINUED LIGHTING INFORMATION.
12. SEE MH SHEETS FOR CONTINUED MECHANICAL INFORMATION.
13. ALL APC'S APC-1 U.N.O.

CEILING LEGEND
ELECTRICAL SYMBOLS INDICATING LIGHTING LOCATIONS. REFER TO ELECTRICAL SHEETS FOR TYPE OF LIGHTING FIXTURES.
MECHANICAL SYMBOLS INDICATING SUPPLY DIFFUSER OR EXHAUST/RETURN GRILLE. REFER TO SHEETS FOR SIZE / TYPE OF DIFFUSER / GRILLE.
MECHANICAL SYMBOL INDICATING RADIANT PANEL LOCATION. REFER TO SHEETS FOR SIZE / TYPE OF PANEL.
ACOUSTICAL PANEL CEILING 2'-0"x2'-0" & METAL SUSPENSION GRID.
ACOUSTICAL PANEL CEILING 2'-0"x4'-0" & METAL SUSPENSION GRID.
NEW 1/2" GYPSUM WALL BOARD CEILING OR SUPPLY.
PROJECTOR BRACKET (OSCI) TO BE MOUNTED ABOVE CEILING. PROVIDE ESCUTCHEON RING WHERE BRACKET EXTENSION POLE PASSES THROUGH P.C.

REV.	DESCRIPTION	DATE
0		00.00.00

PERMIT APPLICATION
SUBMISSION 3-18-09
CURRENT ISSUE STATUS:



WBRC
ARCHITECTS - ENGINEERS
2183 STATE ST. PORTLAND, ME 04102
PHONE: 603.761.1100
FAX: 603.761.1101
WWW.WBRC-MAINE.COM


OCEAN AVENUE ELEMENTARY SCHOOL
PORTLAND, ME

SECOND FLOOR REFLECTED CEILING PLAN SEG. C

SHEET TITLE: SECOND FLOOR REFLECTED CEILING PLAN SEG. C
WBRC JOB FILE: 331610-AE104-C
SCALE: AS NOTED
PROJECT NUMBER: MEJ
DRAWN BY: MEJ
CHECKED BY: MEJ

16 17 18 19 20

1 2 3 4 5 6 7 8 9 10 11 12 13 14 15 16 17 18 19 20

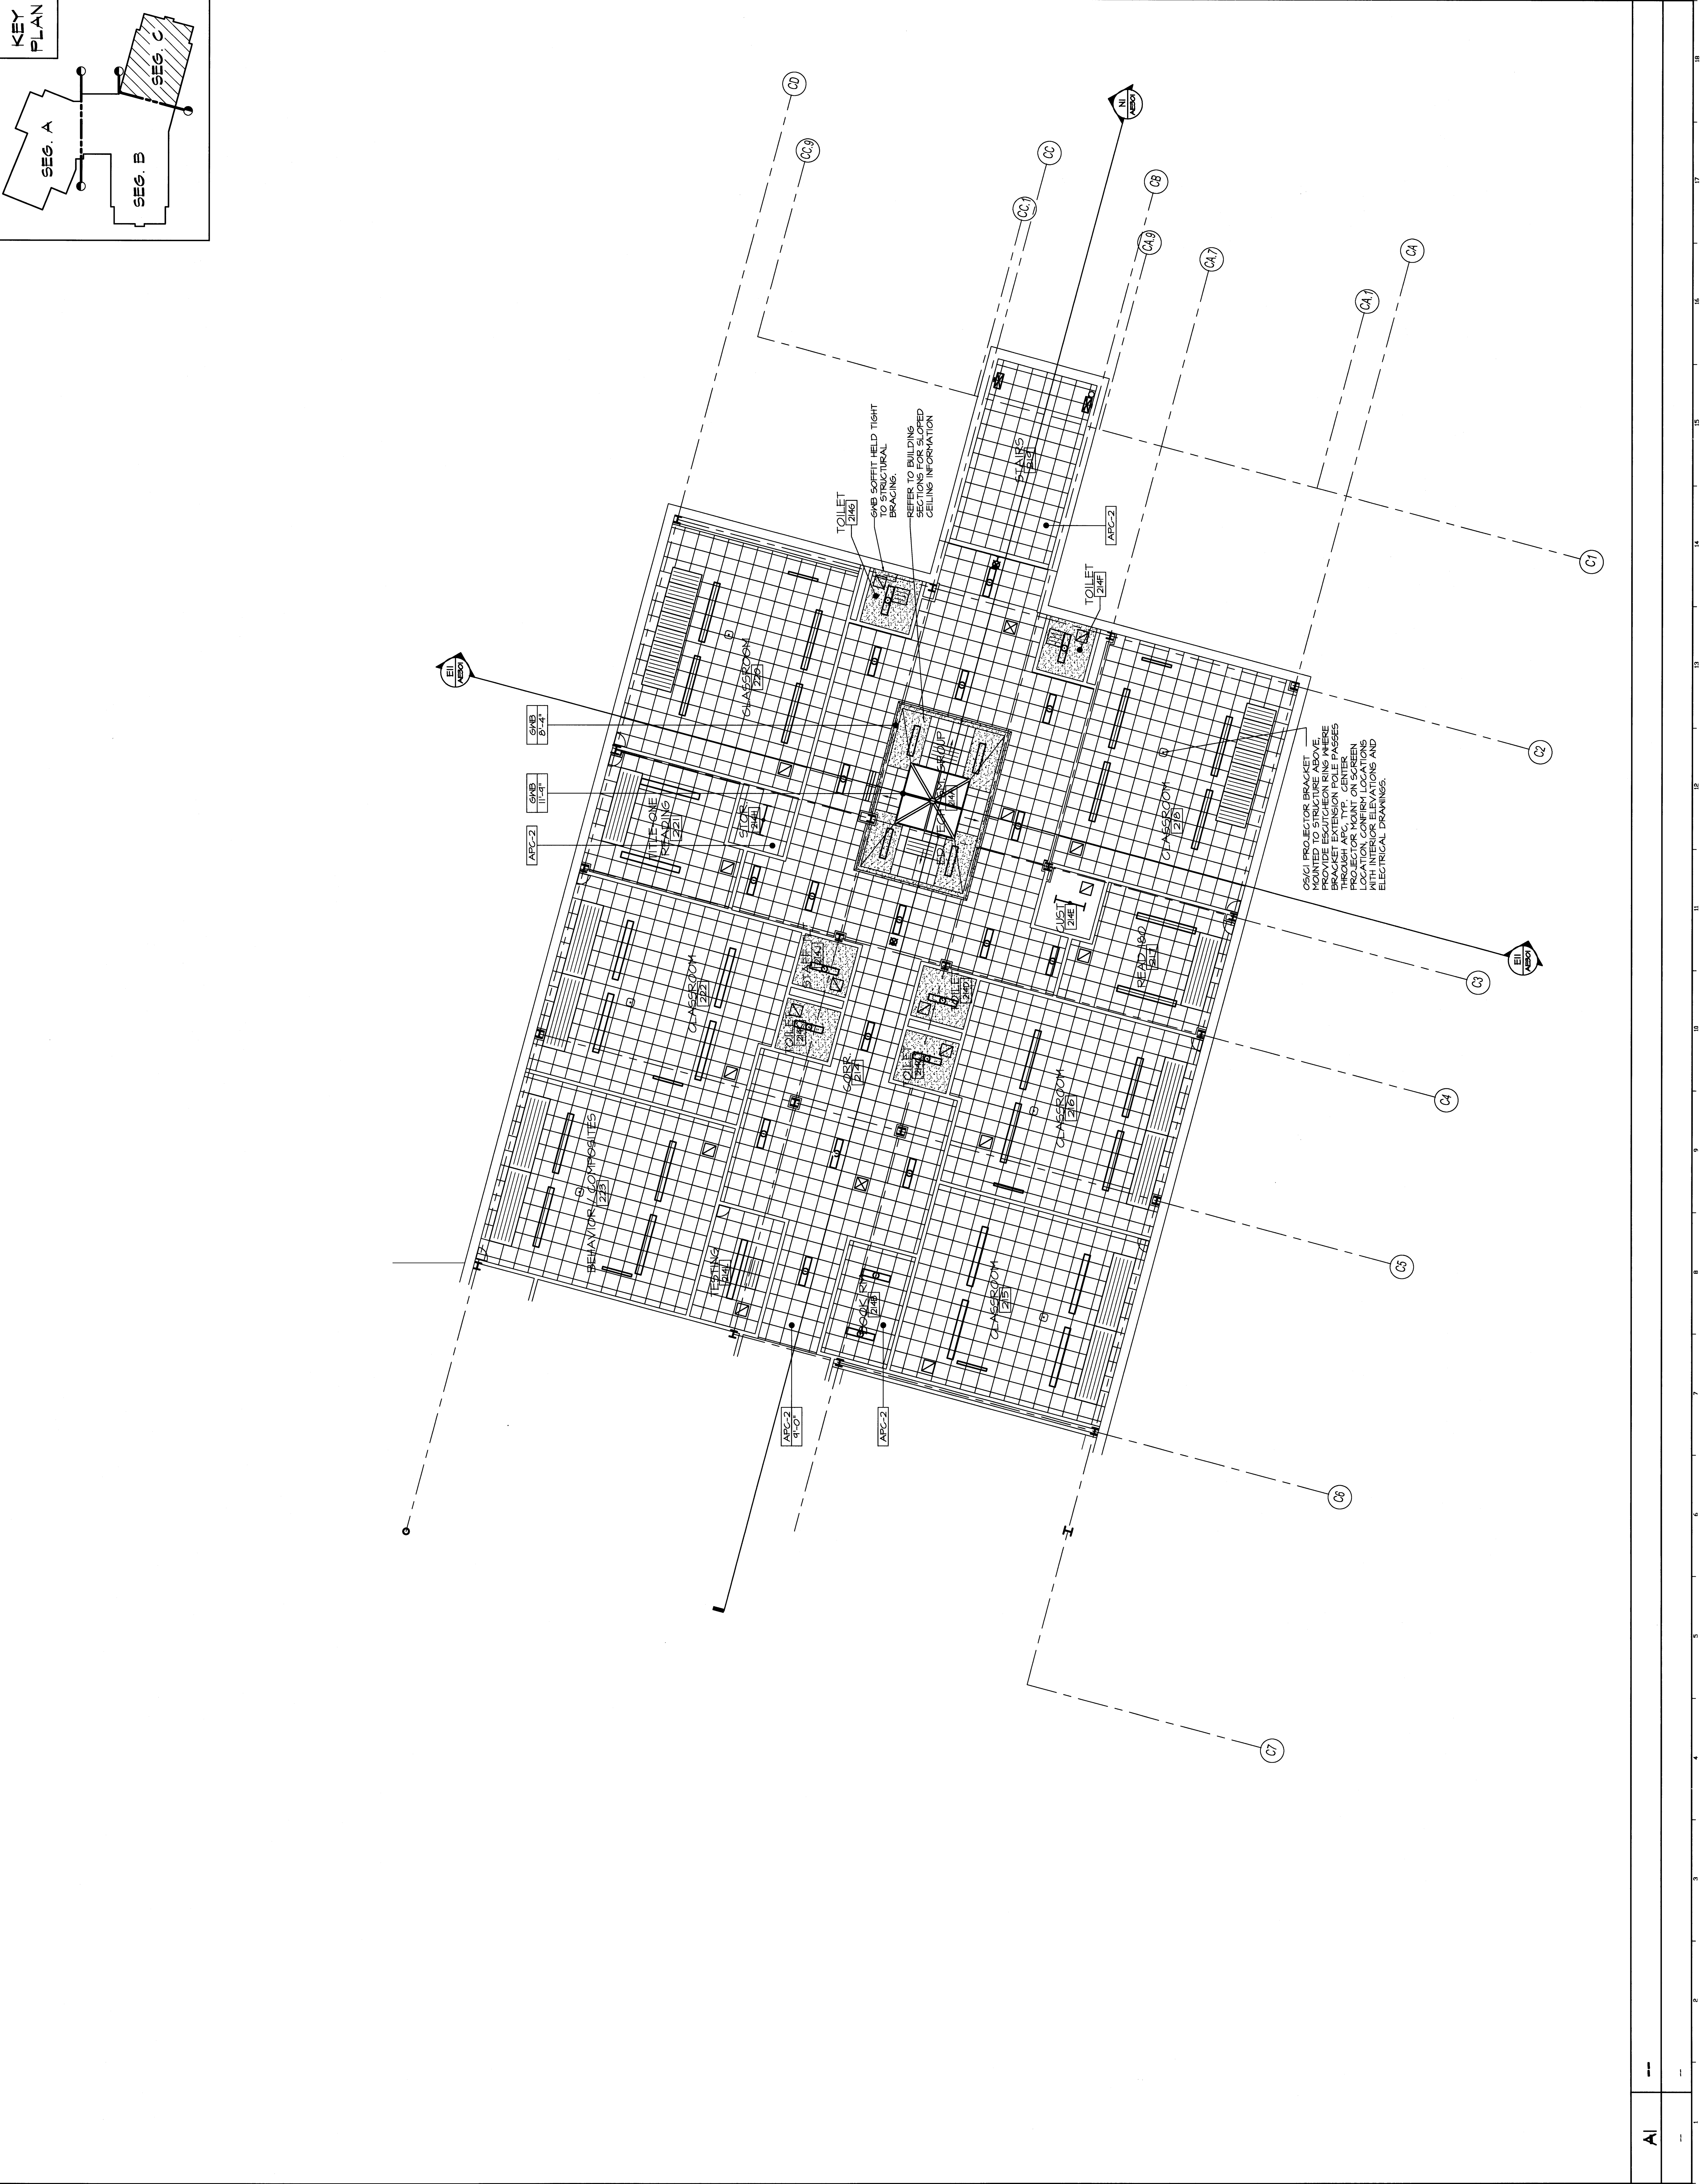

16 17 18 19 20

1 2 3 4 5 6 7 8 9 10 11 12 13 14 15 16 17 18 19 20