




**GENERAL NOTES:**  
 1. REFER TO PLUMBING FIXTURE CONNECTION SCHEDULE FOR TYPING SIZES TO INDIVIDUAL FIXTURES.

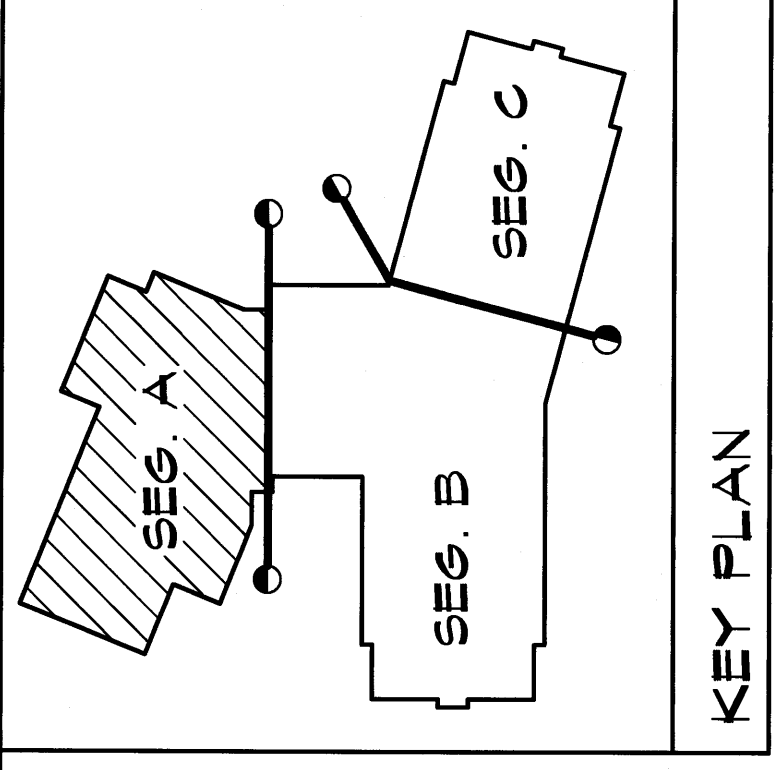

KEY PLAN

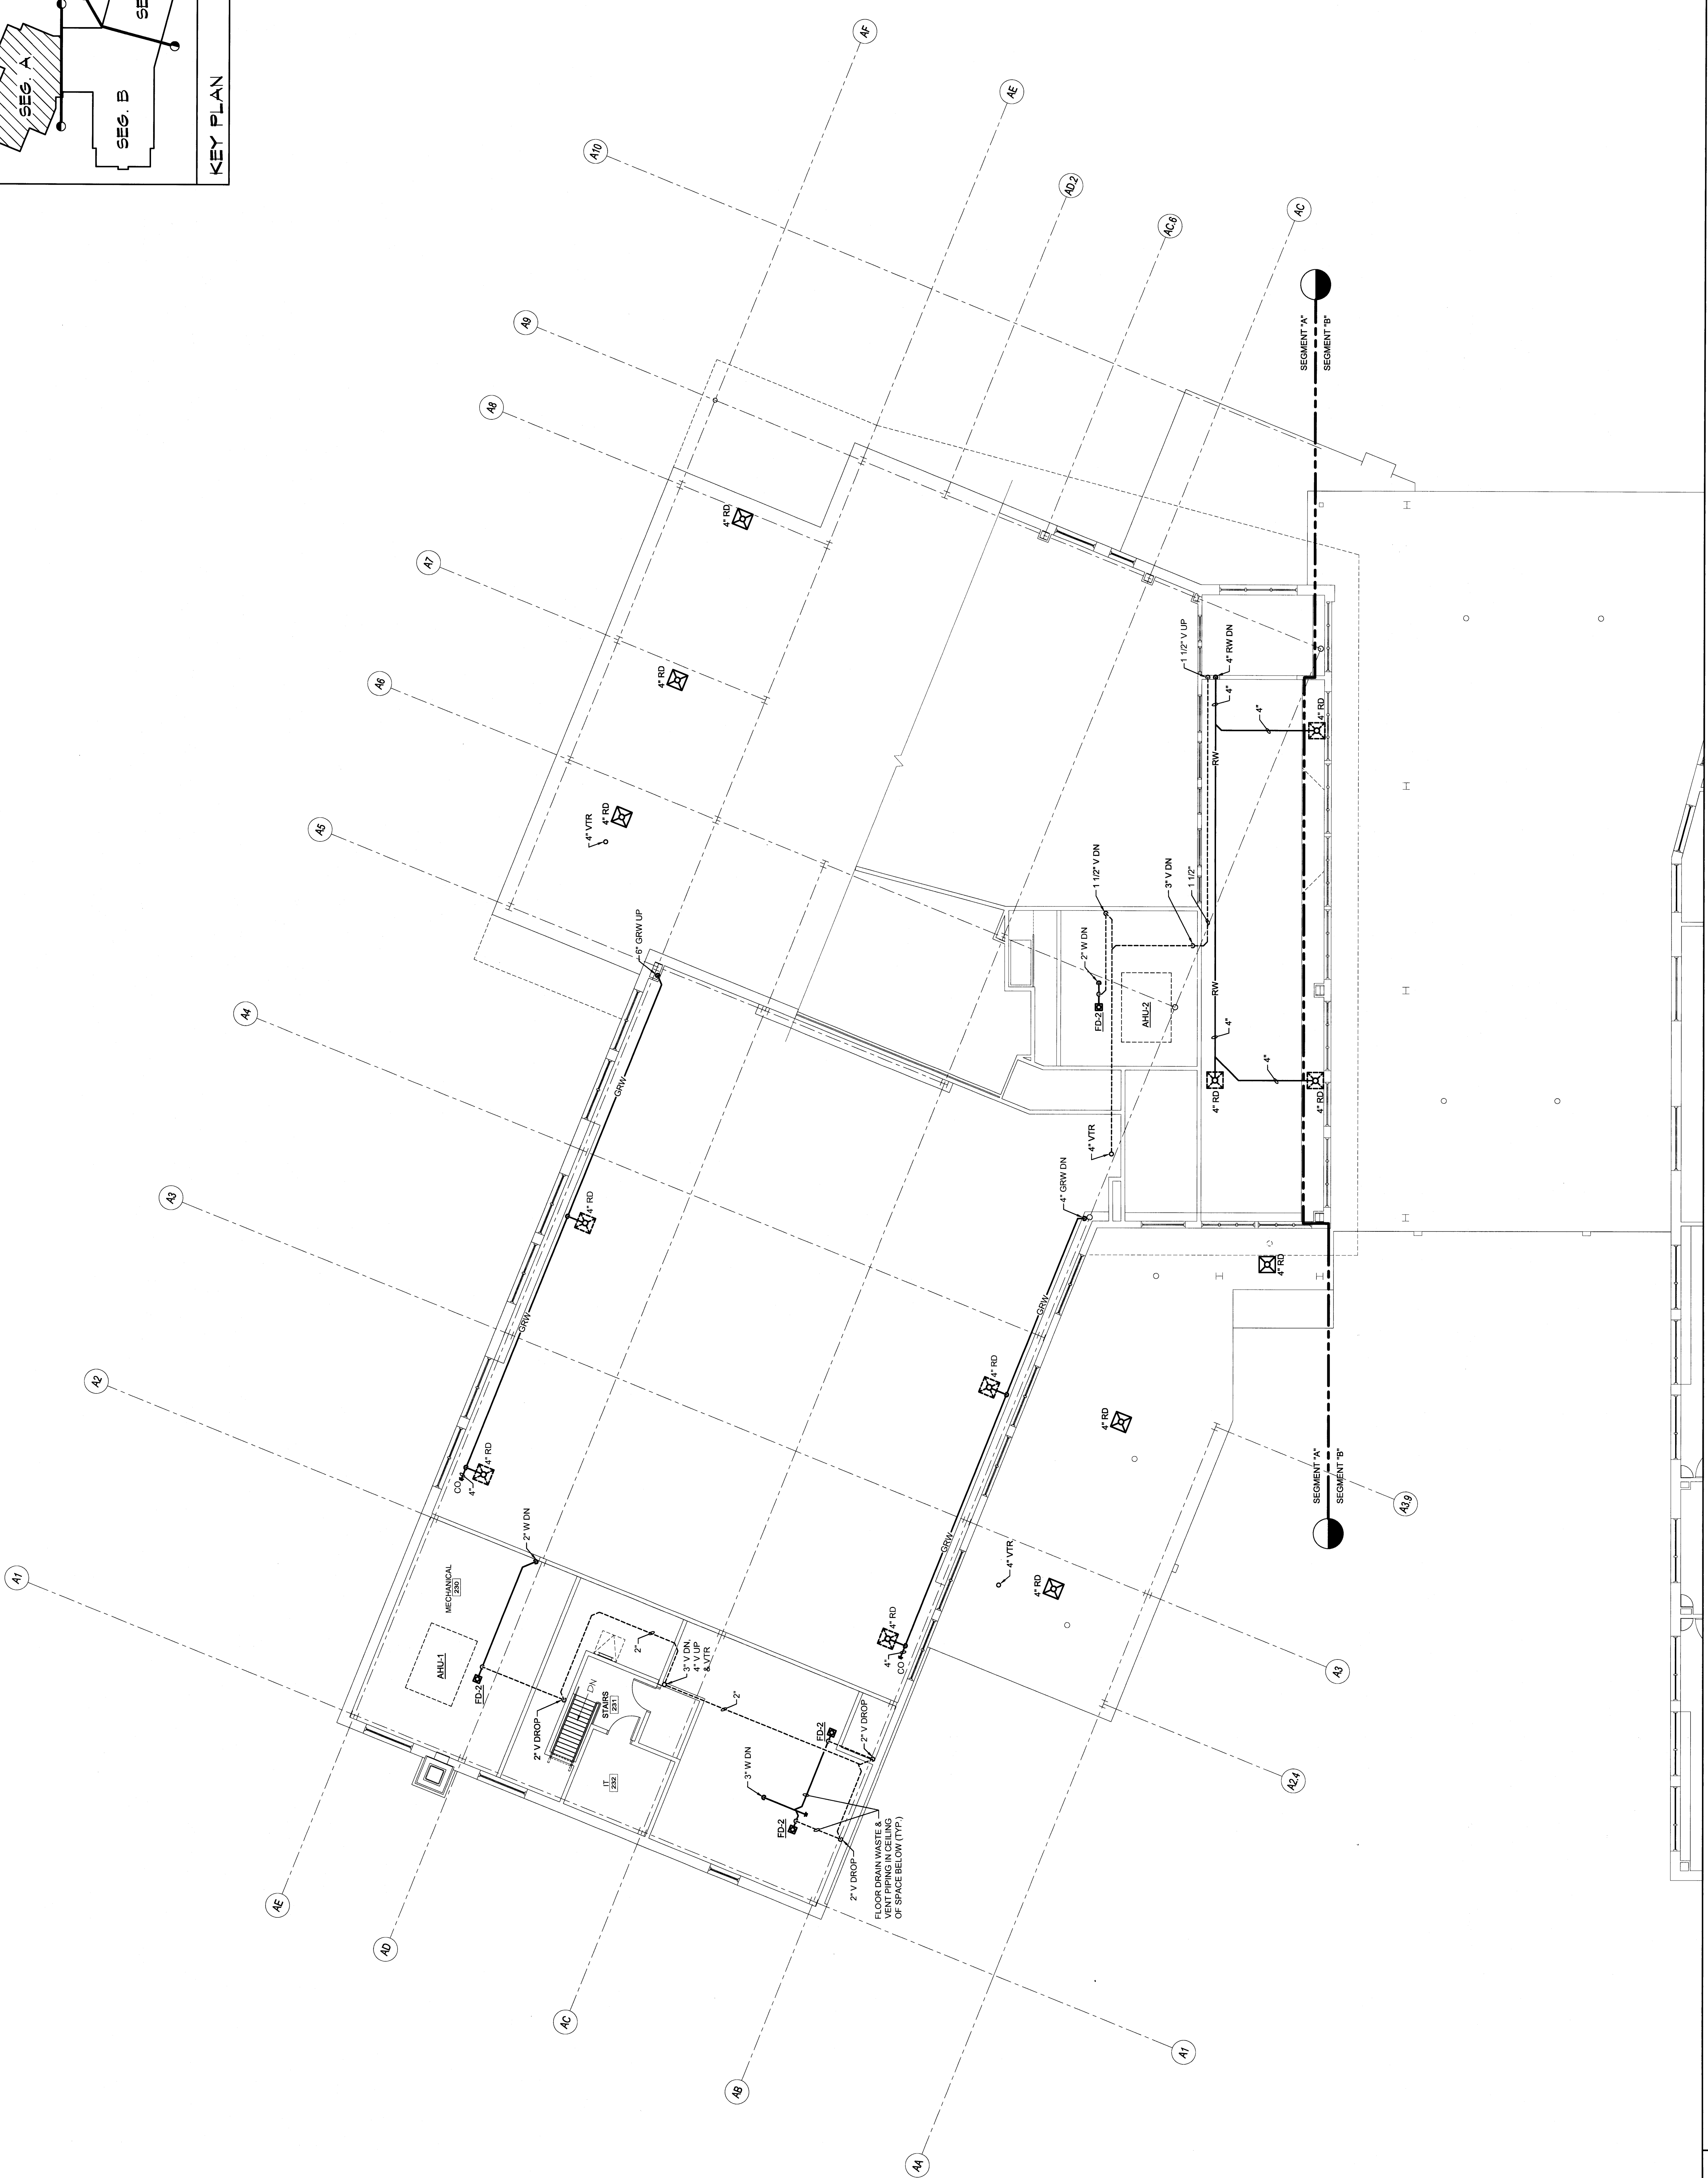

REV. DESCRIPTION DATE  
 0 00100.00  
**PERMIT APPLICATION**  
**SUBMISSION 3-18-09**  
 CURRENT ISSUE STATUS:

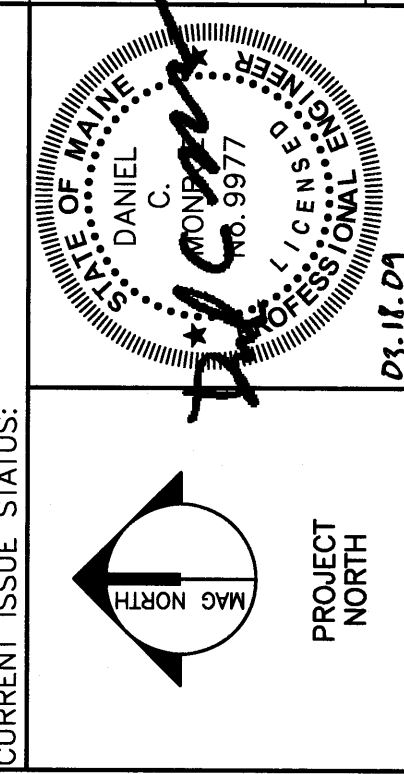

**WBRC**  
 ARCHITECTS • ENGINEERS  
 1000 WASHINGTON ST.  
 SUITE 200  
 PORTLAND, ME 04101  
 WWW.WBRC.COM

PROJECT: NORTH  
 PROJECT MGR: M.E.J.  
 PROJECT: OCEAN AVENUE ELEMENTARY SCHOOL  
 PORTLAND, ME

PROJECT: SECOND FLOOR SANITARY WASTE & VENT PLAN - SEG. A

SHEET TITLE: 331610-PL102-A  
 PROJECT No.: 331610 DRAWING SCALE: 0'  
 SCALE: 1/8" = 1'-0" SHEET No.:  
 PROJECT MANAGER: M.E.J. LAC  
 DRAWN BY: LAC  
 CHECKED BY: DMON

A1 SECOND FLOOR SANITARY WASTE & VENT PLAN - SEG. A

1/8" = 1'-0"