
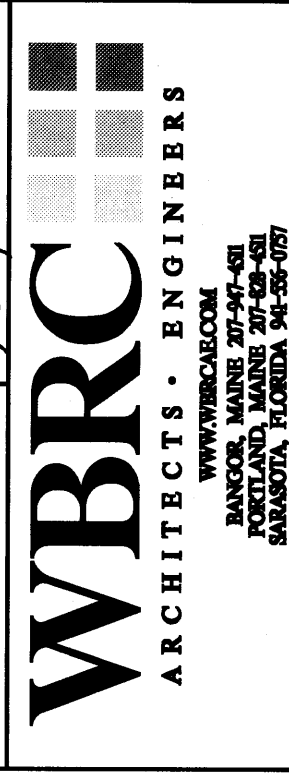


- GENERAL NOTES:**
- REFER TO PLUMBING FIXTURE CONNECTION SCHEDULES TO IDENTIFY INDIVIDUAL FIXTURES.
 - PROVIDE SHOCK ABSORBERS AT ALL CW BRANCHES TO FLUSH VALVES.
 - PROVIDE SHOCK ABSORBERS AT ALL HW BRANCHES TO TOILET ROOMS W/ SENSOR FAUCETS.

- TECHNICAL NOTES:**
- EXPOSED STRUCTURE, NO CEILING IN MECHANICAL ROOMS. ALL EXPOSED UTILITIES REFLECTED CEILING PLANS. INTENT IS FOR EXPOSED UTILITIES TO BE PAINTED. PAINTING BY OTHERS. REFER TO DWG. 9.
 - 1/2" PEAX TUBING DROPS IN WALL. CANNOT BE INSTALLED THROUGH WALLS. TUBING UNDERSLAB TO EACH FLOOR. DRAIN & FLOOR SINK.
 - CURB. SEE STRUCTURAL.

REV.	DESCRIPTION	DATE
0		00/00/00


PERMIT APPLICATION
SUBMISSION 3-18-09
CURRENT ISSUE STATUS:

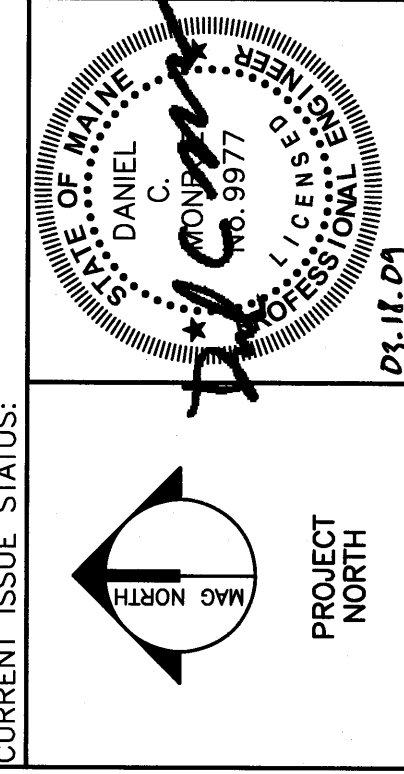

PROJECT:
OCEAN AVENUE ELEMENTARY SCHOOL
PORTLAND, ME

SECOND FLOOR DOMESTIC WATER PLAN - SEG. A

SHEET TITLE:	331610-PL122-A
PROJECT NO.:	331610
DATE:	1/8" = 1'-0"
PROJECT MANAGER:	MJC
DRAWN BY:	LAC
CHECKED BY:	DMON
SHEET NO.:	1
TOTAL SHEETS:	1

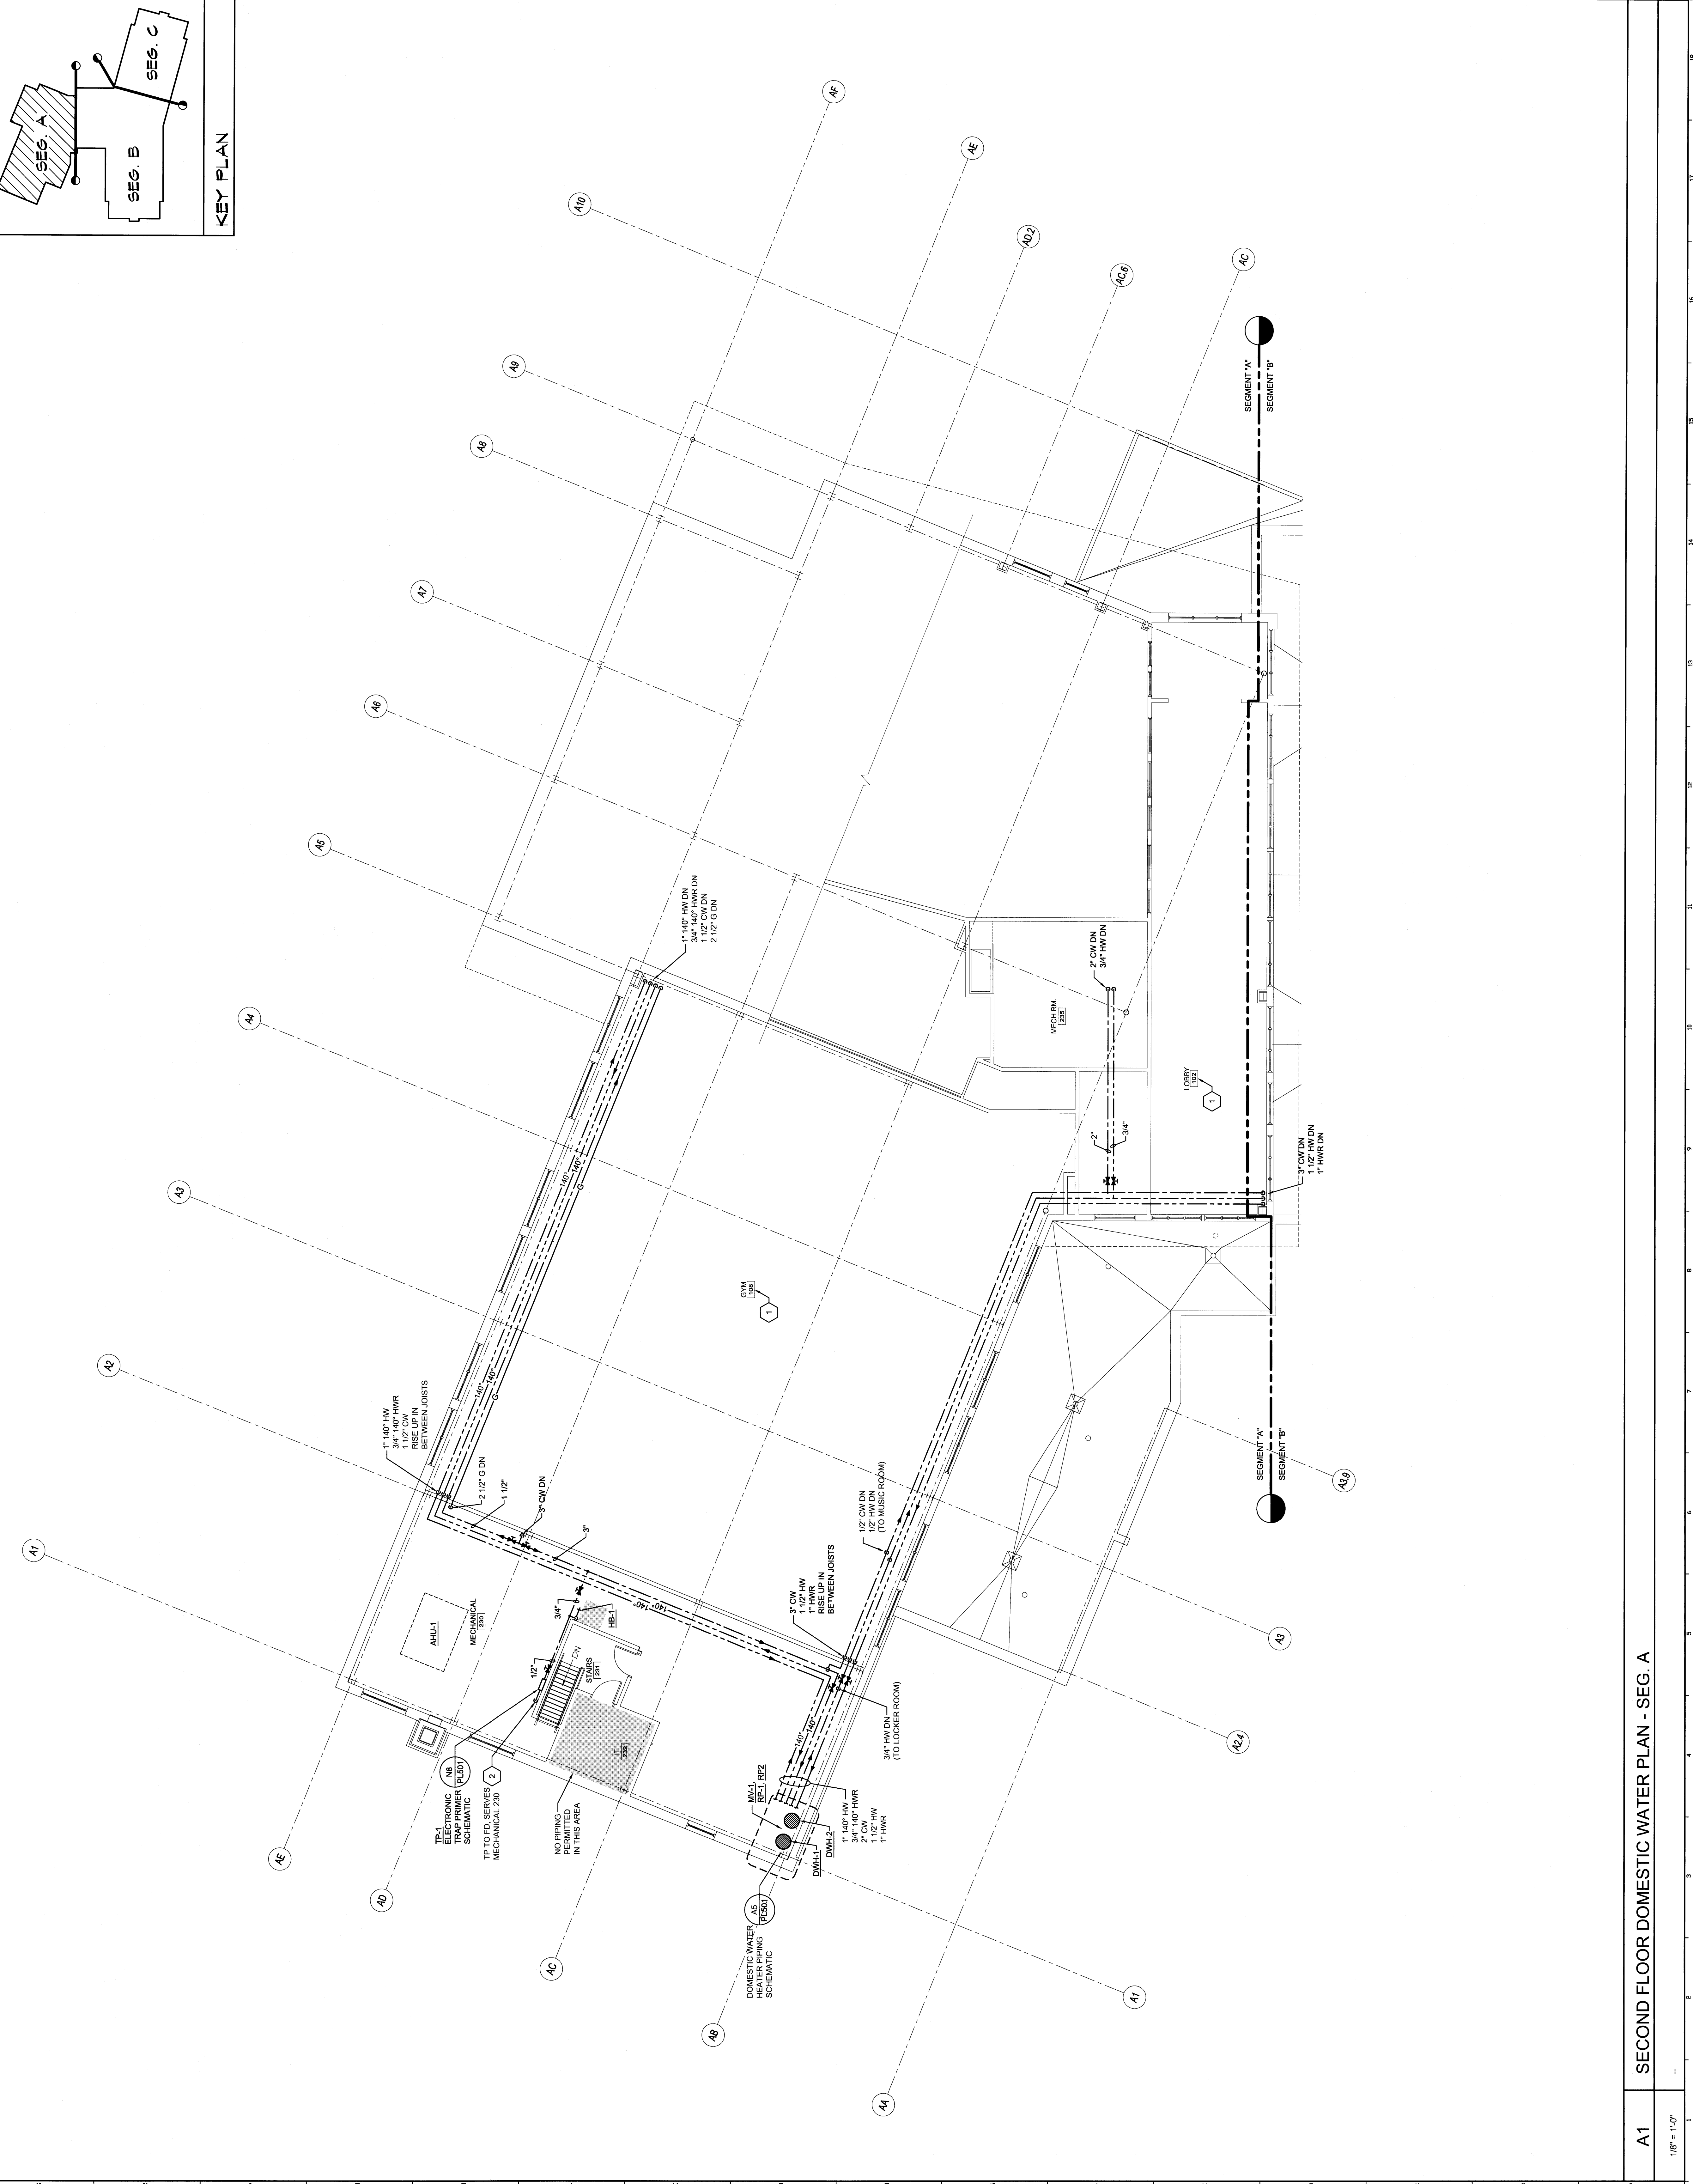

A1 SECOND FLOOR DOMESTIC WATER PLAN - SEG. A

1/8" = 1'-0"