


A1 FIRST FLOOR MECHANICAL DUCTWORK PLAN - SEG. C

1/8" = 1'-0"



TECHNICAL NOTES:
 (1) ELECTRICAL SPACE, NO DUCTWORK PERMITTED IN THIS AREA.

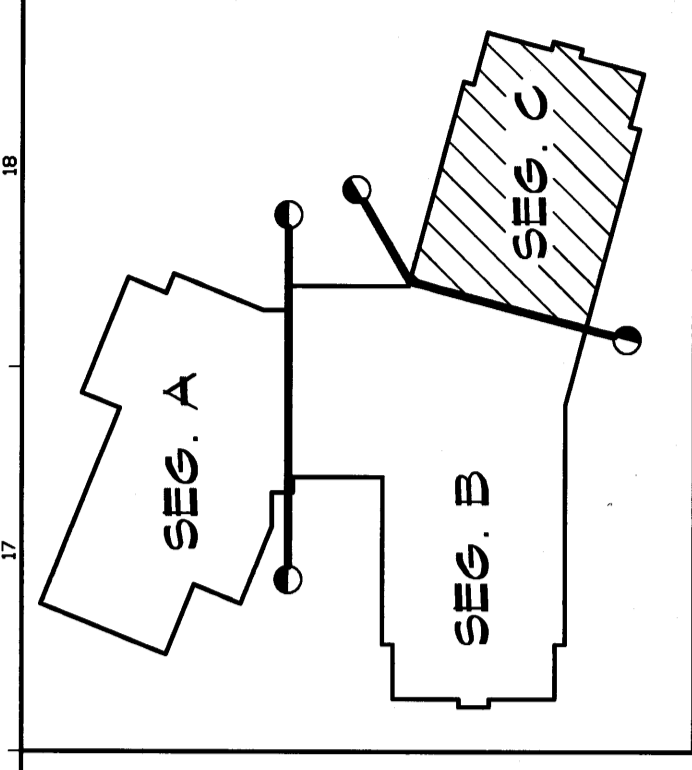

REV.	DESCRIPTION	DATE
0		00.00.00

PERMIT APPLICATION
 SUBMISSION 3-18-09
 CURRENT ISSUE STATUS:



WBRC
 ARCHITECTS • ENGINEERS
 WWW.WBRCARCHITECTS.COM
 100 WASHINGTON ST., SUITE 200
 PORTLAND, MAINE 04101-2000
 (603) 761-1100

PROJECT:	OCEAN AVENUE ELEMENTARY SCHOOL PORTLAND, ME
SHEET TITLE:	FIRST FLOOR MECHANICAL DUCTWORK PLAN - SEG. C
SHEET No.:	A1
PROJECT No.:	331610-MH101-C
SCALE:	1/8" = 1'-0"
PROJECT MANAGER:	CSB
DRAWN BY:	CSB
CHECKED BY:	DMON