
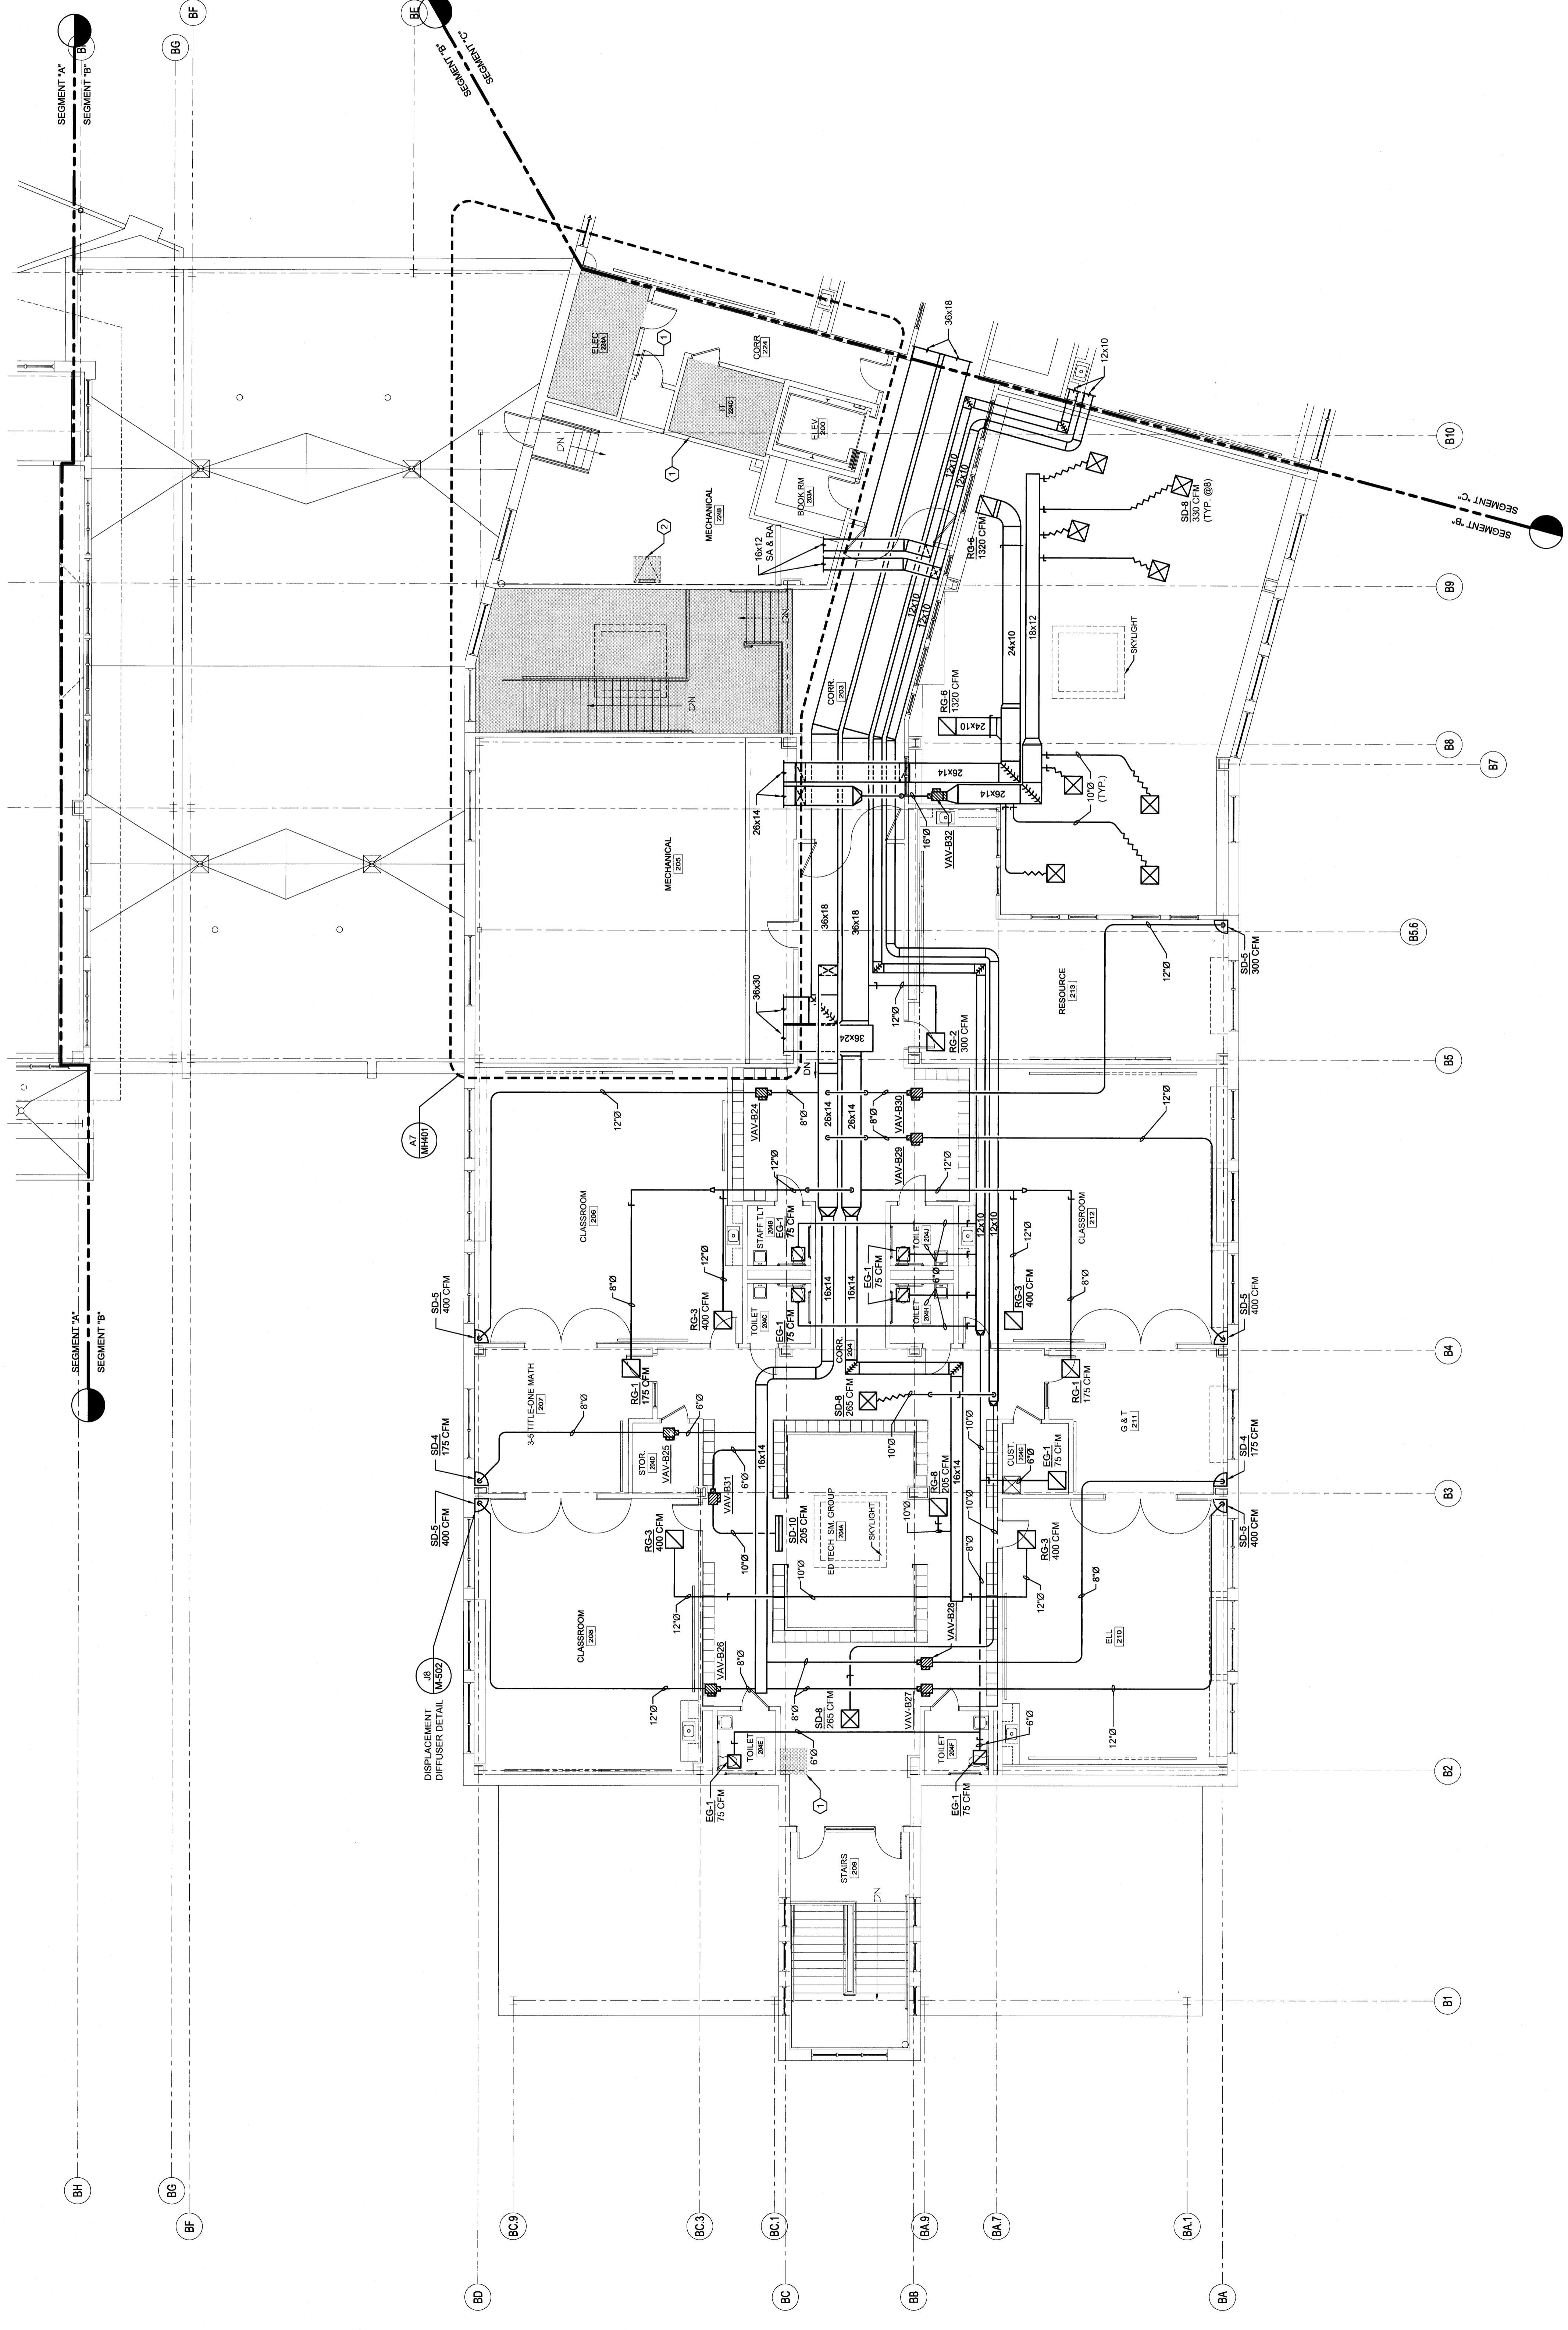



**TECHNICAL NOTES:**

- ① ELECTRICAL SPACE NO DUCTWORK PERMITTED IN THIS AREA.
- ② ROOF-HATCH, NO DUCTWORK PERMITTED IN THIS AREA.

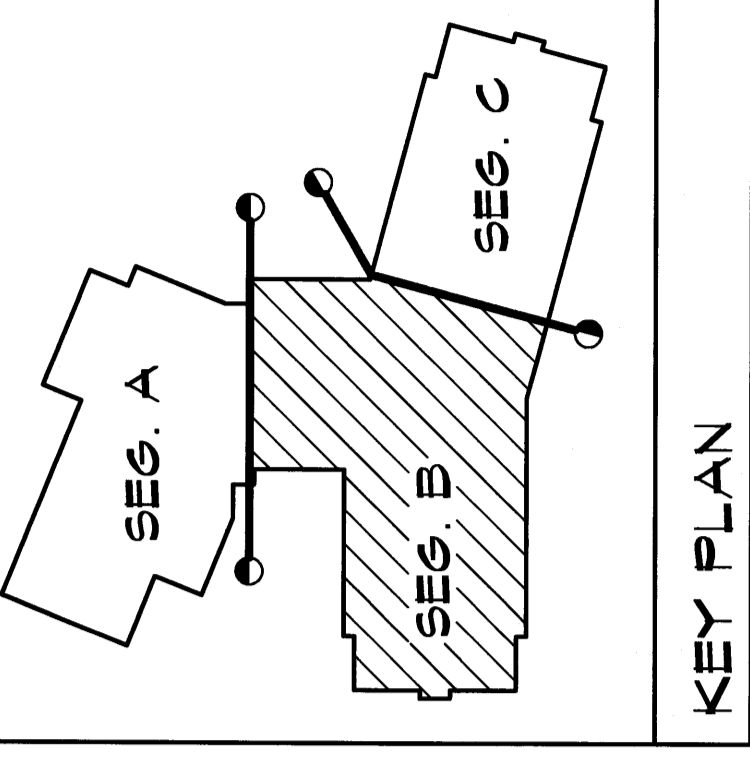

REV.	DESCRIPTION	DATE
0		03.03.20

PERMIT APPLICATION  
SUBMISSION 3-18-09  
CURRENT ISSUE STATUS:

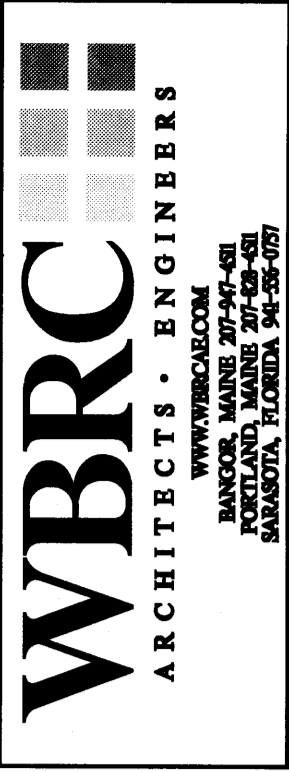

**WBRC**  
ARCHITECTS • ENGINEERS  
WWW.WBRC.COM  
100 WASHINGTON ST.  
PORTLAND, MAINE 04101-2525  
SACONNA, FLORIDA 32080-5520

OCEAN AVENUE ELEMENTARY  
SCHOOL  
PORTLAND, ME

PROJECT  
SECOND FLOOR MECHANICAL  
DUCTWORK PLAN - SEG. B

PROJECT No. 331610 DRAWING SCALE 0'  
SCALE 1/8" = 1'-0"  
PROJECT MANAGER MEG  
DRAWN BY DMON  
CHECKED BY  
SHEET No. **MH102-B**

**A1 SECOND FLOOR MECHANICAL DUCTWORK PLAN - SEG. B**

1/8" = 1'-0"