
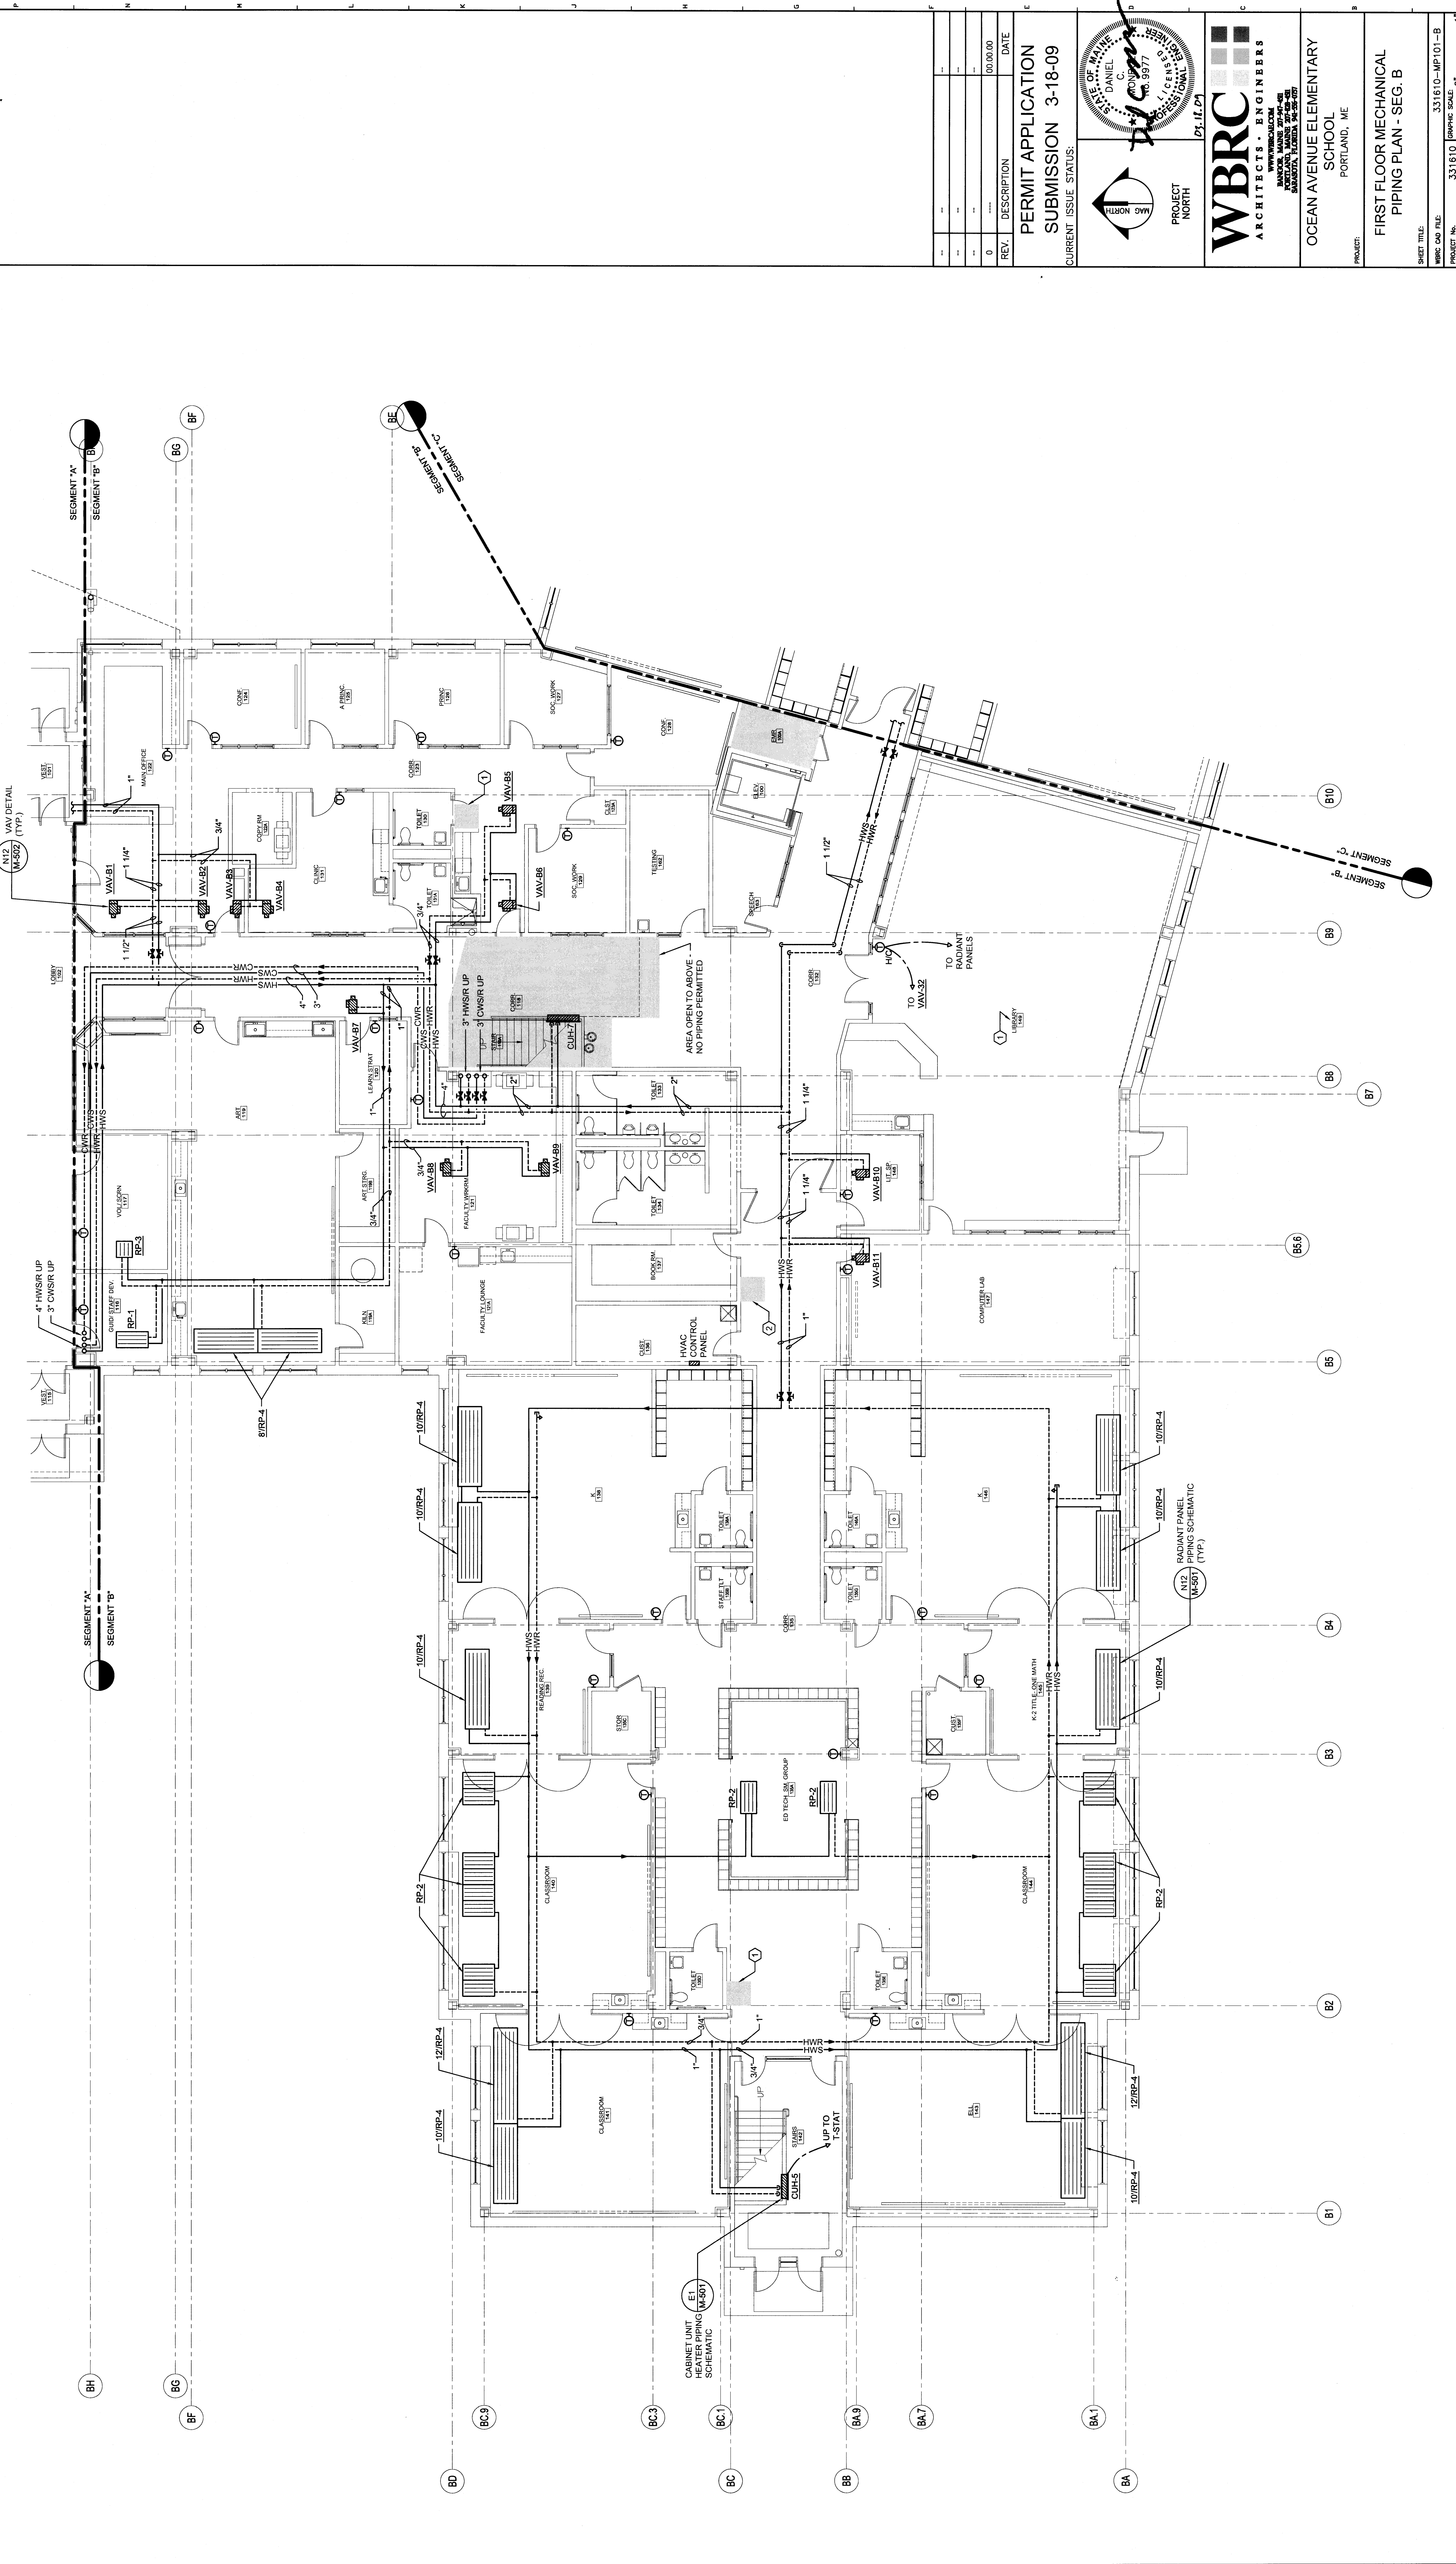


TECHNICAL NOTES:

- ① EXPOSED STRUCTURE AND CEILING IN THIS AREA. COORDINATE EXTENT WITH REFLECTED CEILING PLANS. INTENT IS FOR EXPOSED UTILITIES TO BE PAINTED. PAINTING BY OTHERS, REFER TO DIV. 8.
- ② ELECTRICAL SPACE. NO PIPING PERMITTED IN THIS AREA.
- ③ ROOF HATCH. NO PIPING PERMITTED IN THIS AREA.

GENERAL NOTES:

- 1. ALL PIPE BRANCHES SHALL BE 3/4" UNLESS OTHERWISE NOTED.

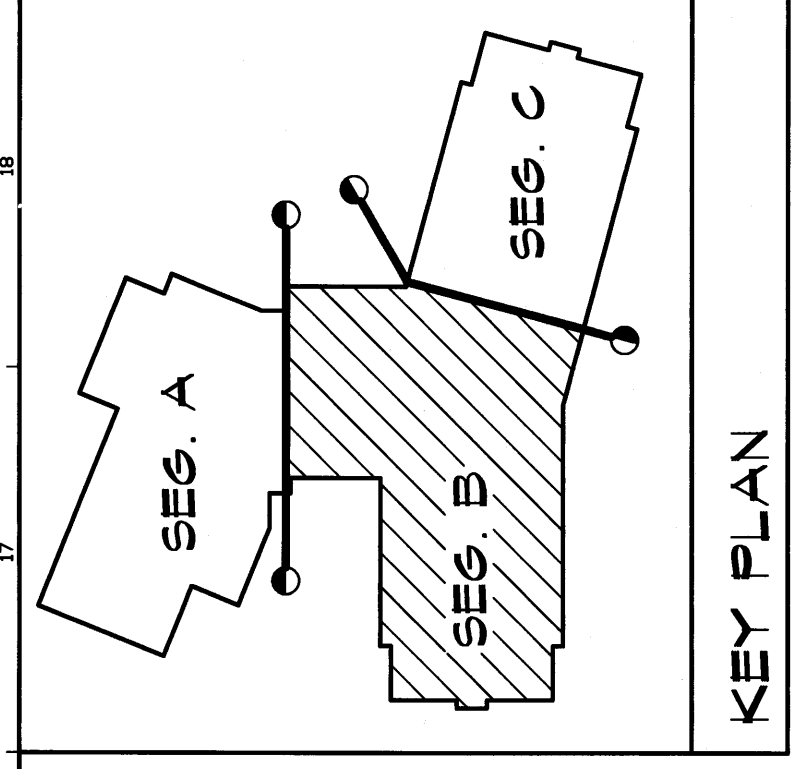

REV.	DESCRIPTION	DATE
0		00.00.00

PERMIT APPLICATION
SUBMISSION 3-18-09
 CURRENT ISSUE STATUS:



WBRC
 ARCHITECTS • ENGINEERS
 WWW.WBRCORC.COM
 100 WATER STREET, SUITE 200
 PORTLAND, ME 04101-3000
 PHONE: 603.761.1100
 FAX: 603.761.1101

OCEAN AVENUE ELEMENTARY SCHOOL
 PORTLAND, ME

FIRST FLOOR MECHANICAL PIPING PLAN - SEG. B

SHEET TITLE:	331610-MP101-B
PROJECT NO.:	331610
SCALE:	1/8" = 1'-0"
PROJECT MANAGER:	MEJ
DRAWN BY:	CSE
CHECKED BY:	DMON
SHEET NO.:	MP101-B