 


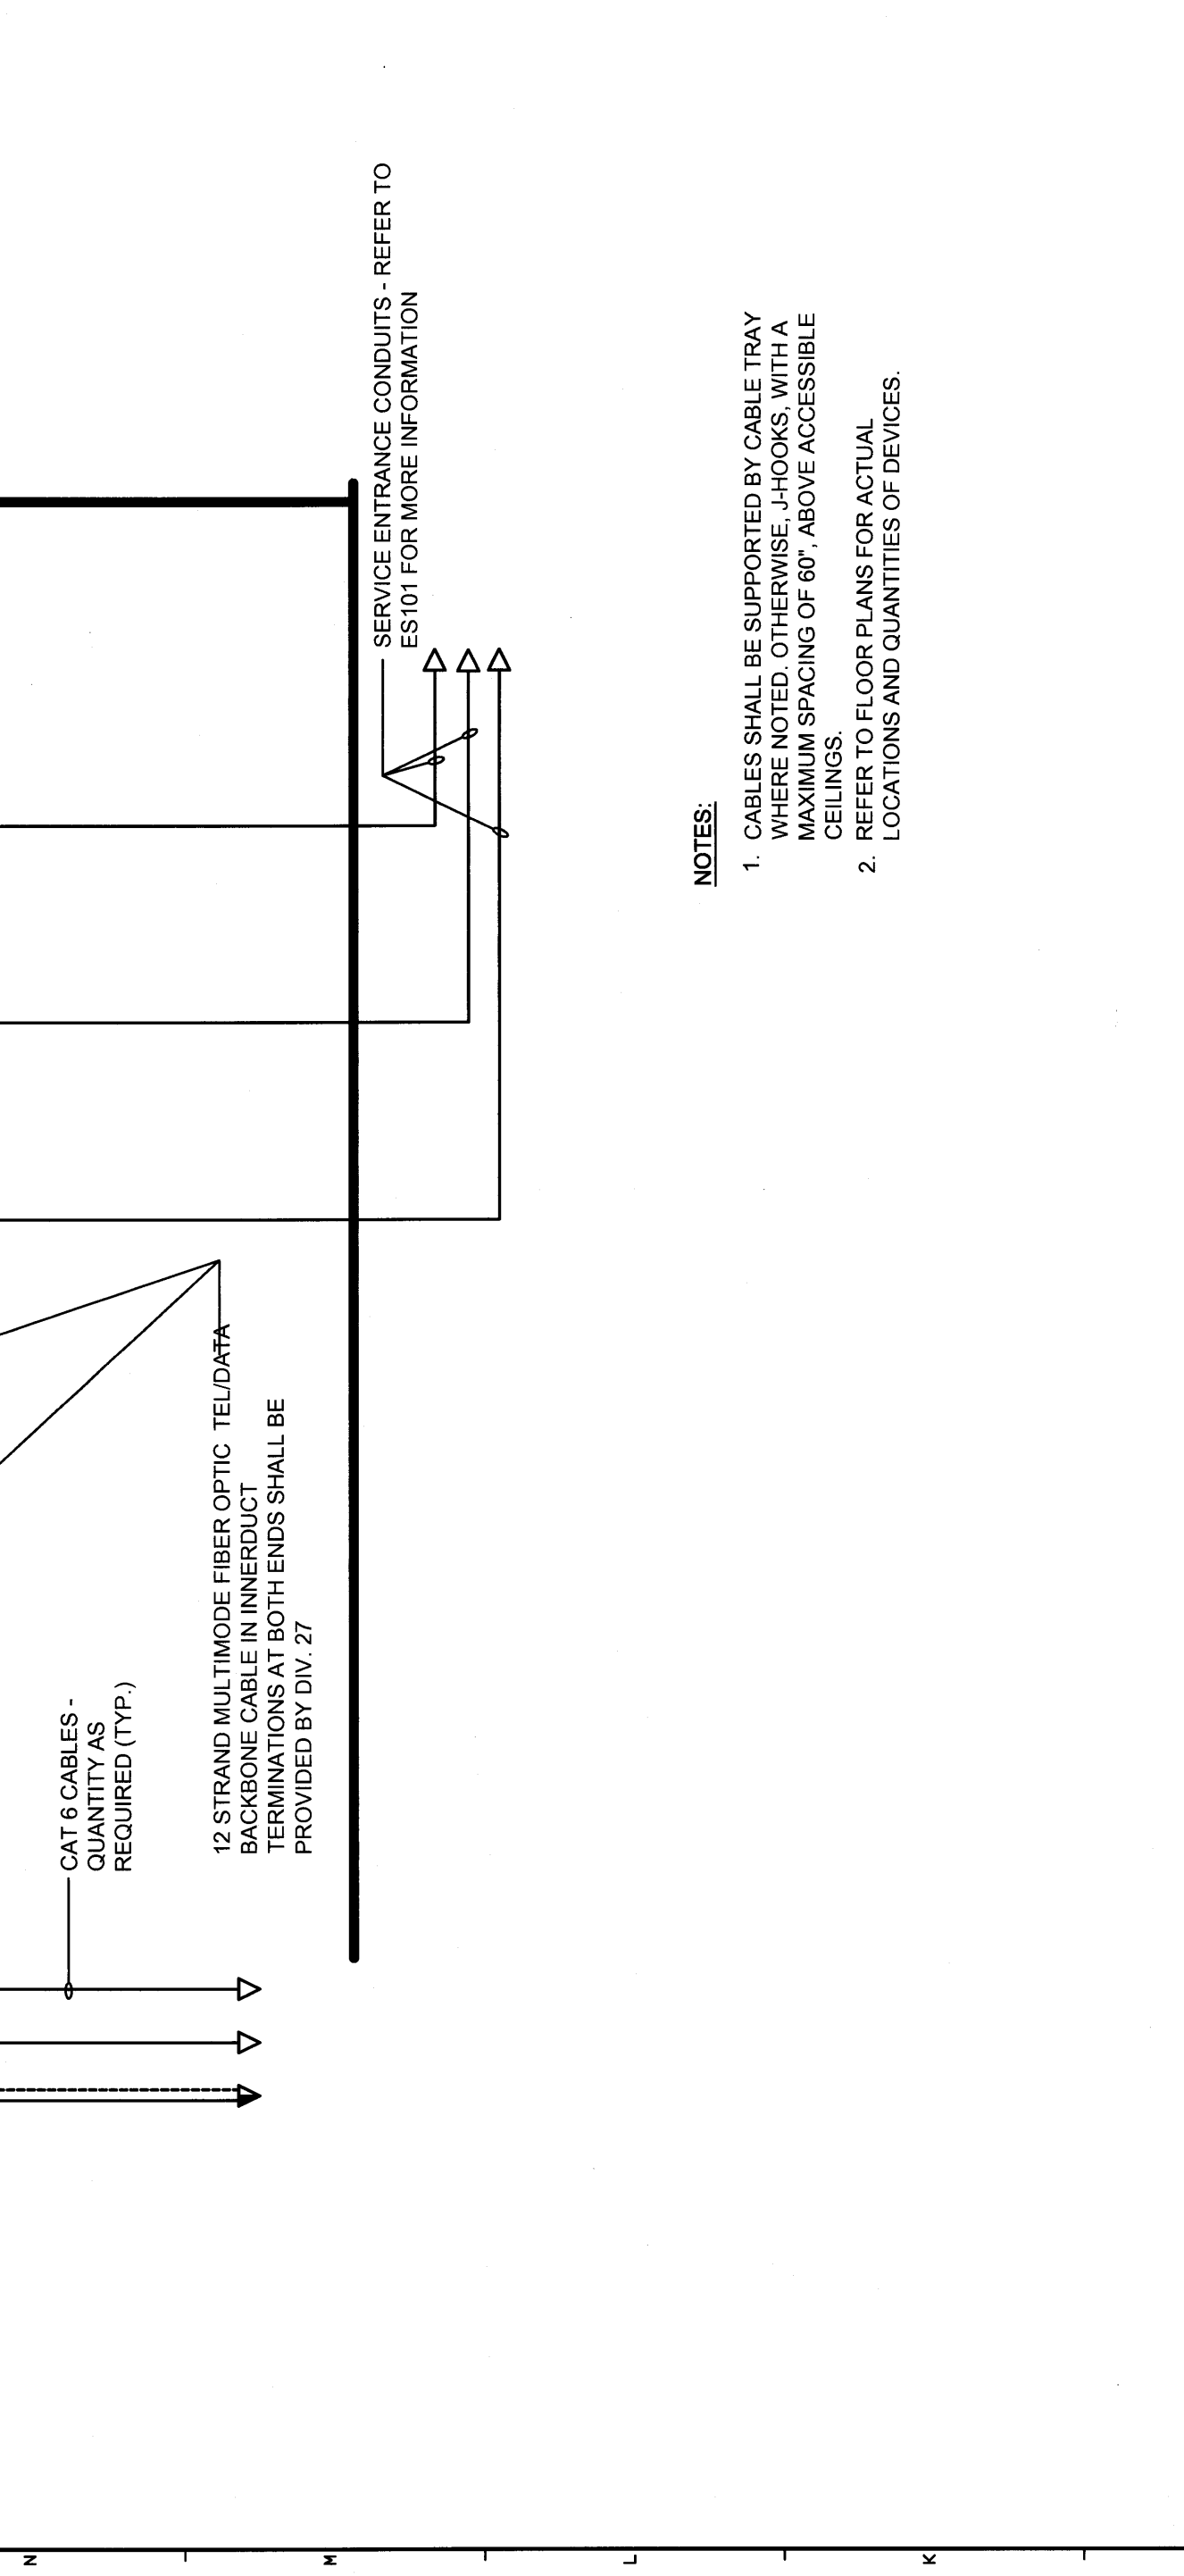
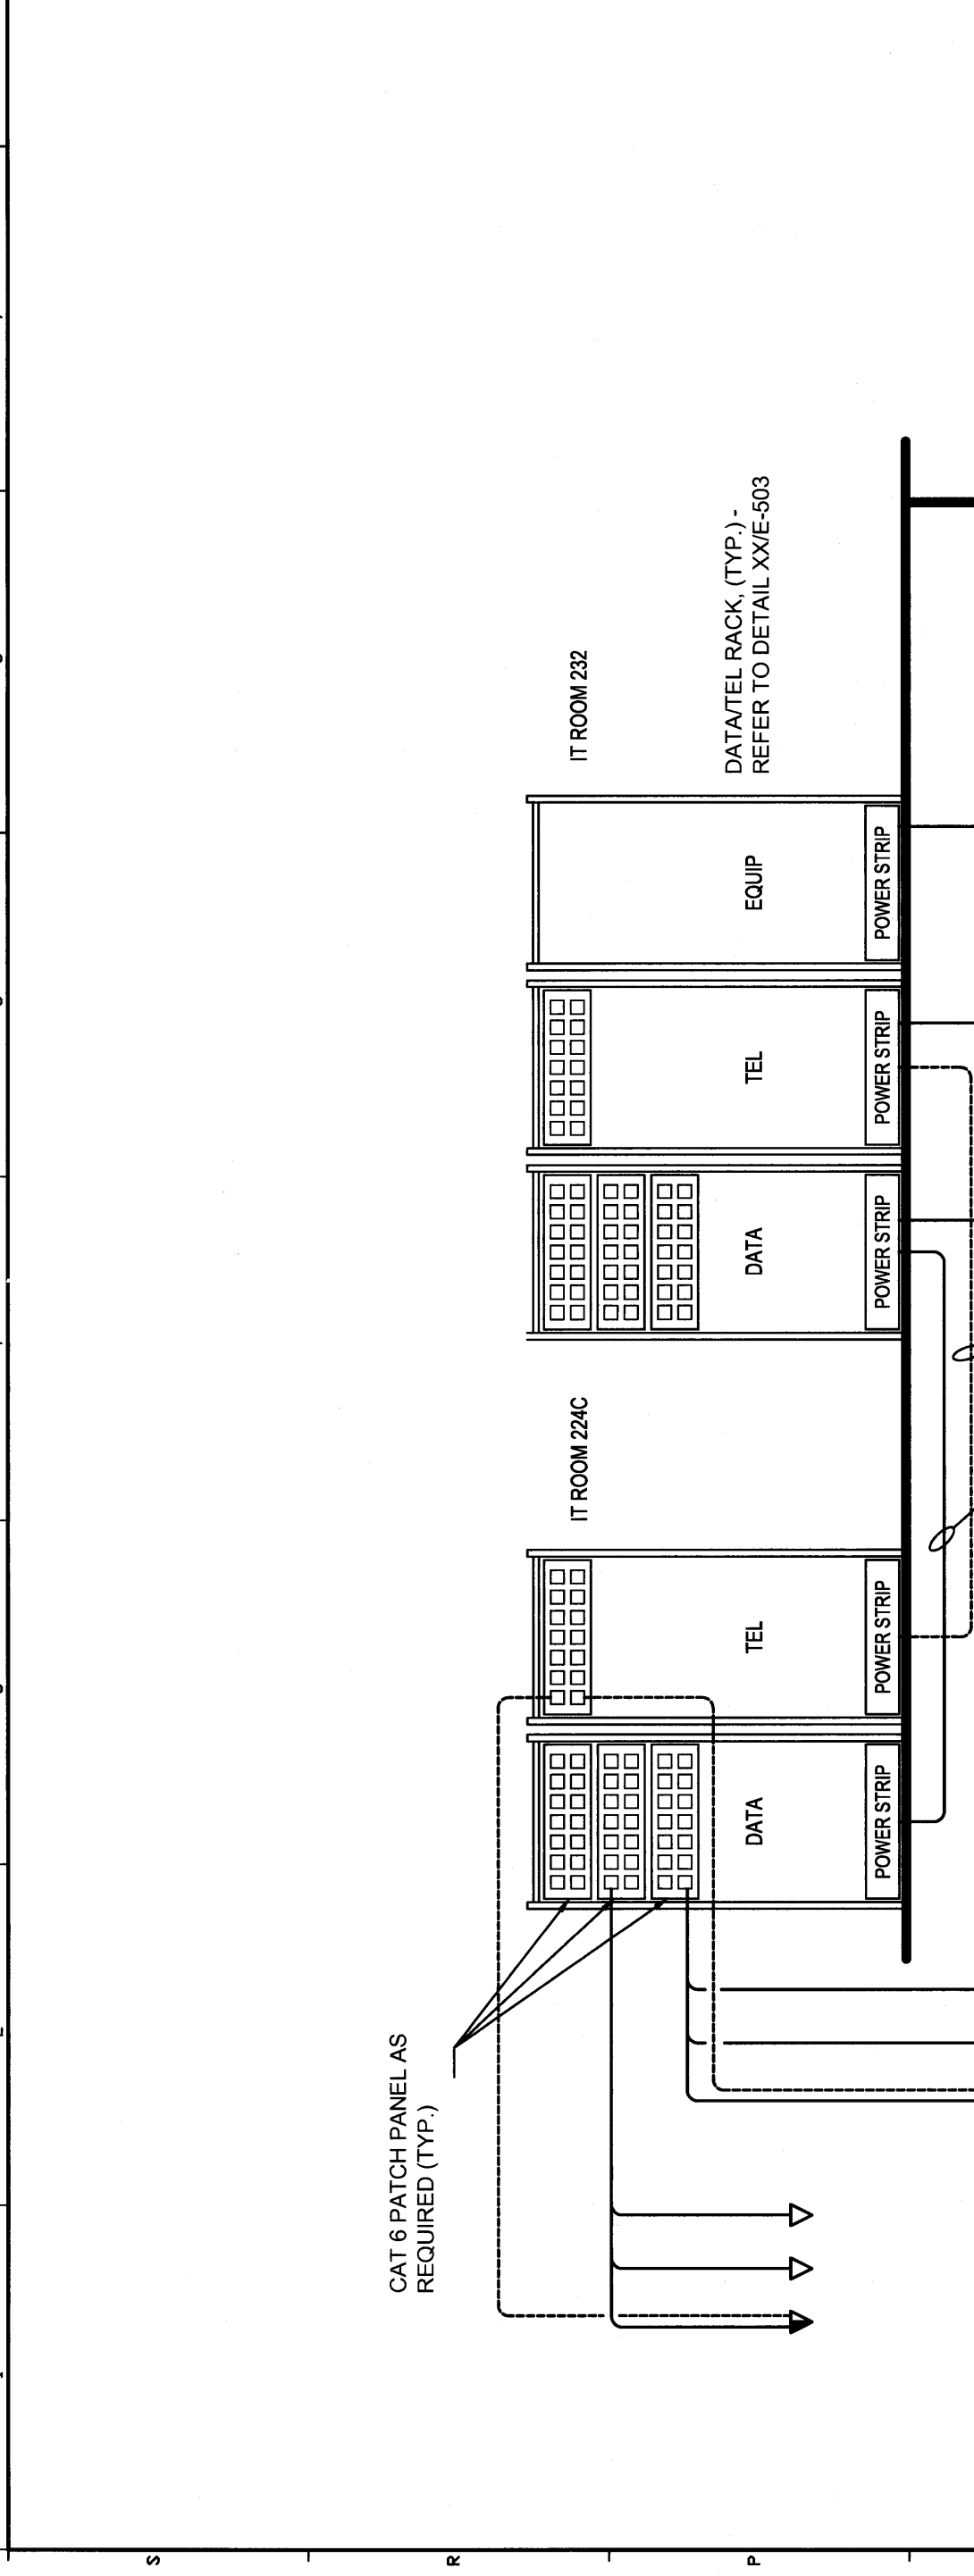
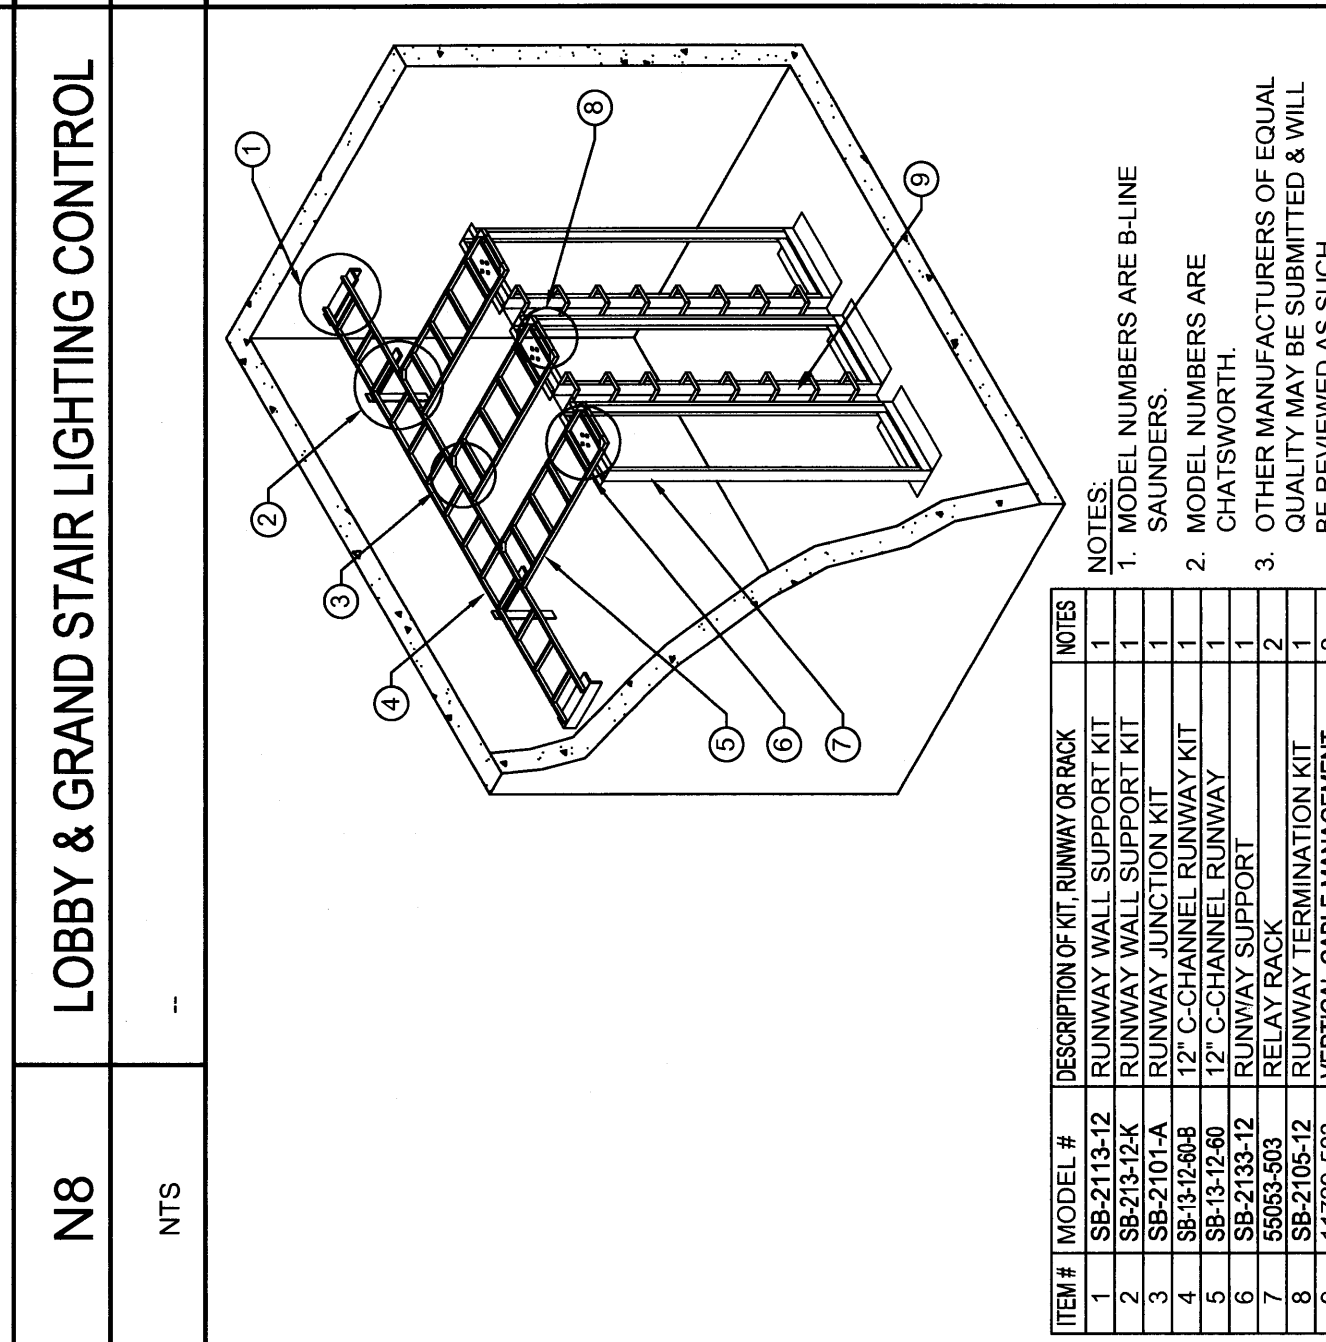
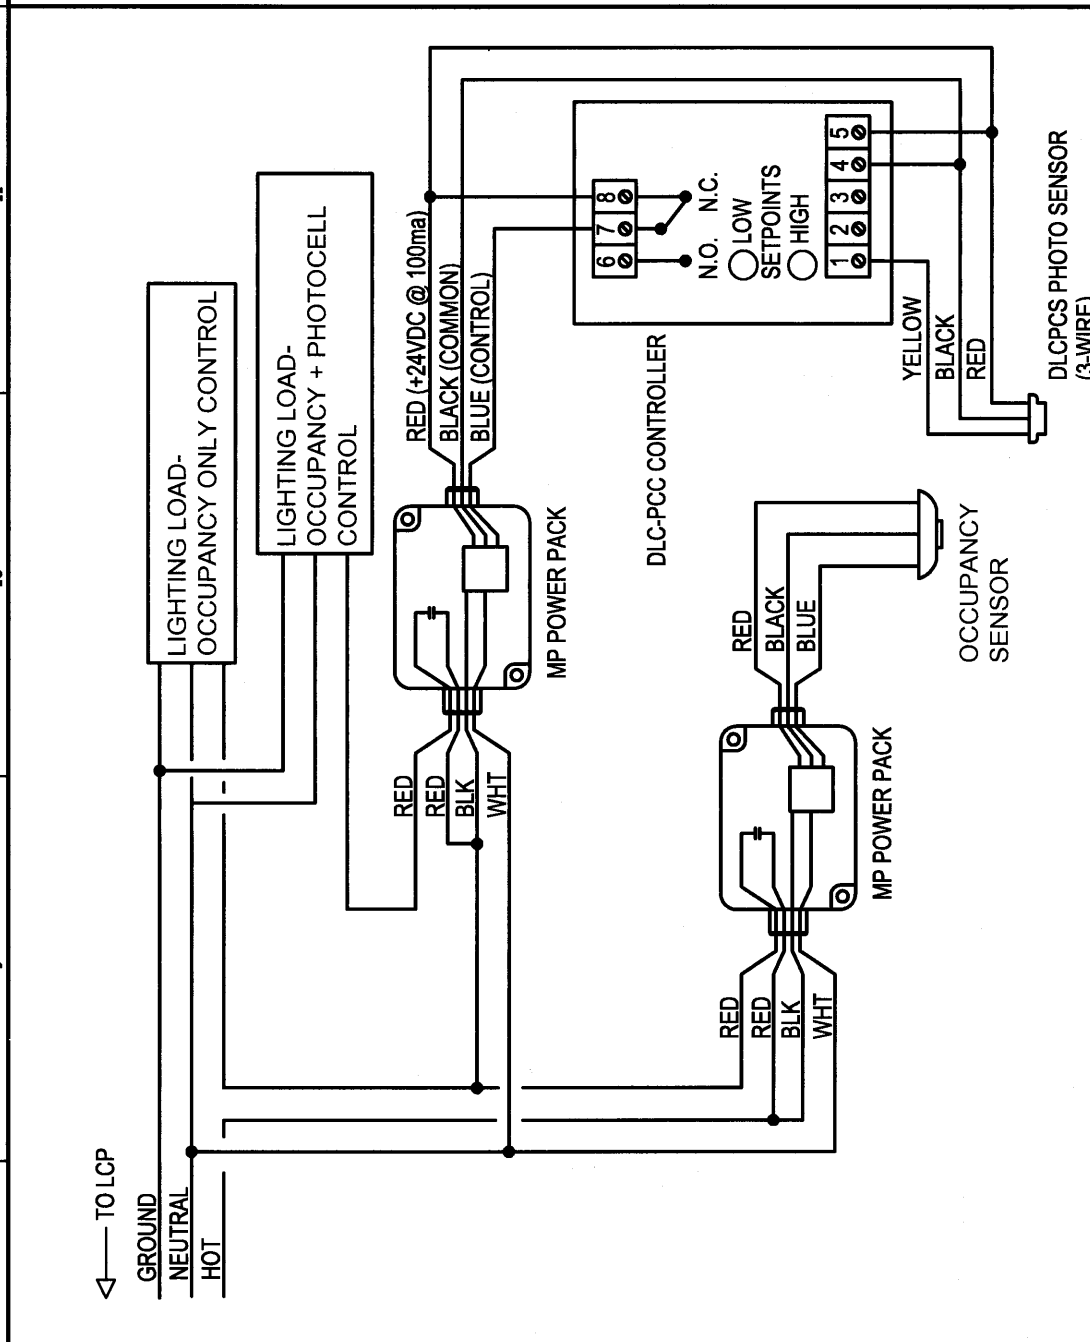
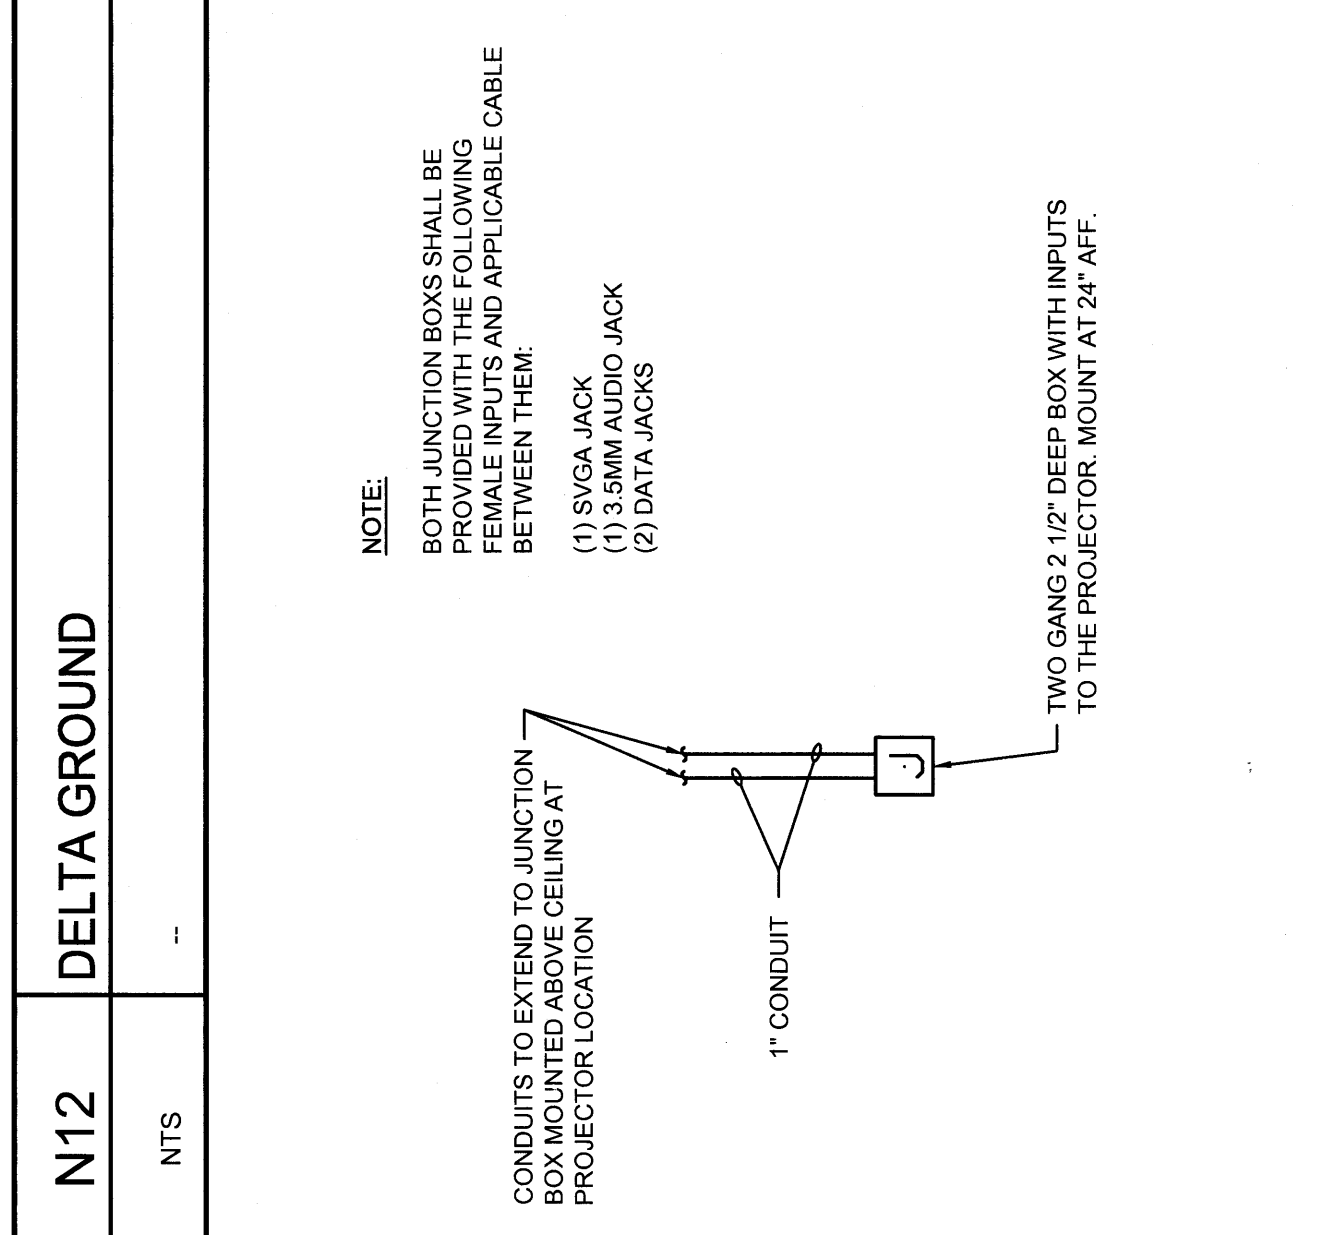
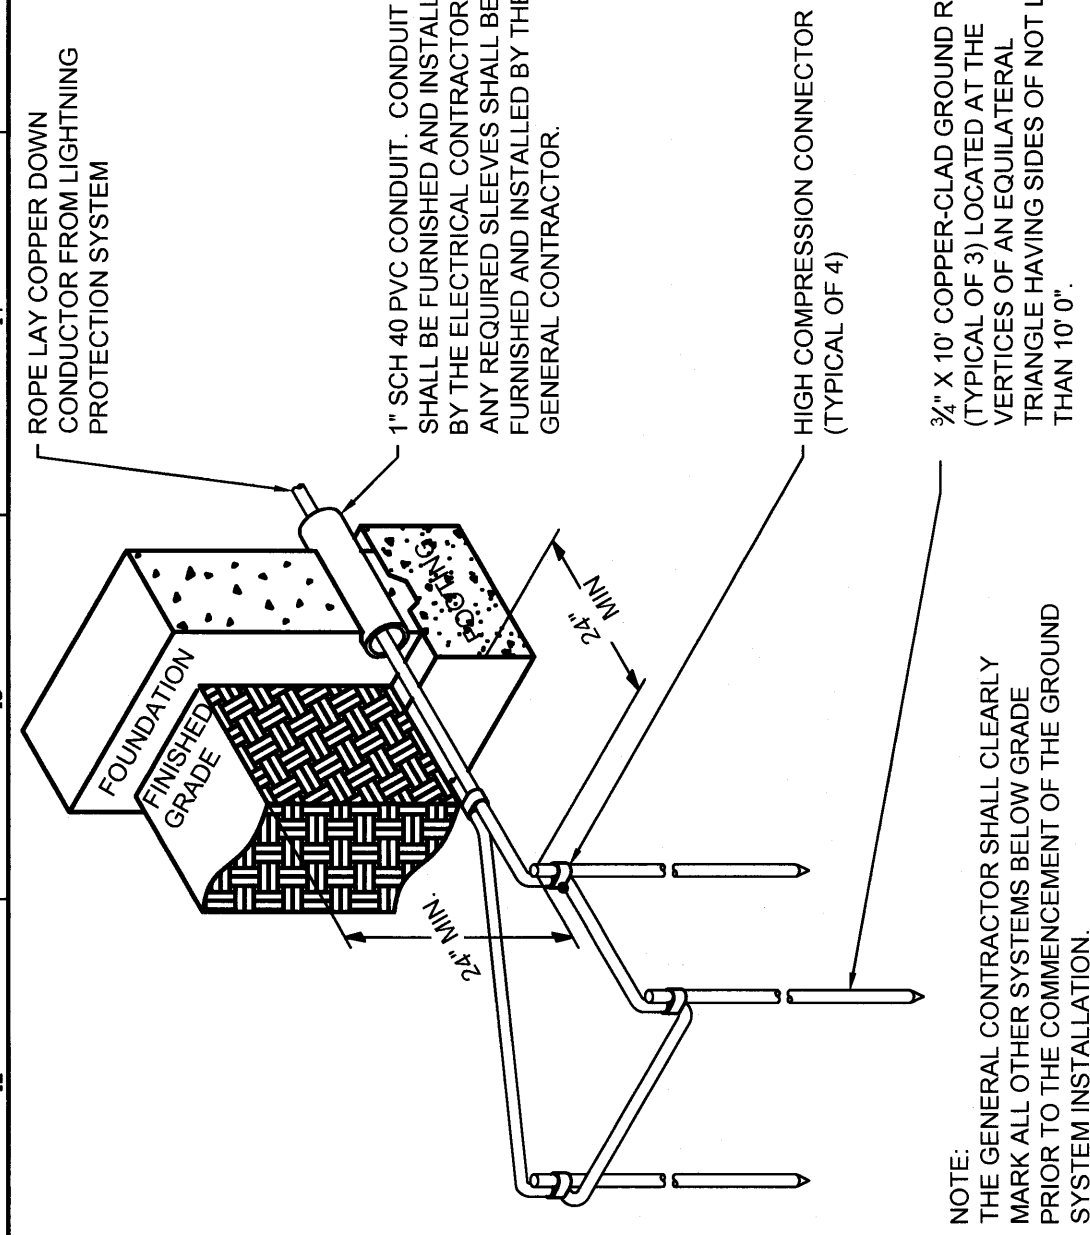
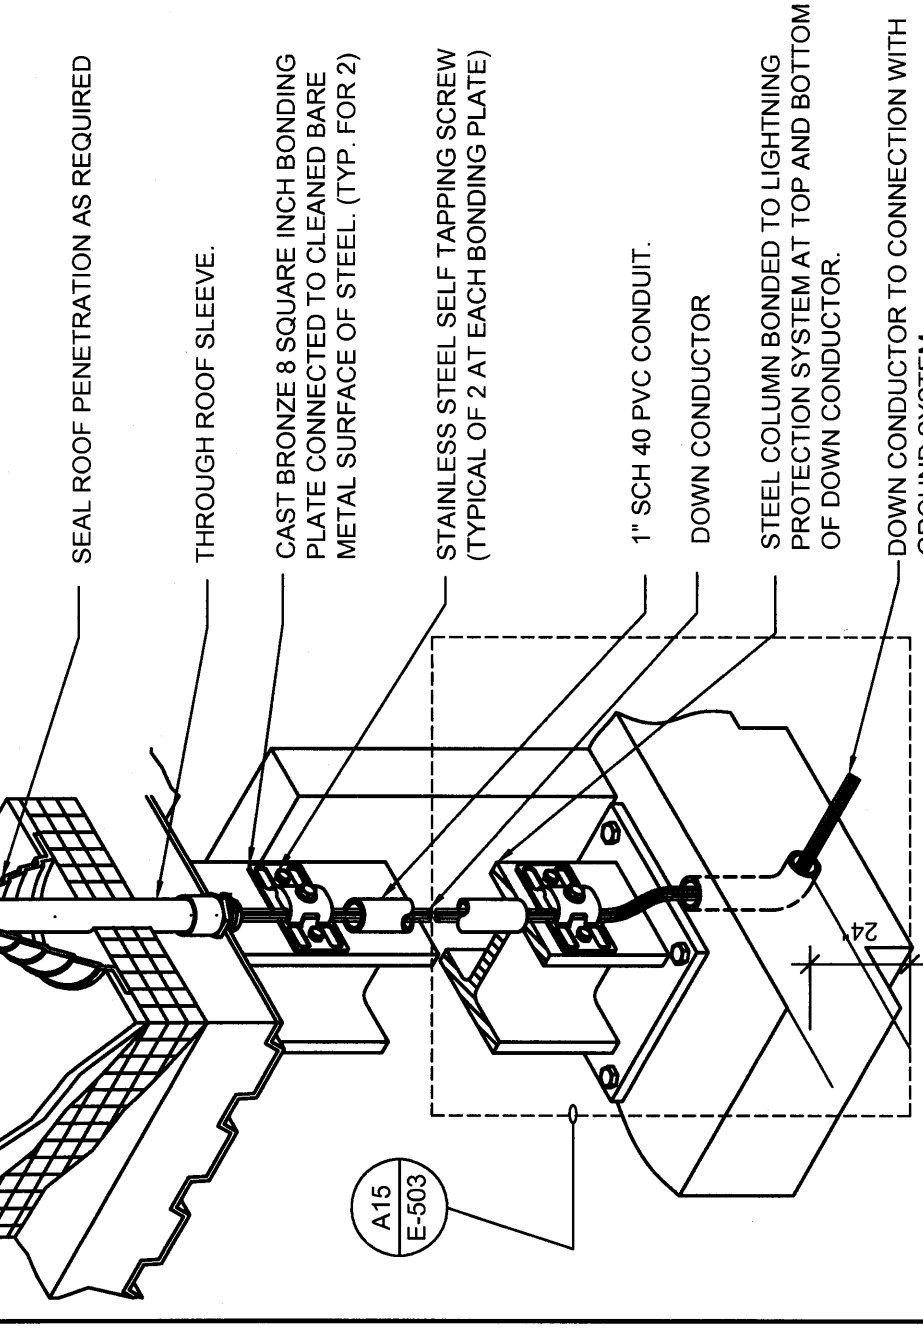
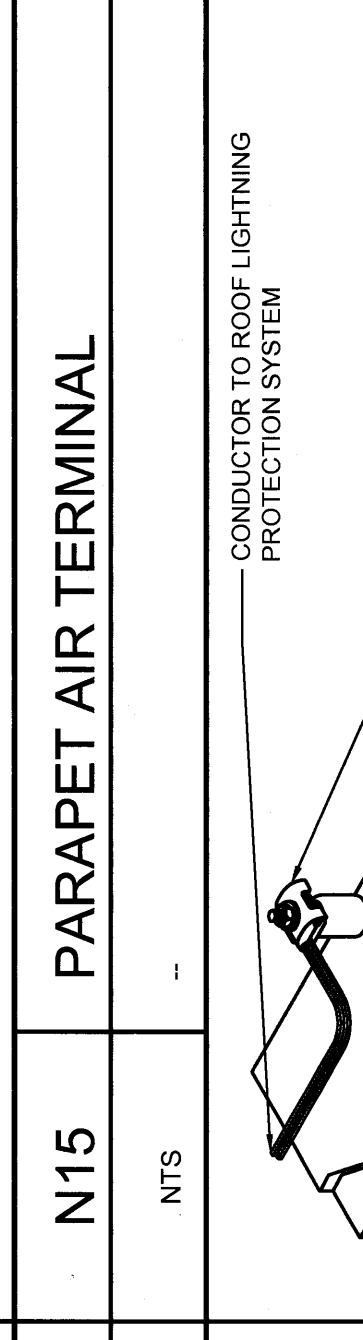
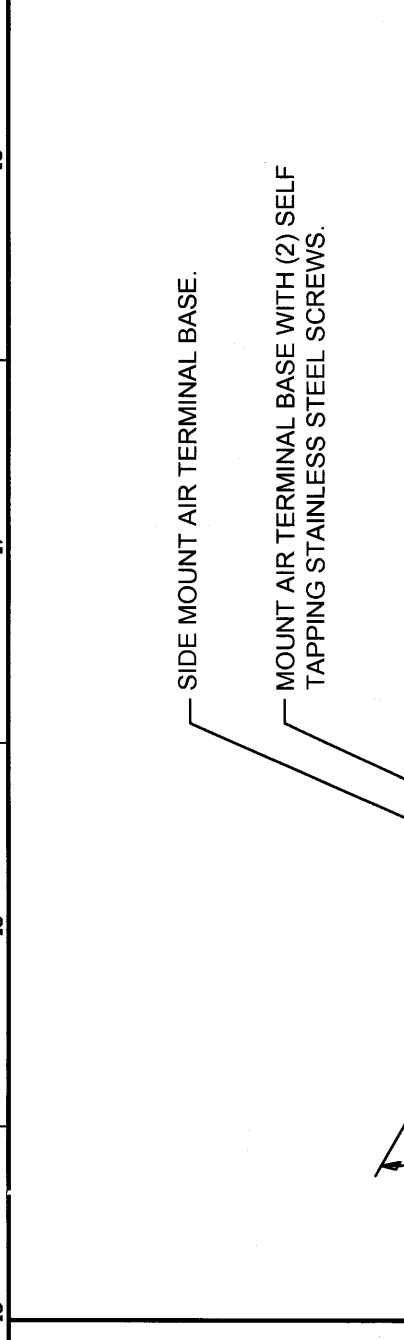
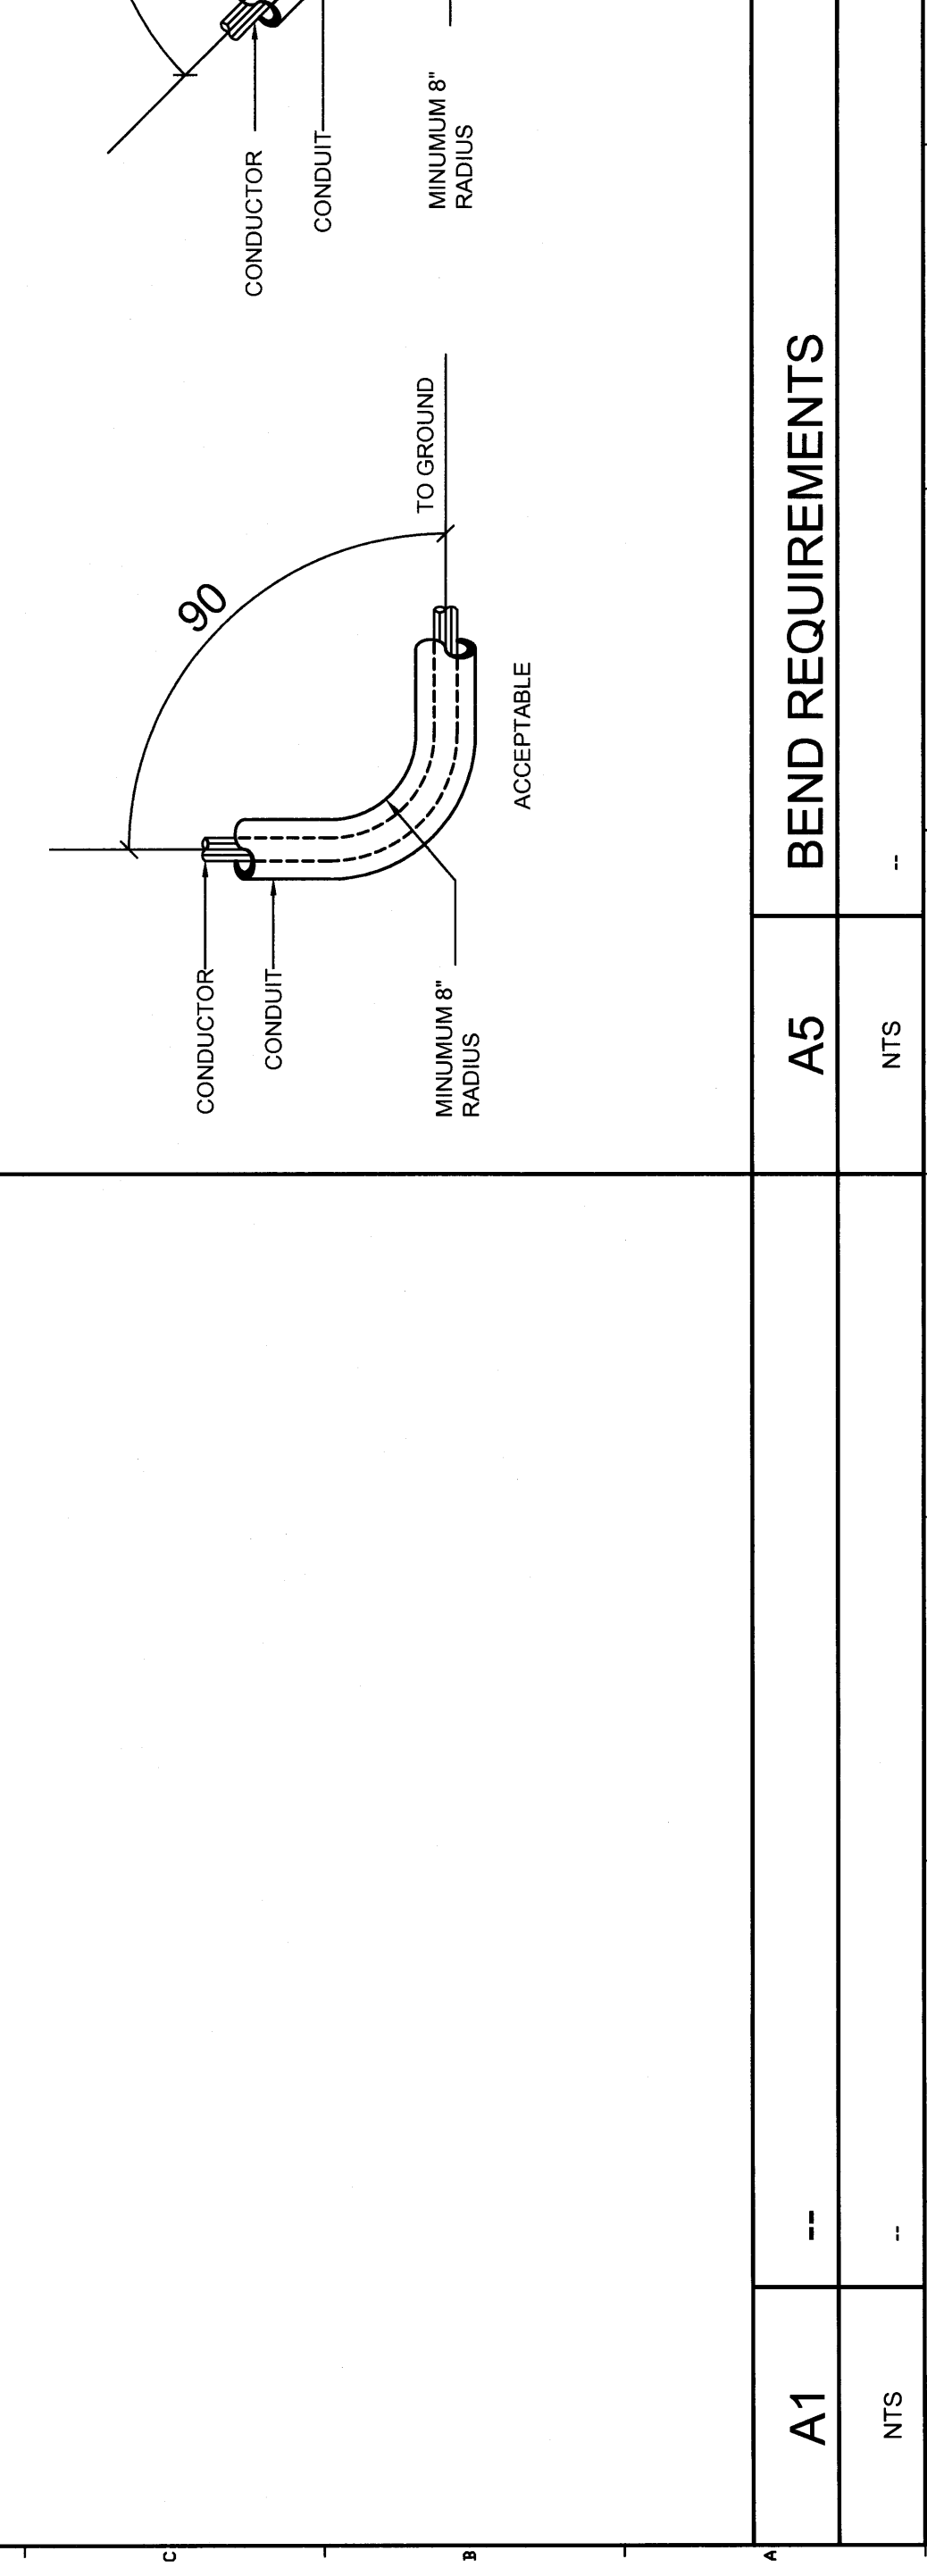
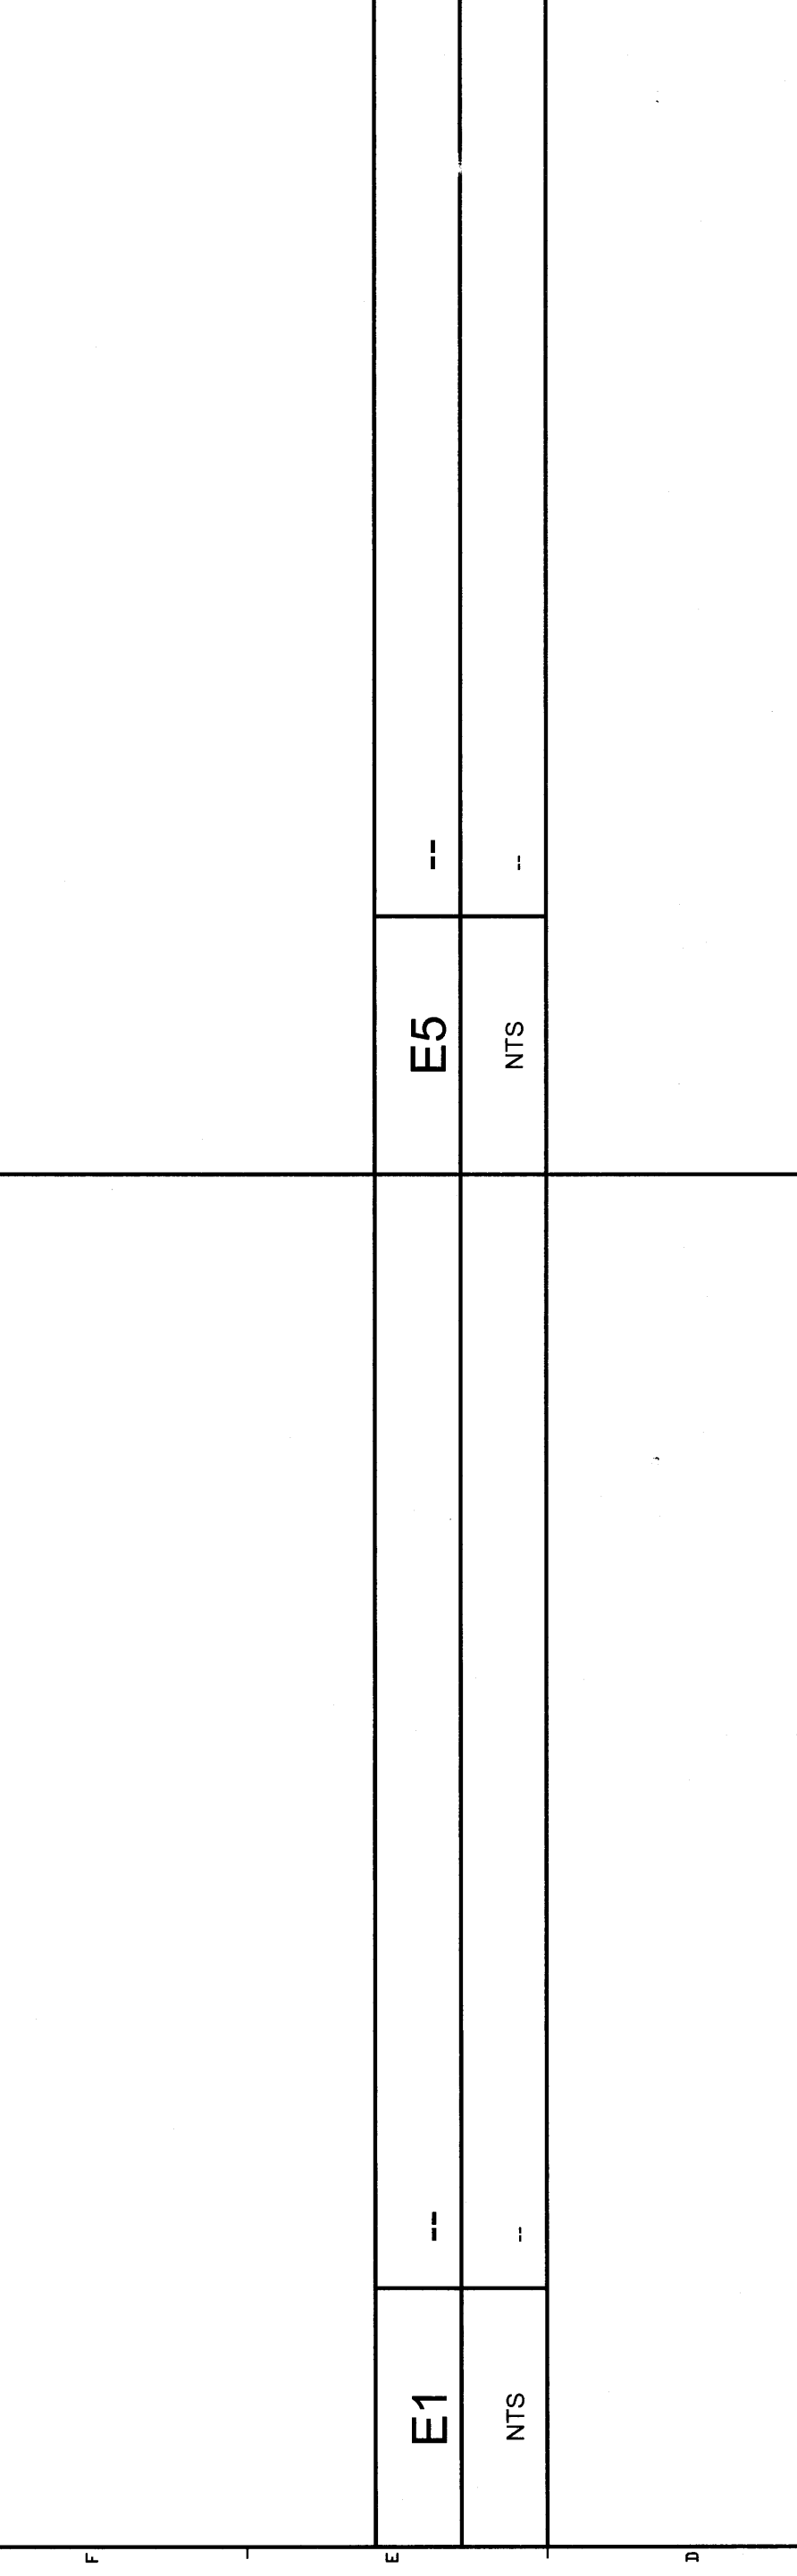
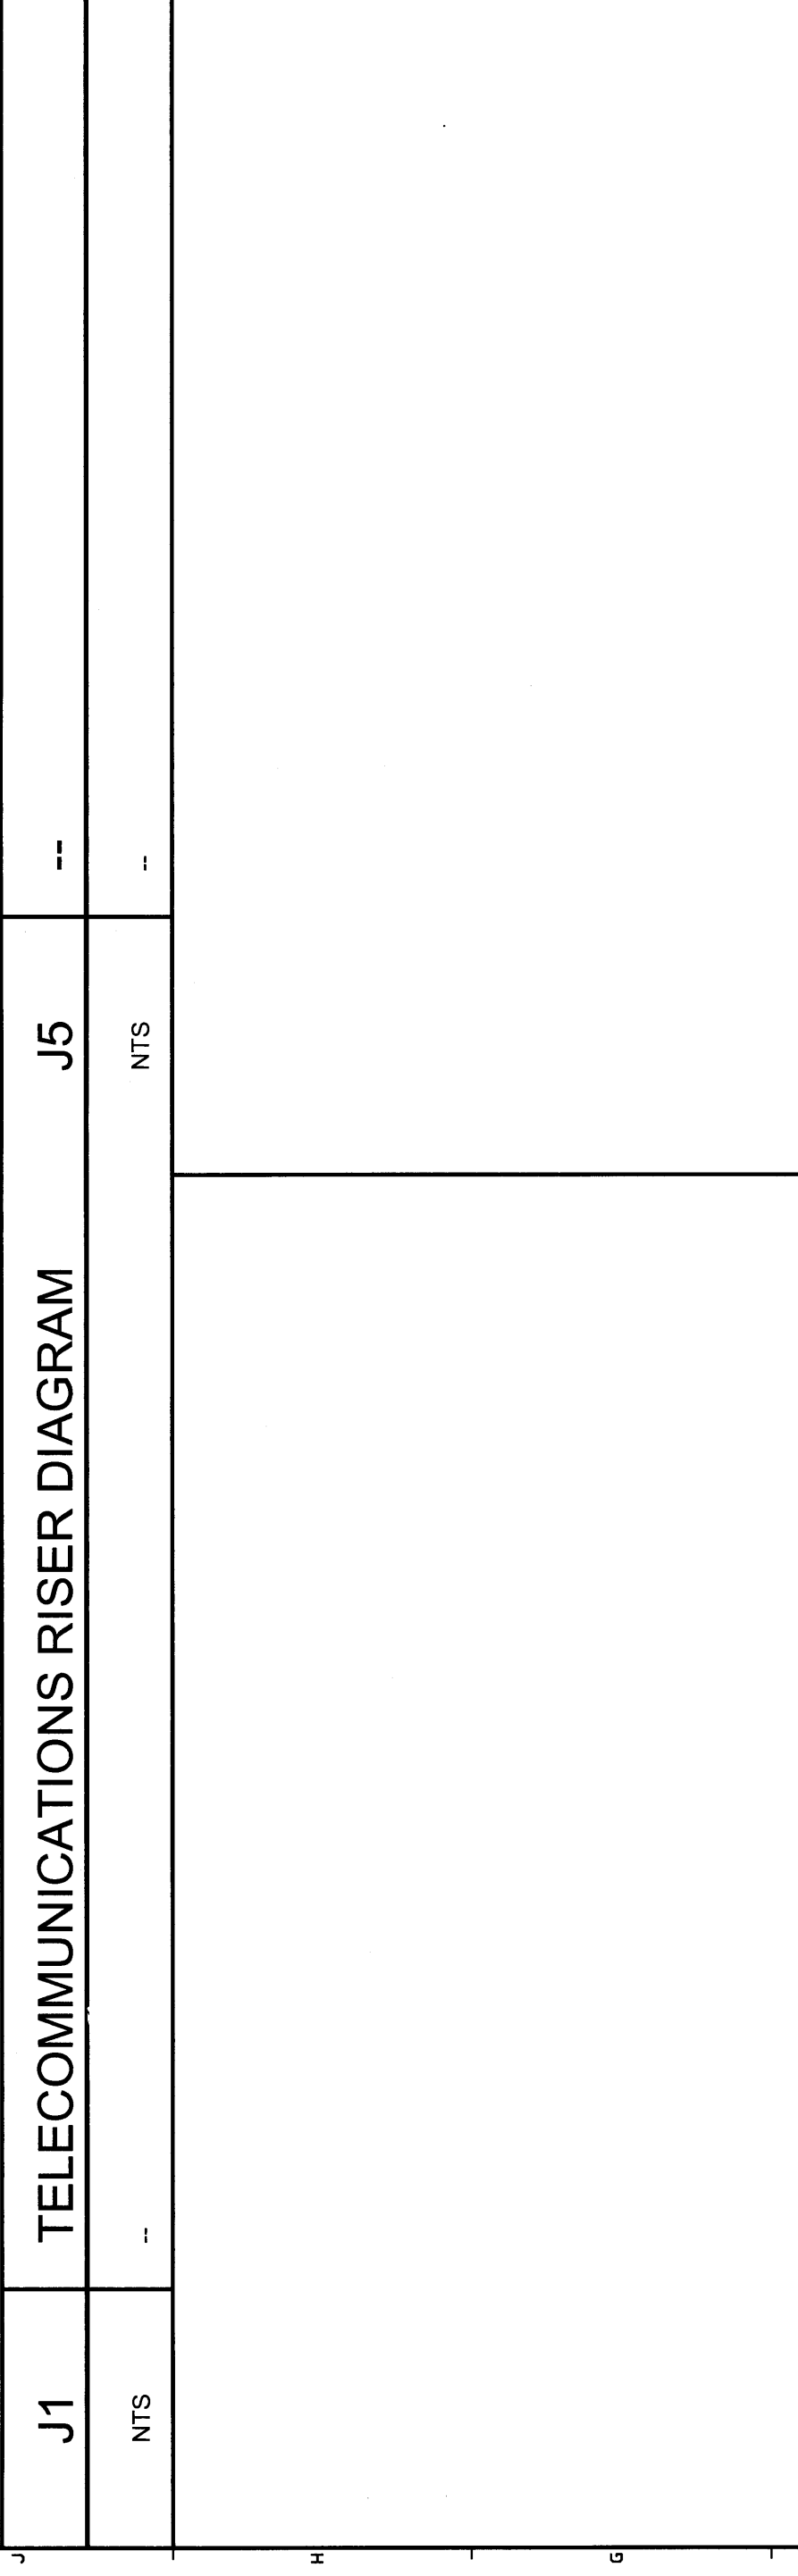
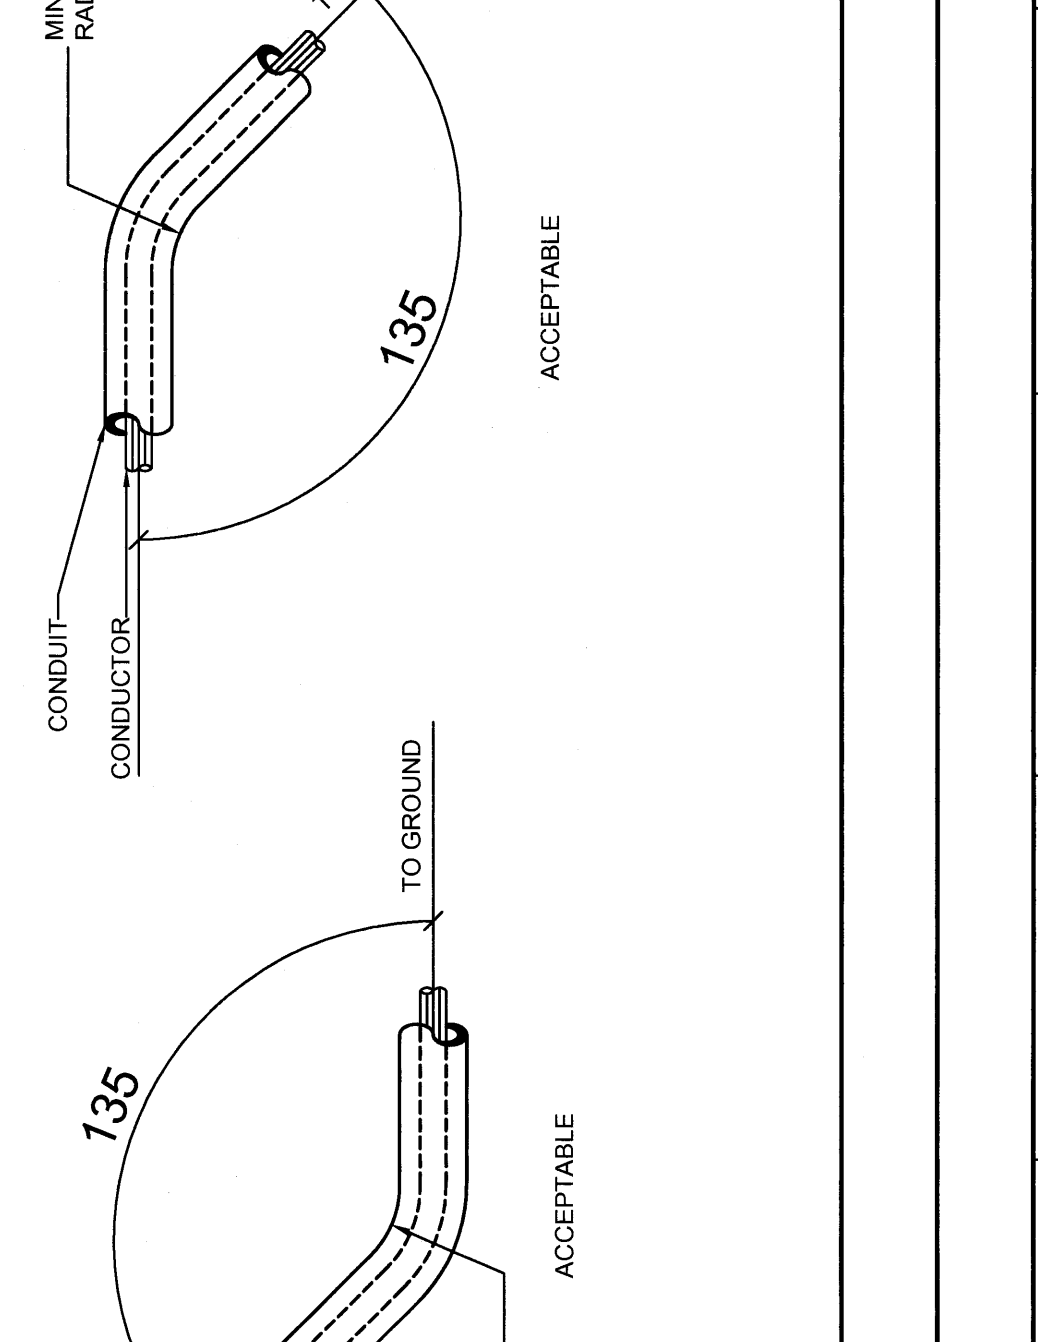
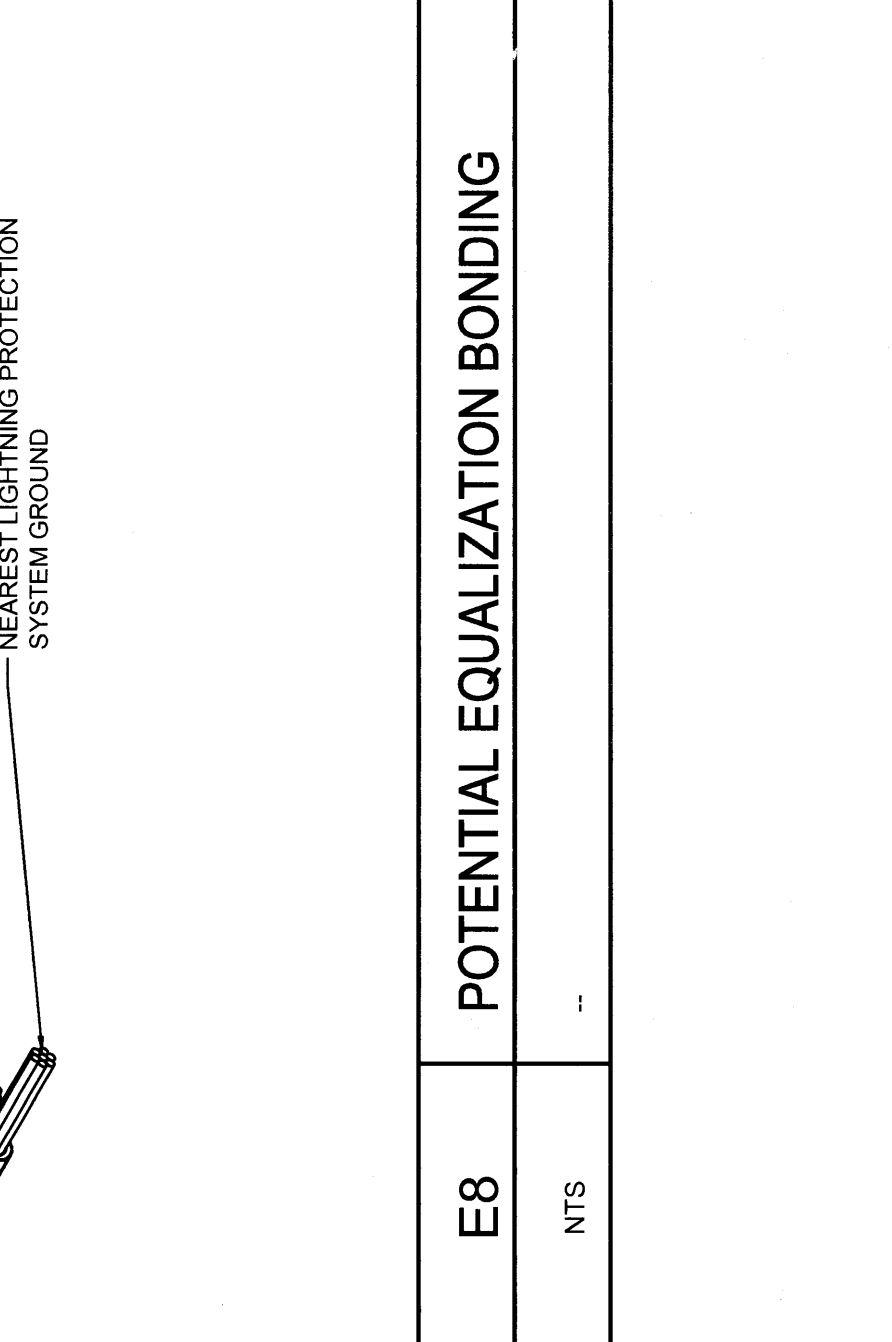
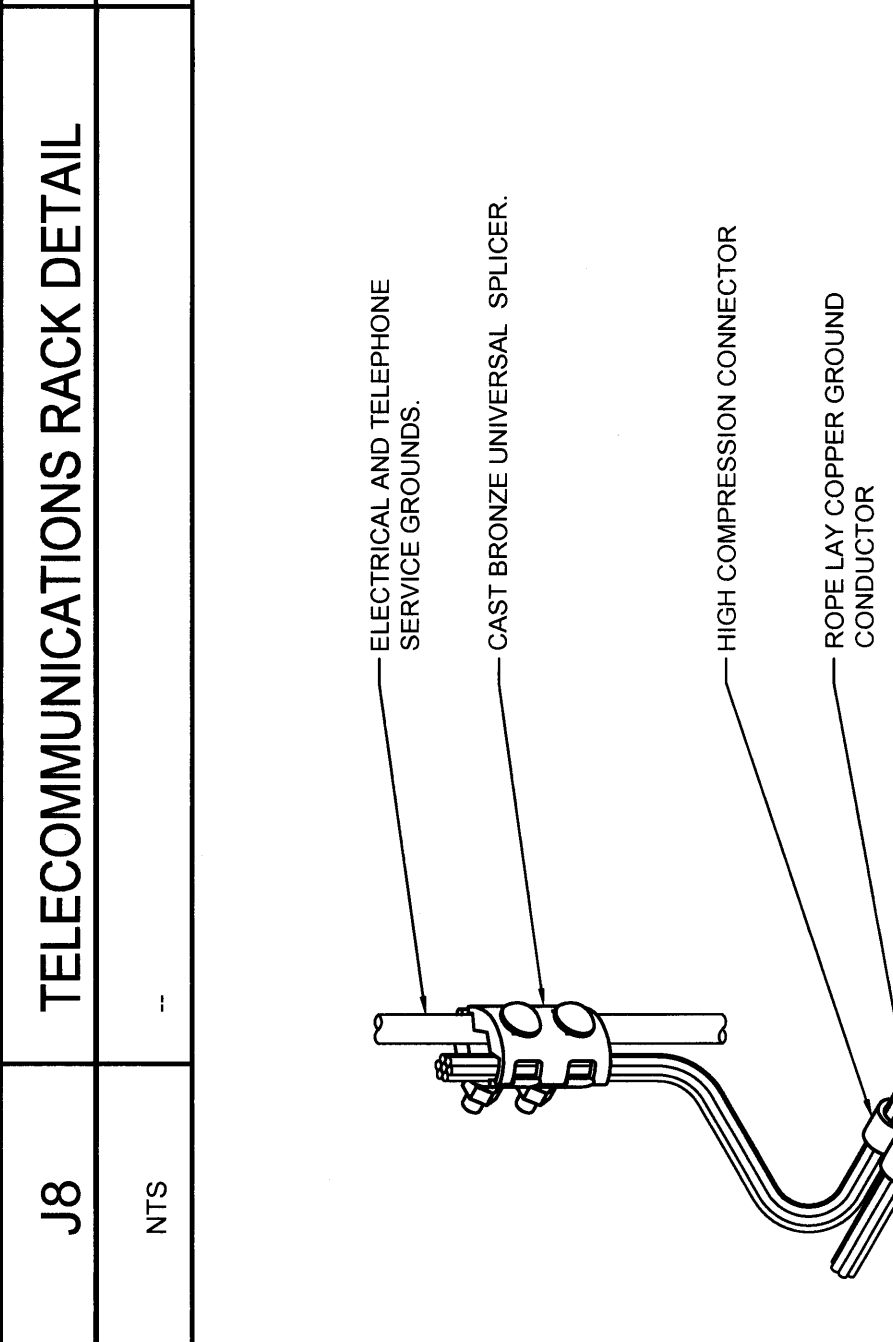
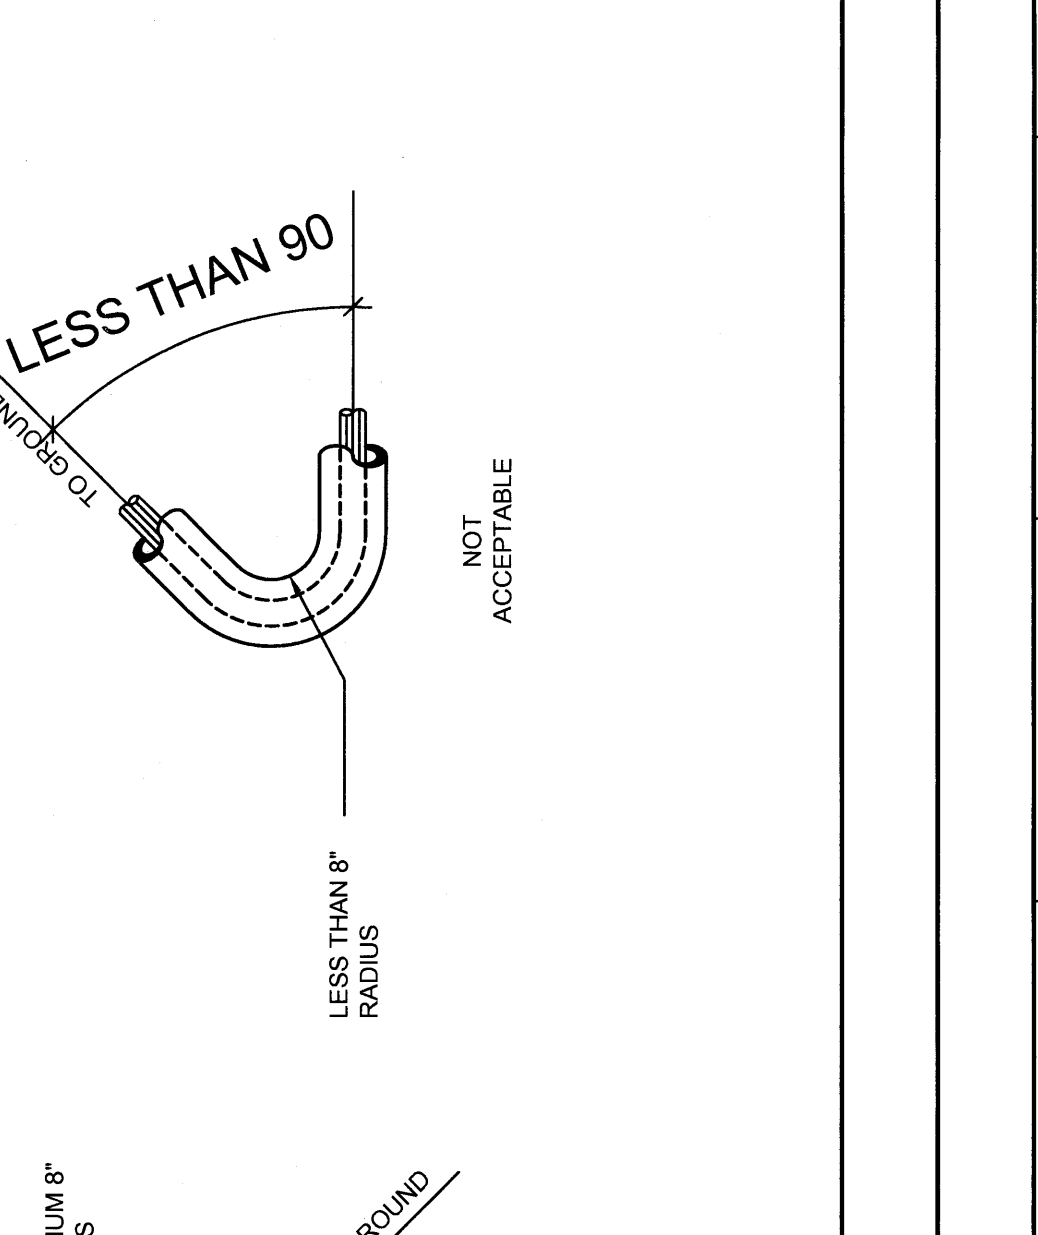
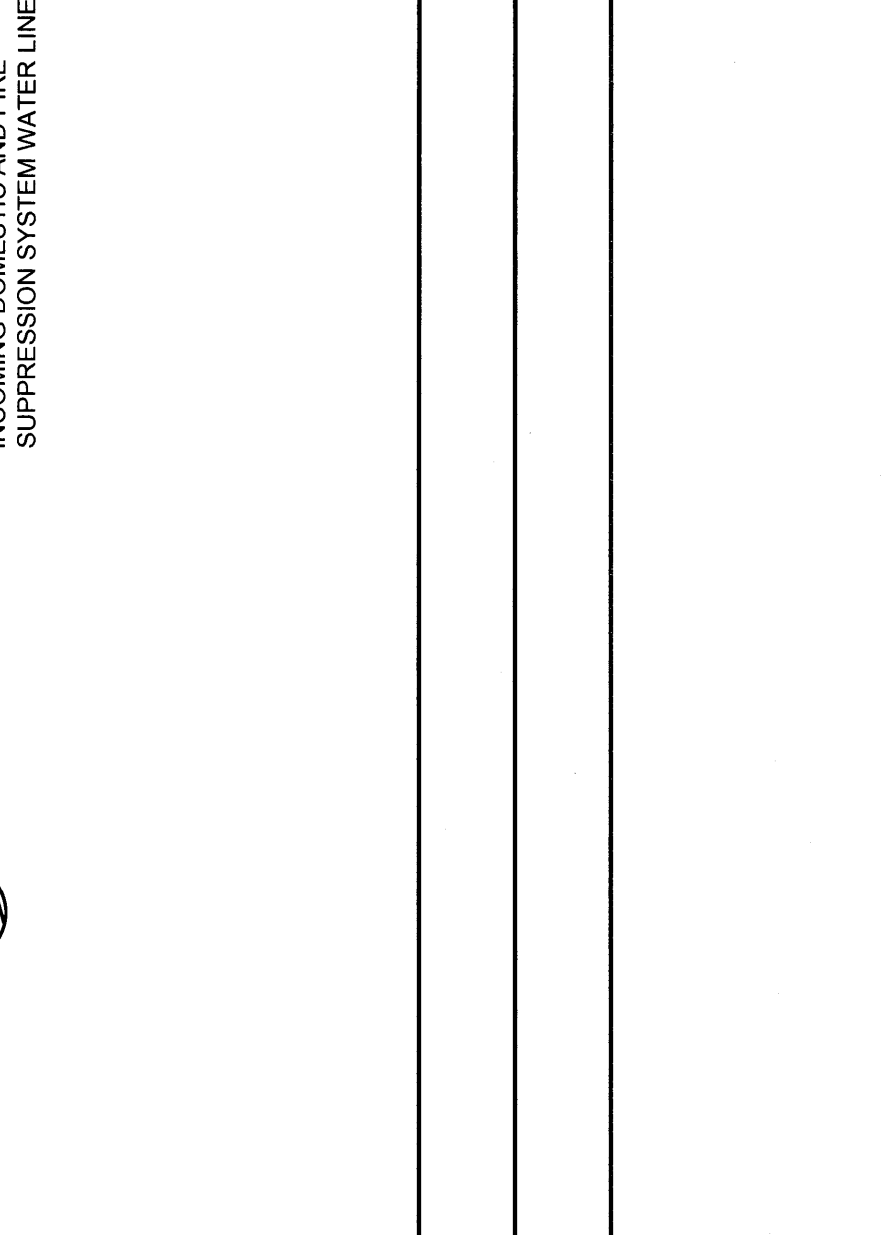
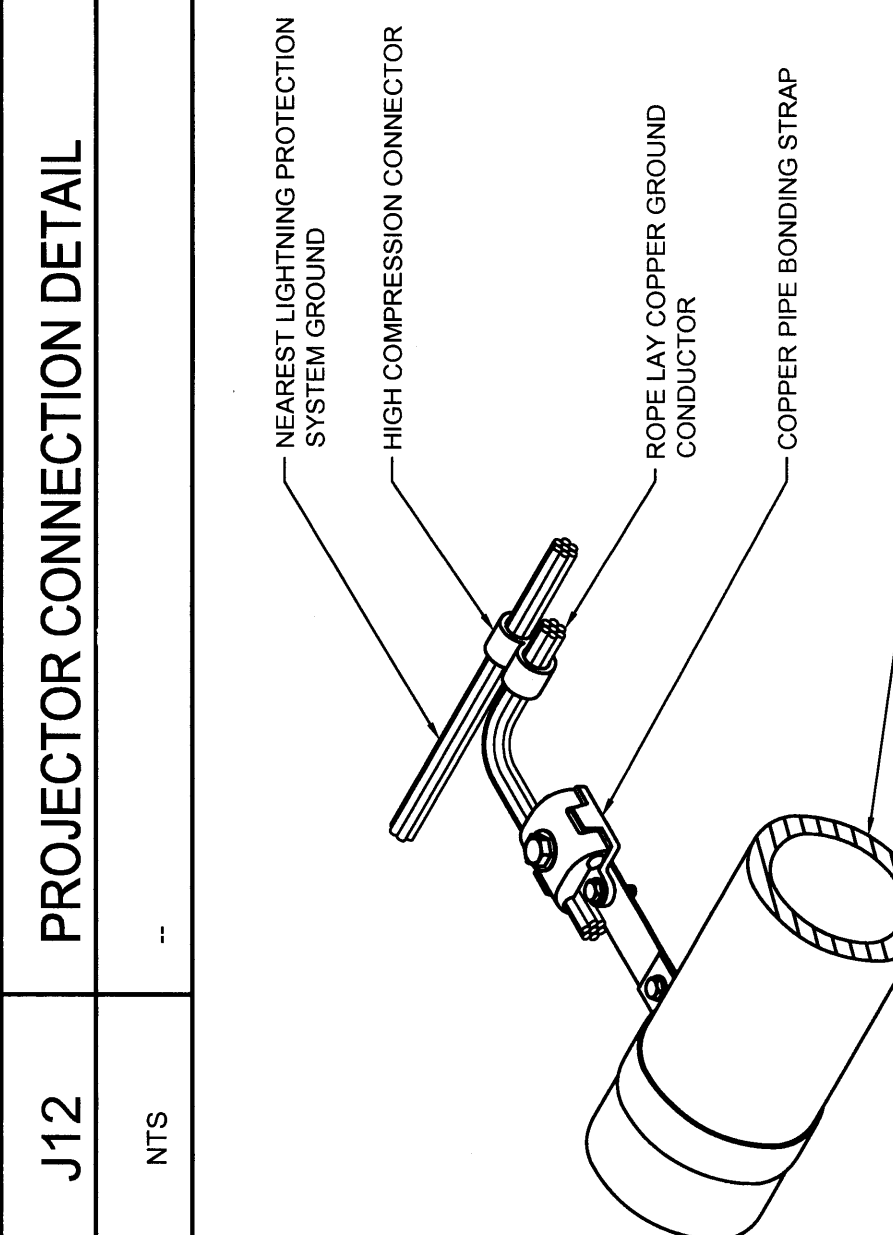
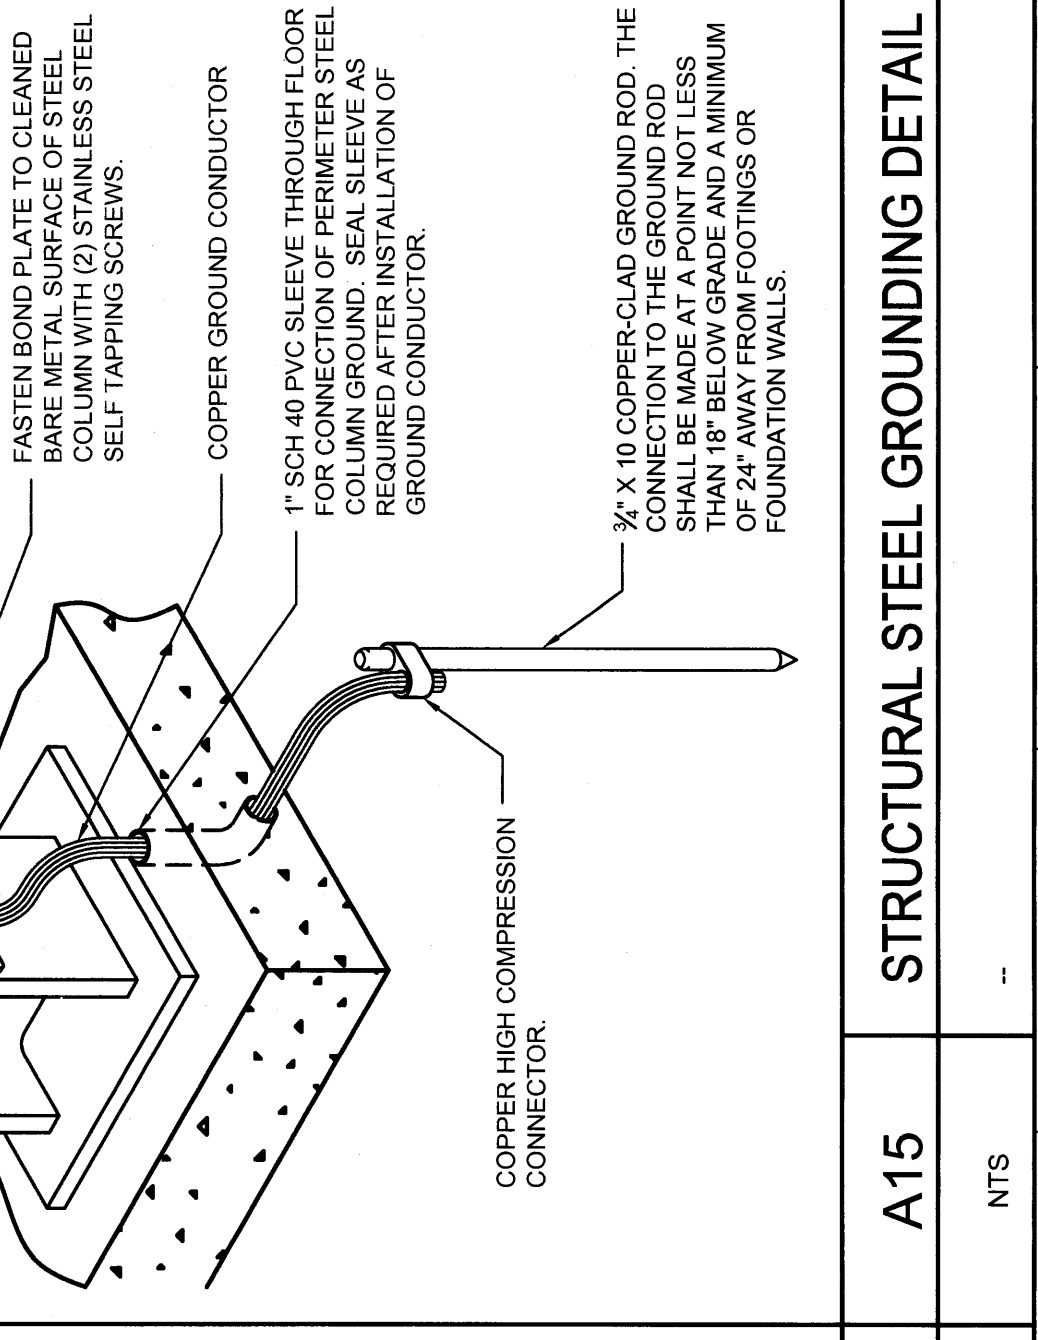


GENERAL NOTES:
 1. MATERIAL COMPATIBILITY SHALL CONFORM TO NFPA 780 & UL 96A REQUIREMENTS.
 2. MATERIAL CHASS SHALL CONFORM TO NFPA 780 & UL 96A REQUIREMENTS.
 3. AIR TERMINAL SPACING SHALL CONFORM TO NFPA 780 REQUIREMENTS.
 4. AIR TERMINALS SHALL BE UL LISTED.

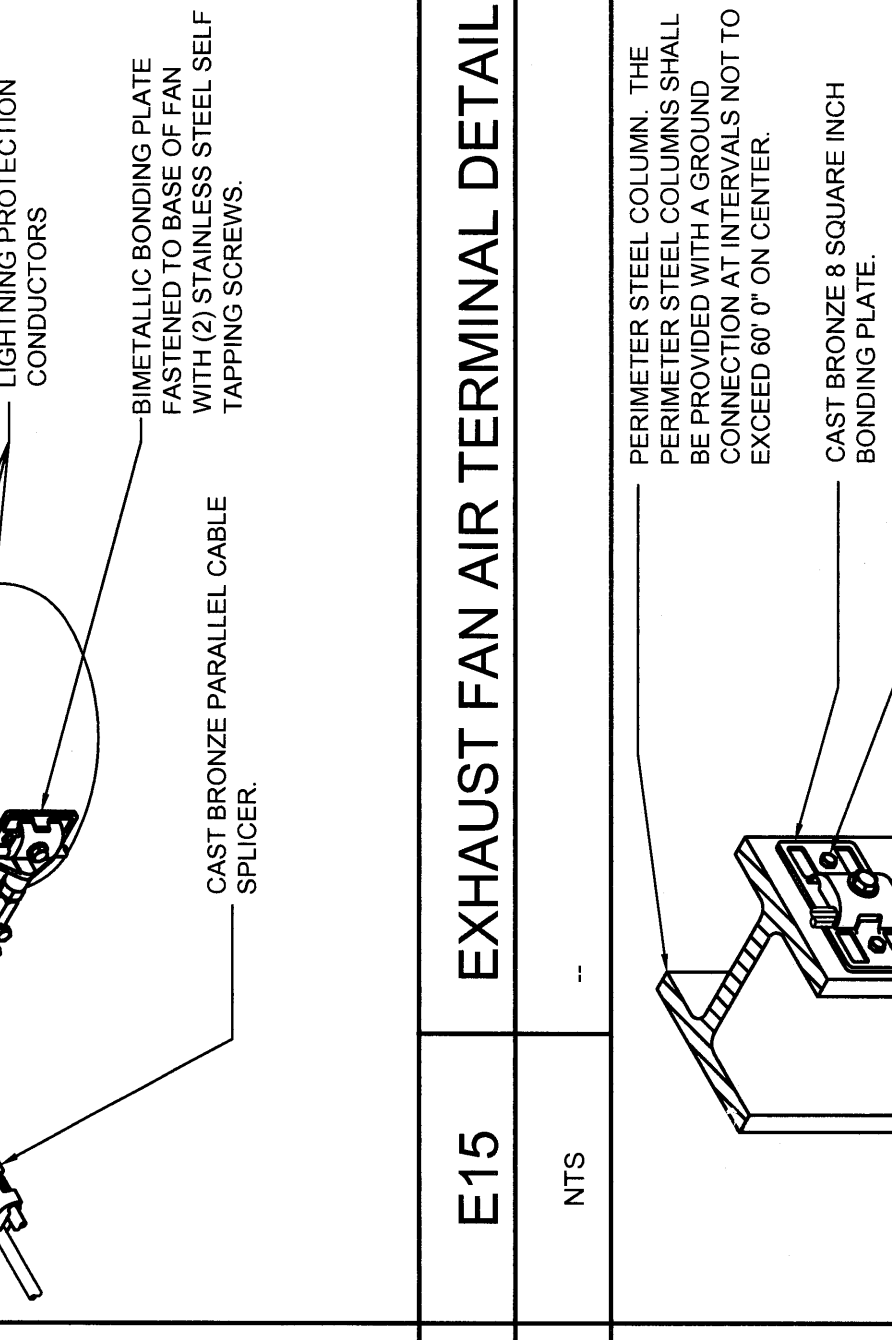

GENERAL NOTES:
 1. MATERIAL COMPATIBILITY SHALL CONFORM TO NFPA 780 & UL 96A REQUIREMENTS.
 2. MATERIAL CHASS SHALL CONFORM TO NFPA 780 & UL 96A REQUIREMENTS.
 3. AIR TERMINAL SPACING SHALL CONFORM TO NFPA 780 REQUIREMENTS.
 4. AIR TERMINALS SHALL BE UL LISTED.

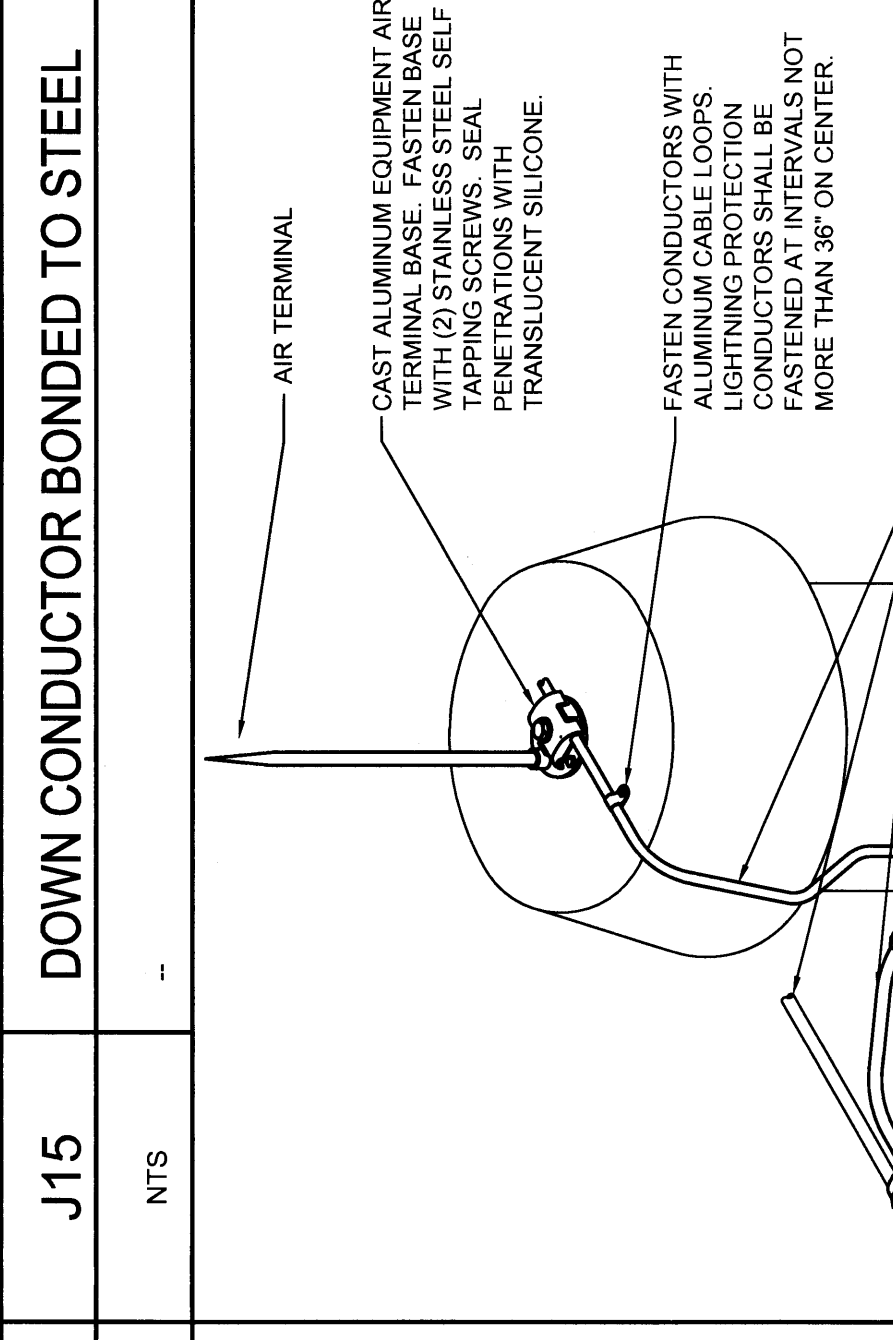

REV.	DESCRIPTION	DATE
0	ISSUED FOR PERMIT	02/02/09

E1	NTS	---	---	---
E5	NTS	---	---	---
E8	NTS	---	---	---
E15	NTS	---	---	---
J1	NTS	---	---	---
J12	NTS	---	---	---
J15	NTS	---	---	---
N15	NTS	---	---	---

E1	NTS	---	---	---
E5	NTS	---	---	---
E8	NTS	---	---	---
E15	NTS	---	---	---
J1	NTS	---	---	---
J12	NTS	---	---	---
J15	NTS	---	---	---
N15	NTS	---	---	---

E1	NTS	---	---	---
E5	NTS	---	---	---
E8	NTS	---	---	---
E15	NTS	---	---	---
J1	NTS	---	---	---
J12	NTS	---	---	---
J15	NTS	---	---	---
N15	NTS	---	---	---

E1	NTS	---	---	---
E5	NTS	---	---	---
E8	NTS	---	---	---
E15	NTS	---	---	---
J1	NTS	---	---	---
J12	NTS	---	---	---
J15	NTS	---	---	---
N15	NTS	---	---	---

E1	NTS	---	---	---
E5	NTS	---	---	---
E8	NTS	---	---	---
E15	NTS	---	---	---
J1	NTS	---	---	---
J12	NTS	---	---	---
J15	NTS	---	---	---
N15	NTS	---	---	---

E1	NTS	---	---	---
E5	NTS	---	---	---
E8	NTS	---	---	---
E15	NTS	---	---	---
J1	NTS	---	---	---
J12	NTS	---	---	---
J15	NTS	---	---	---
N15	NTS	---	---	---

PERMIT APPLICATION
 SUBMISSION 3-18-09
 CURRENT ISSUE STATUS:

WBRC
 ARCHITECTS • ENGINEERS
 100 WASHINGTON STREET, SUITE 1000
 PORTLAND, ME 04101
 PHONE: 407-445-1000
 FAX: 407-445-1001
 WWW: www.wbrc.com

PROJECT:	OCEAN AVENUE ELEMENTARY SCHOOL
PORTLAND, ME	
ELECTRICAL DETAILS	
PRODUCT:	331610
SCALE:	AS NOTED
DATE:	02/02/09

SHEET TITLE:	331610-E-503
SCALE:	AS NOTED
DATE:	02/02/09

SHEET TITLE:	331610-E-503
SCALE:	AS NOTED
DATE:	02/02/09

SHEET TITLE:	331610-E-503
SCALE:	AS NOTED
DATE:	02/02/09

SHEET TITLE:	331610-E-503
SCALE:	AS NOTED
DATE:	02/02/09