



FIRST FLOOR

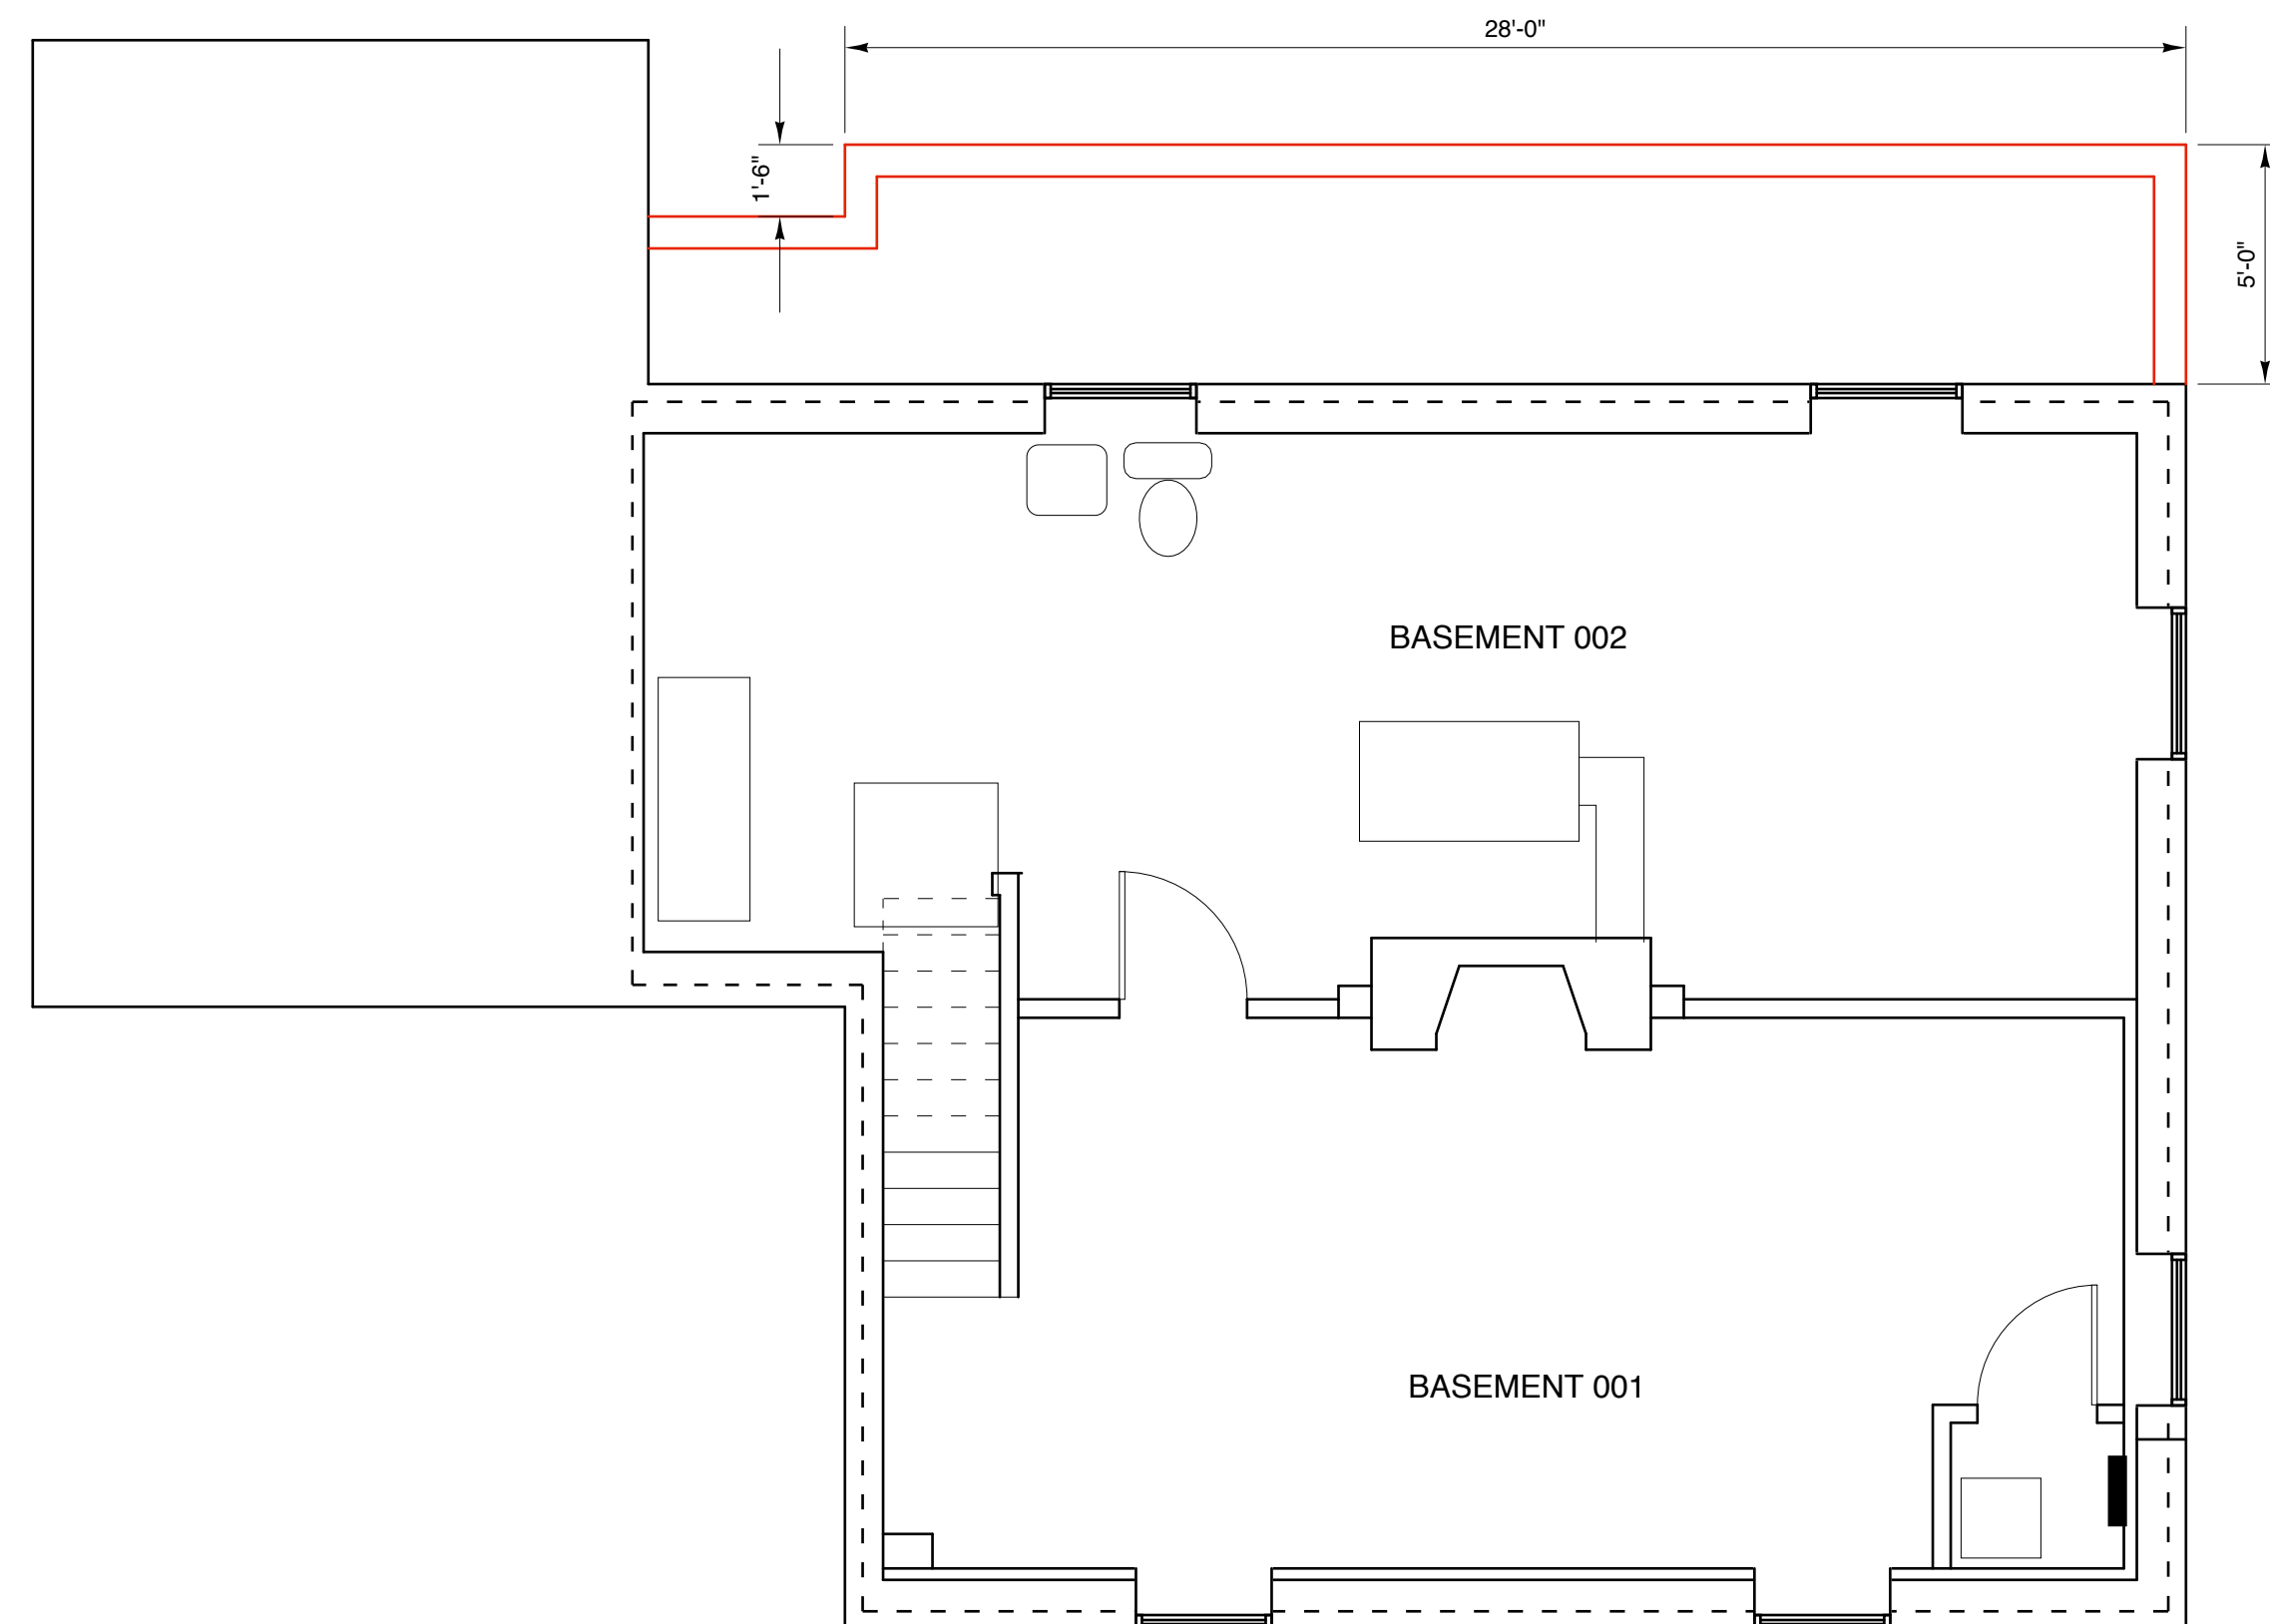


BASEMENT

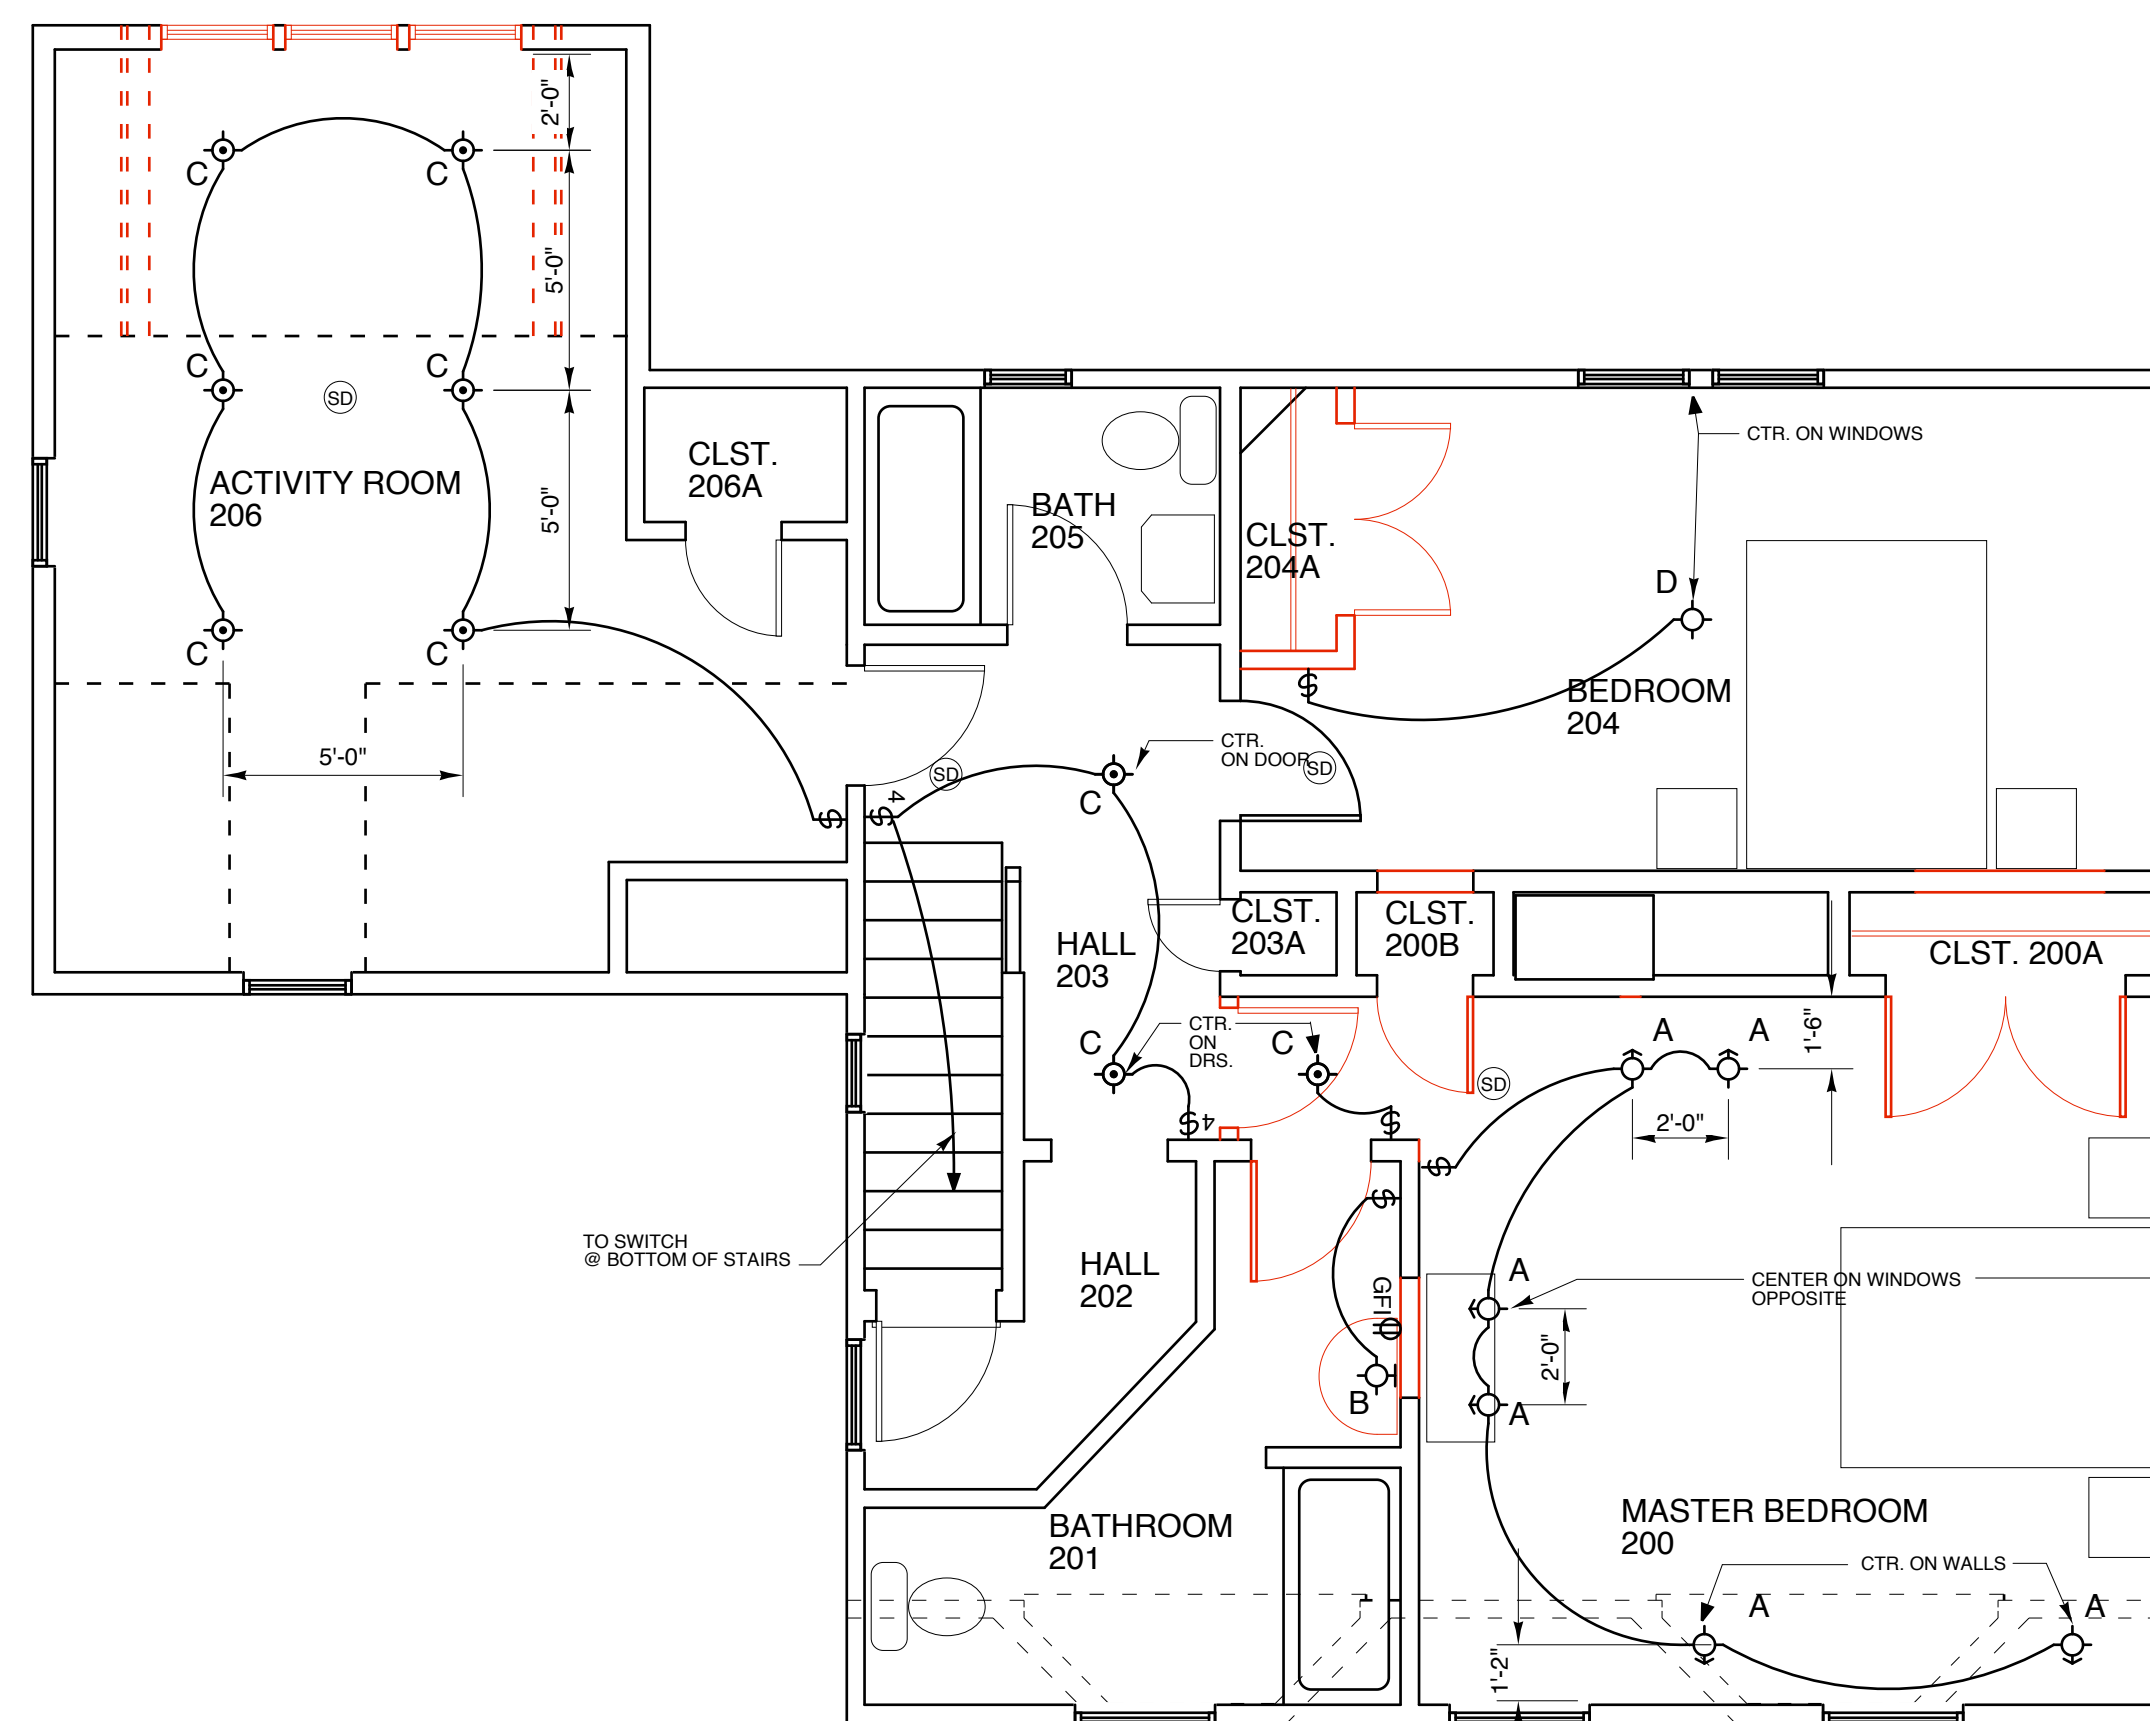

SECOND FLOOR

LIGHT FIXTURE SCHEDULE

TYPE A	RECESSED WALL WASHER	LIGHTOLIER	10004ICX/1096
TYPE B	BATHROOM WALL SCONCE	SEE ALLOWANCES	
TYPE C	RECESSED DOWNLIGHT	LIGHTOLIER	1004ICX/1046
TYPE D	CEILING SURFACE	LIGHTOLIER	TRIPLEX 5005WH226U
TYPE E	RECESSED DOWNLIGHT	LIGHTOLIER	1003R/1046
TYPE F	RECESSED WALL WASHER	LIGHTOLIER	1003R/1035WH
TYPE G	SUSPENDED LIGHT	SEE ALLOWANCES	
TYPE H	UNDERCABINET LIGHT	ALKCO	ECO28
TYPE H-1	UNDERCABINET LIGHT	ALKCO	ECO23
TYPE I	SUSPENDED LIGHT	SEE ALLOWANCES	
TYPE J	RECESSED ENTRANCE LIGHT	LIGHTOLIER	1104ICX/1128
TYPE K	RECESSED DOWNLIGHT	LIGHTOLIER	1002P/11046
TYPE L	RECESSED WALL WASHER	LIGHTOLIER	1002P/1096
TYPE M	RECESSED DOWNLIGHT	LIGHTOLIER	2000AIC/2013

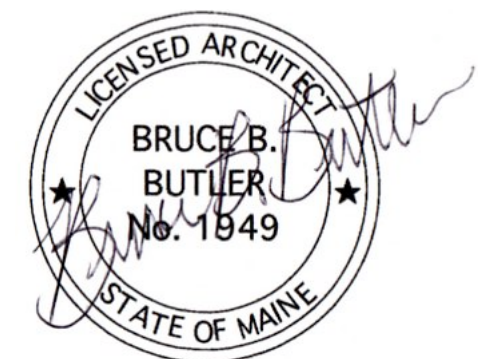

**LAWLER RESIDENCE**  
116 Parsons Road  
Portland Maine

By **Bruce B. Butler**  
Architect  
AIA

SCALE 1/4" = 1'-0"

DRAWN BY: **BBB**

DATE: 5/20/08

PROJECT NO.:

PROPOSED LIGHTING PLANS

**A400**