

MARK	DATE	DESCRIPTION

DATE:	6.1.13
CHECKED BY:	JAD
DRAWN BY:	Initials
JOB:	10-2013
SHEET TITLE:	THIRD FLOOR PLAN

ELECTRICAL SYMBOLS- EXISTING TO REMAIN IN UNDISTURBED SPACES

- ⊕ DUPLEX OUTLET 18" A.F.F. - PROVIDE GFI'S IN BATHROOMS AND NET AREAS
- ⊕ DOUBLE DUPLEX OUTLET 18" A.F.F.
- ⊕ SPECIAL PURPOSE POWER OUTLET - CONSULT OWNER - RE STOVE, MICROWAVE, DISPOSAL
- ⊕ WALL PHONE JACK 18" A.F.F. UNLESS NOTED OTHERWISE
- ⊕ CABLE TV IF REQ'D - ASK OWNER
- ⊕ SWITCH
- ⊕ THREE-WAY SWITCH
- ⊕ COMPUTER - CONSULT OWNER - RE INTERNET CONNECTION


- ⊕ DUPLEX FLOOR OUTLET
- ⊕ CEILING FAN
- ⊕ EXHAUST FAN

LIGHTING SYMBOLS

- ⊕ RECESSED CAN FIXTURE
- ⊕ WALL SCONCE
- ⊕ EXTERIOR WALL SCONCE
- ⊕ UTILITY LIGHT
- ⊕ SURFACE MOUNTED FIXTURE
- ⊕ PENDANT
- ⊕ EXISTING TRACK LIGHT

LIFE SAFETY SYMBOLS

- S SMOKE DETECTOR
- FE FIRE EXT. WALL MTD.
- CO CARBON MONOXIDE DETECTOR

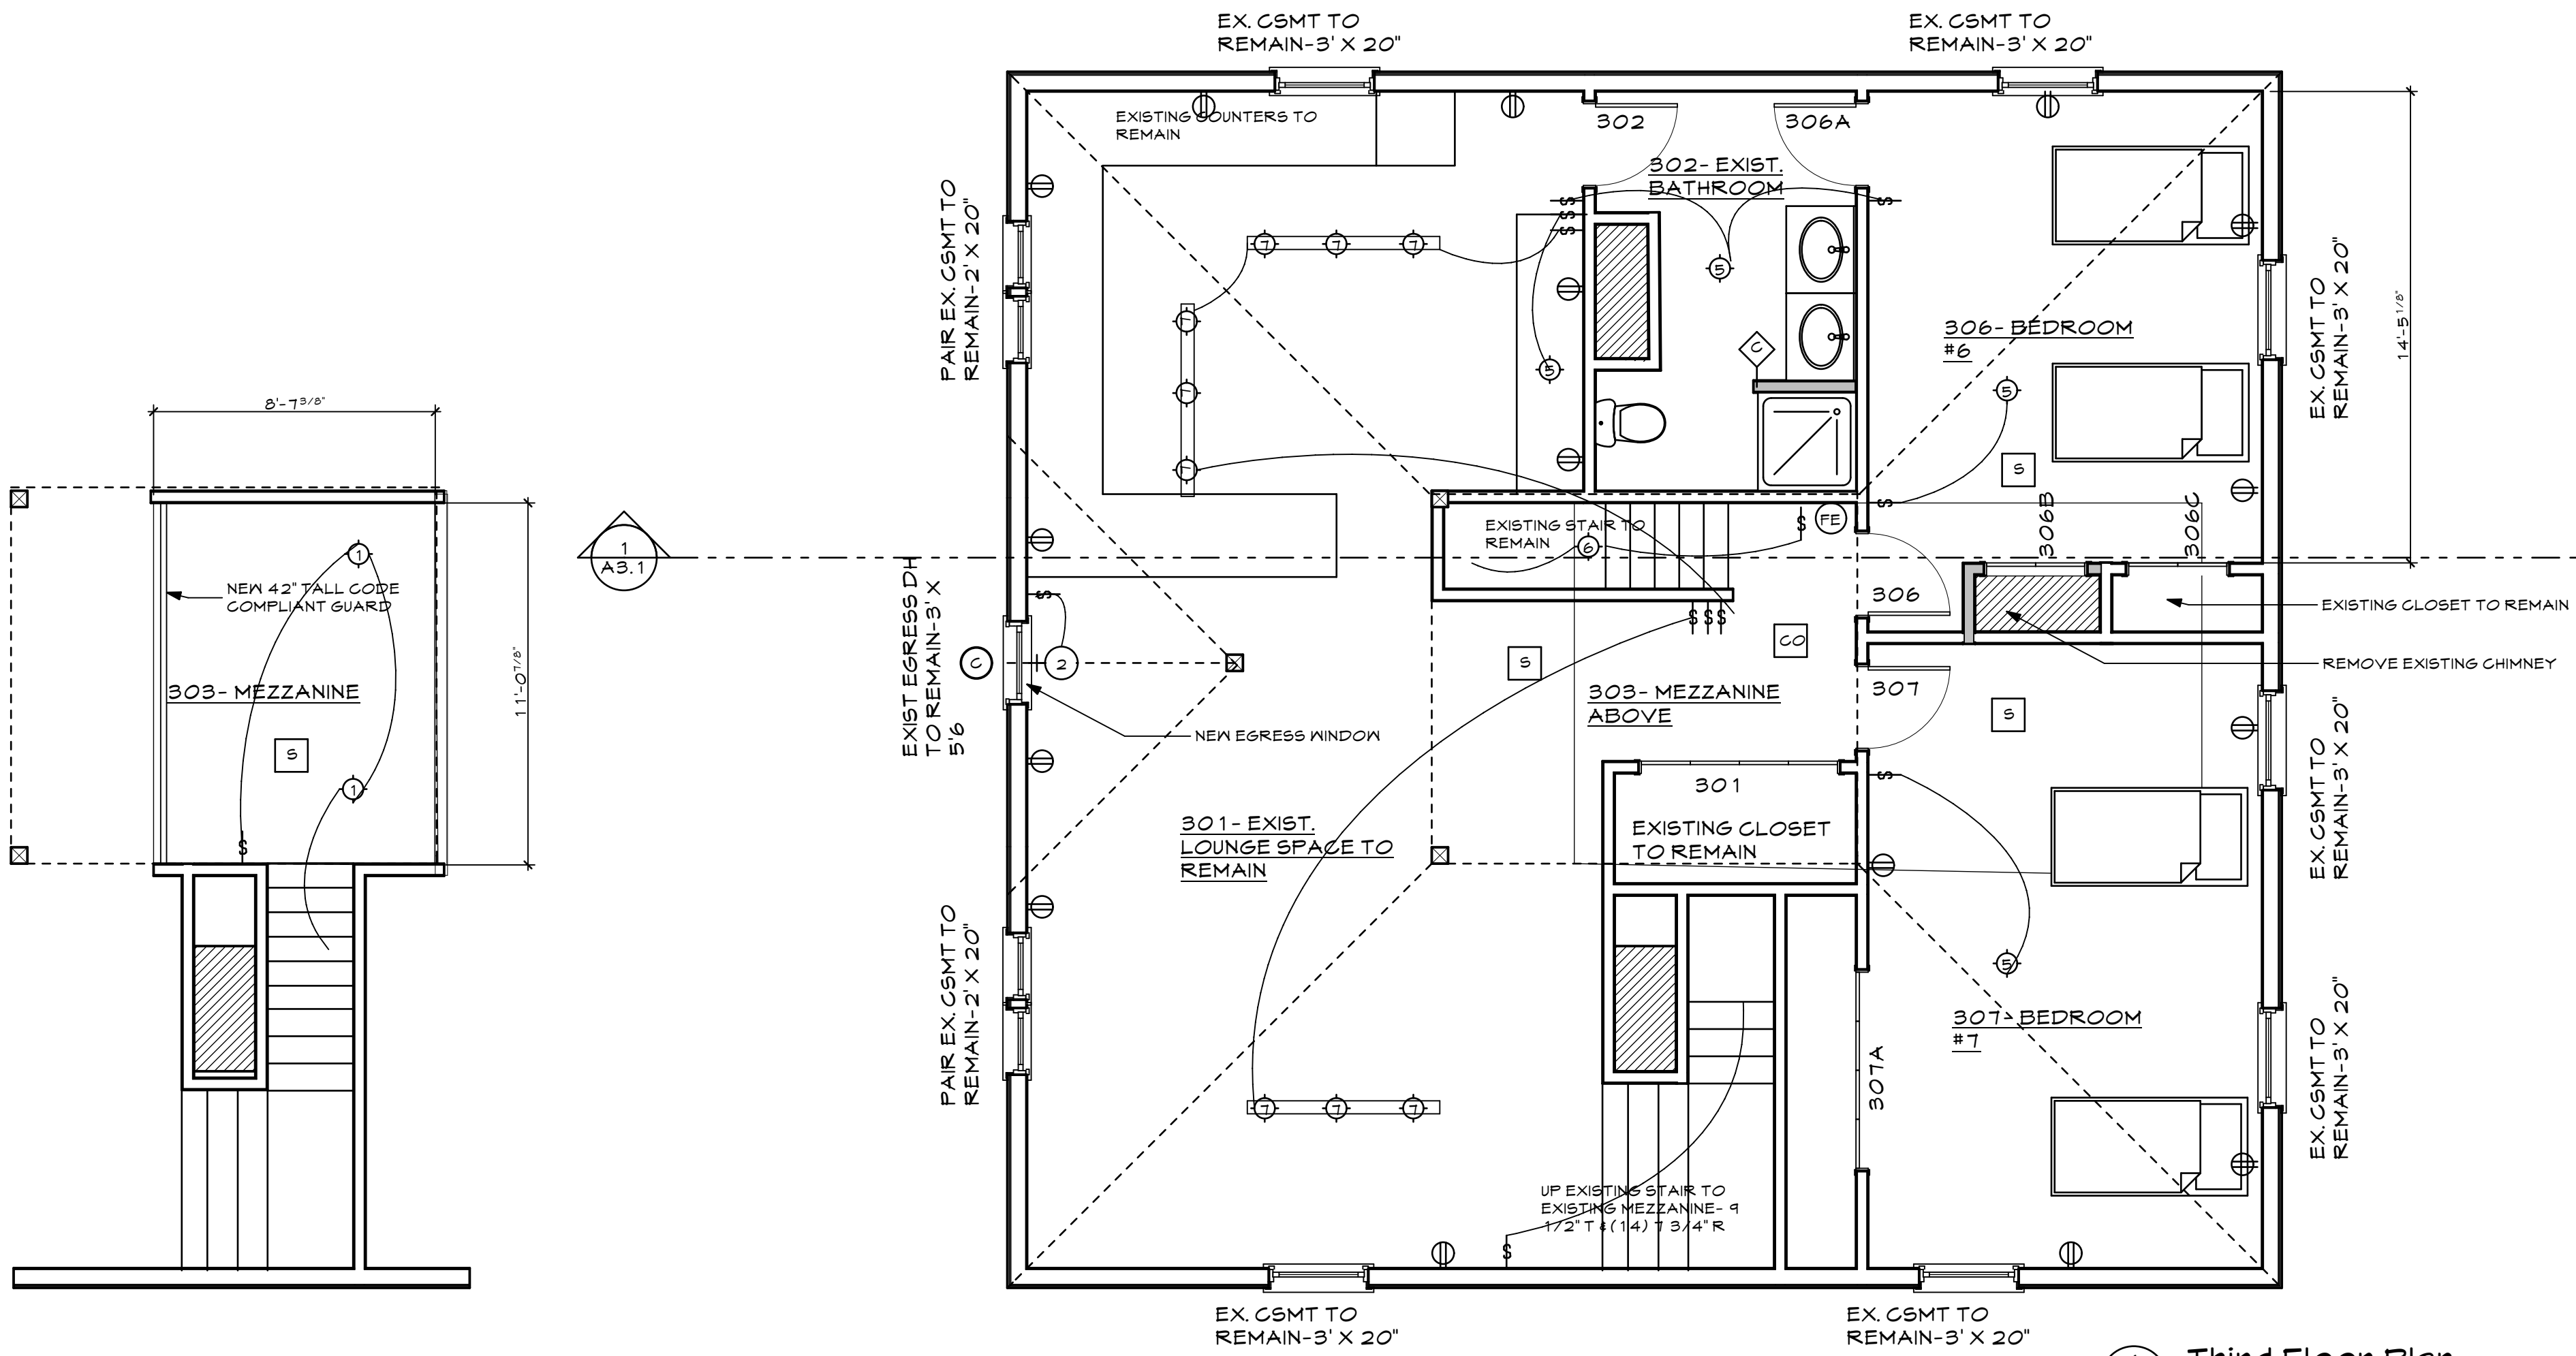

1 Third Floor Plan
A1.4 SCALE: 1/4" = 1'-0"

