


SCALE: 3/32" = 1'
C Size

UNIVERSITY OF NEW ENGLAND
WESTBROOK COLLEGE CAMPUS
COLEMAN
LOWER LEVEL

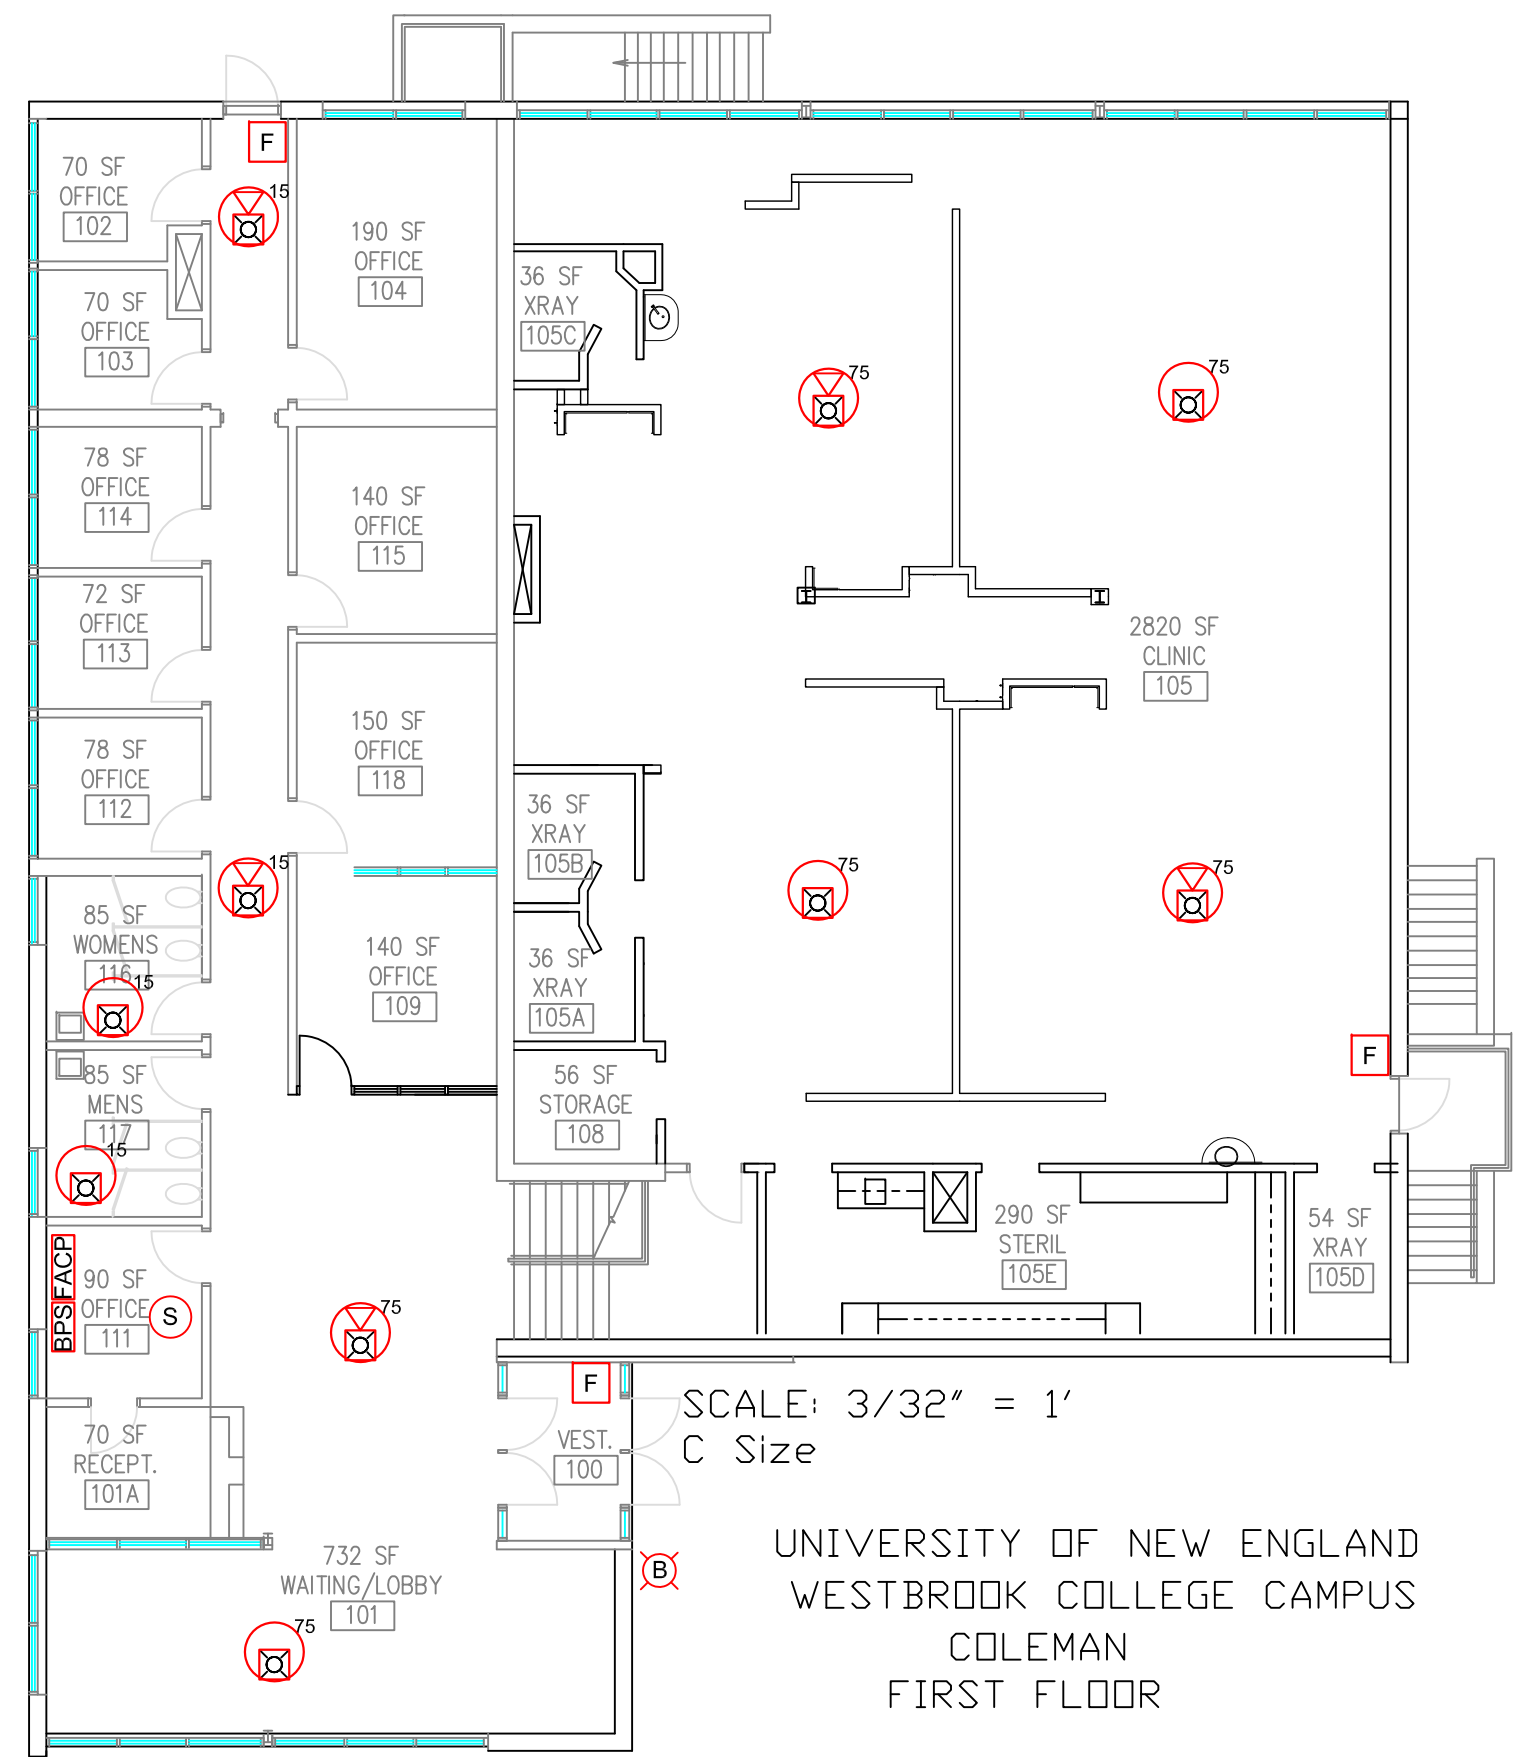

SCALE: 3/32" = 1'
C Size

UNIVERSITY OF NEW ENGLAND
WESTBROOK COLLEGE CAMPUS
COLEMAN
FIRST FLOOR

DWG NAME:

Coleman Hall
University of New England
Portland, Maine
Fire Alarm Riser Diagram
FA102

R.B. Allen
Co., Inc.

P.O. BOX 770
131 LAFALETTE RD
NO. HAMPSHIRE
1980-258-7254



EDWARDS SYSTEM TECHNOLOGY

Coleman Hall
University of New England
Portland, Maine
FIRE ALARM FLOOR PLANS

JOB NAME:

SCALE:	NTS	DATE	TRD	TRD
0	Original Issue	3/15	KMB	TRD
REV.	DESCRIPTION	DATE	DRWN:	R/W/D:

PO No.
Coleman Hall
UNE
Portland, Maine
FIRE ALARM
DWG NO. FA102