


Upper Level Plan

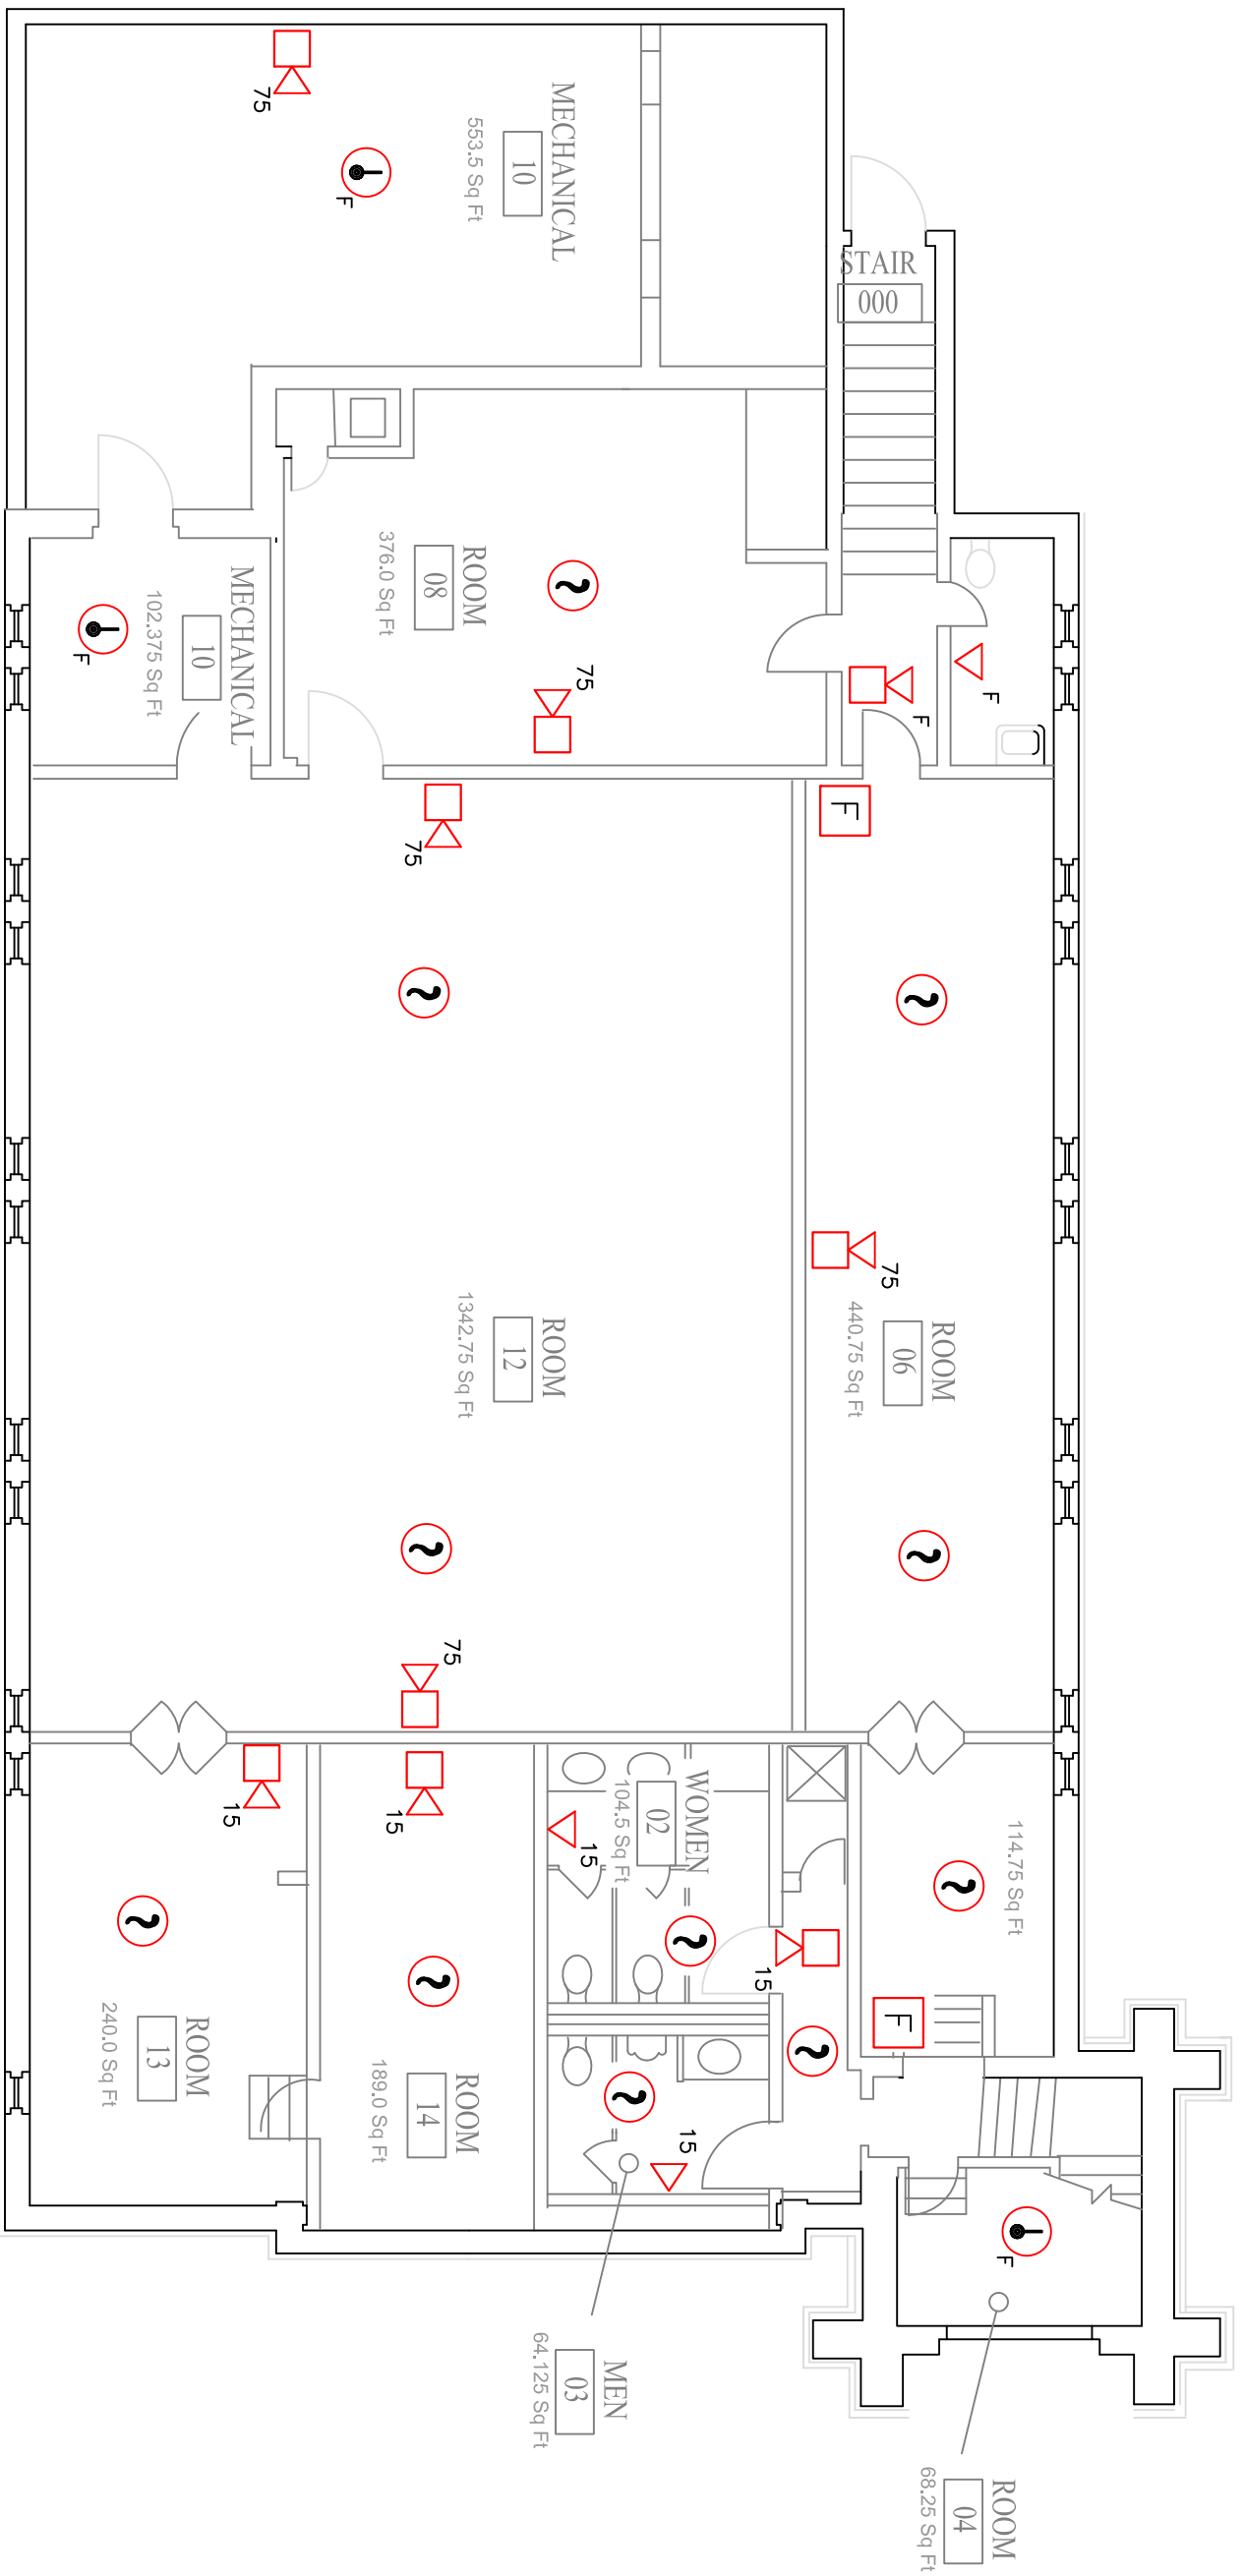


Lower Level Plan

0 1 2 3 4 5 6 7 8

SCALE: 1/8" = 1'-0"

JOB NAME:
**University of New England
 Ludcke Auditorium
 Portland, Maine
 FIRE ALARM FLOOR PLANS**

**R.B. Allen
 Co., Inc.**
 P.O. BOX 770
 131 LAFAYETTE RD
 NO. HAMPTON, NH 03862
 1-800-256-7264



EDWARDS SYSTEM TECHNOLOGY

DWG NAME:
**University of New England
 Ludcke Auditorium
 Portland, Maine
 FIRE ALARM FLOOR PLANS**

DWG No: FA-101

REV.	DESCRIPTION	DATE	DRWN:	RVW'D:
0	Original Issue	6/13	DHH	TRD

Contractor:

PO No. 803529
 University of New England - Ludcke Aud
 Portland, Maine
 FIRE ALARM PLANS
 DWG No. FA-101