


**Auditorium Round Table Plan**

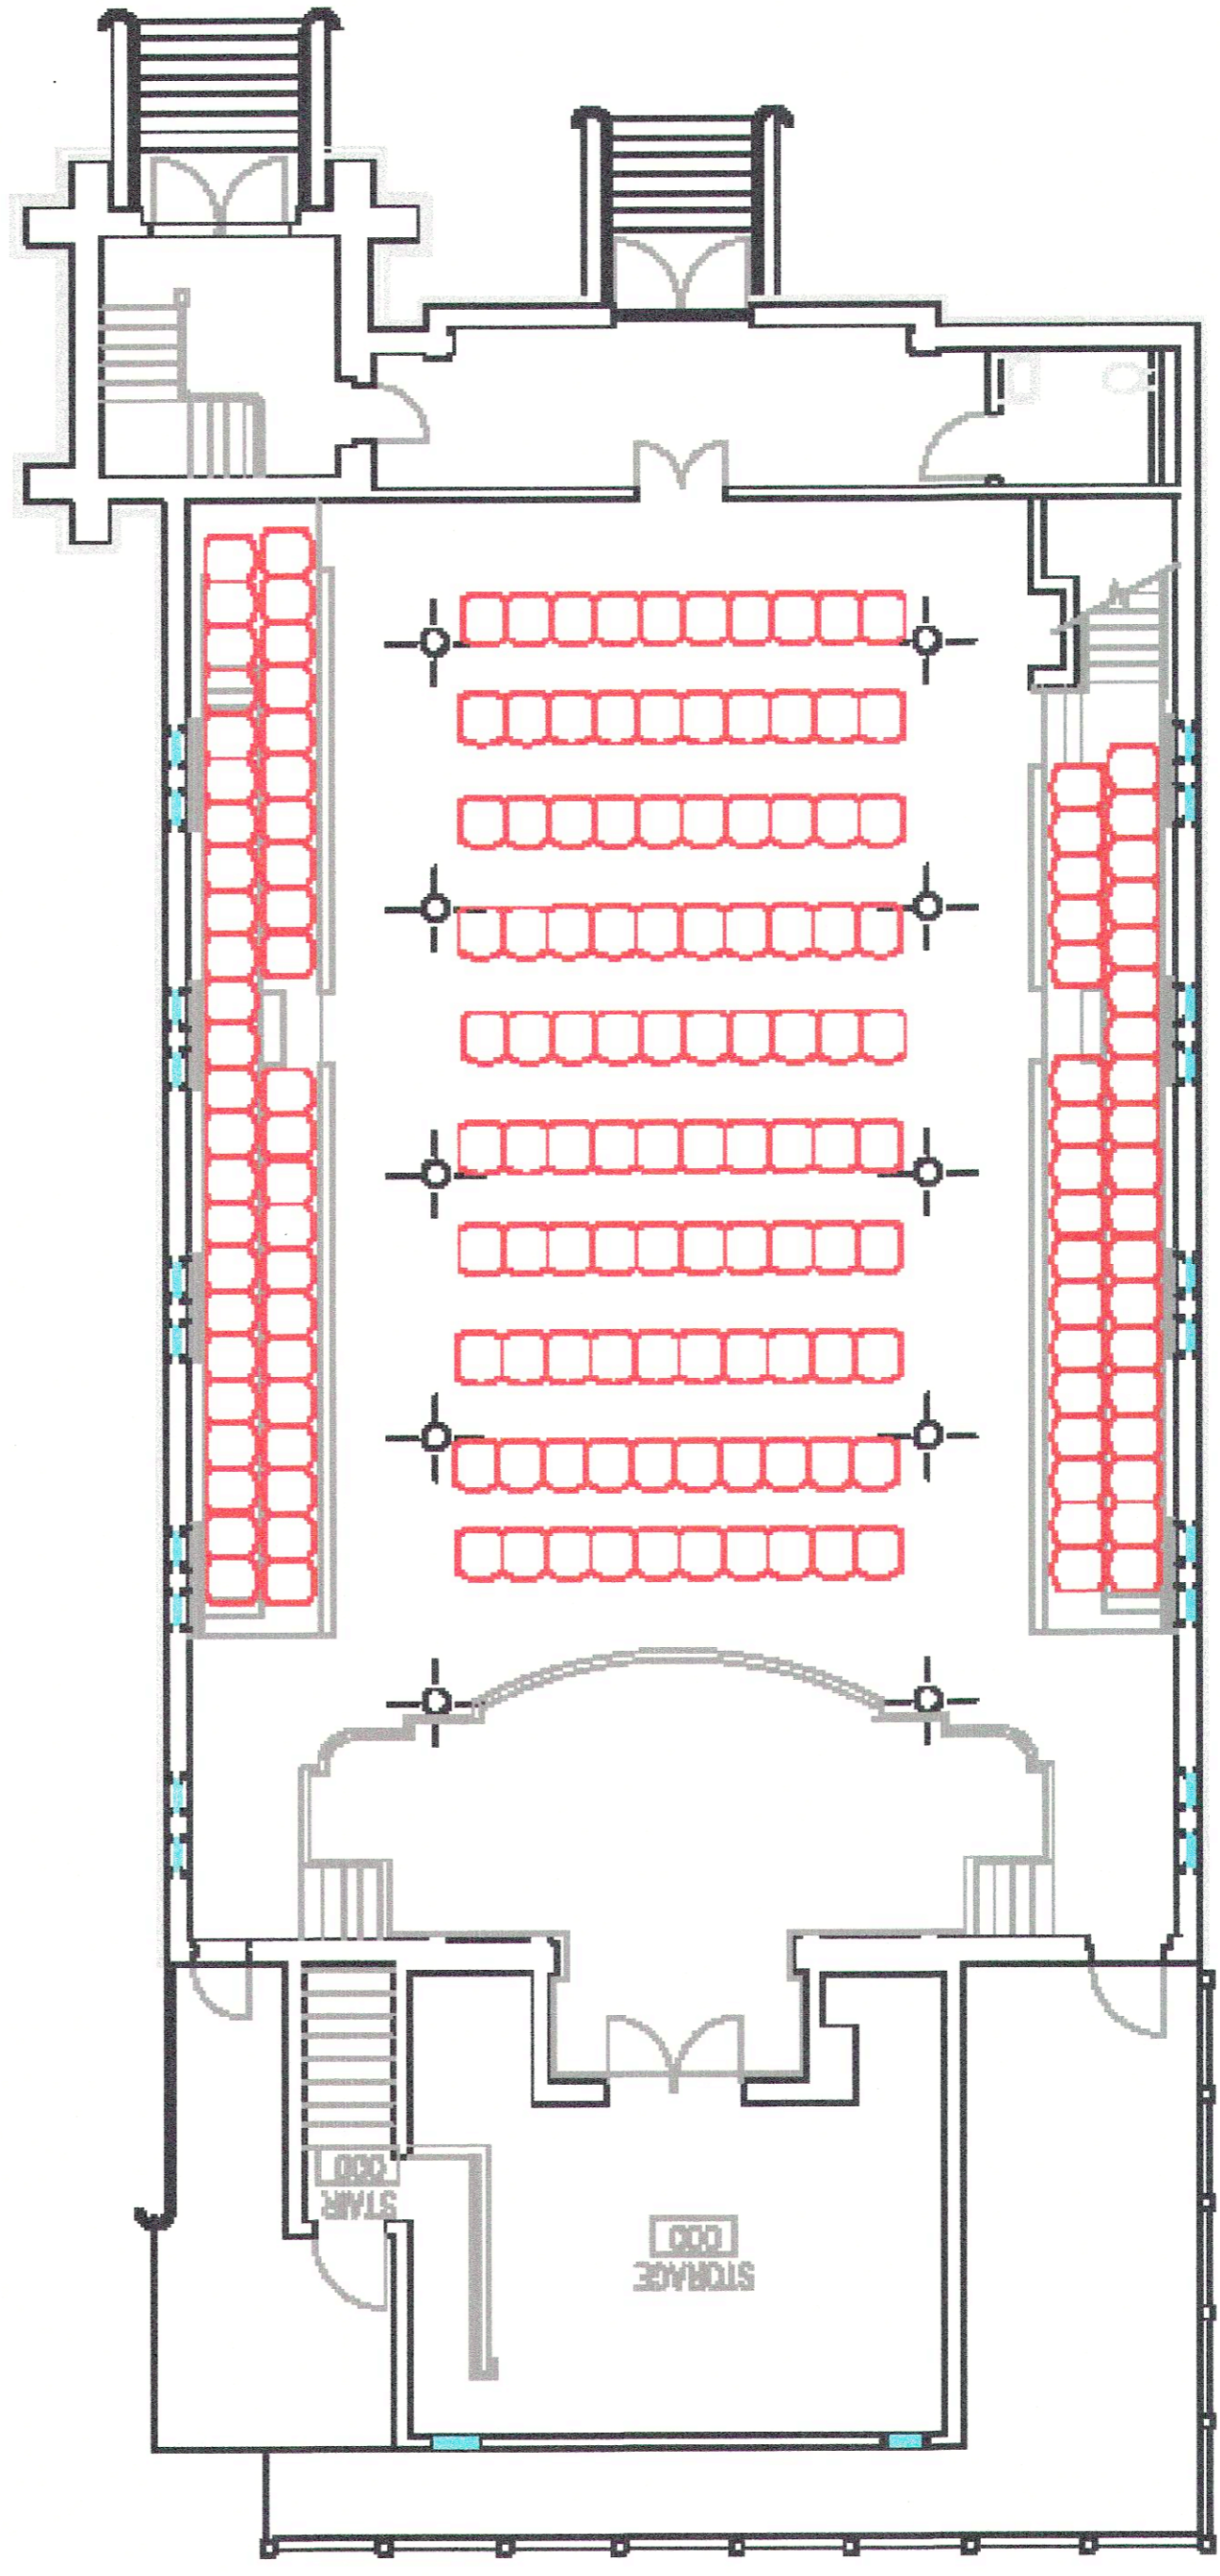

**Auditorium Seating Plan**

DWG NAME:  
 University of New England  
 Ludcke Auditorium  
 Portland, Maine  
 SEATING FLOOR PLANS  
 DWG No: FA-102

**R.B. Allen Co., Inc.**  
 P.O. BOX 770  
 131 LAFAVETTE RD  
 NO. HAMPTON  
 1304-257284

EST  
 ENVIRO SYSTEM TECHNOLOGY

JOB NAME:  
 University of New England  
 Ludcke Auditorium  
 Portland, Maine  
 SEATING FLOOR PLANS

Contractor:

SCALE: NTS	DATE	DRWN:	RW/D:	TRD
0	6/13	DHH		
REV.	DESCRIPTION			

PO No. 80529  
 University of New England - Ludcke Aud  
 Portland, Maine  
 SEATING PLANS  
 DWG NO. FA-102