


**Upper Level Plan**

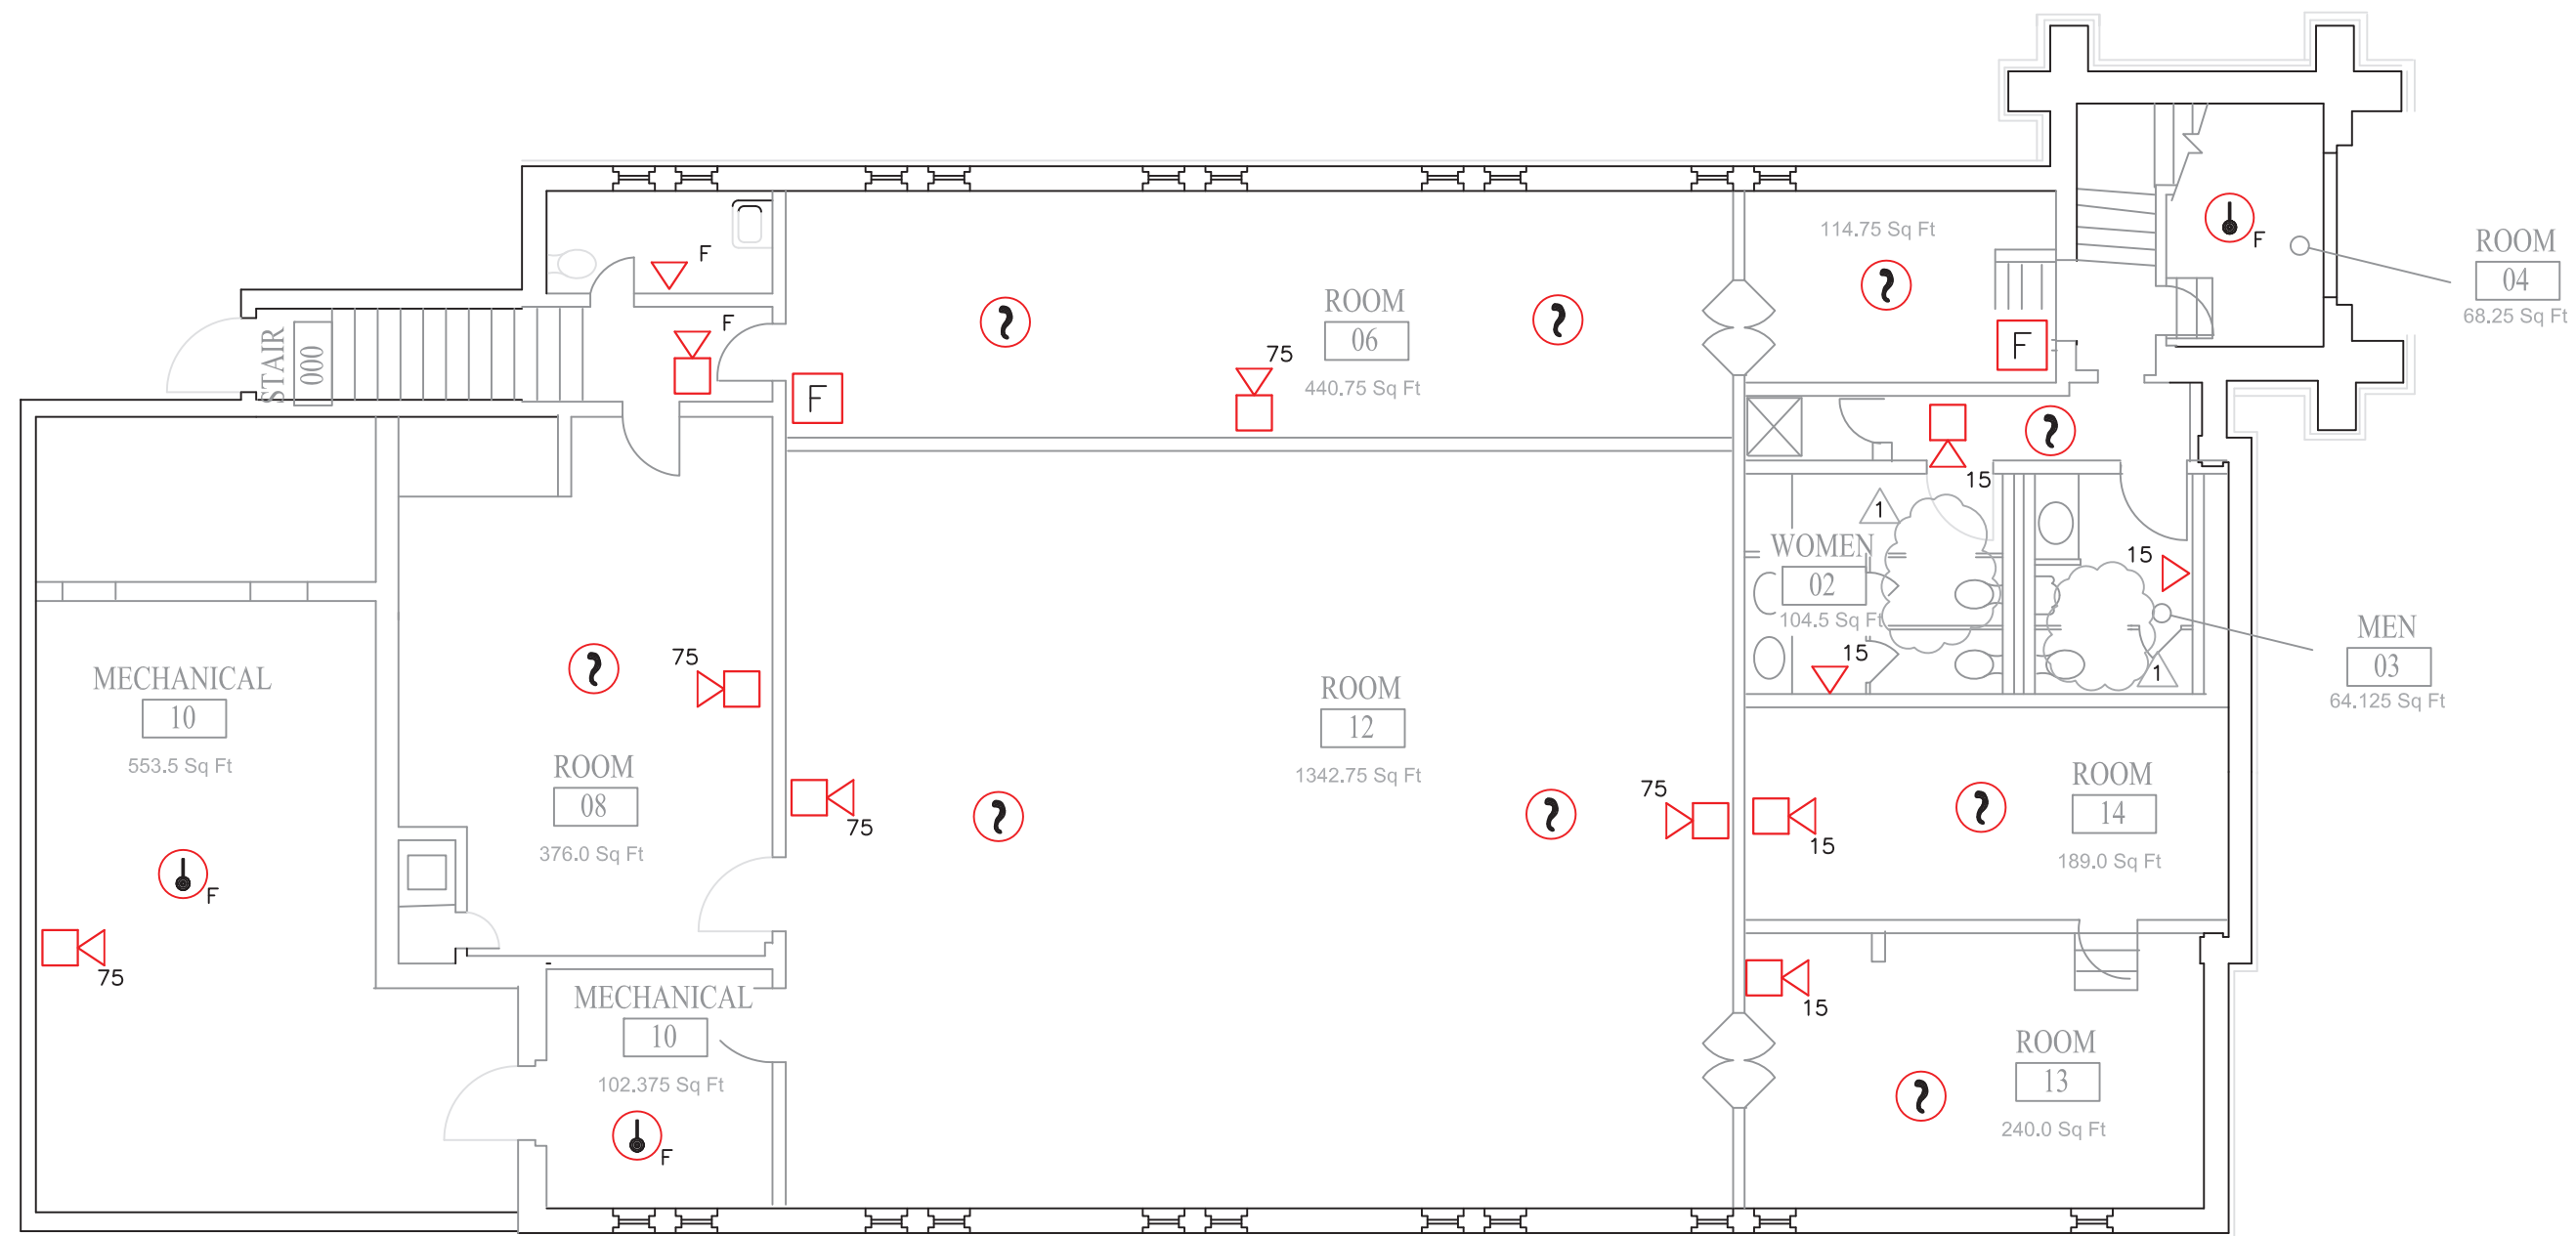

**Lower Level Plan**

DWG NAME:  
**University of New England**  
 Ludcke Auditorium  
 Portland, Maine  
**FIRE ALARM FLOOR PLANS**  
 DWG No: FA-101

**R.B. Allen Co., Inc.**  
 P.O. BOX 170  
 131 LAKE ST.  
 NO. HAMPTON, NH 03862  
 1-800-258-7284

**University of New England**  
 Ludcke Auditorium  
 Portland, Maine  
**FIRE ALARM FLOOR PLANS**

JOB NAME:  
 Contractor:

REV.	DESCRIPTION	DATE	DRWN:	IRWN/D:
1	Horn/Strobe Addition and Smokes Deleted	7/13	DHH	TRD
0	Original Issue	6/13	DHH	TRD

PO No. 80529  
 University of New England - Ludcke Aud  
 Portland, Maine  
**FIRE ALARM PLANS**  
 DWG No. FA-101