

PLUMBING FIXTURE SCHEDULE

TAG	DESCRIPTION	BRANCH SIZES				NOTES
		CW	HW	VENT	WASTE	
P-1	WATER CLOSET-FLUSH VALVE, FLOOR MOUNT, ADA COMPLIANT	1"	----	1-1/2"	3"	
P-1B	WATER CLOSET - TANK TYPE, FLOOR MOUNT, RIGHT HEIGHT	1/2"	----	1-1/2"	3"	
P-2	URINAL - FLUSH VALVE - 1/8 GAL/FLUSH	3/4"	----	1-1/2"	2"	
P-3A	LAVATORY, COUNTER MOUNT	3/8"	3/8"	1-1/2"	1-1/2"	
P-3B	LAVATORY, PEDESTAL TYPE	3/8"	3/8"	1-1/2"	1-1/2"	
P-3C	LAVATORY, WALL MOUNT	3/8"	3/8"	1-1/2"	1-1/2"	
P-4	KITCHEN SINK	1/2"	1/2"	1-1/2"	2"	
P-5	IMP/SERVICE BASIN	3/4"	3/4"	1-1/2"	3"	PROVIDE CHECK VALVES AT WATER INLETS
HB	HOSE BIBB	1/2"	----	----	----	
FD	FLOOR DRAIN			1-1/2"	2"	

ELECTRIC DHW HEATER SCHEDULE



TAG	SERVES	MANUFACTURER	MODEL	VOLTS	PHASE	HEAT INPUT (KW)	AMPS	MAX FLOW (GPM)	TEMP RISE (DEG-F)	WATER STORAGE (GAL)	HEIGHT (INCHES)	WIDTH (INCHES)	DEPTH (INCHES)
EWH-1	SINGLE SINK OR LAV	EEMAX	MT004120T	120	1	3.5	0.5	48	0	10.75"	5.25"	2.9"	
EWH-2	KITCHEN SINKS	EEMAX	MT010240T	208	1	9.5	1.0	48	0	13.5"	5.25"	4"	
EWH-3	MOP BASIN + LAVS	EEMAX	EMT6	120	1	1.44				6"	19"	15.5"	

NOTE: 208V WILL HAVE A 25% DERATING

PUMP SCHEDULE

TAG	SERVES	MAKE & MODEL	TYPE	GPM	HEAD	ELECTRICAL			BASIN				NOTES
						MOTOR HP	VOLTS/PH (60 Hz.)	DIA.	HEIGHT	INLET TYPE	INLET SIZE	DISCH SIZE	
SP-1	ELEV SUMP	ZOELLER M152	SUBMERSIBLE	53	15	0.4	115/1	18"	30"	HOLE IN BASIN COVER	3	1-1/2"	NOTE 2, NOTE 3.
EP-1	SANITARY	ZOELLER J840	SUBMERSIBLE	35	50	2	208/3	36"	60"	HOLES IN BASIN	4 & 6	1-1/4"	NOTE 1

NOTES:
1. DUPLEX MODEL
2. PLUG CONNECTIONS, COORDINATE LOCATION OF GFI OUTLETS.
3. PROVIDE OIL SMART SYSTEM

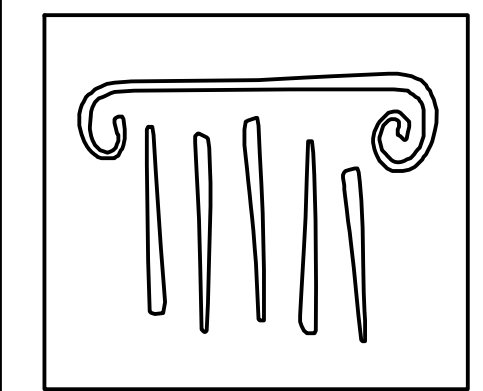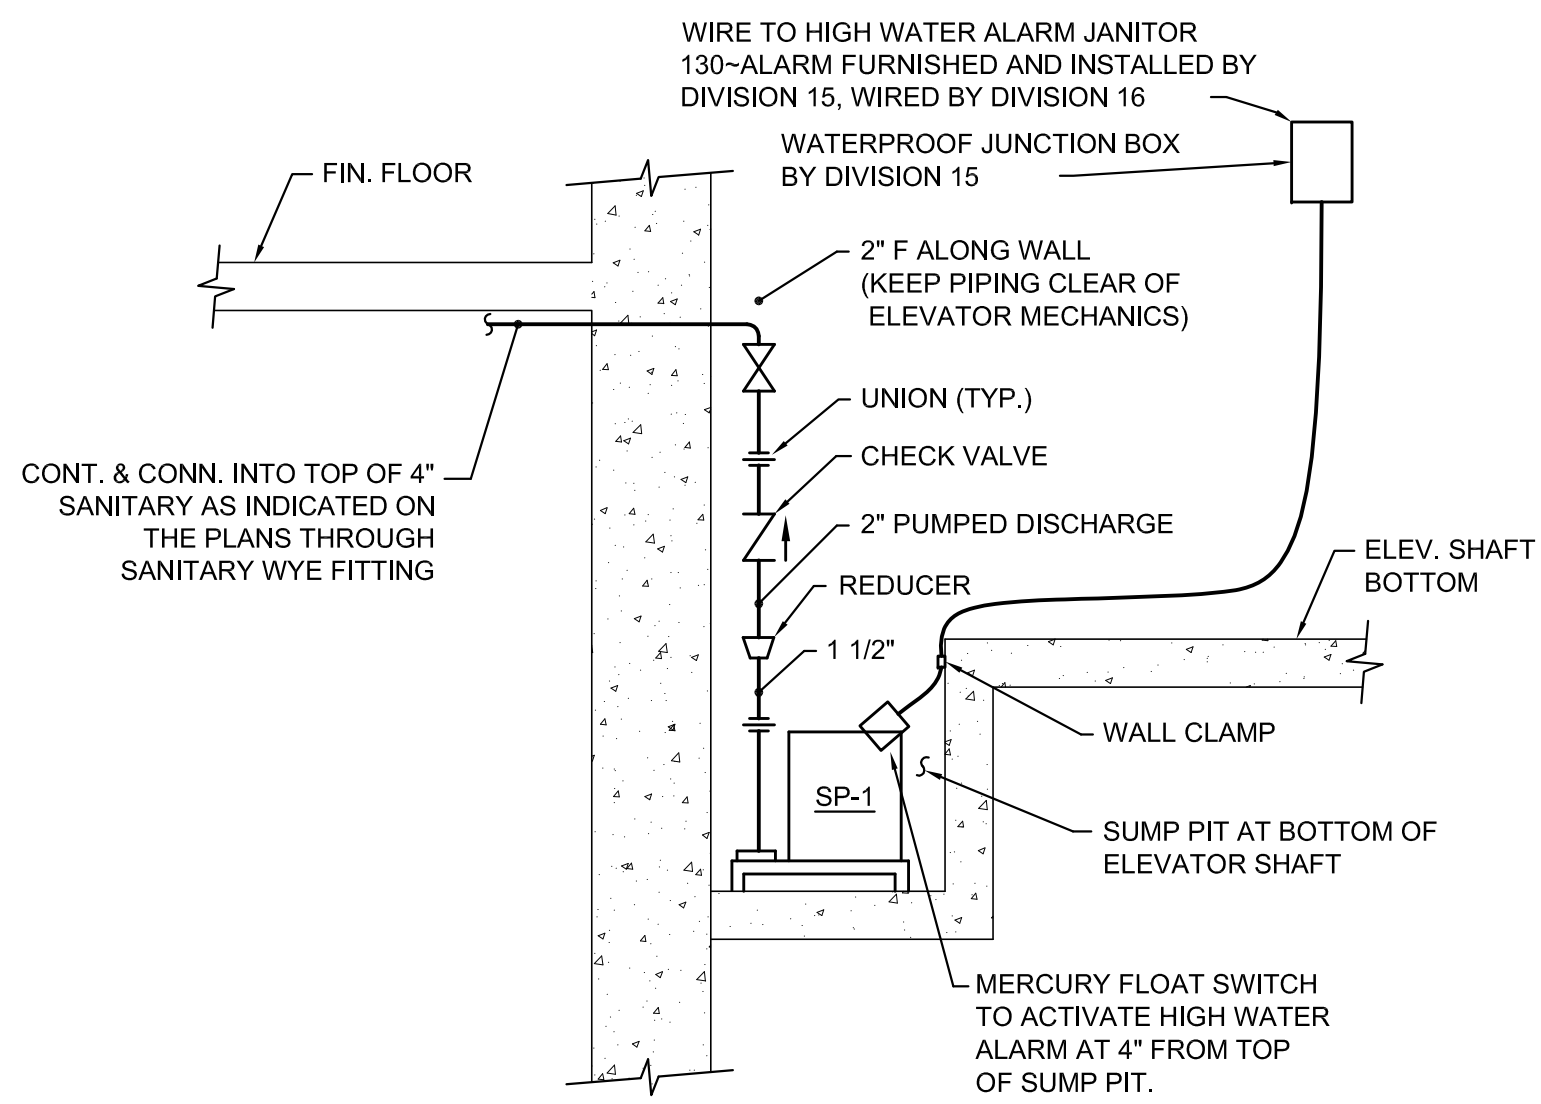



65 NEWBURY STREET
PORTLAND, ME 04101
207.761.9000
info@portcityarch.com
WWW.PORTCITYARCH.COM

F1 PLUMBING SCHEDULES

F8 DETAIL ~ ELEVATOR SUMP PUMP



NONE

NOT TO SCALE

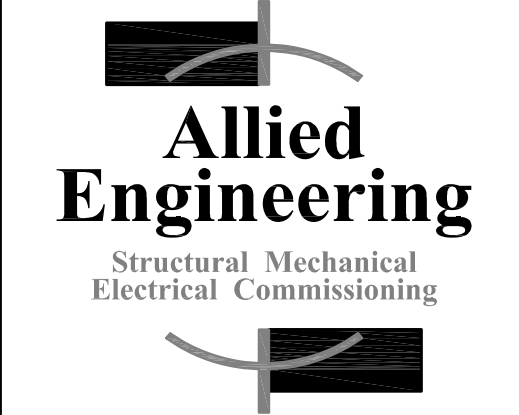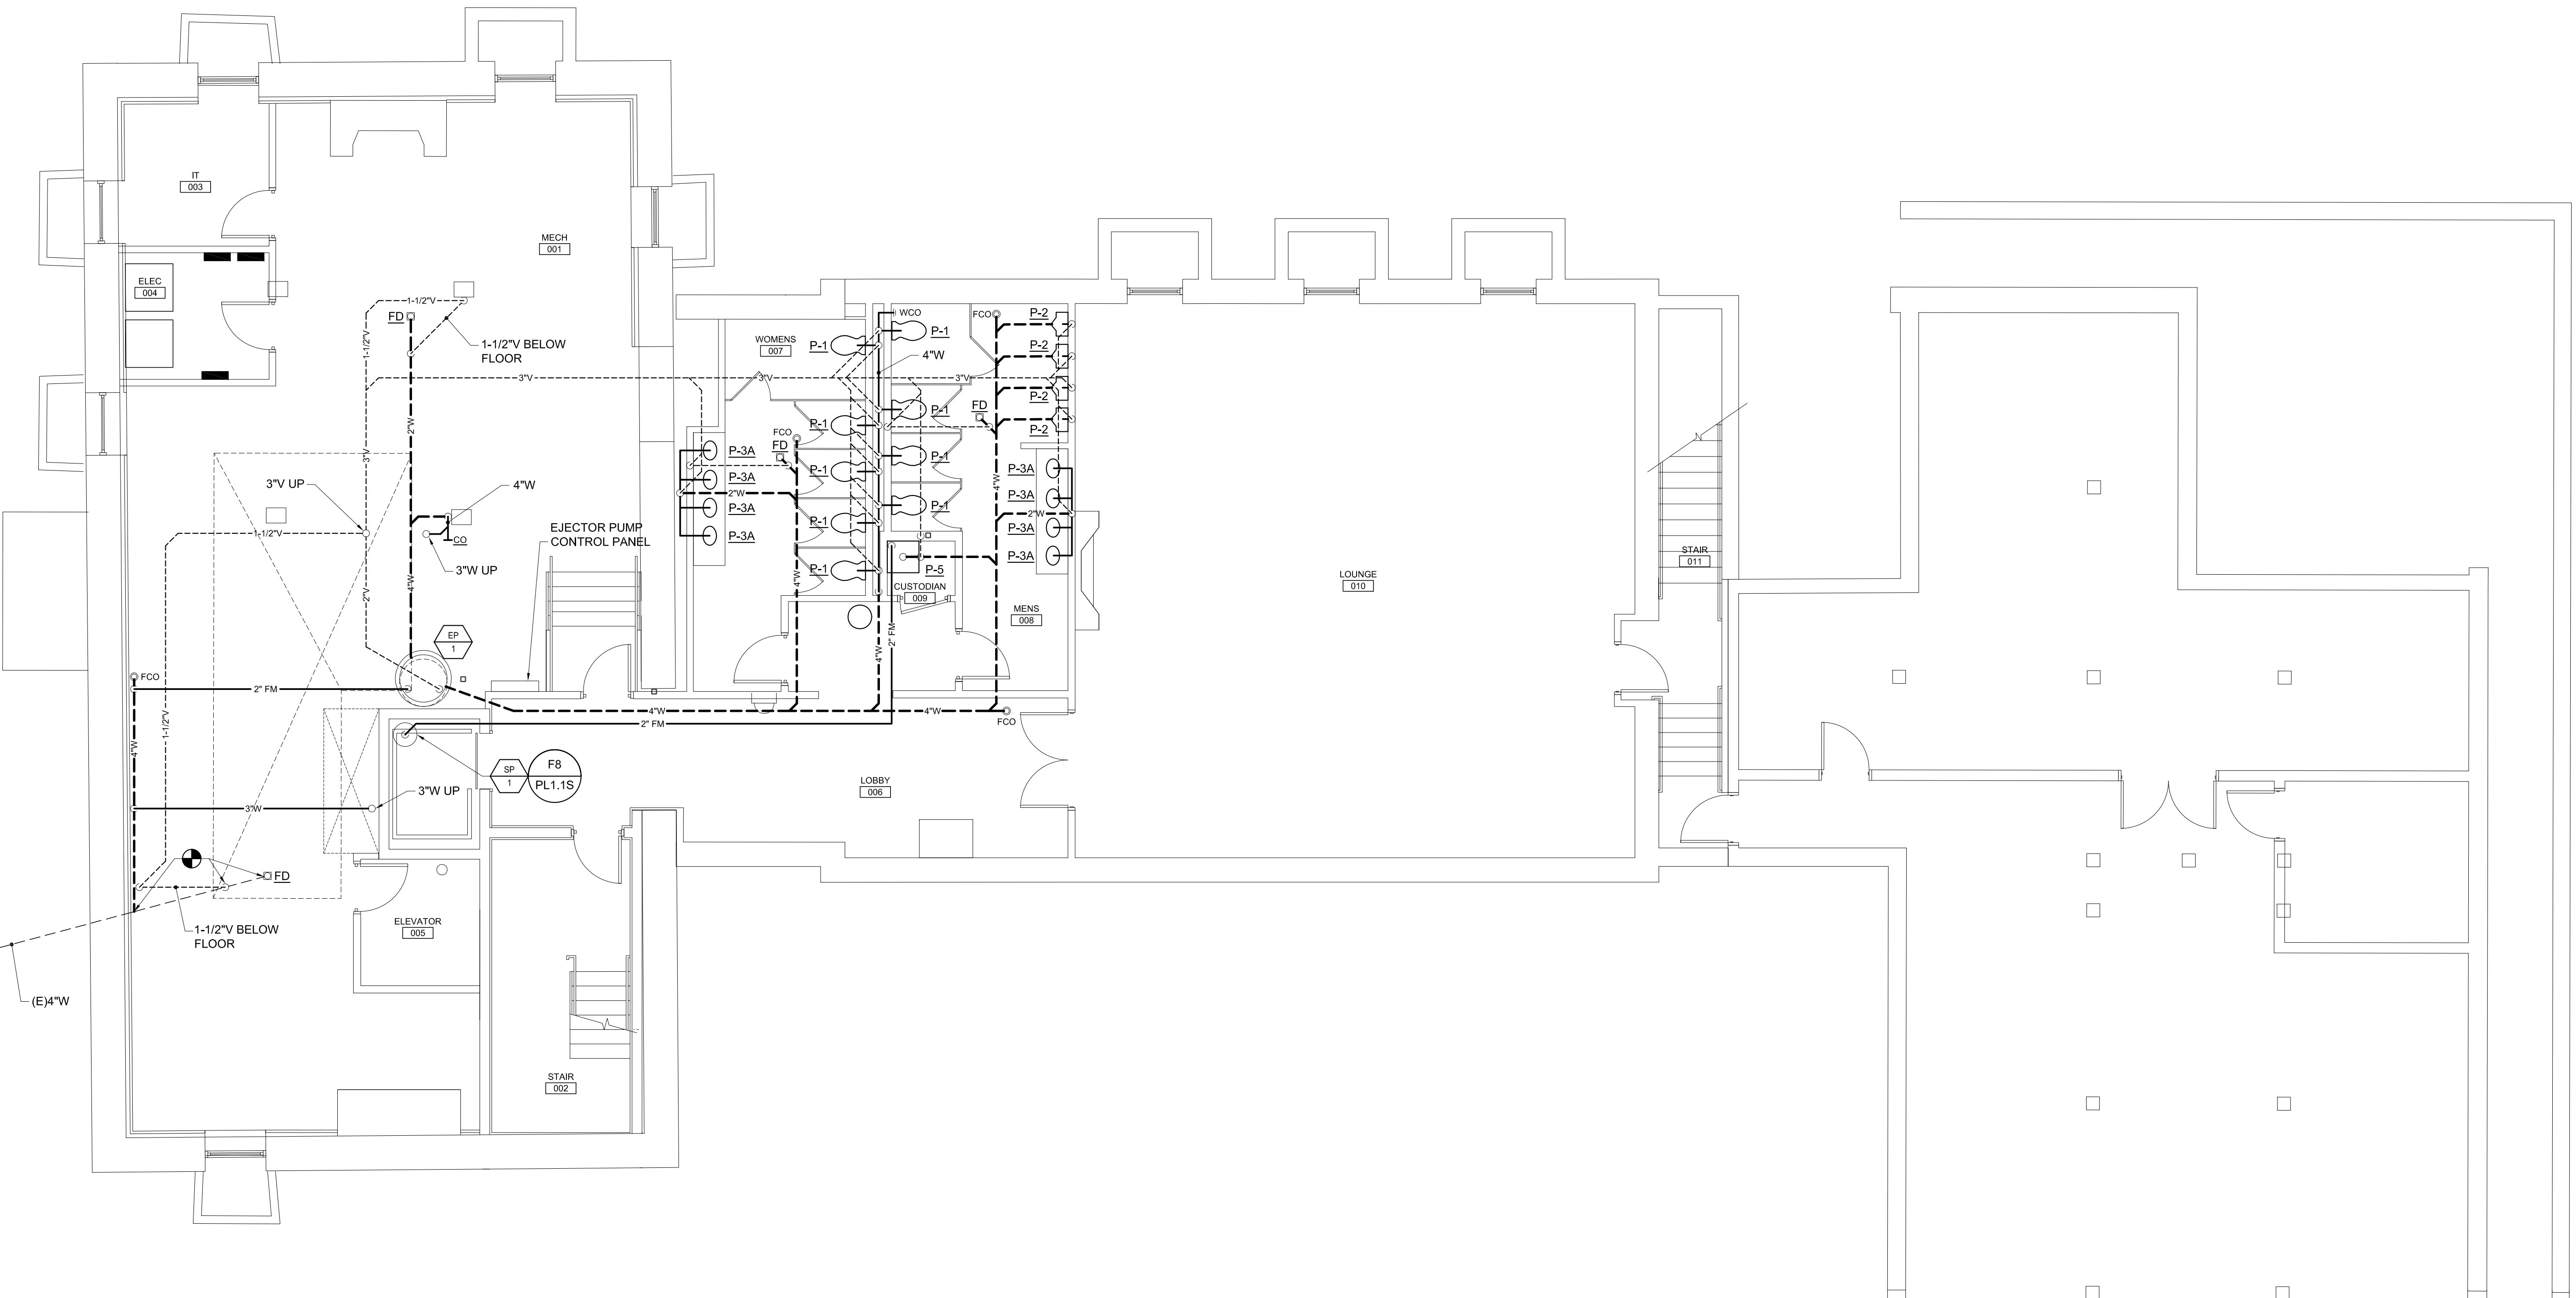

Allied Engineering
Structural Mechanical
Electrical Commissioning

160 Veranda Street
Portland, Maine 04103
T: 207.221.2260
F: 207.221.2266
Web: www.allied-eng.com

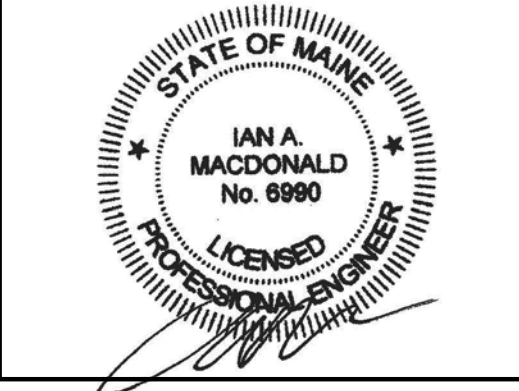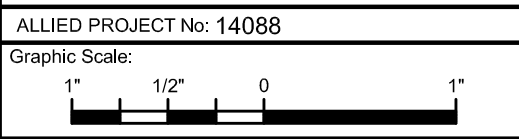

REVISIONS

No.	Description	Date

PERMIT SET

**UNIVERSITY OF
NEW ENGLAND**
PORTLAND, MAINE

**ALUMNI HALL
RENOVATION**

**SANITARY PIPING
PLAN ~ LOWER LEVEL**

Project Number **14525**
Date **May 1, 2015**
Drawn by **REW**
Checked by **HAG**

P3

Scale **AS NOTED**

A1 SANITARY PIPING PLAN ~ LOWER LEVEL

3/16" = 1'-0"

N:\Projects\2014\14088 - UNE - Alumni Hall\00 Drawing Files\14088.dwg Apr 30, 2015 - 4:02pm