
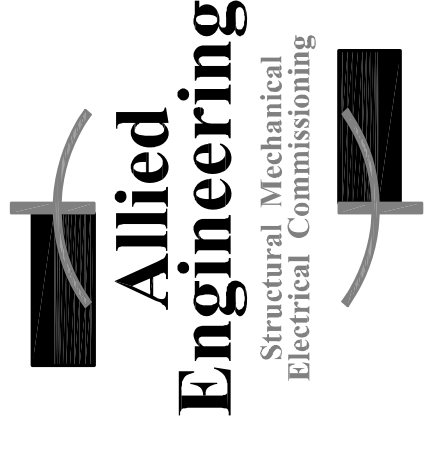


65 NEWBURY STREET
 PORTLAND, ME 04101
 207.761.9000
 info@portcityarch.com
 WWW.PORTCITYARCH.COM

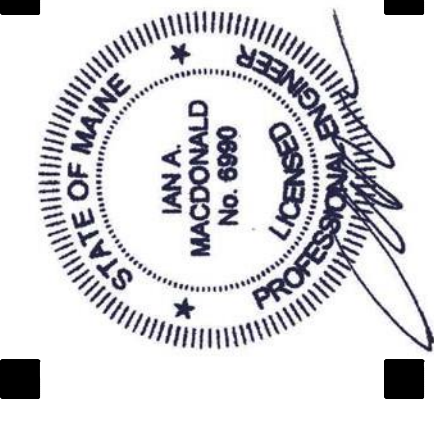

160 Veranda Street
 Portland, Maine 04103
 T: 207.221.2260
 F: 207.221.2266
 Web: www.allied-eng.com

GENERAL CONTRACTOR:
 ZALIER PROJECT INC #4088
 GENERAL SCALE: 1/2" = 1'

CONSTRUCTION DOCUMENT SET FOR CONSTRUCTION

No.	REVISIONS	Date
1	As Noted	08/07/2015
2	As Noted	08/07/2015
3	As Noted	08/07/2015
4	As Noted	08/07/2015
5	As Noted	08/07/2015


UNIVERSITY OF NEW ENGLAND
 PORTLAND, MAINE

ALUMNI HALL RENOVATION

MECHANICAL PIPING PLAN ~ SECOND FLOOR

Project Number: 14525
 Date: August 7, 2015
 Drawn by: REW
 Checked by: HAG

MP1.3
 Scale: AS NOTED

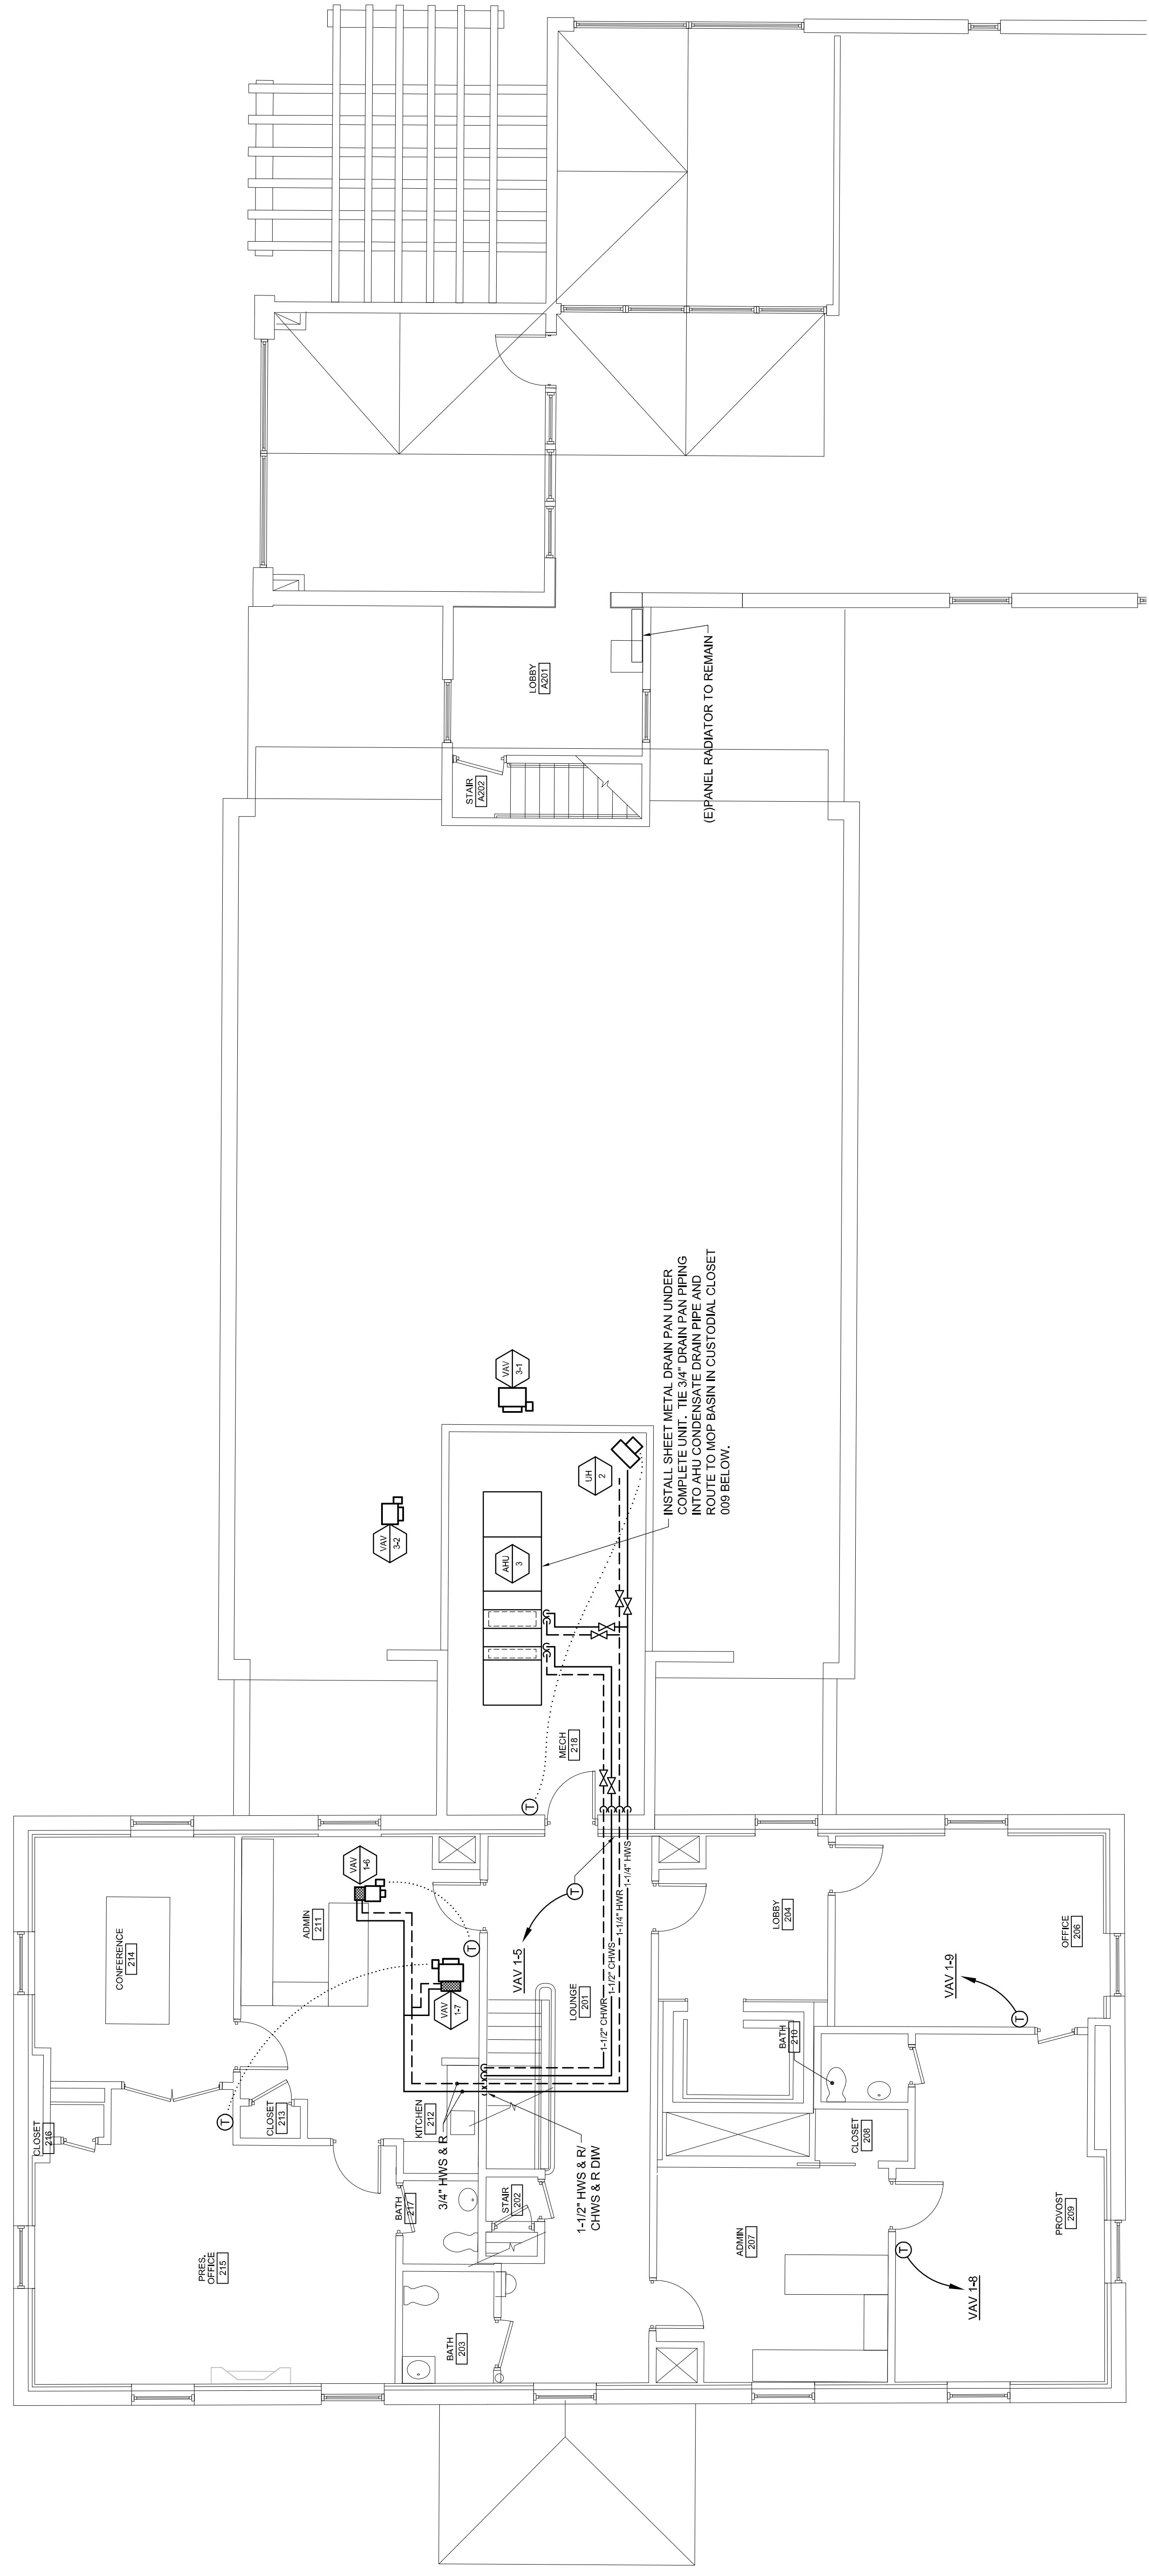

INSTALL SHEET METAL DRAIN PAN UNDER COMPLETE UNIT. TIE 3/4\" DRAIN PAN PIPING INTO AHU CONDENSATE DRAIN PIPE AND ROUTE TO MOP BASIN IN CUSTODIAL CLOSET 009 BELOW.

(E)PANEL RADIATOR TO REMAIN

A1 MECHANICAL PIPING PLAN ~ SECOND FLOOR

3/16\" = 1'-0\"