



LOWER LEVEL PLAN
SCALE: 1/8" = 1'-0"

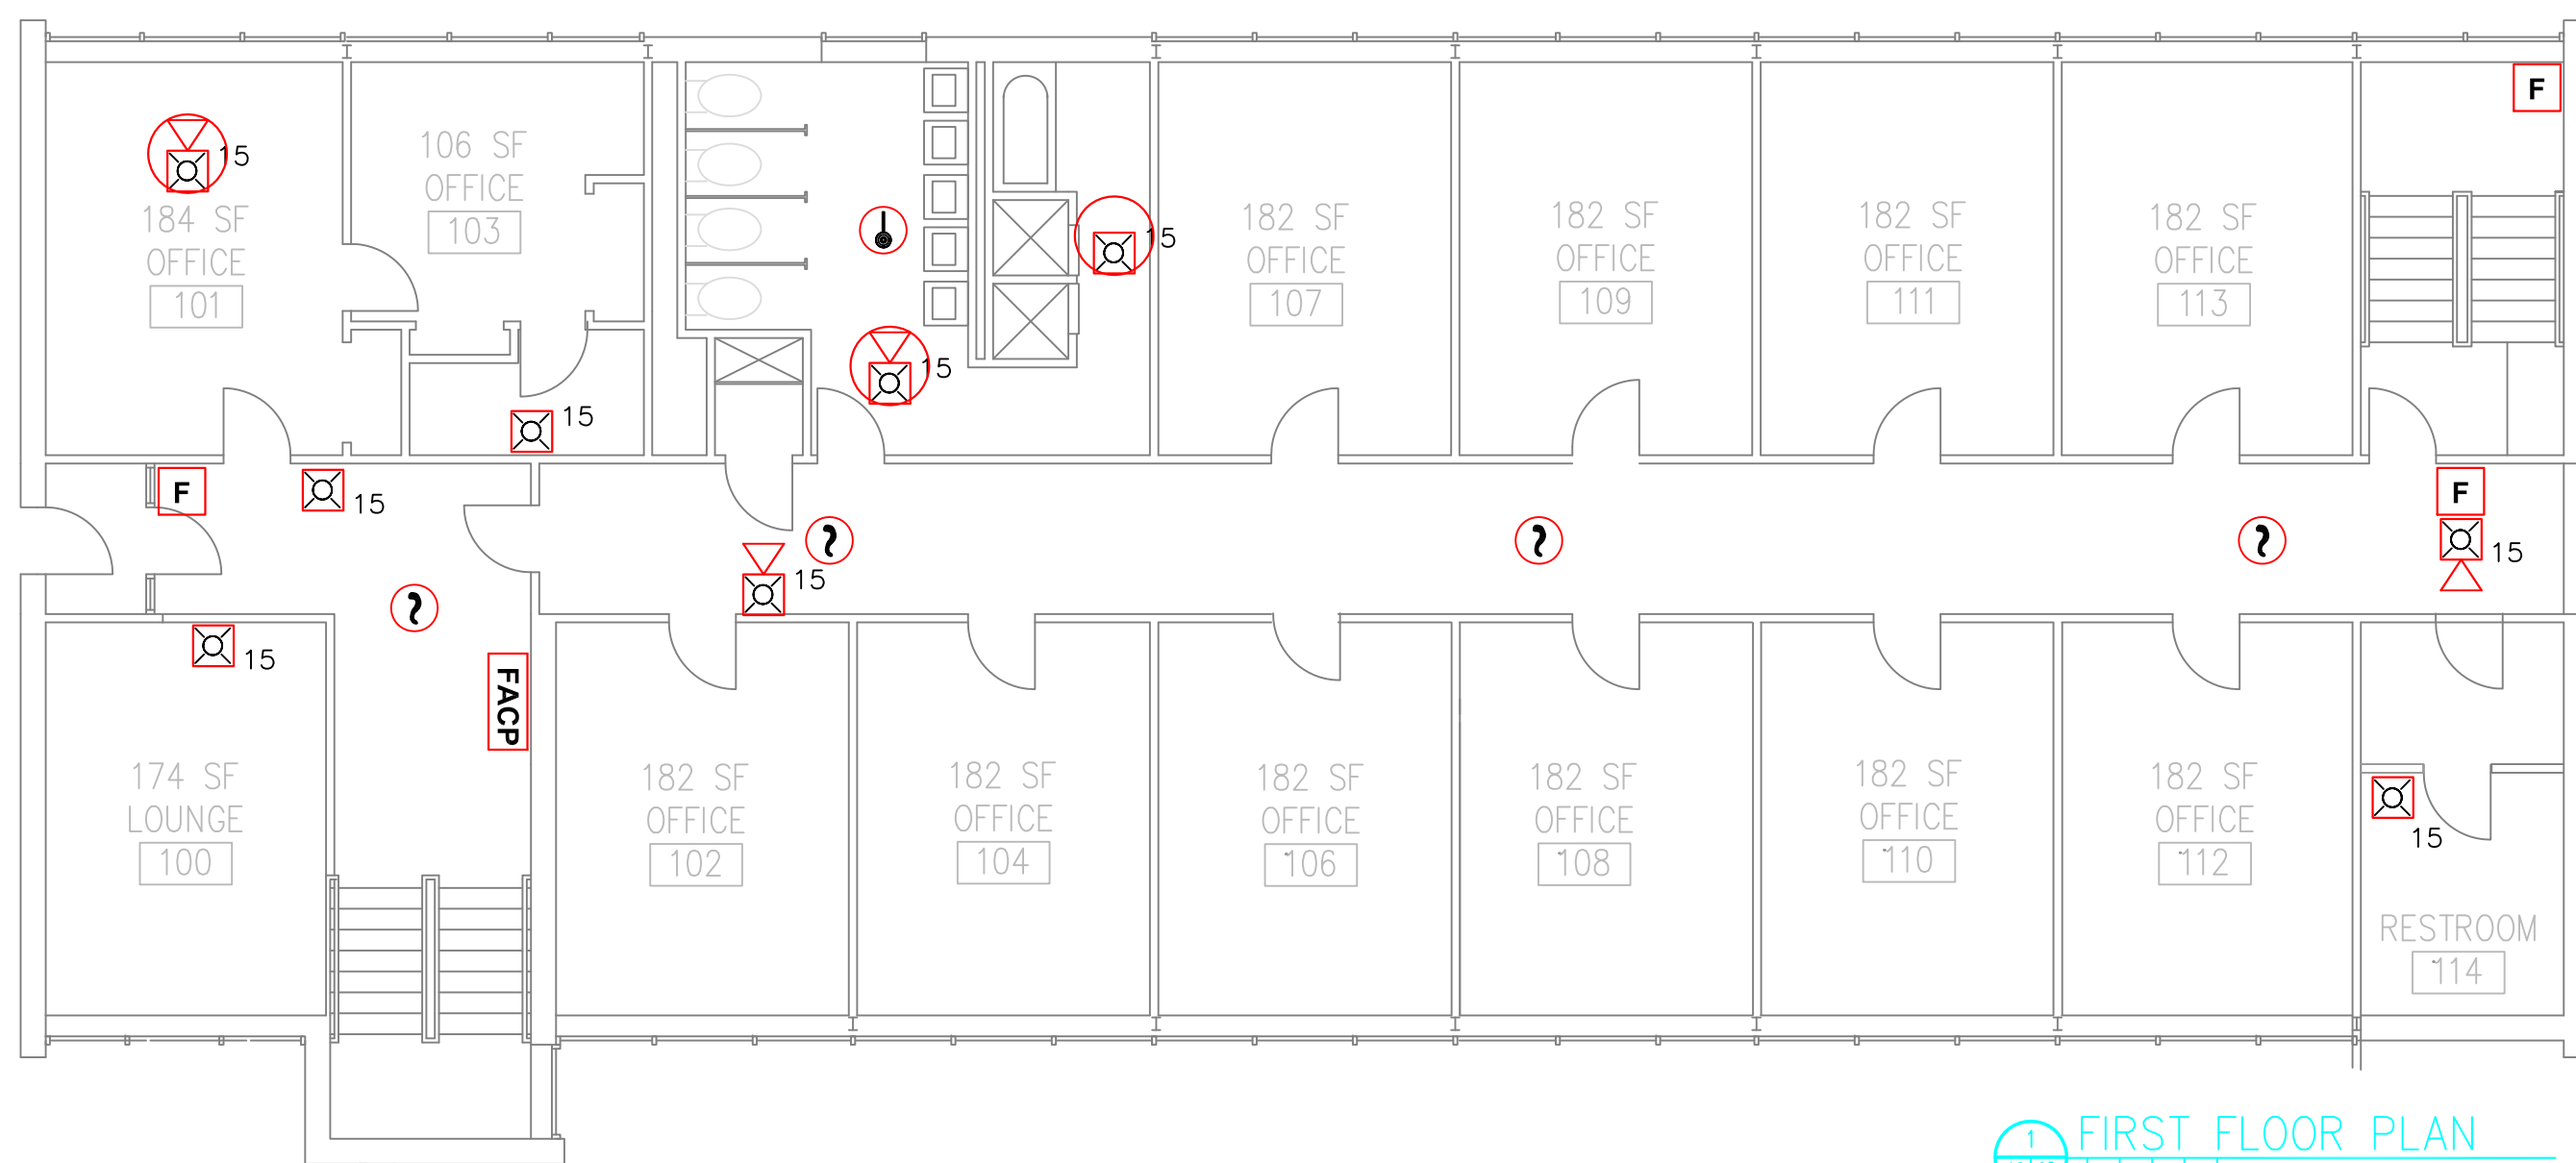

FIRST FLOOR PLAN
SCALE: 1/8" = 1'-0"

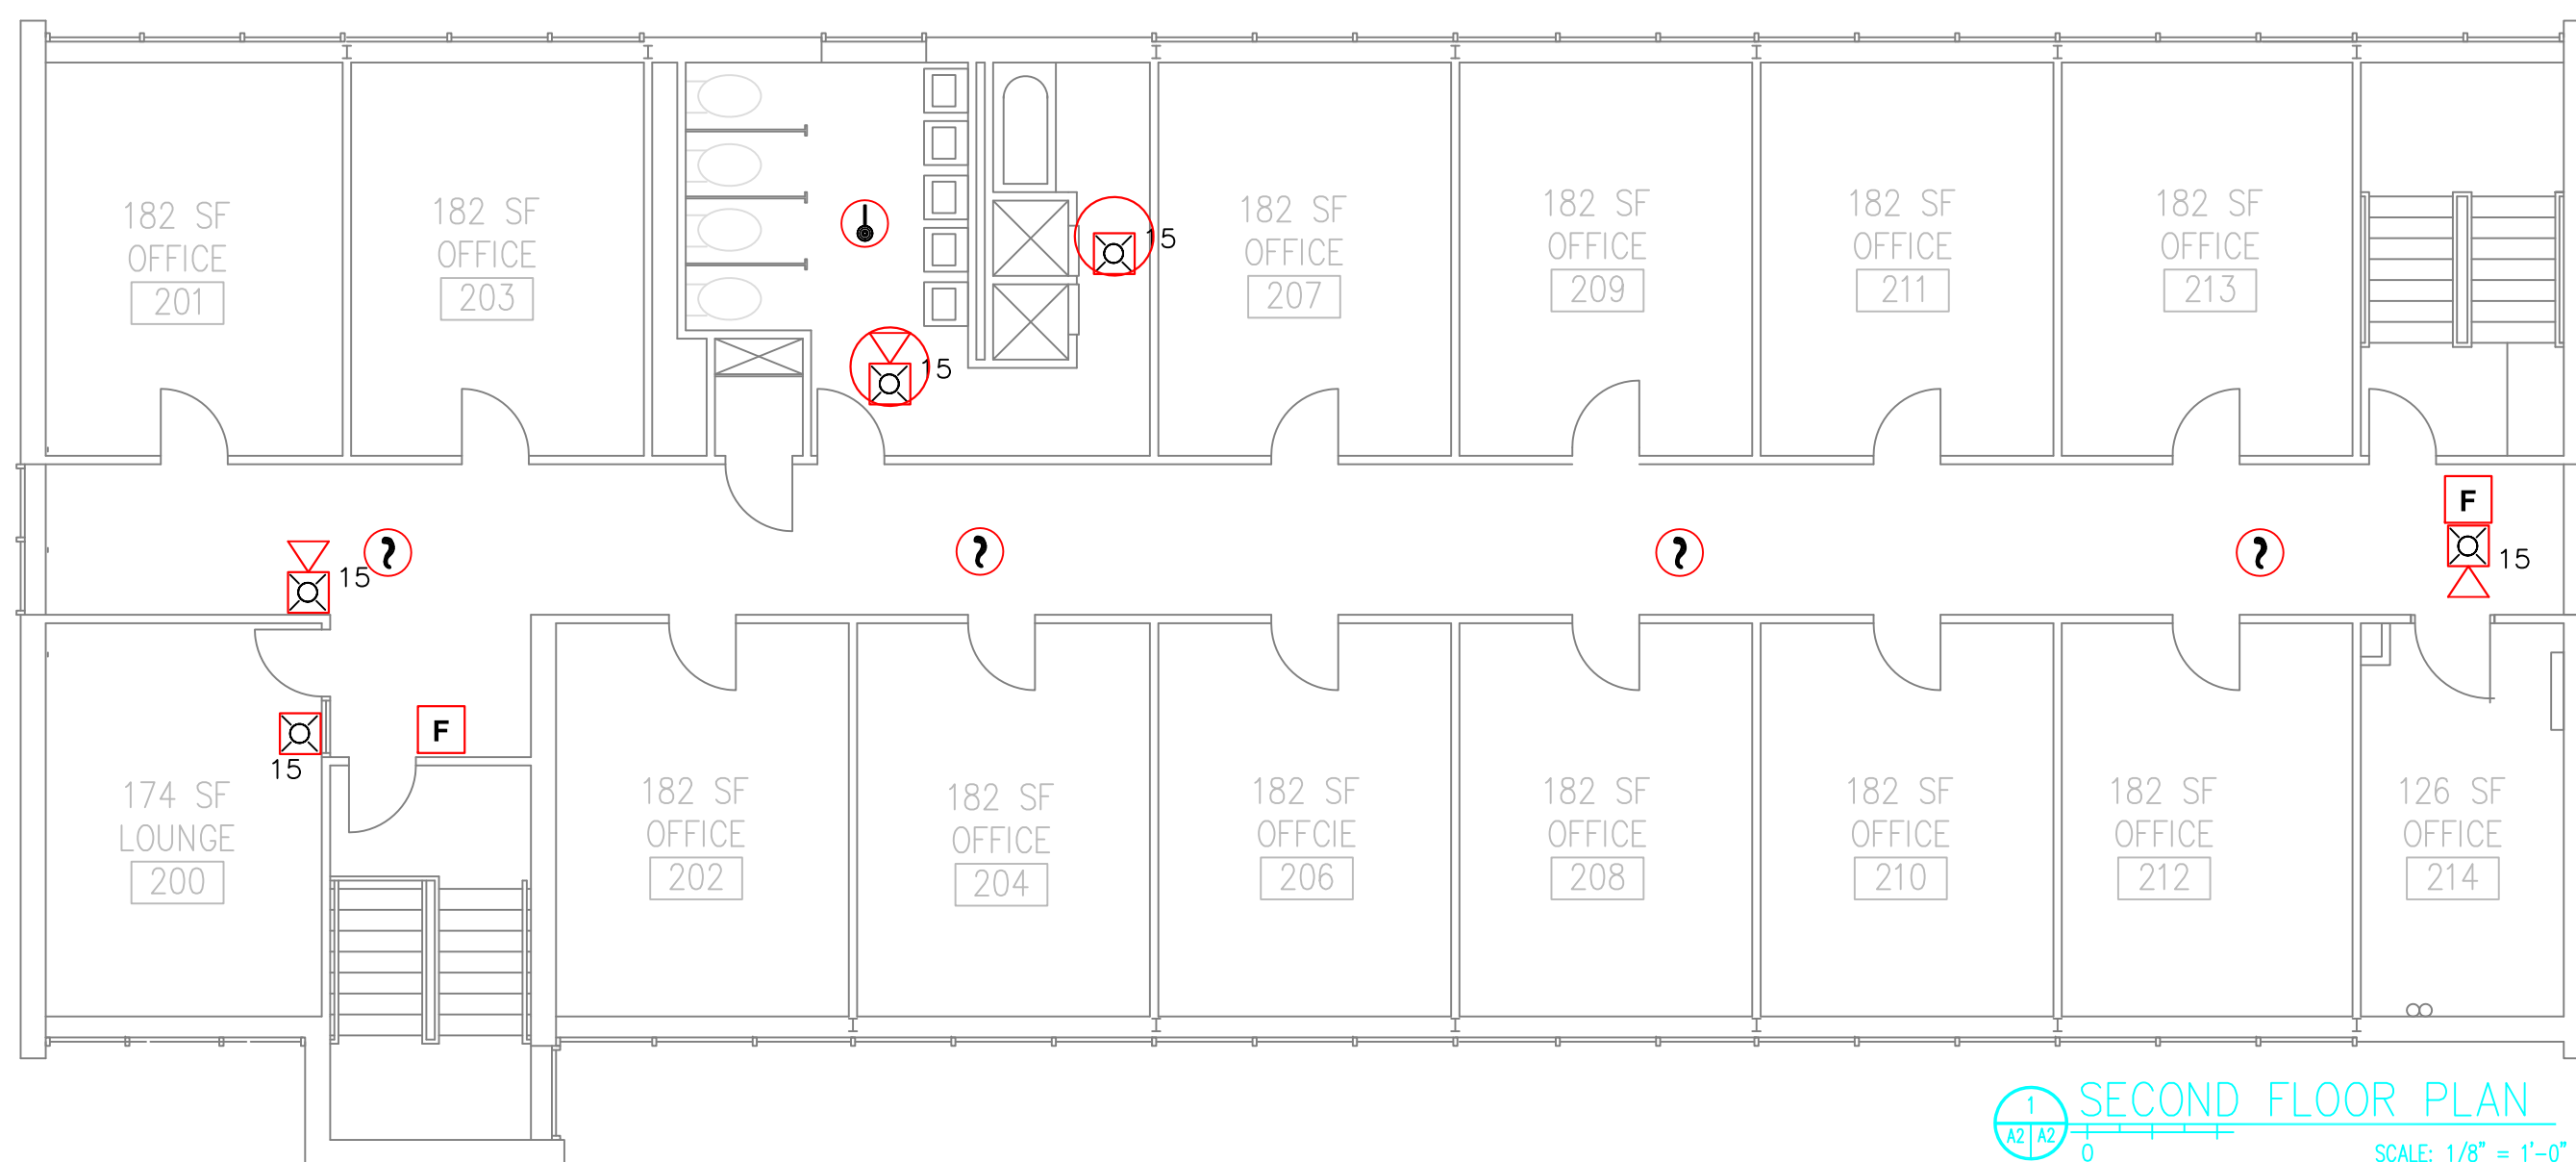

SECOND FLOOR PLAN
SCALE: 1/8" = 1'-0"

LEGEND:

RISER DIAG SYM	NFPA SYMBOL	DESCRIPTION	CATALOG #
FACP	FACP	Fire Alarm Control Panel	IO1000RD
ANN		Remote Annunciator	RLCD-CR
BPS		Remote Booster Panel	BPS10A
F	P	Manual Pull Station	SIGA-278
?	?	Addressable Smoke Detector w/ Standard Base	SIGA-PD SIGA-SB
		Addressable Smoke Detector w/ Standard Base	SIGA-HFS
CT1	AIM	Addressable Single Input Module	SIGA-CT1
CT2	AIM	Addressable Dual Input Module	SIGA-CT2
CR	ACM	Addressable Control Relay	SIGA-CR
ⓧ#	ⓧ#	Horn/Strobe Unit (Red Wall Mount) # Indicates Candela Setting	G1RF-HDVM
ⓧ#	ⓧ#	Strobe Unit (Red Wall Mount) # Indicates Candela Setting	G1RF-VM
MB		Radio Master Box	AES 7788
ⓑ		Exterior Beacon	495S-1280R

* NFPA 170 (2009)
Tables: 6.5, 6.7.1, 6.7.2, & 6.7.3
(Some symbols may not appear on drawing)



Linnell Hall
All Floors
University of New England
Portland, Maine
FIRE ALARM RISER DIAGRAM

REV.	DESCRIPTION	DATE	DRWN:	RW/D:
0	Original Issue	3/17	KMB	TRD