


LOWER LEVEL HVAC PIPING PLAN
SCALE: 1/8" = 1'-0"

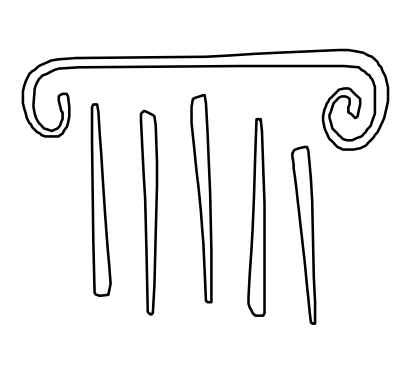

PORT CITY ARCHITECTURE

65 NEWBURY STREET
PORTLAND, ME 04101
207.761.9000
fax: 207.761.2010
lita@portcityarch.com

Titan Mechanical, Inc.
Design/Build Engineering - Mechanical Contracting
P.O. Box 3927 / 232 Riverside Industrial Parkway
Portland, Maine 04104
Ph. (207) 878-5223 Fax. (207) 878-5235

UNIVERSITY OF NEW ENGLAND
COLLEGE OF PHARMACY
CLASSROOMS

716 STEVENS AVENUE, PORTLAND, ME

#	DATE	DESCRIPTION
---	------	-------------


DATE ISSUED	3/11/09
PROJECT NUMBER	08518

SHEET NAME
LOWER LEVEL HVAC PIPING PLAN


DRAWN BY	CJM
CHECKED BY	JPN

M1.1


BID DOCUMENTS - NOT FOR CONSTRUCTION

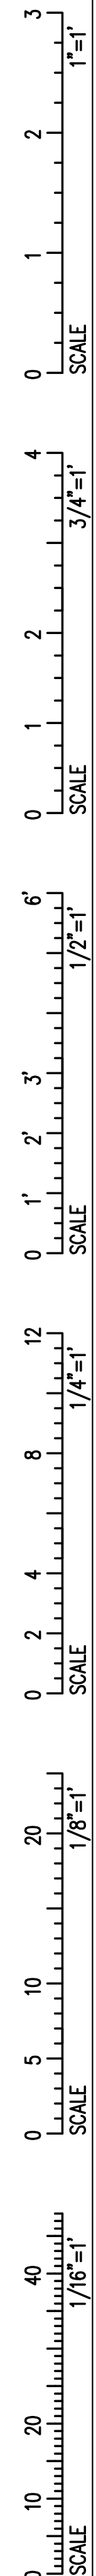

PLUMBING FIXTURE SCHEDULE						
TAG	FIXTURE	CW	HW	WASTE	VENT	REMARKS
P-1	WALL HUNG TOILET	1/2"	---	4"	2"	ZURN Z5610 TOILET W/ ZURN Z6000AV-DF DUAL FLUSH VALVE & Z5950 ELONGATED, OPEN FRONT SEAT
P-2	WALL HUNG TOILET	1/2"	---	4"	2"	ZURN Z5615211 1.28 GPF TOILET W/ ECOVANTAGE HARDWIRED SENSOR FLUSH VALVE & Z5950 OPEN FRONT SEAT
P-3	URINAL	1/2"	---	2"	2"	ZURN Z5730 "SMALL PINT" 1/8 GPF URINAL W/ HARDWIRED SENSOR FLUSH VALVE
P-4	UNDERCOUNTER LAVATORY	1/2"	1/2"	1 1/2"	1 1/2"	KOHLER K-2211 UNDERCOUNTER LAVATORY W/ ZURN Z26917-CWB AQUASENSE SENSOR FAUCET
P-5	MOP SINK	1/2"	1/2"	3"	2"	STERN-HILLIAMS HL-1800 24"X24" W/ ZURN Z-343M-RC "AQUASPEC" MOP SINK FAUCET
P-6	WALL HUNG LAVATORY	1/2"	1/2"	1 1/2"	1 1/2"	ZURN Z5330 W/ ZURN Z26917-CWB AQUASENSE SENSOR FAUCET
P-7	EYE WASH	1/2"	1/2"	1 1/2"	1 1/2"	GUARDIAN G1814 WALL MOUNTED, STAINLESS STEEL BOWL W/ THERMOSTATIC MIXING VALVE

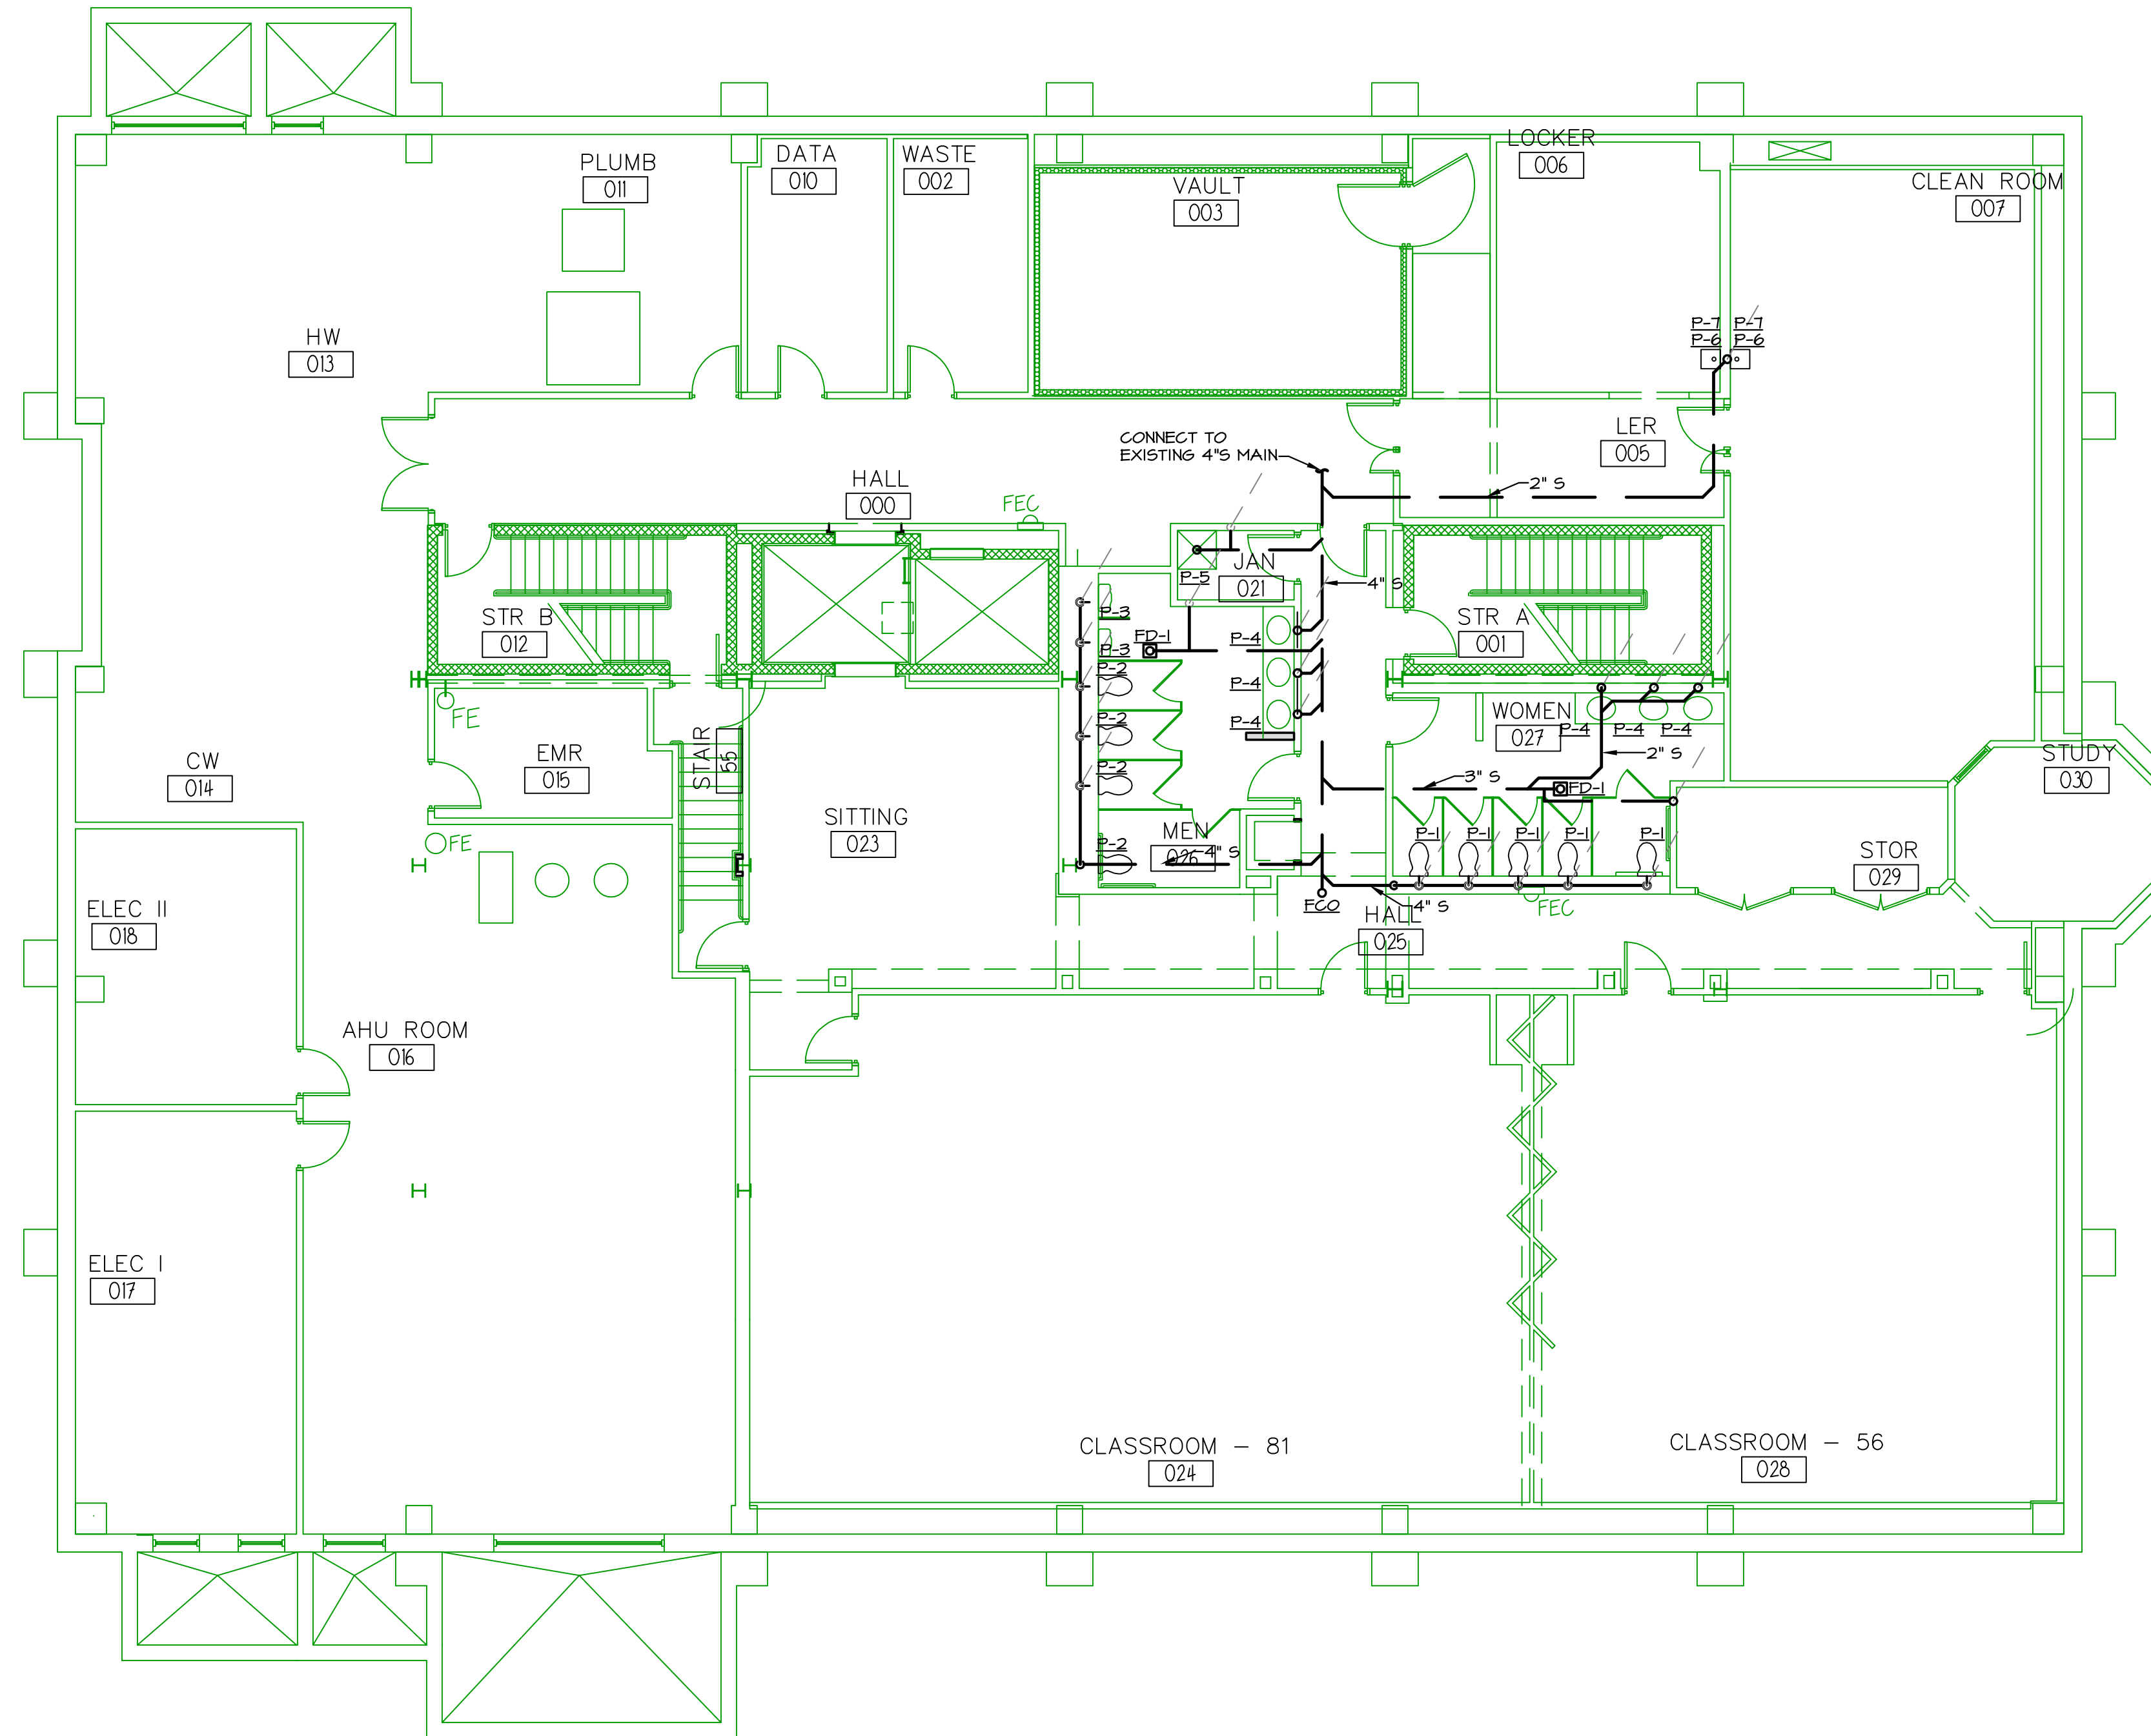

LOWER LEVEL SANITARY PLUMBING PLAN
SCALE: 1/8" = 1'-0"

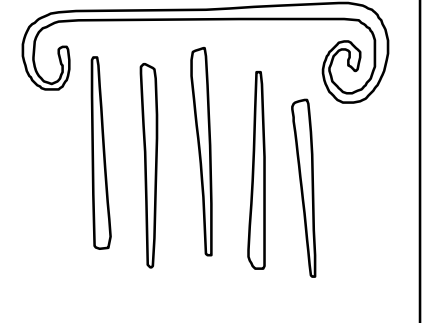

PORT CITY ARCHITECTURE

65 NEWBURY STREET
PORTLAND, ME 04101
207.761.9000
fax: 207.761.2010
lita@portcityarch.com

Titan Mechanical, Inc.
Design/Build Engineering - Mechanical Contracting
P.O. Box 3927 / 232 Riverside Industrial Parkway
Portland, Maine 04104
Ph. (207) 878-5223 Fax. (207) 878-5235

UNIVERSITY OF NEW ENGLAND
COLLEGE OF PHARMACY
CLASSROOMS

716 STEVENS AVENUE, PORTLAND, ME

#	DATE	DESCRIPTION
---	------	-------------

DATE ISSUED 3/11/09

PROJECT NUMBER 08518

SHEET NAME



LOWER LEVEL SAN. PLUMB. PLAN

DRAWN BY
CJM


CHECKED BY
JPN

M2.0

BID DOCUMENTS - NOT FOR CONSTRUCTION

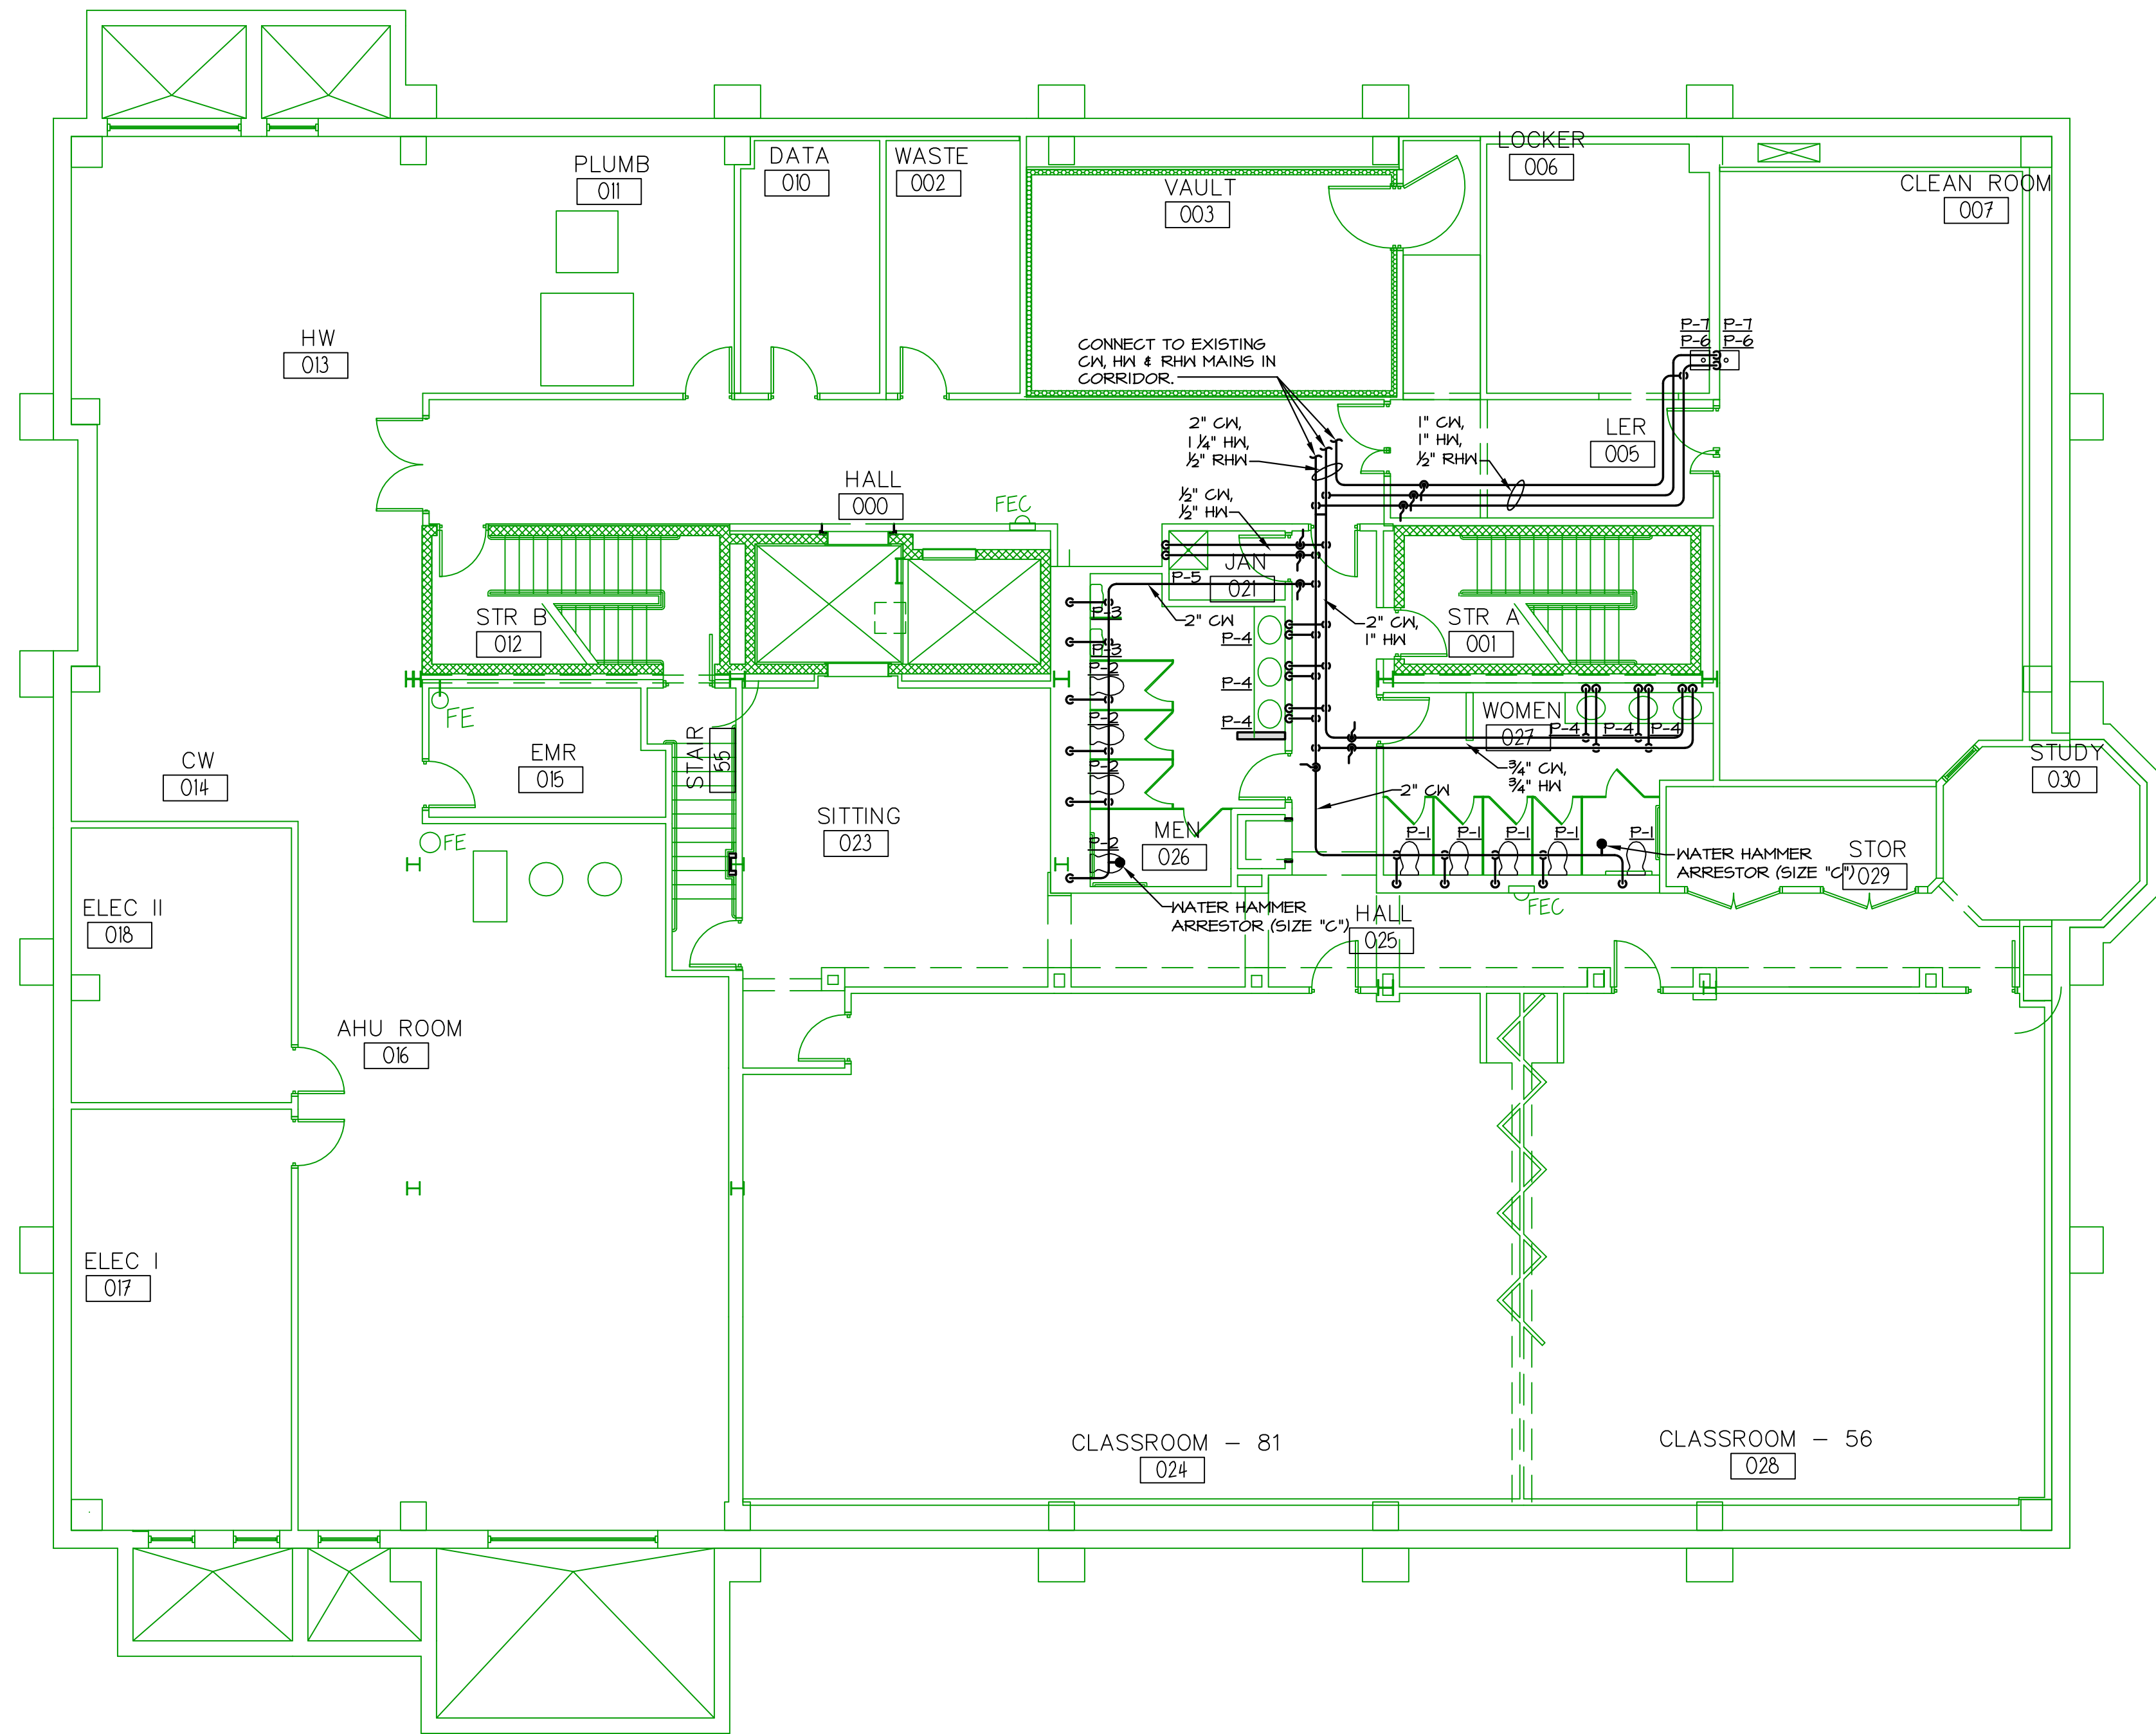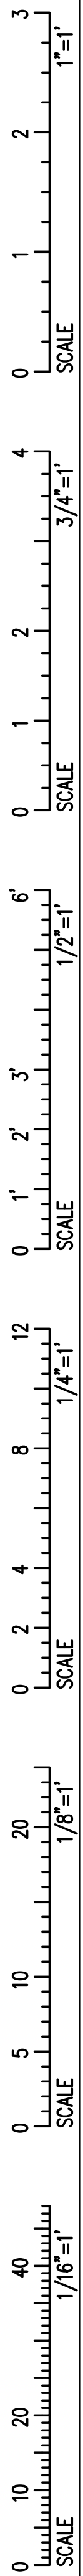


LOWER LEVEL DOMESTIC PLUMBING PLAN
 SCALE: 1/8" = 1'-0"

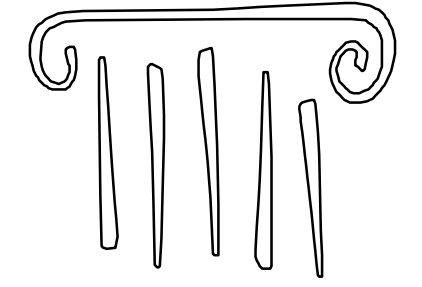

PORT CITY ARCHITECTURE

 65 NEWBURY STREET
 PORTLAND, ME 04101
 207.761.9000
 fax: 207.761.2010
 lita@portcityarch.com



Titan Mechanical, Inc.
 Design/Build Engineering - Mechanical Contracting
 P.O. Box 3927 / 232 Riverside Industrial Parkway
 Portland, Maine 04104
 Ph. (207) 878-5223 Fax. (207) 878-5235

UNIVERSITY OF NEW ENGLAND
 COLLEGE OF
 PHARMACY
 CLASSROOMS

716 STEVENS AVENUE, PORTLAND, ME

#	DATE	DESCRIPTION

DATE ISSUED	3/11/09
PROJECT NUMBER	08518

SHEET NAME
LOWER LEVEL PLUMBING PLAN

DRAWN BY	CJM
CHECKED BY	JPN

M2.1

