



3rd Floor Plan

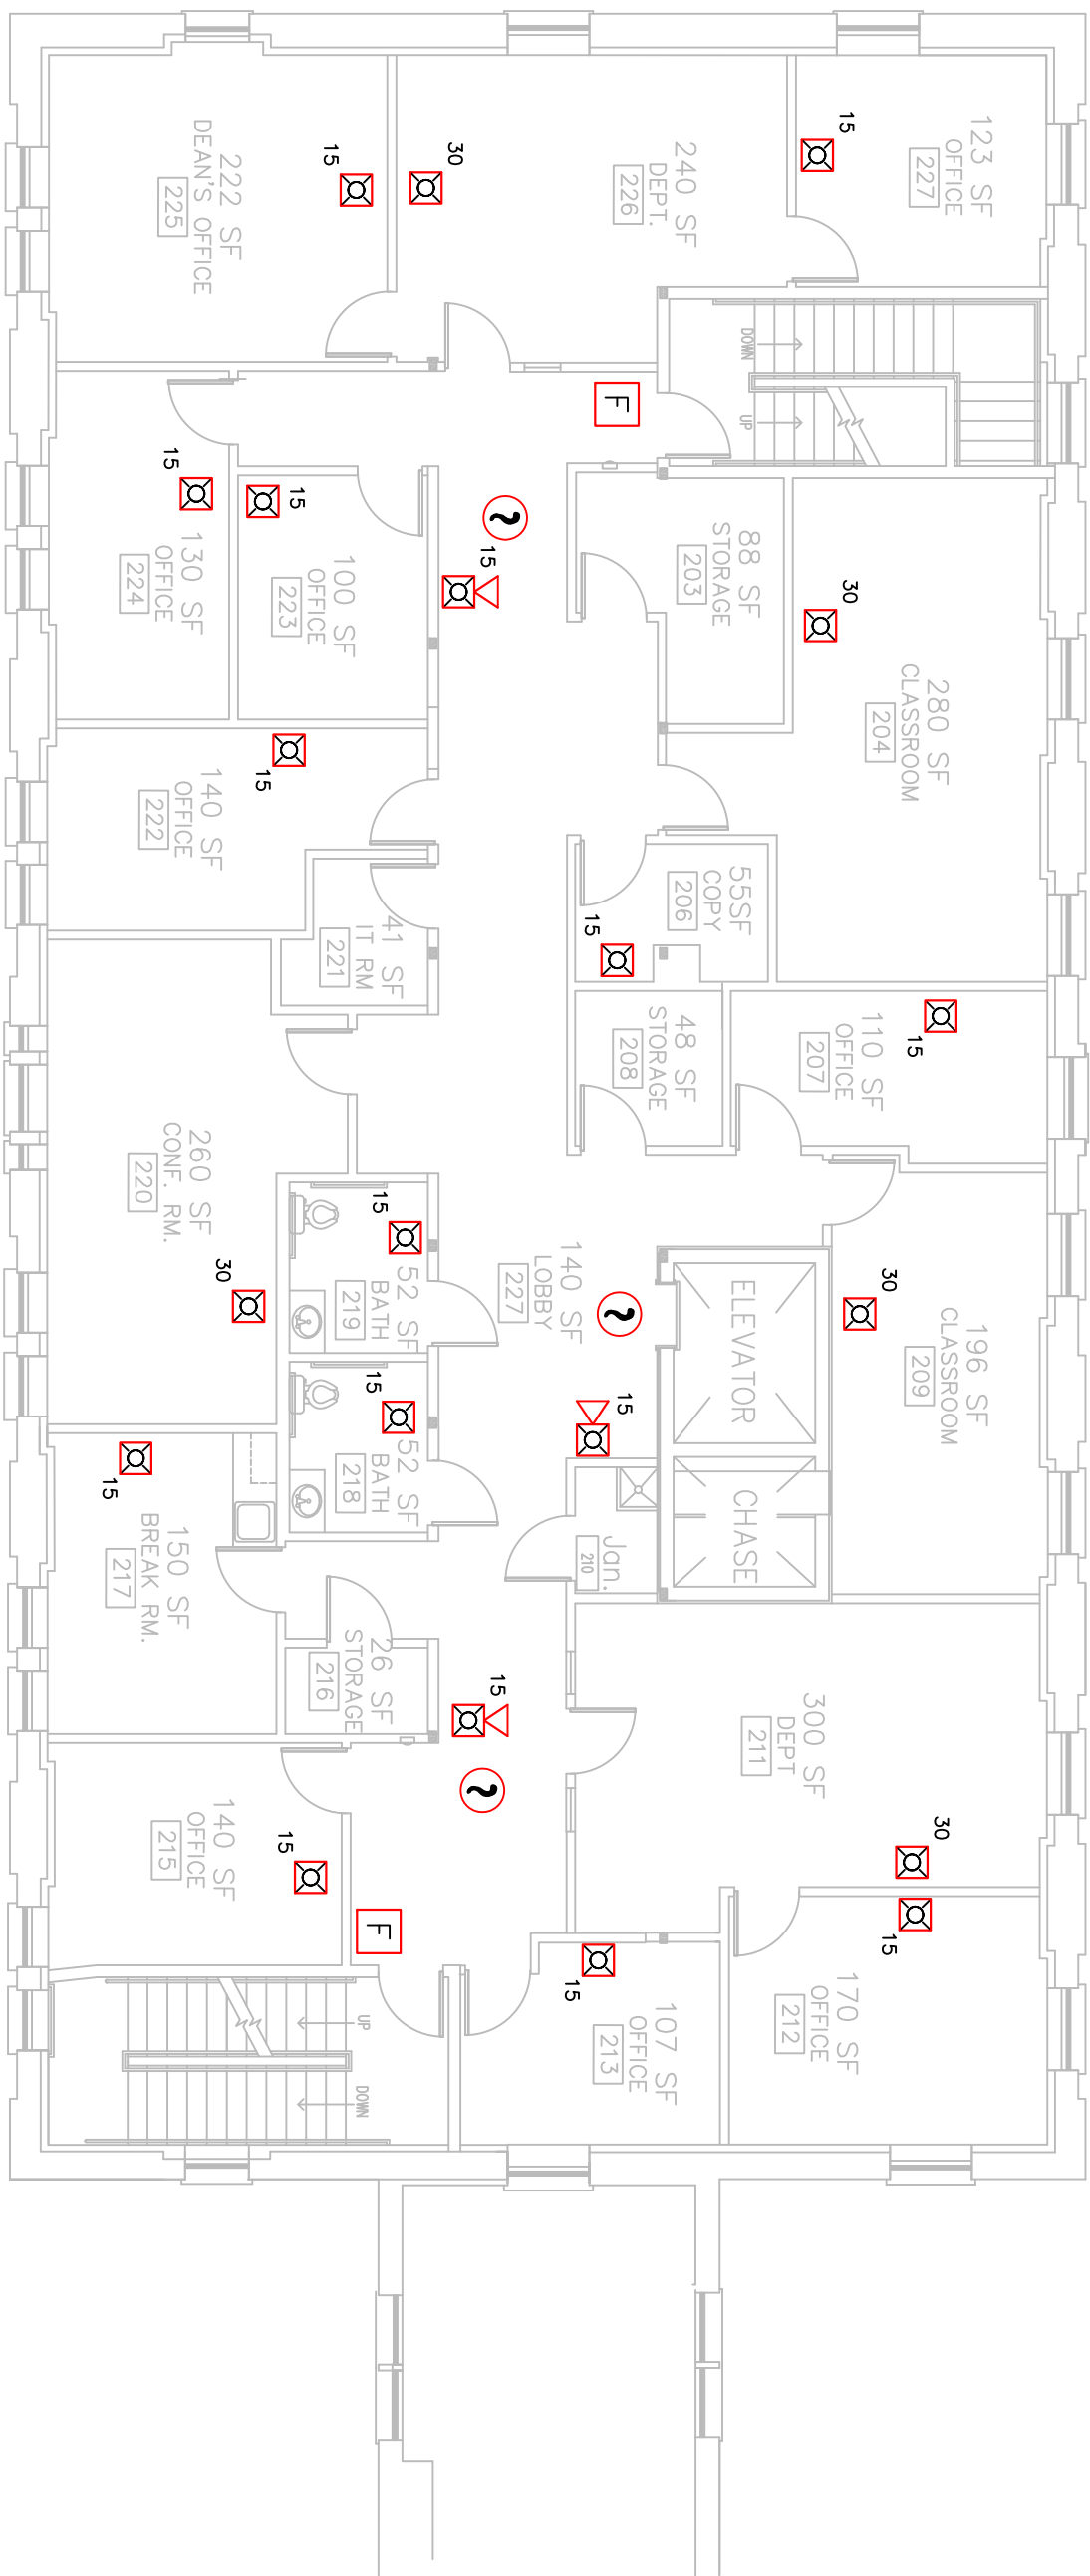

2nd Floor Plan

DWG NAME:
 University of New England
 Hersey Hall
 Portland, Maine
 FIRE ALARM PLAN
 DWG No: FA-04 Hersey 2nd

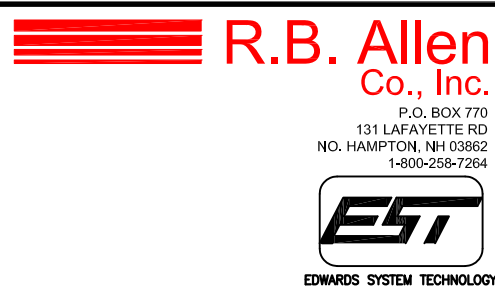

JOB NAME:
 University of New England
 Hersey Hall
 Portland, Maine
 Fire Alarm System Upgrade
 2nd & 3rd Floor Plans
 Contractor:

REV.	DESCRIPTION	DATE	DRWN:	TRD:
0	Original Issue	02/14	DHH	TRD

SCALE: 1/8" = 1'-0" (Plotted C Size)

PD No. 85001

University of New England
 Portland - Hersey Hall
 Portland, Maine
 FIRE ALARM PLANS
 DWG No: FA-04 Hersey 2nd