


UNIVERSITY OF NEW ENGLAND  
 PARKER PAVILION  
 LOWER LEVEL

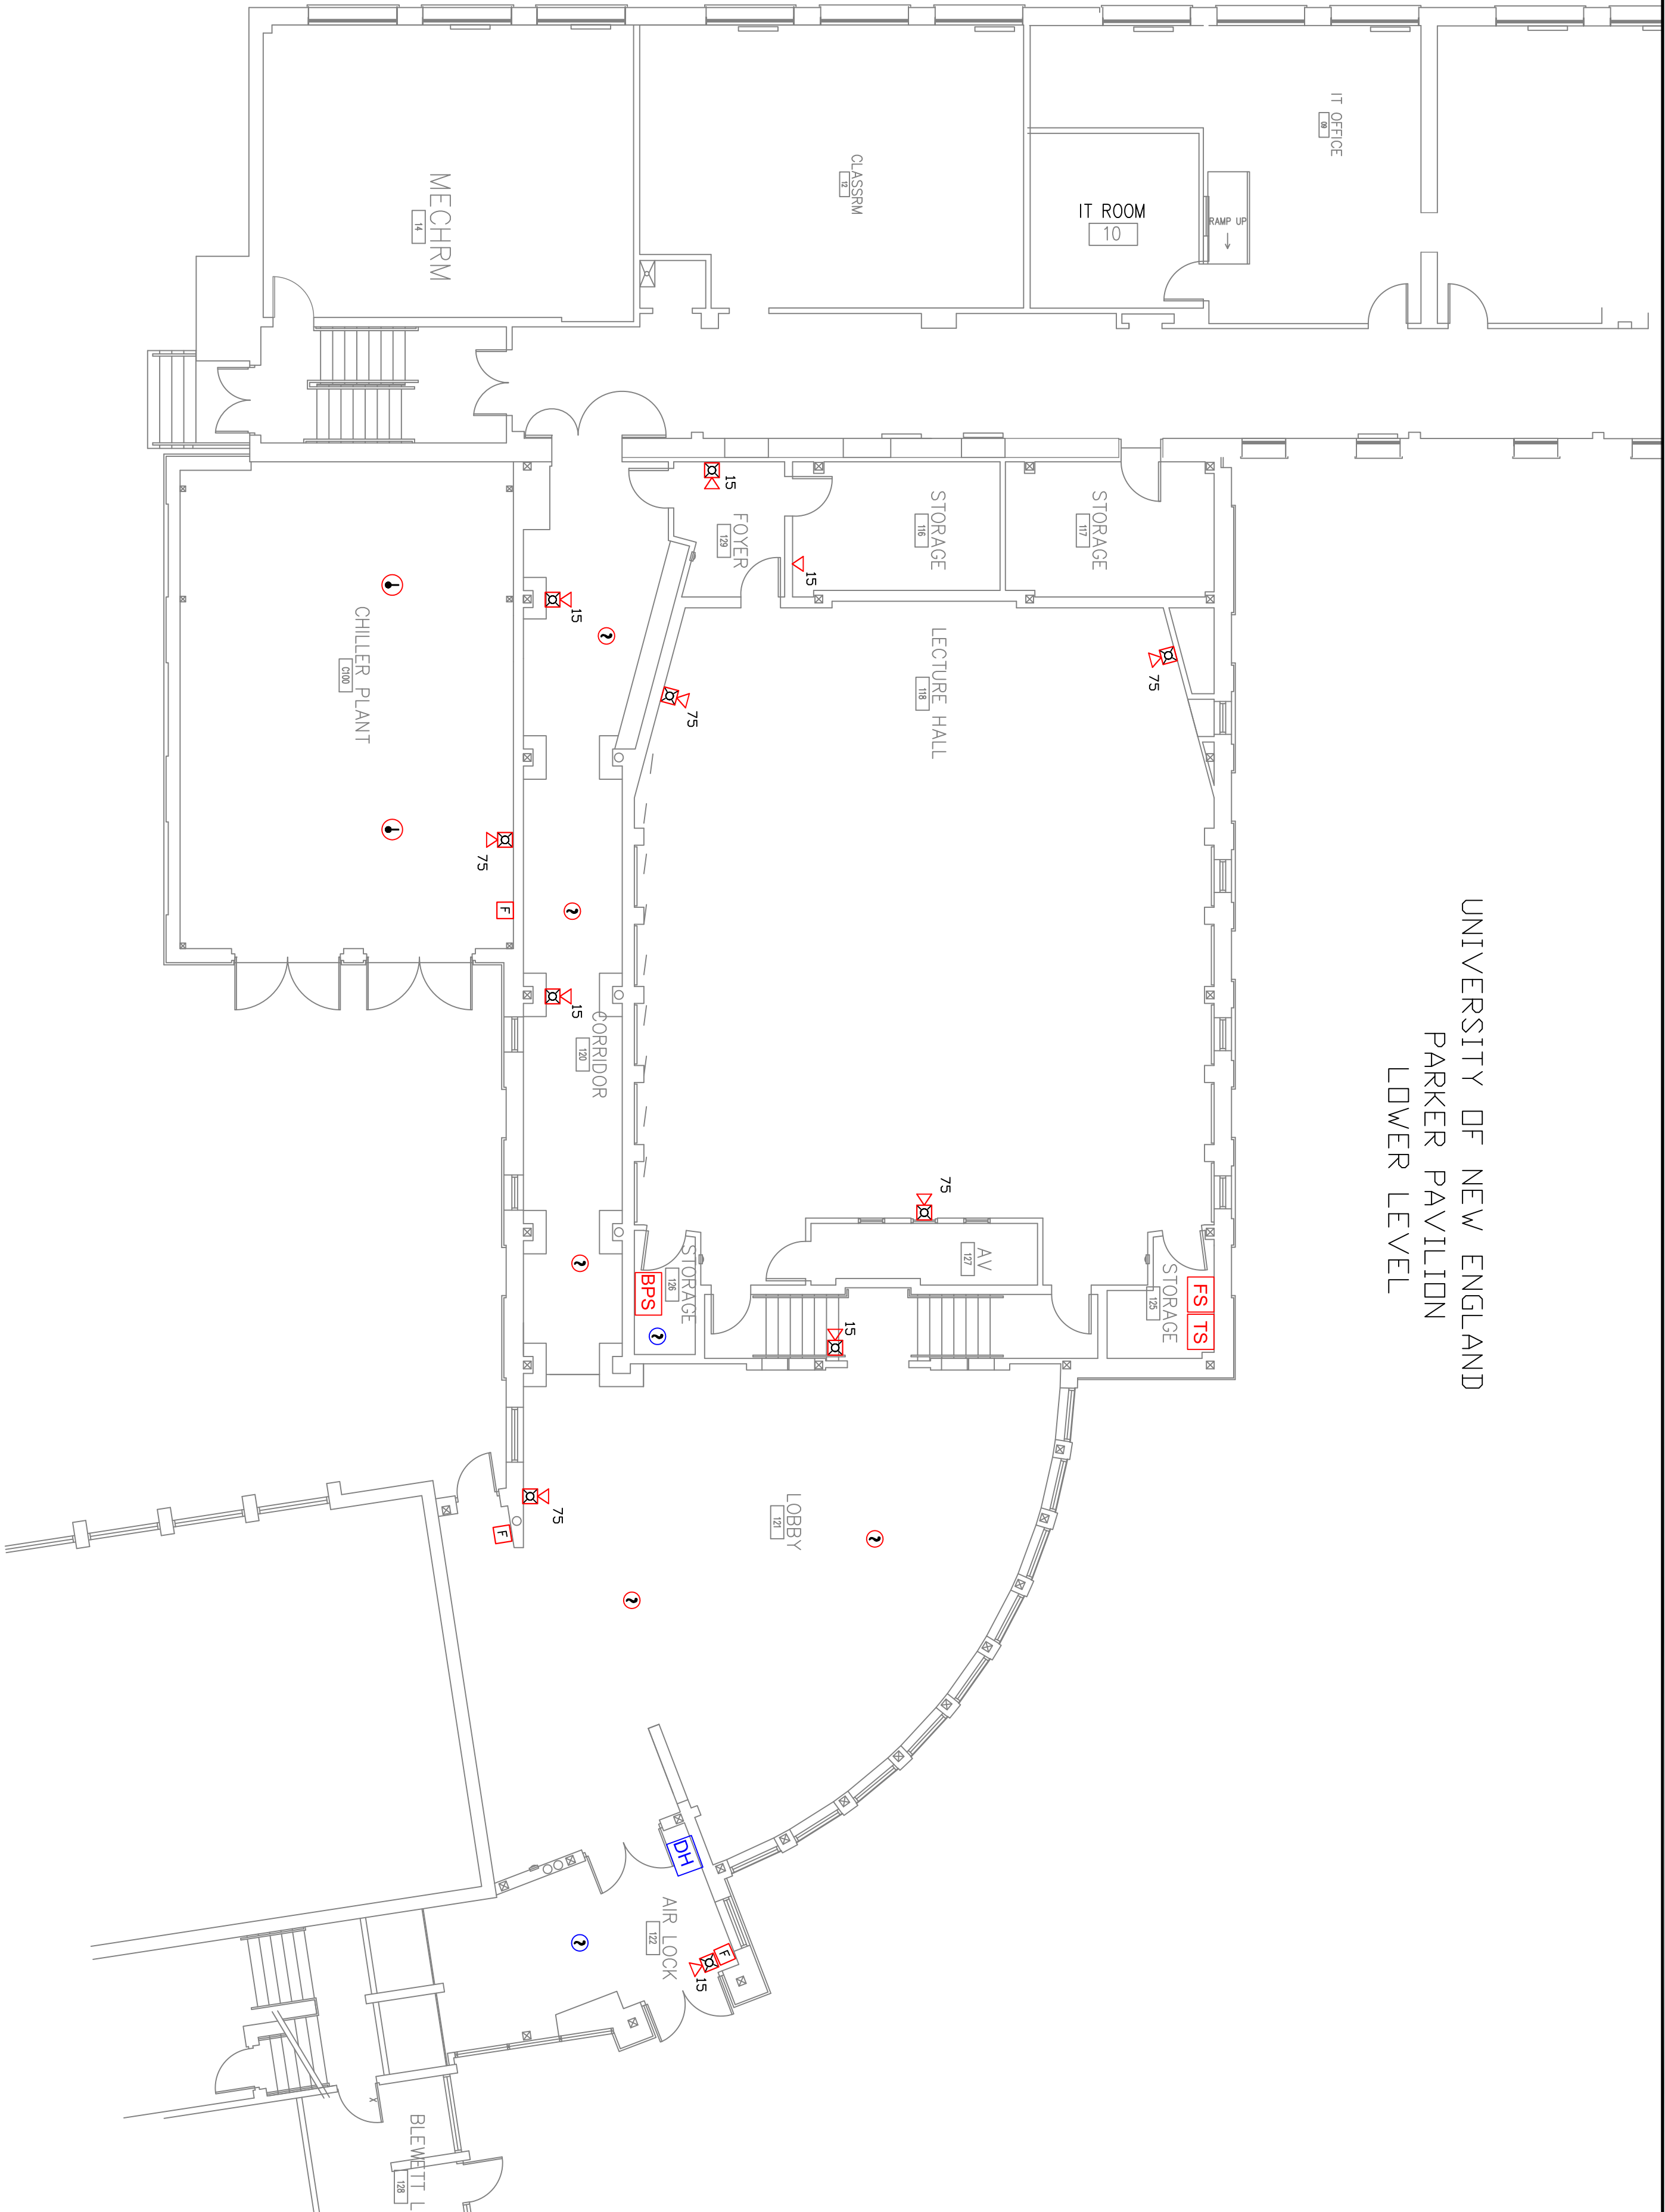

DWG NAME:  
 University of New England  
 Proctor Hall  
 Portland, Maine  
 FIRE ALARM PLAN  
 DWG No: FA-10 Parker

**R.B. Allen**  
 Co., Inc.  
 P.O. BOX 770  
 131 LAFAYETTE RD  
 NO. HAMPTON, NH 03862  
 1-800-258-7264

JOB NAME:  
 University of New England  
 Proctor Hall  
 Portland, Maine  
 Fire Alarm System Upgrade  
 First Floor Plan

Contractor:

SCALE: 1/8" = 1'-0" (Plotted C Size)

REV.	DESCRIPTION	DATE	DRWN:	RW'D:
0	Original Issue	02/14	DHH	TRD

PO No. 85001  
 University of New England - Proctor Hall  
 Portland, Maine  
 FIRE ALARM PLANS  
 DWG No. FA-10 Parker