

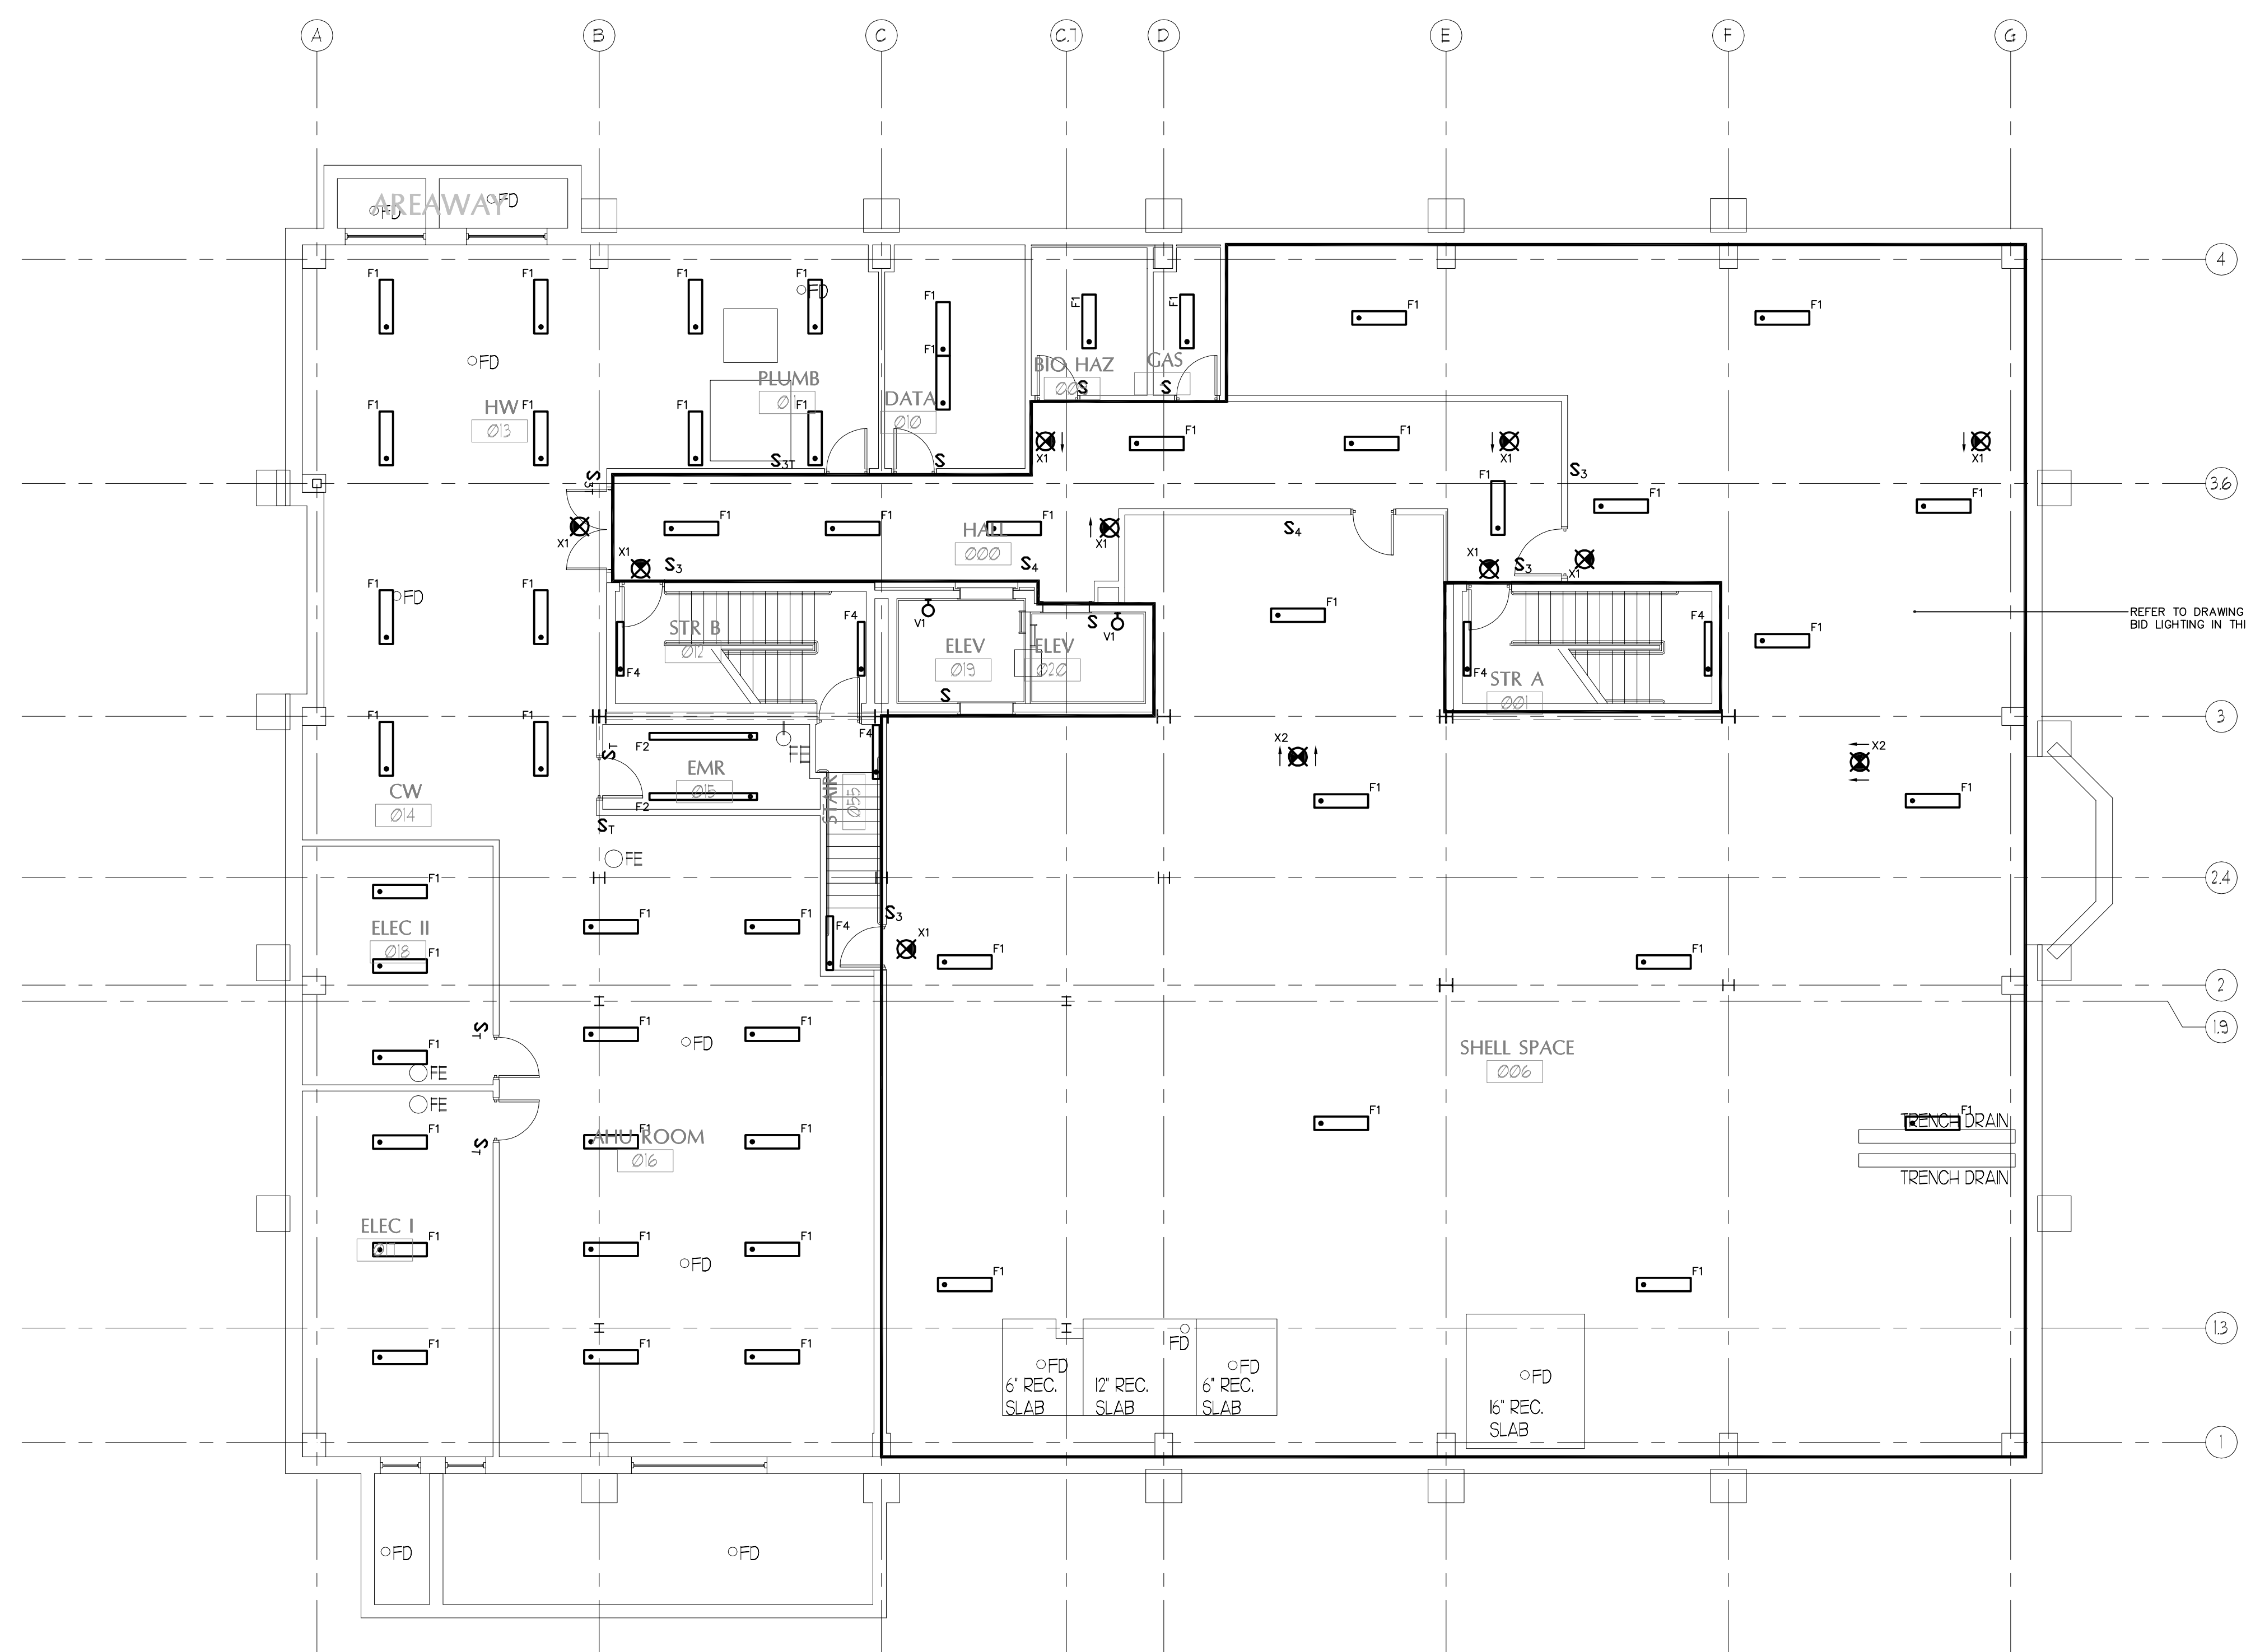


IF THIS SHEET IS NOT 24 X 36 IT IS A REDUCED SCALE PRINT - SCALE ACCORDINGLY

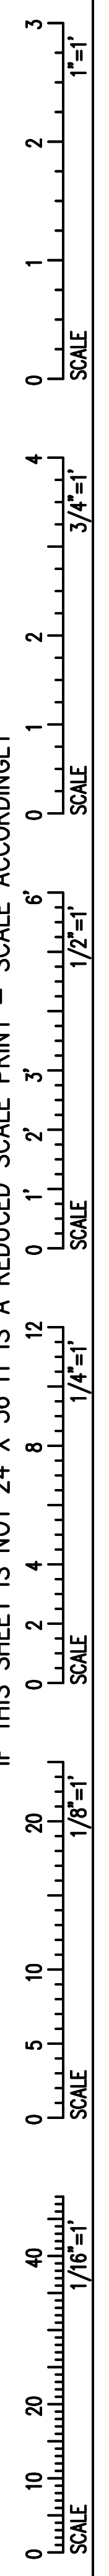


**1** LOWER LEVEL LIGHTING PLAN-BASE B ID  
Scale: 1/8"=1'-0"

REFER TO DRAWING EL1.1 FOR ALTERNATE BID LIGHTING IN THIS AREA.

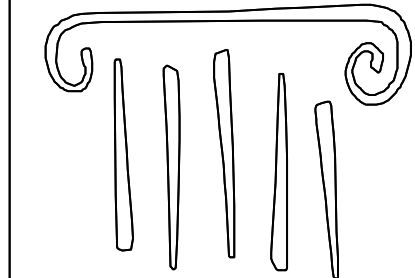

**PORT CITY ARCHITECTURE**

65 NEWBURY STREET  
PORTLAND, ME 04101  
207.761.9000  
fax: 207.761.2010  
lita@portcityarch.com

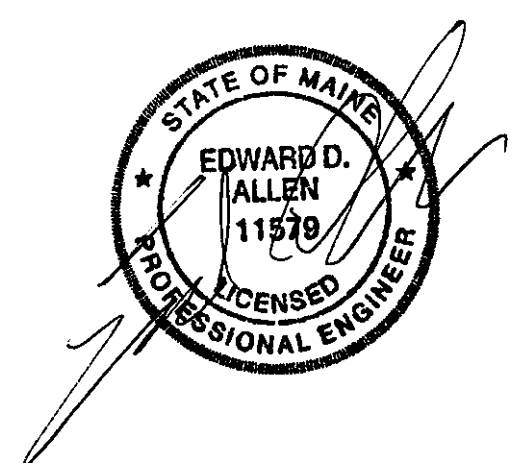

**VANZELM ENGINEERS**

VANZELM HEYWOOD & SHADFORD, INC.  
10 TALCOTT NOTCH FARMINGTON, CT 06032  
TEL: (860)284-2004 FAX: (860)284-2006  
PROJECT NO.: 2007120.00

**BECKER structural engineers, inc.**

**SYTDesign CONSULTANTS**  
CIVIL ENGINEERING & LANDSCAPE ARCHITECTURE

**ALLIED/COOK CONSTRUCTION**

**Favreau**

**Titan Mechanical, Inc.**  
Design-Build Engineering - Mechanical Contracting

#	DATE	DESCRIPTION
		PERMIT SET
	01/24/08	Date Issued
	06506	Project Number

SHEET NAME  
**ELECTRICAL LIGHTING PLAN - LWR LVL BASE BID**

Drawn By  
AMM  
Checked By  
MER

**EL1.0**

**PERMIT SET - NOT FOR CONSTRUCTION**