
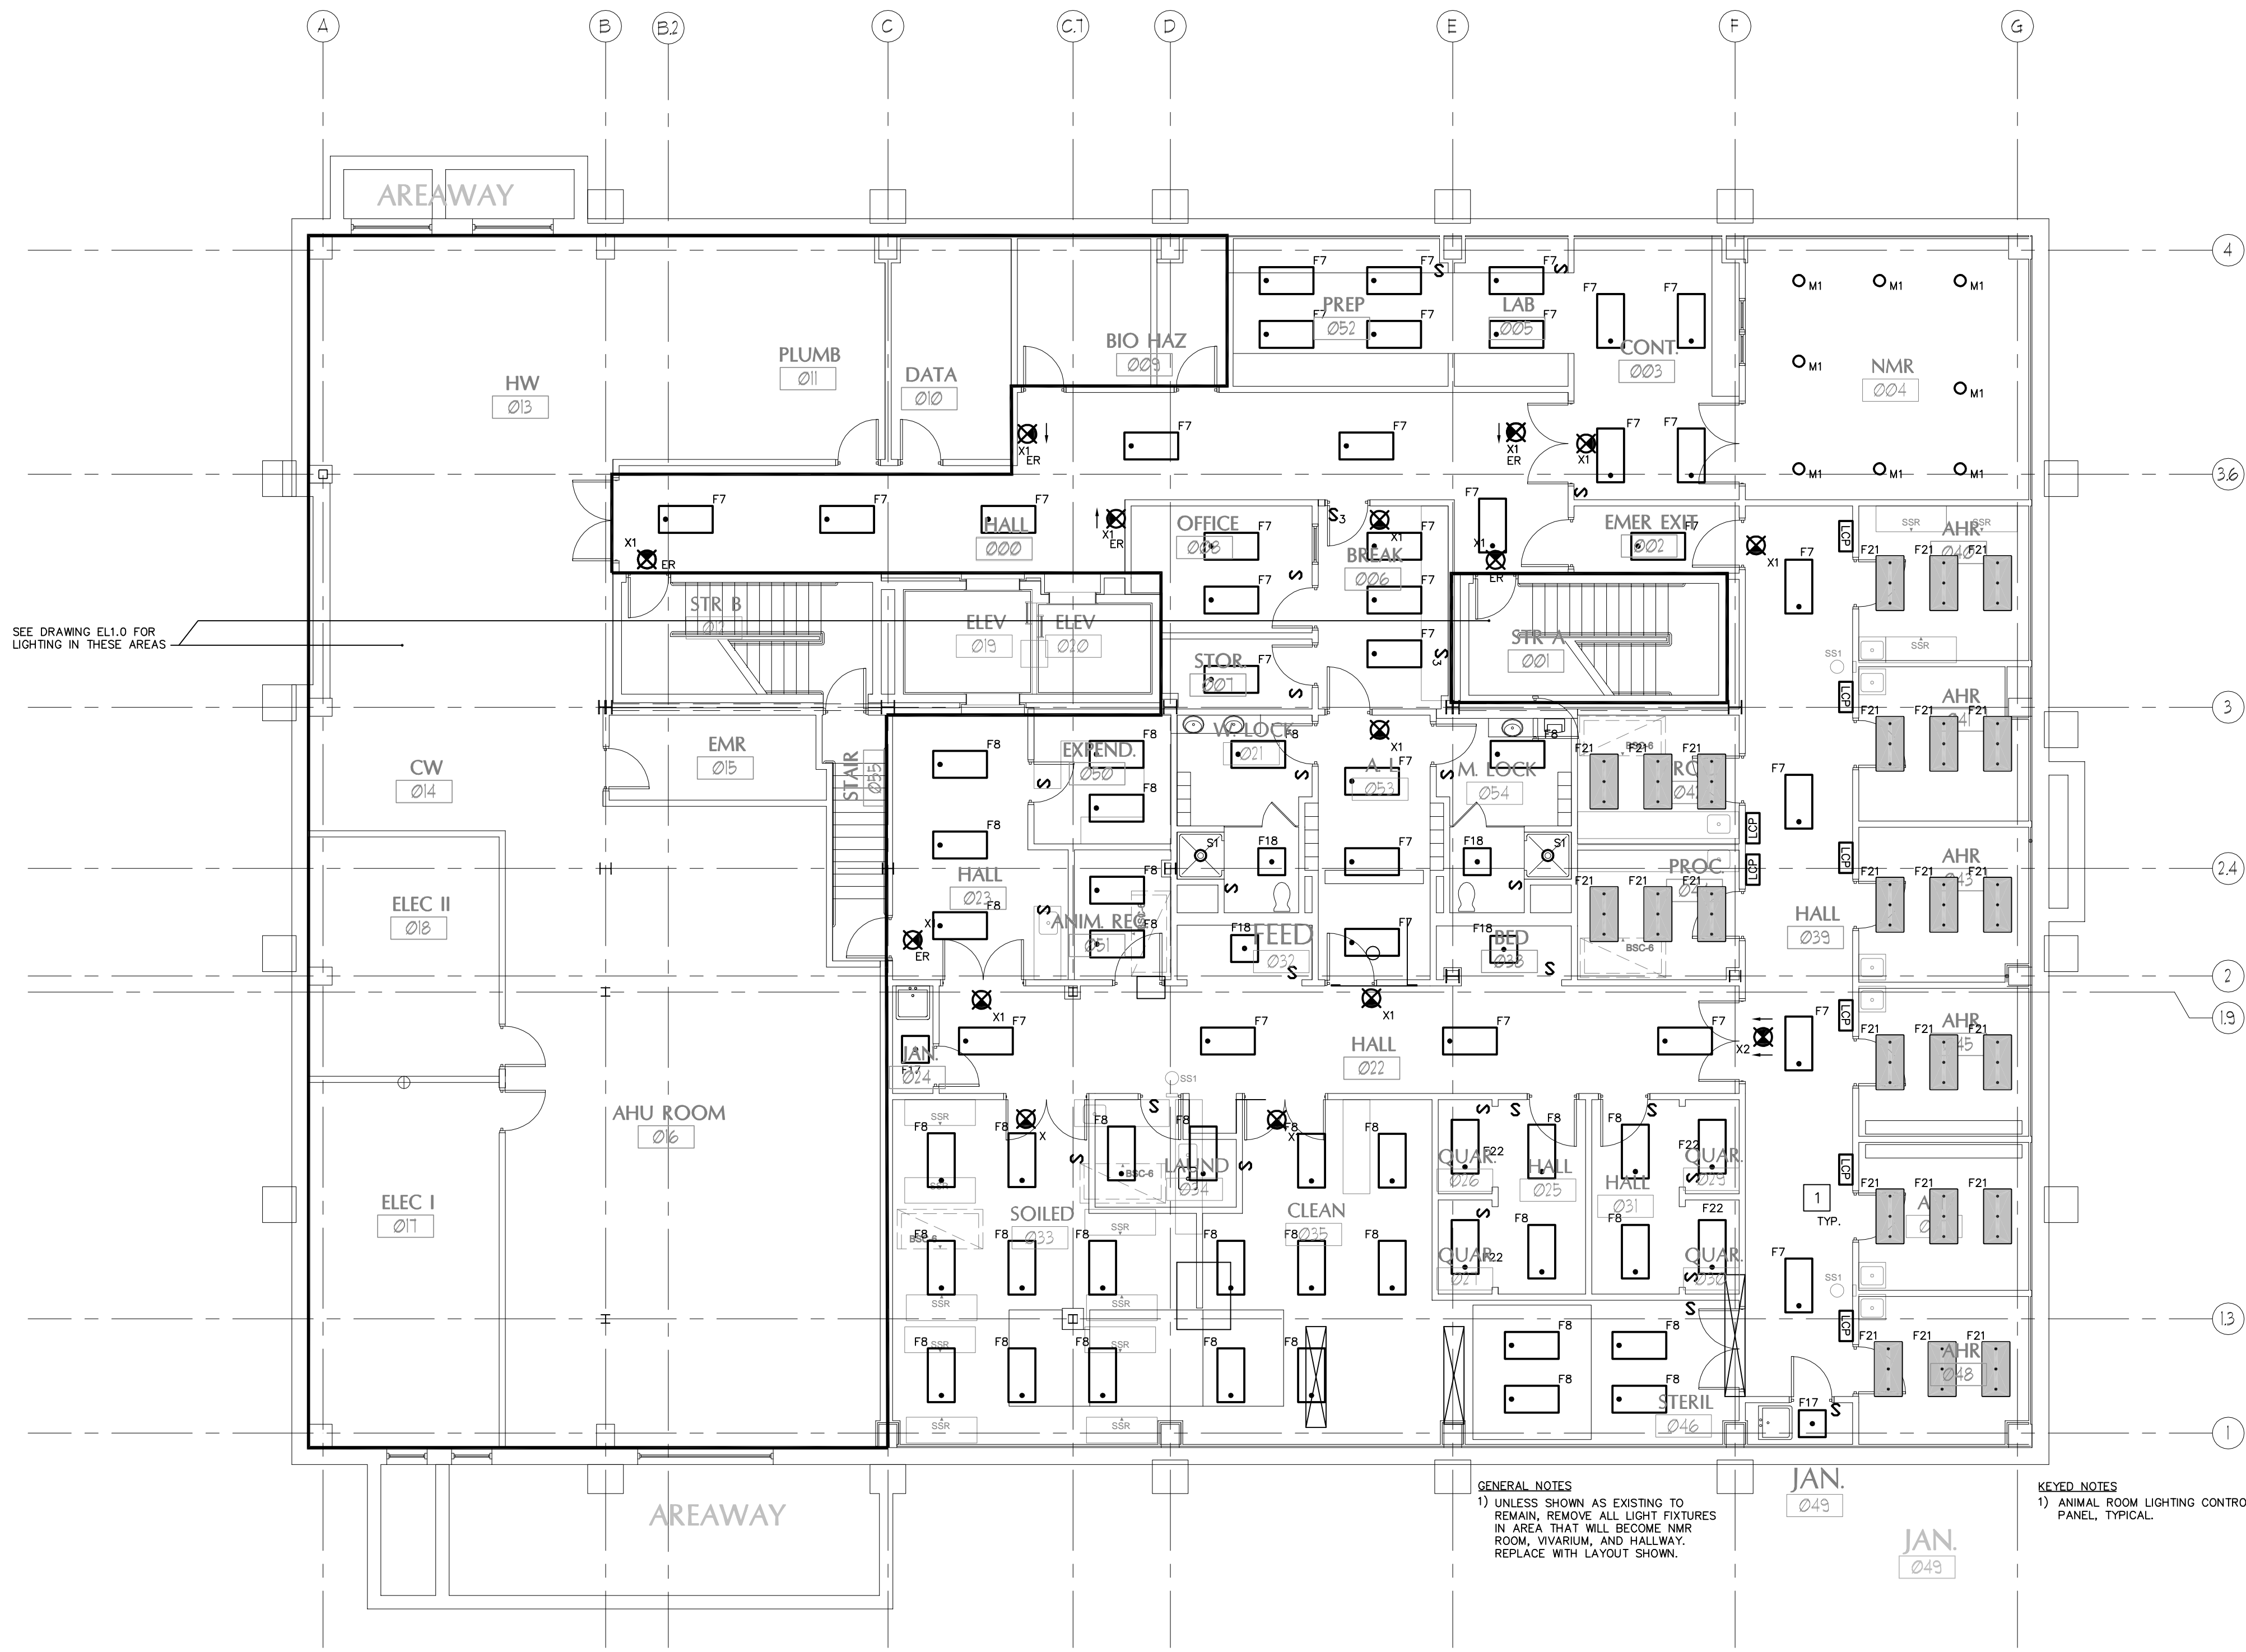



IF THIS SHEET IS NOT 24 X 36 IT IS A REDUCED SCALE PRINT - SCALE ACCORDINGLY

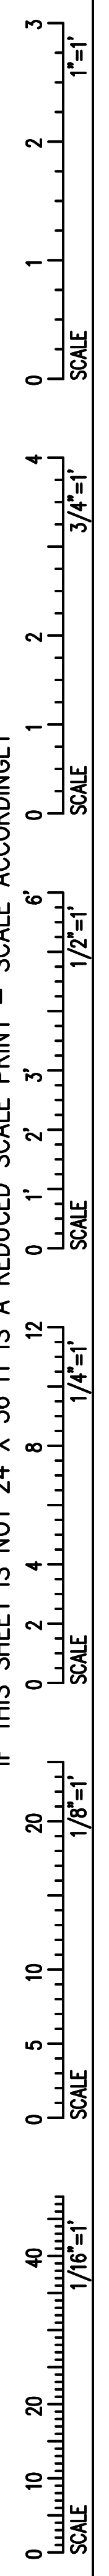

1 LOWER LEVEL LIGHTING PLAN - ALTERNATE
Scale: 1/8"=1'-0"


GENERAL NOTES
1) UNLESS SHOWN AS EXISTING TO REMAIN, REMOVE ALL LIGHT FIXTURES IN AREA THAT WILL BECOME NMR ROOM, VIVARIUM, AND HALLWAY. REPLACE WITH LAYOUT SHOWN.

KEYED NOTES
1) ANIMAL ROOM LIGHTING CONTROL PANEL, TYPICAL.

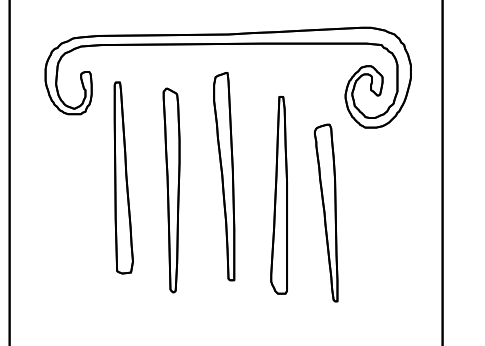

PORT CITY ARCHITECTURE

65 NEWBURY STREET
PORTLAND, ME 04101
207.761.9000
fax: 207.761.2010
lita@portcityarch.com

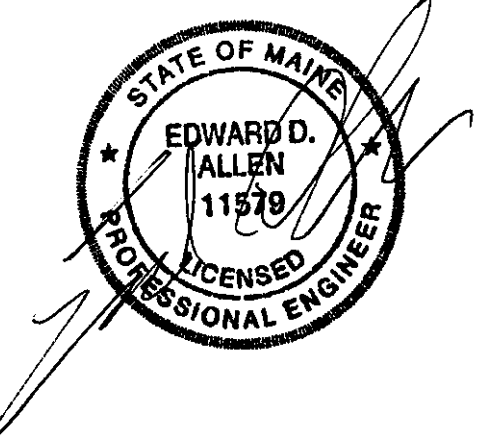

VANZELM
ENGINEERS

VANZELM HEYWOOD & SHADFORD, INC.
10 TALCOTT NOTCH FARMINGTON, CT 06032
TEL: (860)284-2064 FAX: (860)284-2066
PROJECT NO.: 2007120.00

BECKER
structural engineers, inc.

SYTDesign
CONSULTANTS
CIVIL ENGINEERING & LANDSCAPE ARCHITECTURE

ALLIED/COOK
CONSTRUCTION

Pavreanu

Titan Mechanical, Inc.
Design-Build Engineering - Mechanical Contracting

#	DATE	DESCRIPTION
		PERMIT SET
	01/24/08	Date Issued
	06506	Project Number

SHEET NAME
ELECTRICAL LIGHTING PLAN - LOWER LEVEL - ALTERNATE

Drawn By
AMM

Checked By
MER

EL1.1

PERMIT SET - NOT FOR CONSTRUCTION