



IF THIS SHEET IS NOT 24 X 36 IT IS A REDUCED SCALE PRINT - SCALE ACCORDINGLY

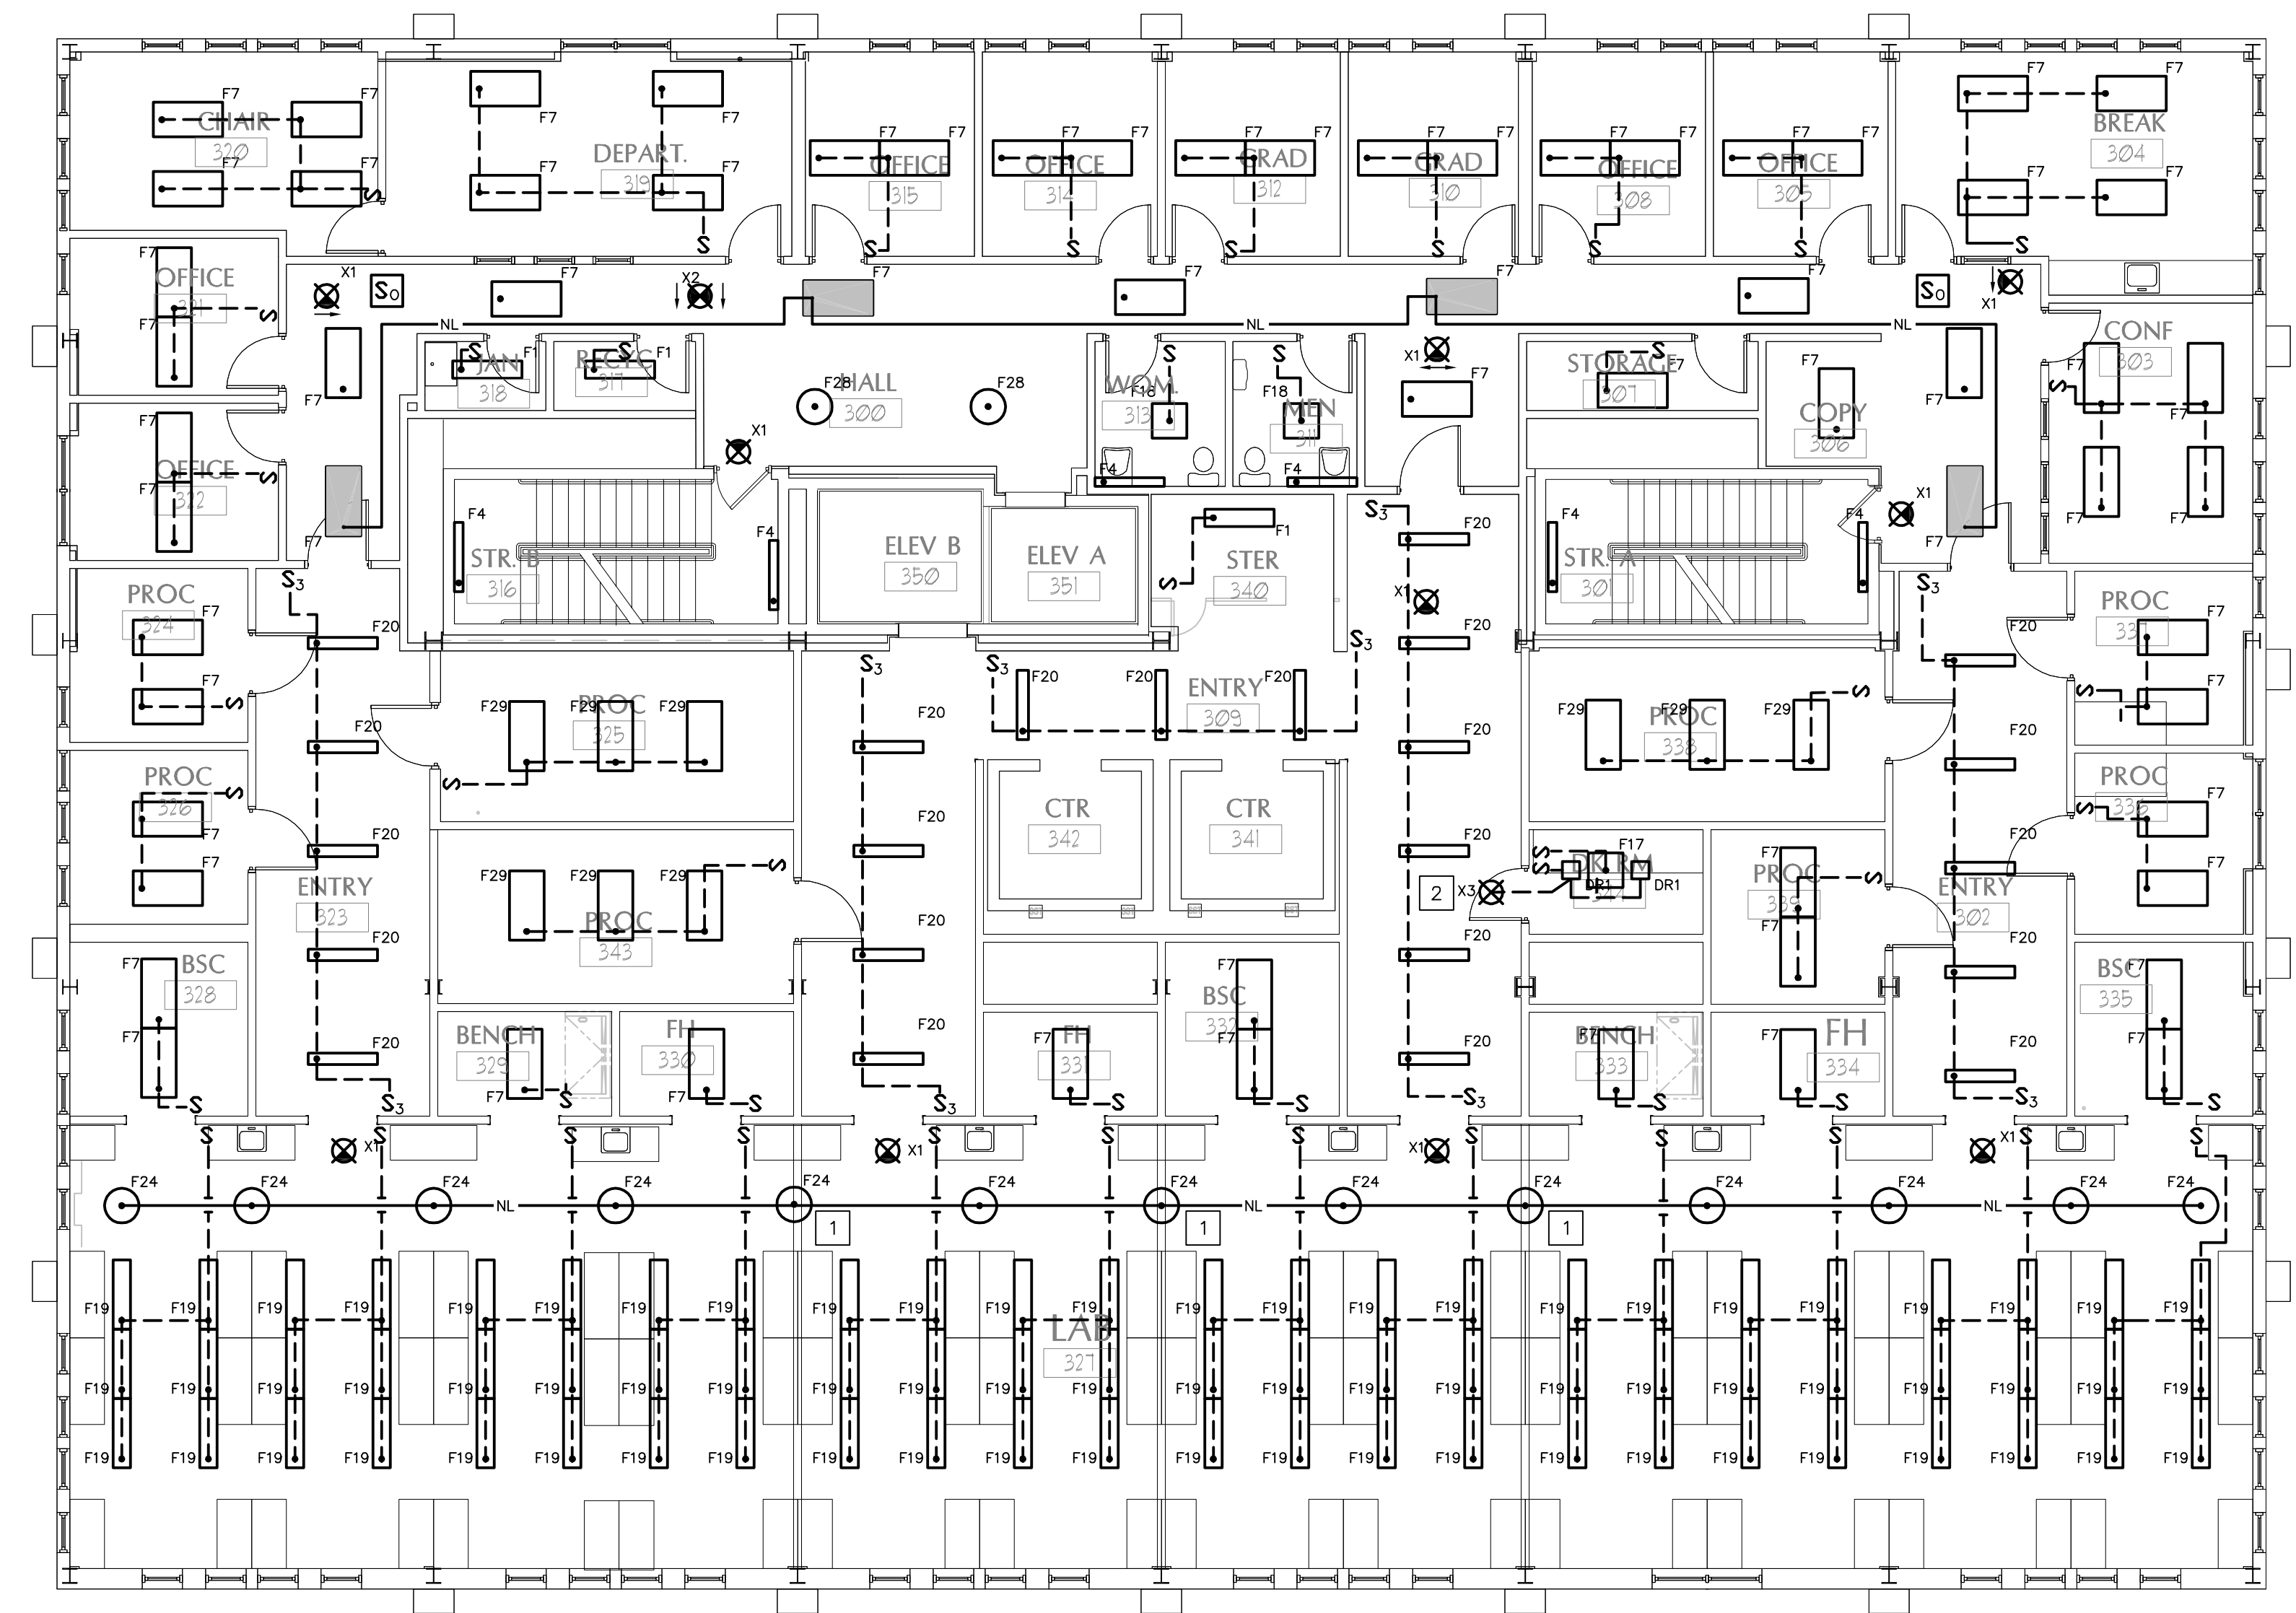


KEYED NOTES:  
 1. FIXTURE TO BE REMOVED IF LAB DIVIDING PARTITION IS INSTALLED. TYPICAL OF 3.  
 2. DARK ROOM IN USE LIGHT.

1 THIRD FLOOR LIGHTING PLAN  
 Scale: 1/8"=1'-0"

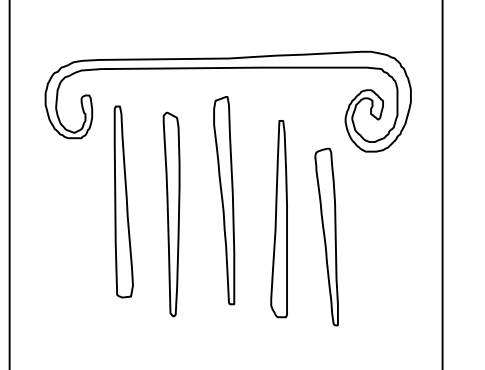

PORT CITY ARCHITECTURE

65 NEWBURY STREET  
 PORTLAND, ME 04101  
 207.761.9000  
 fax: 207.761.2010  
 lita@portcityarch.com

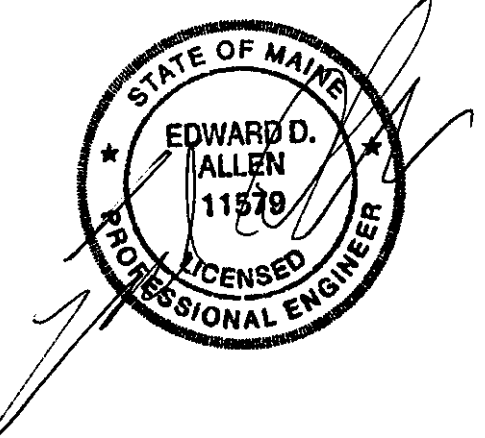

**VANZELM**  
 ENGINEERS

VANZELM HEYWOOD & SHADFORD, INC.  
 10 TALCOTT NOTCH FARMINGTON, CT 06032  
 TEL: (860)284-2004 FAX: (860)284-2006  
 PROJECT NO.: 2007120.00

**BECKER**  
 structural engineers, inc.

**SYTDesign**  
 CONSULTANTS  
 CIVIL ENGINEERING & LANDSCAPE ARCHITECTURE

**ALLIED/COOK**  
 CONSTRUCTION

**Favreau**  
 electric

**Titan Mechanical, Inc.**  
 Design-Build Engineering - Mechanical Contracting

#	DATE	DESCRIPTION
		PERMIT SET
	01/24/08	Date Issued
	06506	Project Number

SHEET NAME  
**ELECTRICAL LIGHTING PLAN - THIRD FLOOR**

Drawn By  
 AMM  
 Checked By  
 MER

**EL1.4**

**PERMIT SET - NOT FOR CONSTRUCTION**