

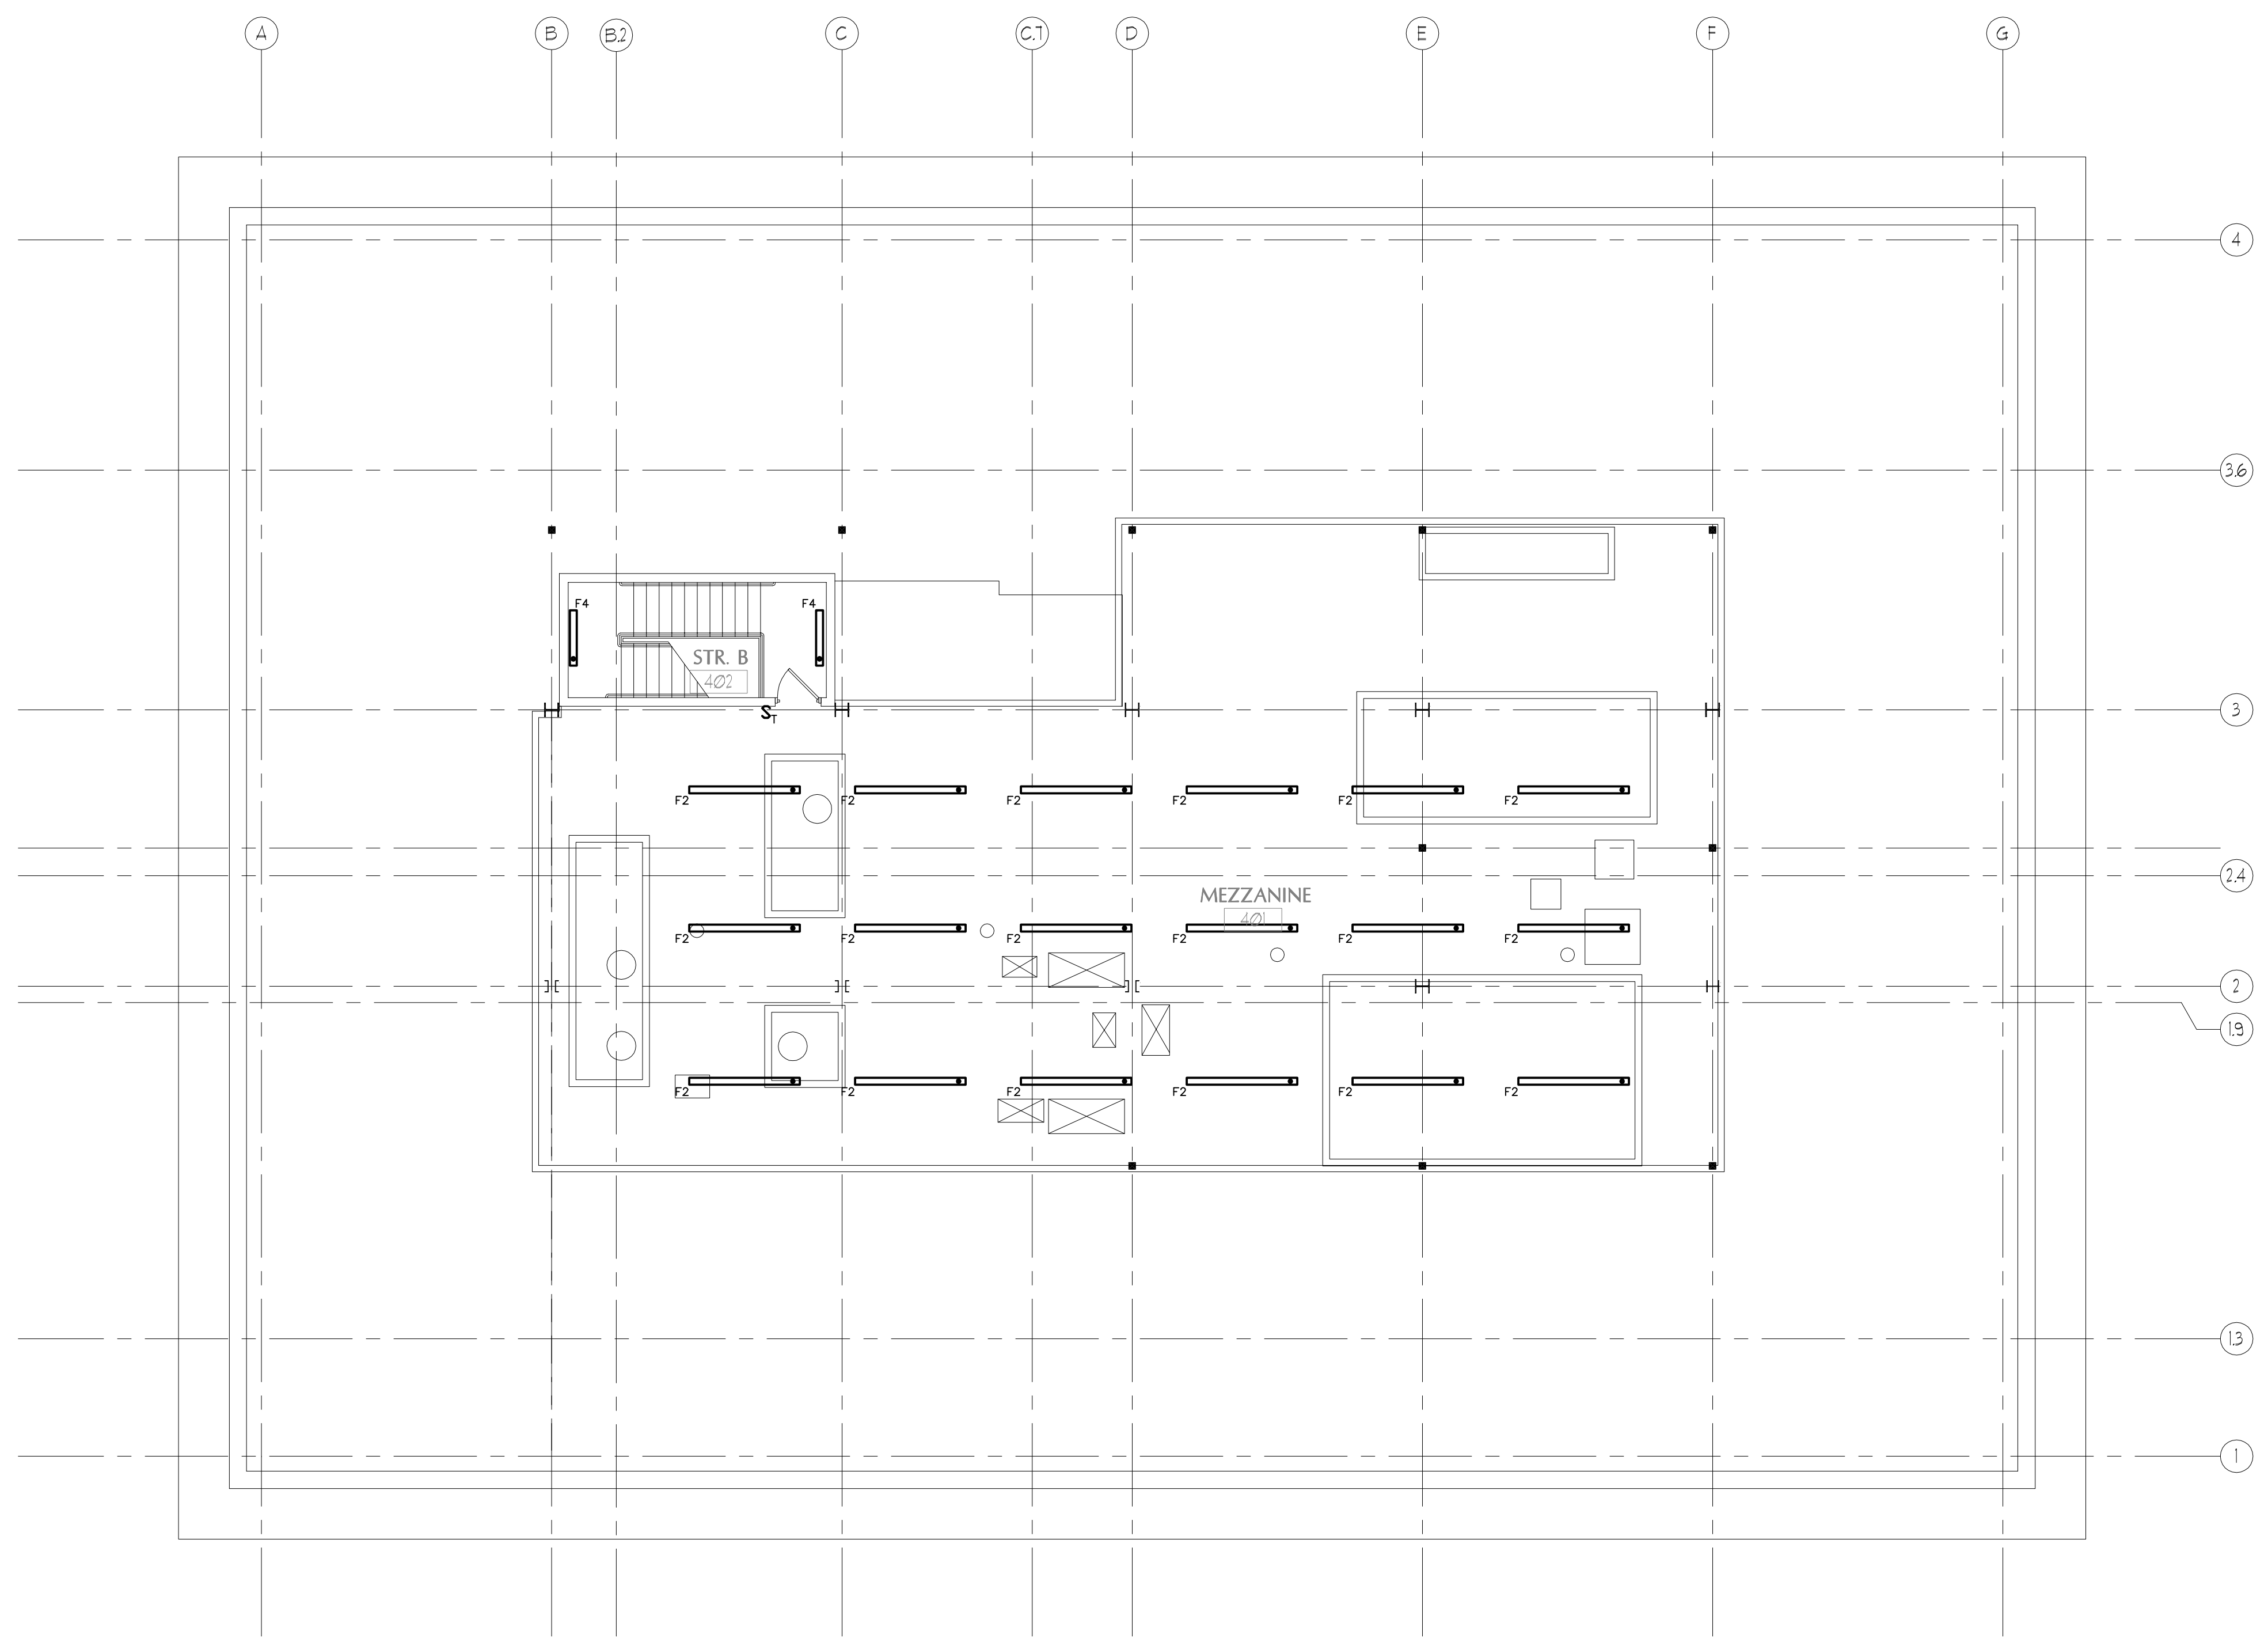


IF THIS SHEET IS NOT 24 X 36 IT IS A REDUCED SCALE PRINT - SCALE ACCORDINGLY

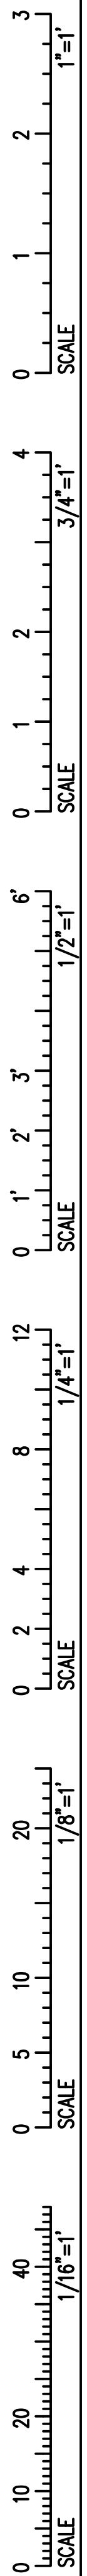


1 MECHANICAL MEZZANINE LIGHTING PLAN
Scale: 1/8"=1'-0"

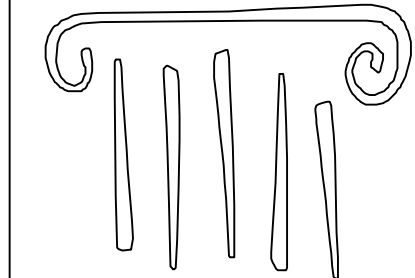

PORT CITY ARCHITECTURE

65 NEWBURY STREET
PORTLAND, ME 04101
207.761.9000
fax: 207.761.2010
lita@portcityarch.com

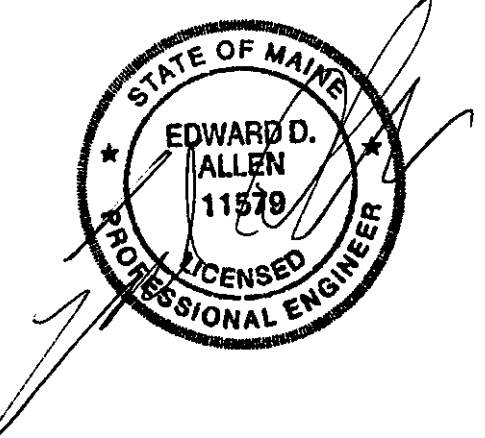

VANZELM ENGINEERS

VANZELM HEYWOOD & SHADFORD, INC.
10 TALCOTT NOTCH FARMINGTON, CT 06032
TEL: (860)284-5064 FAX: (860)284-5065
PROJECT NO.: 2007120.00

BECKER
structural engineers, inc.

SYTDesign
CONSULTANTS
CIVIL ENGINEERING & LANDSCAPE ARCHITECTURE

ALLIED/COOK
CONSTRUCTION

Favreau
electric

Titan Mechanical, Inc.
Design-Build Engineering - Mechanical Contracting


#	DATE	DESCRIPTION
		PERMIT SET
	01/24/08	Date Issued
	06506	Project Number

SHEET NAME
ELECTRICAL LIGHTING PLAN - MECH. MEZZANINE

Drawn By
AMM

Checked By
MER

EL 1.5

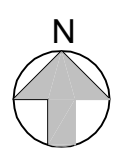

PERMIT SET - NOT FOR CONSTRUCTION