

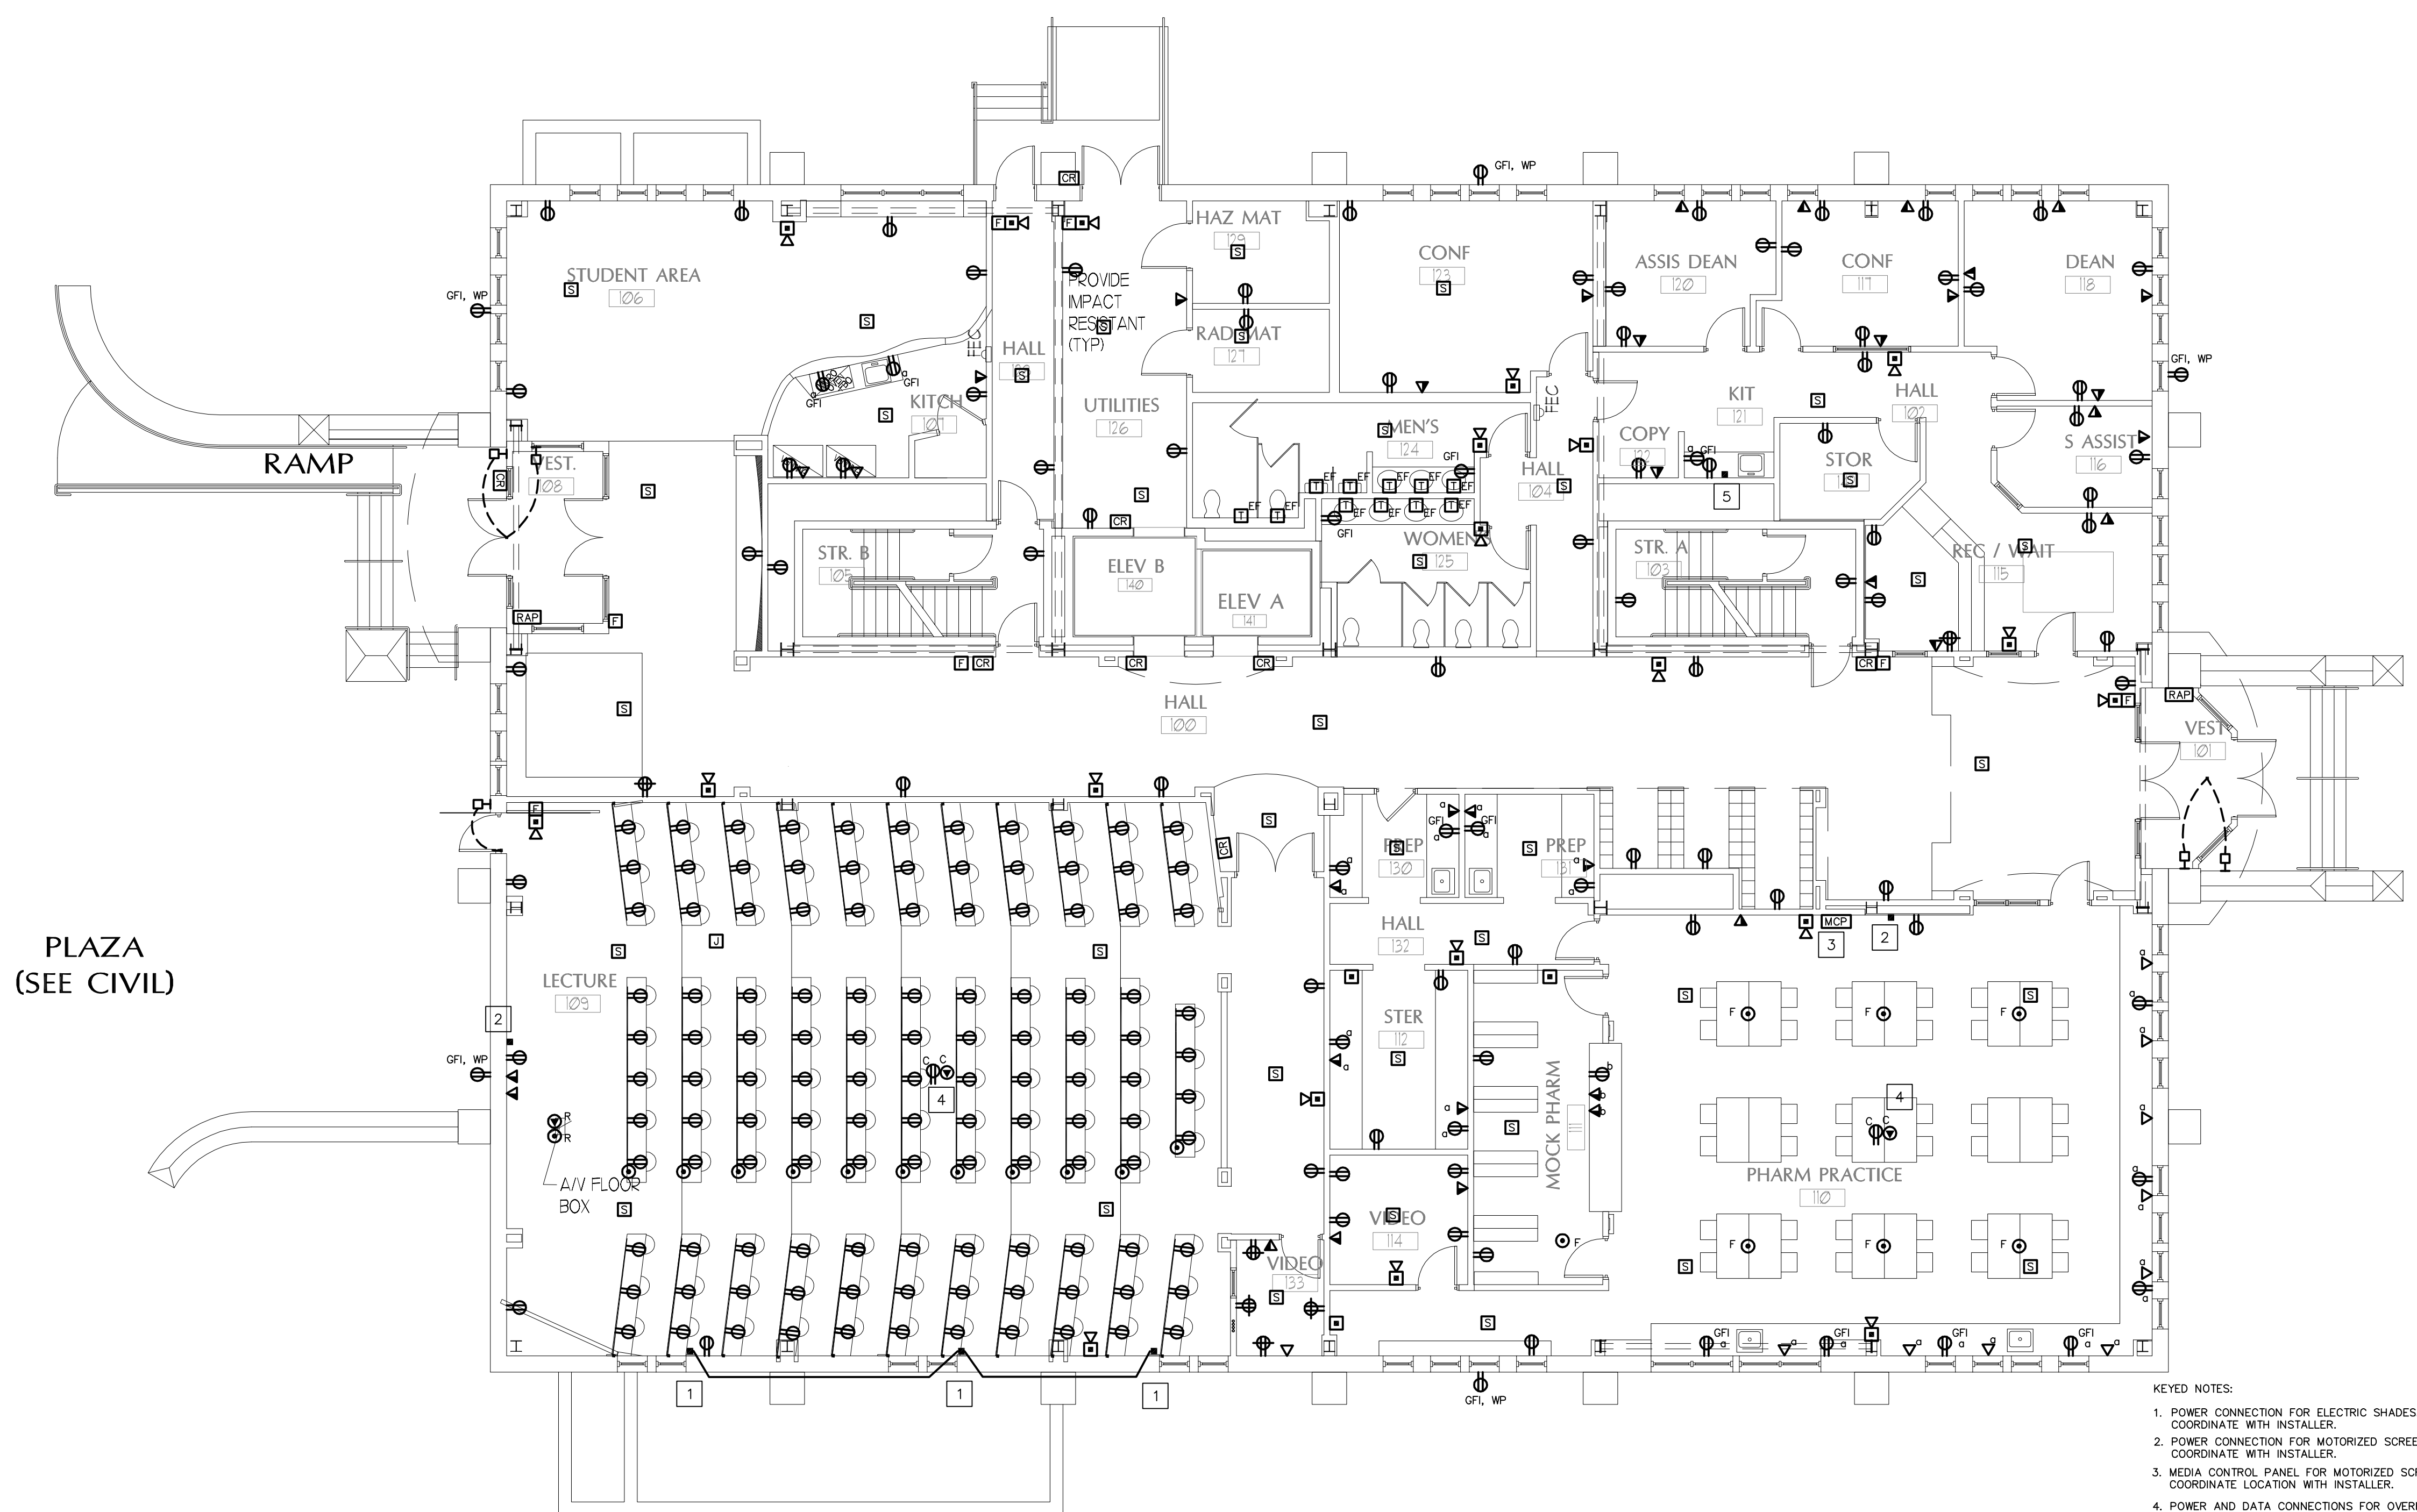


IF THIS SHEET IS NOT 24 X 36 IT IS A REDUCED SCALE PRINT - SCALE ACCORDINGLY

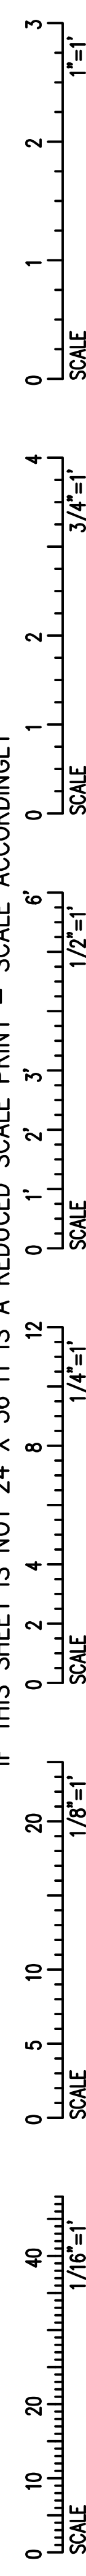


1 FIRST FLOOR PLAN
 SCALE: 1/8" = 1'-0"

- KEYED NOTES:
1. POWER CONNECTION FOR ELECTRIC SHADES. COORDINATE WITH INSTALLER.
 2. POWER CONNECTION FOR MOTORIZED SCREEN. COORDINATE WITH INSTALLER.
 3. MEDIA CONTROL PANEL FOR MOTORIZED SCREEN. COORDINATE LOCATION WITH INSTALLER.
 4. POWER AND DATA CONNECTIONS FOR OVERHEAD PROJECTOR. COORDINATE LOCATION WITH INSTALLER.
 5. POWER CONNECTION FOR COFFEE URN.

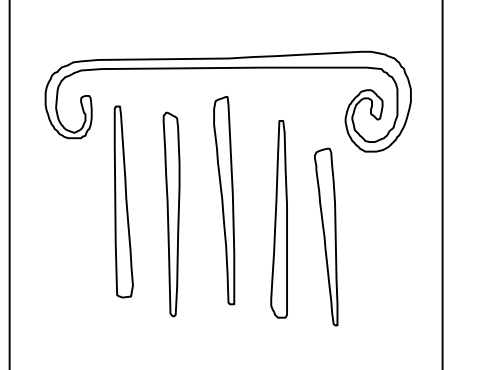

PORT CITY ARCHITECTURE

65 NEWBURY STREET
 PORTLAND, ME 04101
 207.761.9000
 fax: 207.761.2010
 lita@portcityarch.com

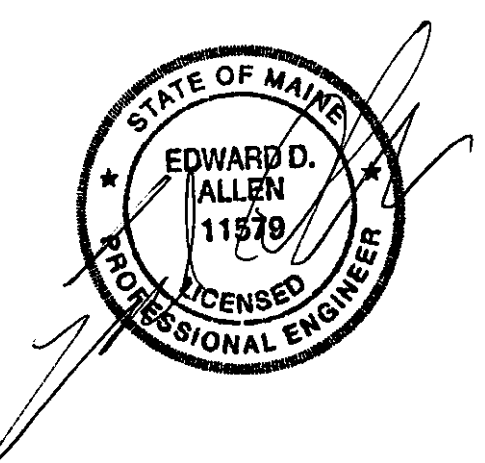

VANZELM ENGINEERS

VANZELM HEYWOOD & SHADFORD, INC.
 10 TALCOTT NOTCH FARMINGTON, CT 06032
 TEL: (860)284-5064 FAX: (860)284-5066
 PROJECT NO.: 2007120.00

BECKER
 structural engineers, inc.

SYTDesign
 CONSULTANTS
 CIVIL ENGINEERING & LANDSCAPE ARCHITECTURE

ALLIED/COOK
 CONSTRUCTION

Favreau
 electric

Titan Mechanical, Inc.
 Design-Build Engineering - Mechanical Contracting

#	DATE	DESCRIPTION
		PERMIT SET

Date Issued: 01/24/08

Project Number: 06506

SHEET NAME
ELECTRICAL POWER PLAN - FIRST FLOOR

Drawn By: AMM
 Checked By: MER

EP1.2

PERMIT SET - NOT FOR CONSTRUCTION